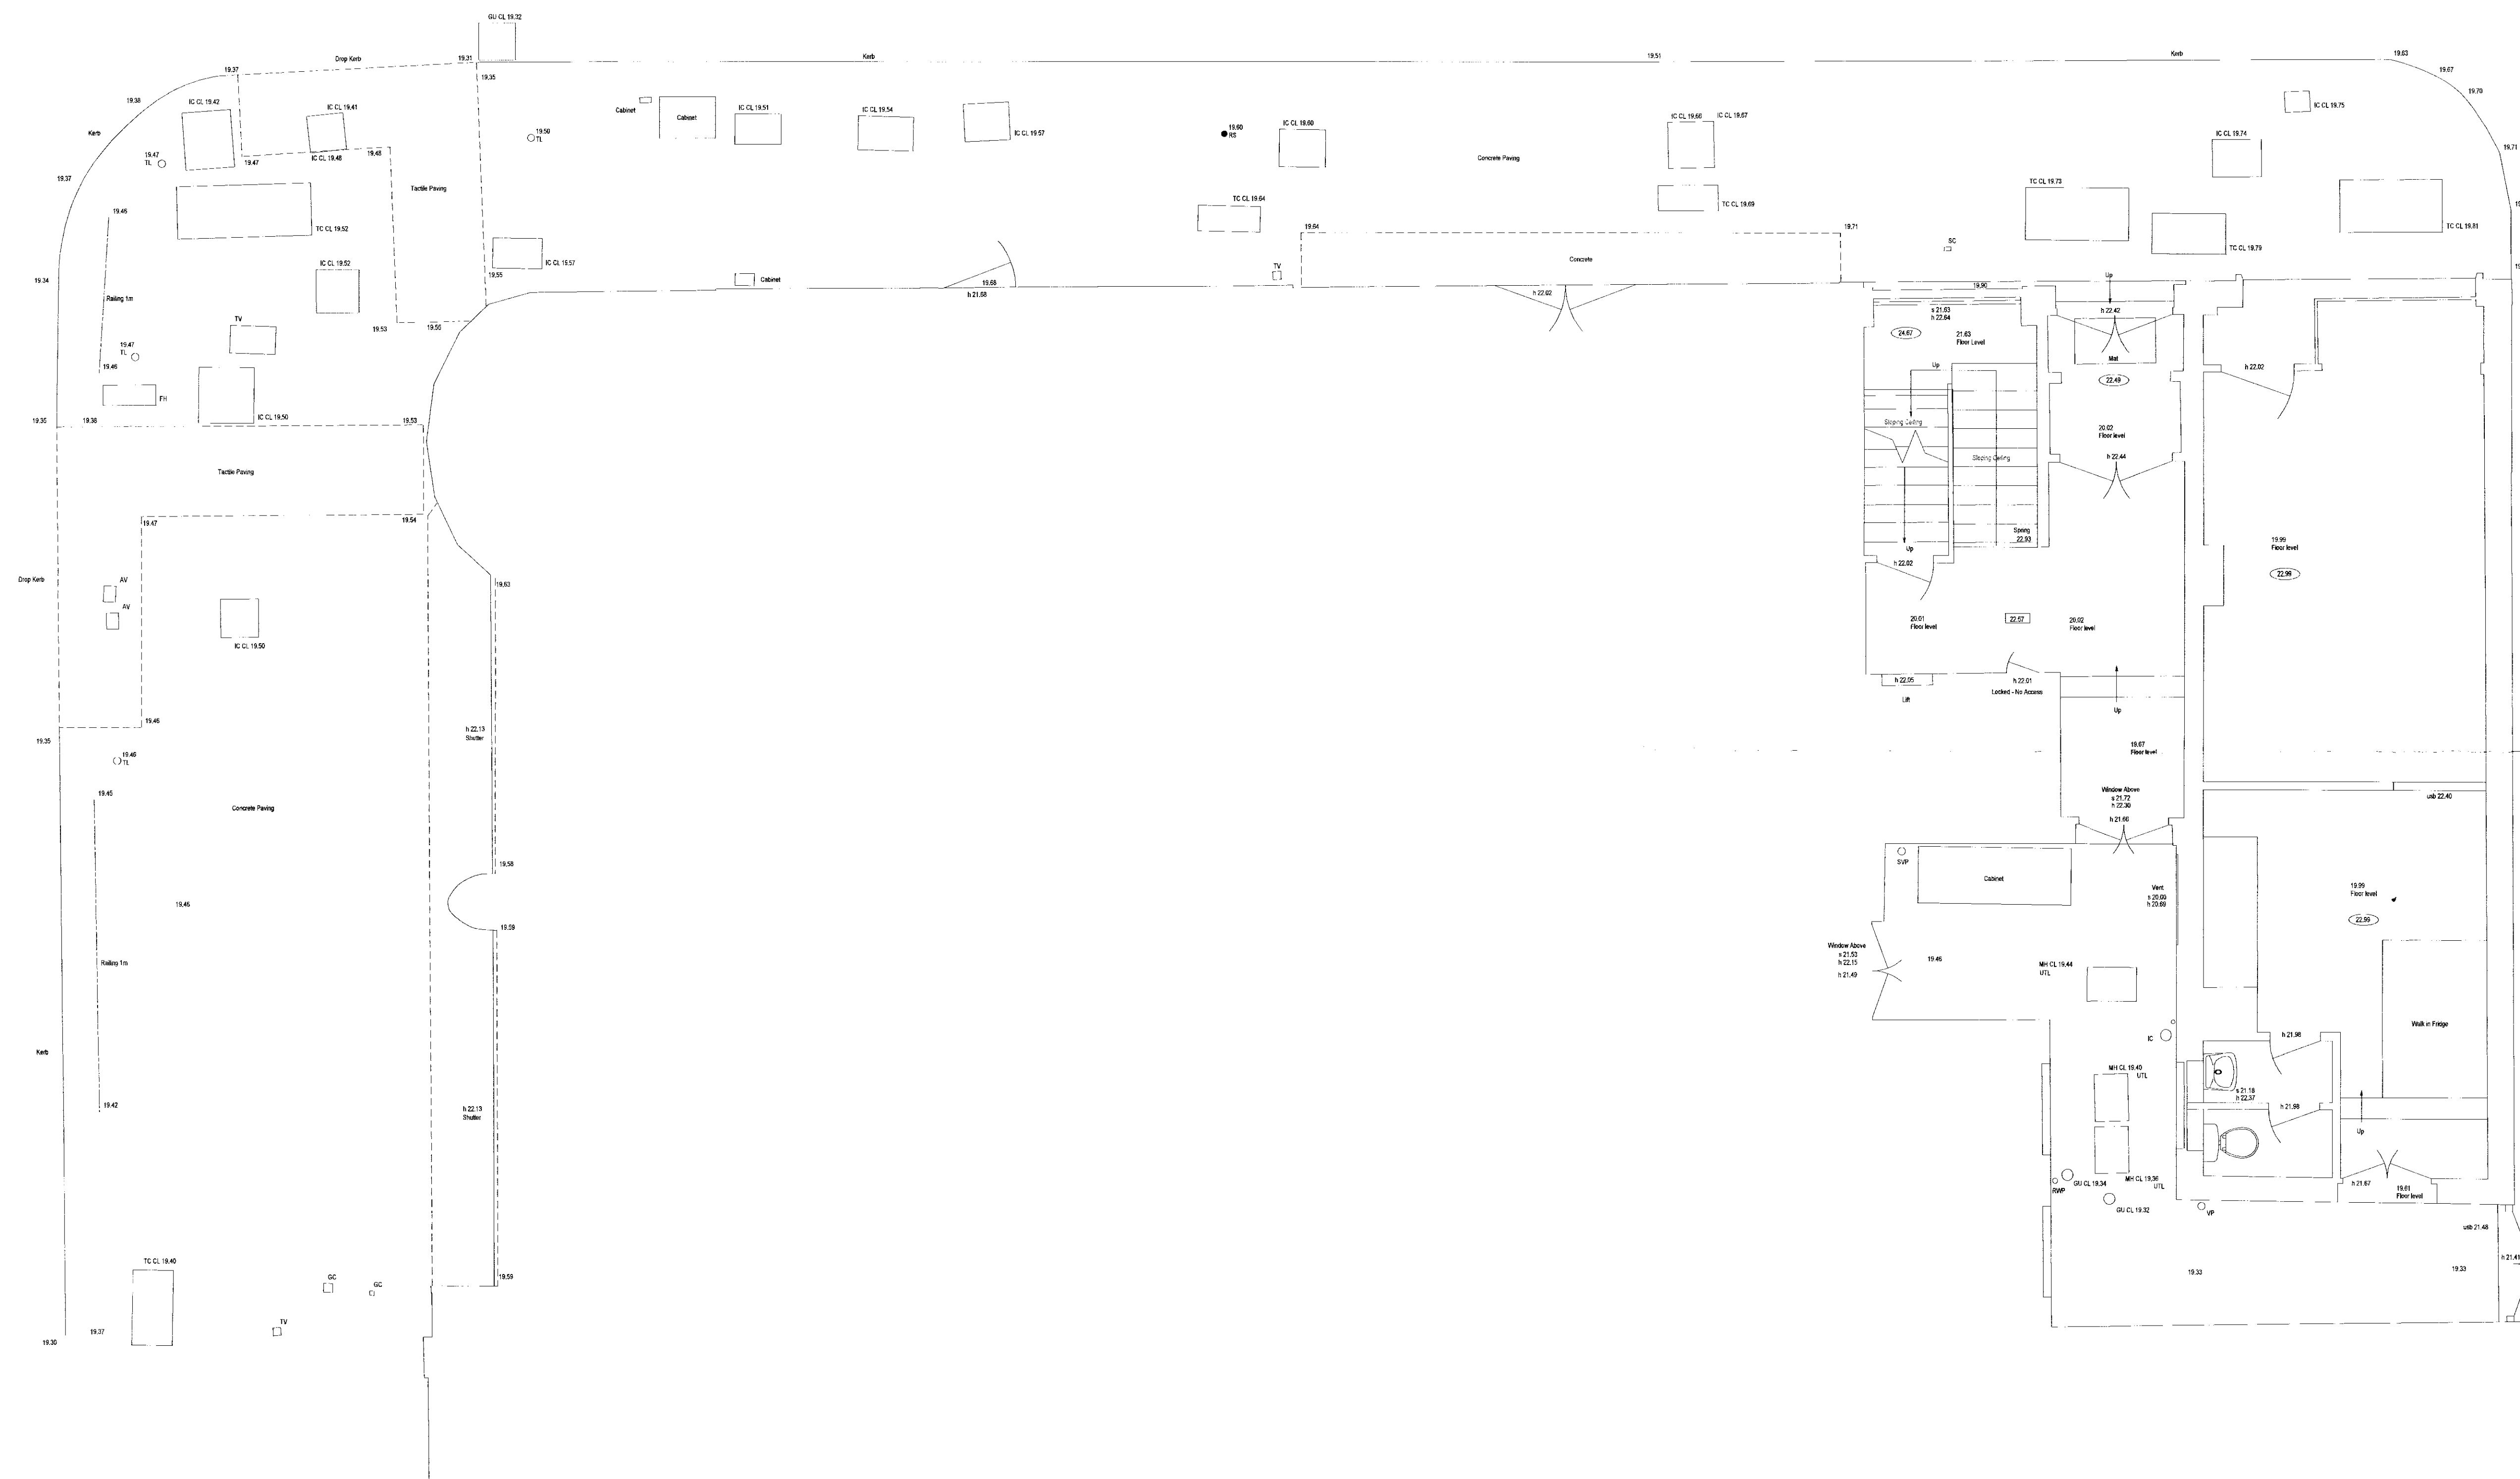


- NOTES
- LEVELS ARE RELATED TO STATION ONE.
ASSUMED LEVEL 20.00 METRES.
 - SURVEY HAS BEEN CARRIED OUT TO AN
ACCURACY COMMENSURATE WITH A 1:50
SCALE DRAWING.

- ABBREVIATION LIST
- ELECTRICS
- AC AIR CONDITIONING VENTS OR EQUIPMENT
 - DP DOUBLE PLUG
 - ELS EMERGENCY LIGHT SWITCH
 - EP ELECTRIC POINT
 - ESM ELECTRIC SWITCH MACHINE
 - FA FIRE ALARM
 - FES FIRED ELECTRIC SWITCH
 - JB JUNCTION BOX
 - L LIGHT
 - LCB LIFT CALL BUTTON
 - LS LIGHT SWITCH
 - SP SINGLE PLUG
 - WL WALL LIGHT
- WHERE THESE ARE FOLLOWED BY A MEASUREMENT, THIS IS THE HEIGHT FROM FLOOR
- GENERAL
- AC AIR CONDITIONING VENTS OR EQUIPMENT
 - BSI BATHING KID
 - GU GULLY
 - IC INSPECTION COVER
 - WH WAREHOUSE
 - ST STAIRWAY
 - SWP SOIL AND WASTE PIPE
- ± 1.00 BILL LEVEL
h 1.00 HEAD LEVEL
wh 1.00 LEVEL OF UNDERSIDE OF BEAM
wh 1.00 LEVEL OF UNDERSIDE OF DUCTING
wh 1.00 LEVEL OF UNDERSIDE OF PIPE
wh 1.00 UNDERGROUND LEVEL
- 2.40 CEILING LEVEL
2.14 FALSE CEILING LEVEL

NO.	DATE	DETAILS

REVISIONS

KND SURVEYS LTD

Tel: 01494 718453
Fax: 01494 717576
e-mail: enquiry@knds-surveys.com

74 WATFORD LANE
HOLLIER GREEN
HIGH WYCOMBE
BUCKINGHAMSHIRE
HP15 8UG

CLIENT

SEYMOUR LTD
4A LYNHURST GARDENS
LONDON
NWS 5NR

JOB TITLE

122 - 126 KILBURN HIGH ROAD
NWS

DRAWING TITLE

SITE SURVEY & GROUND FLOOR PLAN

DRAWING NO. K 07 07 G	DRAWN BY RJG	DATE 07 NOV 2007
SURVEYED BY RJG/PSW	SCALE 1:50	