


## Proposed Ground Floor

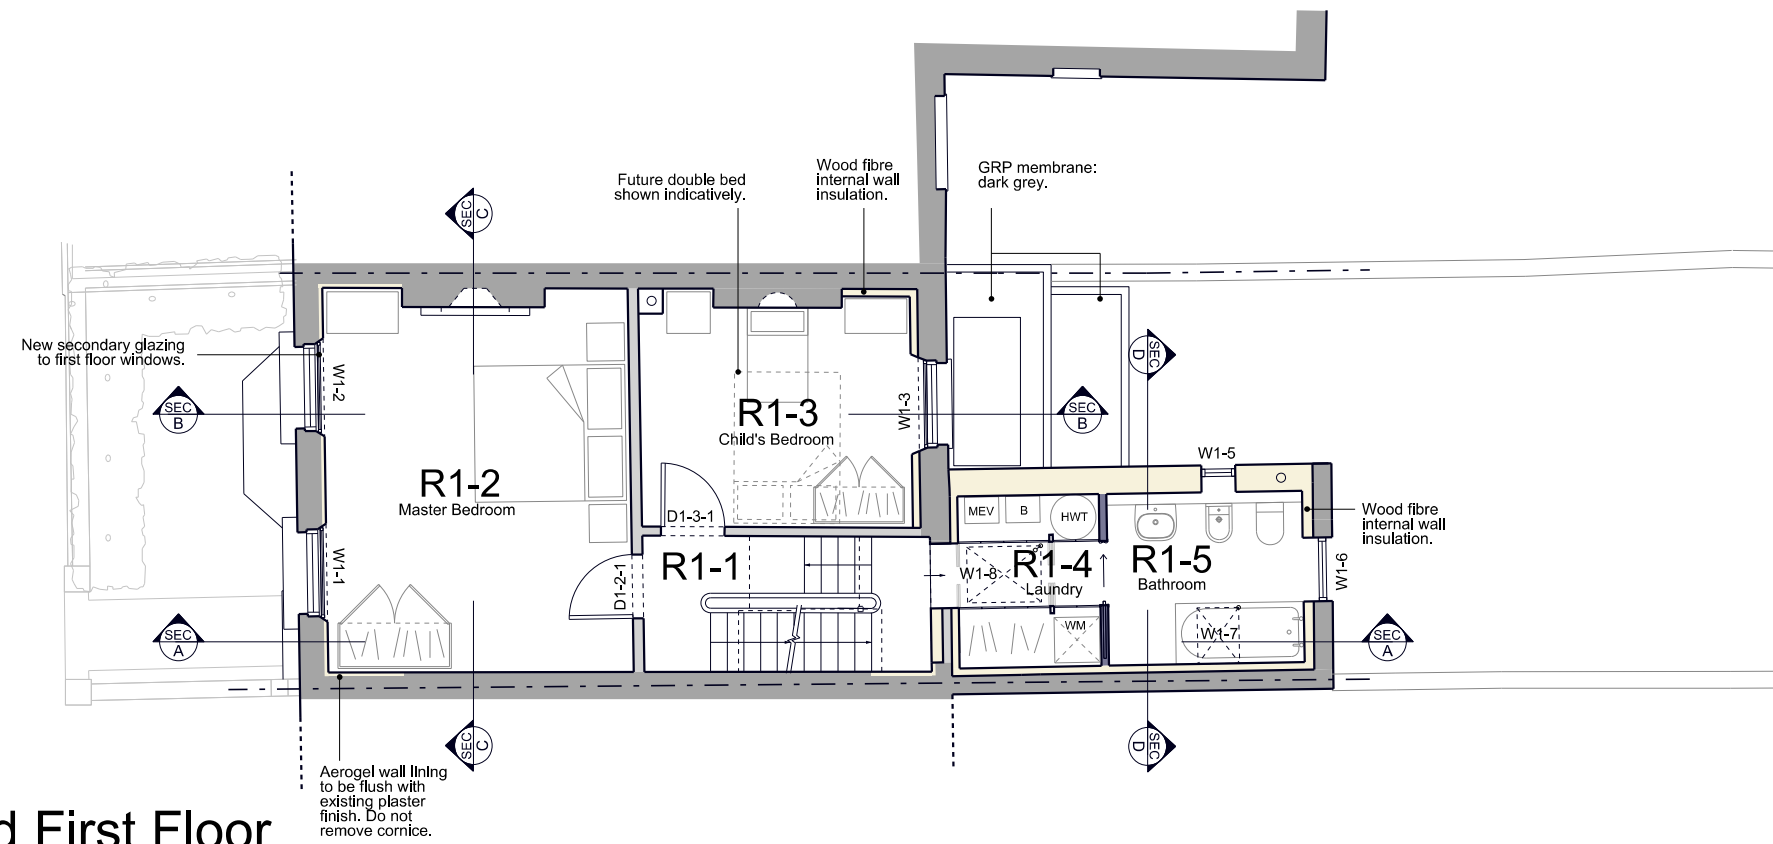

## Proposed First Floor

## Proposed Ground and First Floor Plans

Drawing Status:

## Planning

[illegible]

prewett  
bizley  
architects

Project

67 Falkland Road  
London  
NW5 2XB

	Drawing

## Proposed Ground and First Floor Plans

Scale

1:100 @ A3


Date \_\_\_\_\_

Date  
June 14

Drg. no.

109 P 00

vision

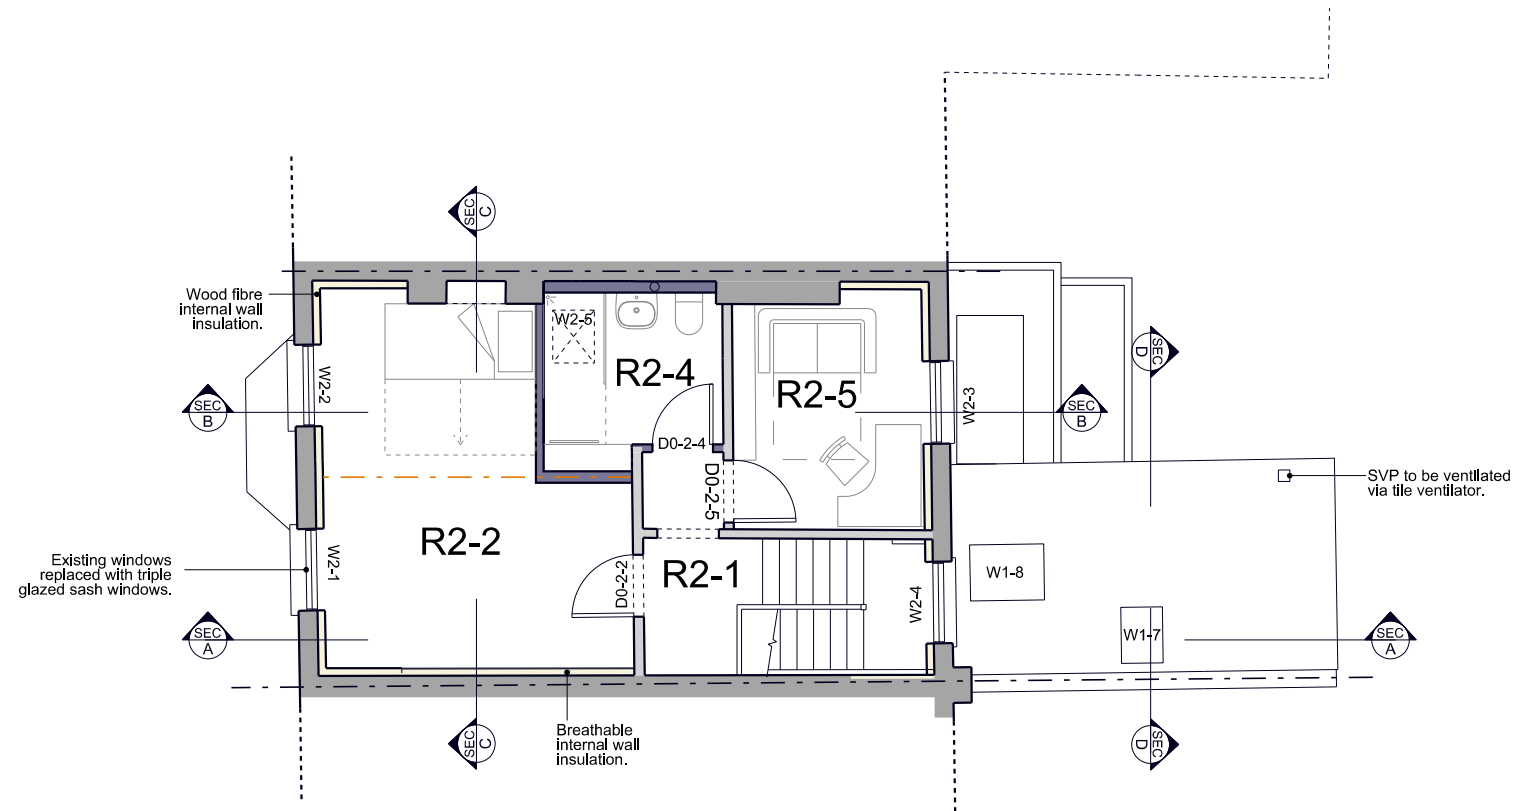


Architectural roof plan showing ventilation layout. Key features include:

- New Velux GGU 0066 CK02 triple glazed rooflight (top left).
- SVP through roof (top center).
- W2-5 (top left, below rooflight).
- W1-8 (bottom center, below rooflight).
- W1-7 (bottom right, below rooflight).
- New man-made slate roof (bottom right).
- SVP to be ventilated via tile ventilator (bottom right).


## Proposed Second Floor and Roof Plans

 Drg. no. <b>109 P 01</b>	Revision <b>-</b>
-----------------------------	----------------------






—

 [illegible]

<p>prewett bizley architects</p> <p>10 Palatine Road    London N16 8SX    07962 640 174  arjanredl@gmail.com</p>		
<p>Project</p> <p>67 Falkland Road  London  NW5 2XB</p>		
<p>Drawing</p> <p>Proposed Rear Projection  Elevation</p>		
<p>Scale</p> <p>1:100 @ A3</p>	<p>Date</p> <p>June 14</p>	
<p>Drp. no.</p> <p>109 P 11</p>		<p>Revision</p> <p>-</p>

 

## Proposed Section AA

Drawings may be scaled for purposes of Planning.  
Any discrepancies should be reported immediately to the designer.  
If In doubt ask,  
This drawing is copyright of the designer.

These drawings are based on plans provided by others.  
The designer accepts no liability for inaccuracies.  
Check all dimensions on site before proceeding with the works.

Drawing Status:  
**Planning**

[illegible]

prewett  
bizley  
architects

10 Palatine Road London N16 8SX 07962 640 174  
anjaniedl@gmail.com


Project  
67 Falkland Road  
London  
NW5 2XB

Drawing

Proposed Section  
AA

Scale 1:100 @ A3	Date June 14
---------------------	-----------------

 Drg. no.	Revision
109 P 20	-



Drawings may be scaled for purposes of Planning.  
Any discrepancies should be reported immediately to the designer.  
If in doubt ask,  
This drawing is copyright of the designer.

These drawings are based on plans provided by others.  
The designer accepts no liability for inaccuracies.  
Check all dimensions on site before proceeding with the works.

Drawing Status:

## Planning

[illegible]

prewett  
bizley  
architects

10 Palatine Road London N16 8SX 07962 640 174  
anjaniedl@gmail.com

Project	
---------	--

67 Falkland Road  
London  
NW5 2XB

Drawing


Proposed Section  
BB

Scale  
1:100 @ A3


Date  
June 14

Drg. no.  
**109 P 21**


ision

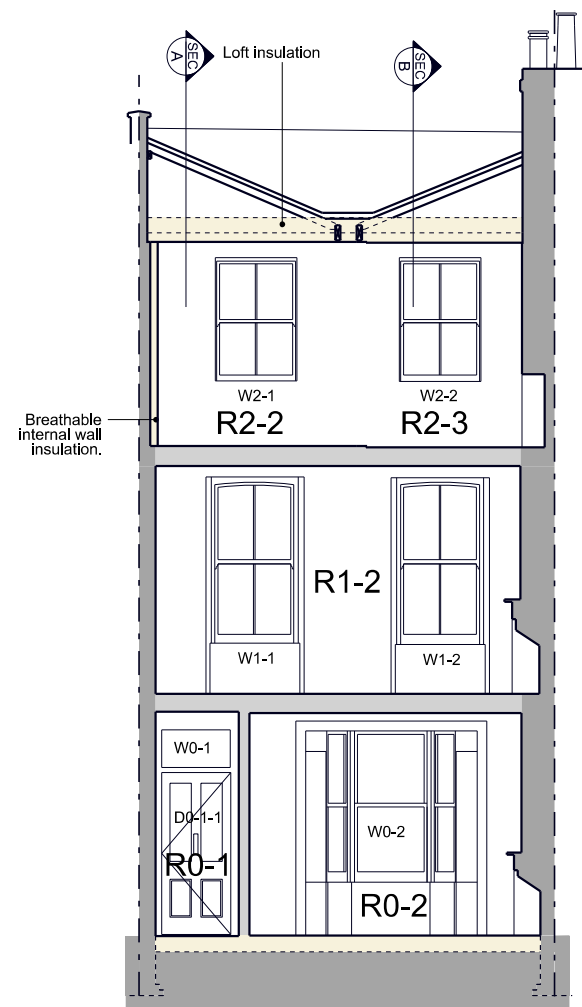

## Proposed Section CC

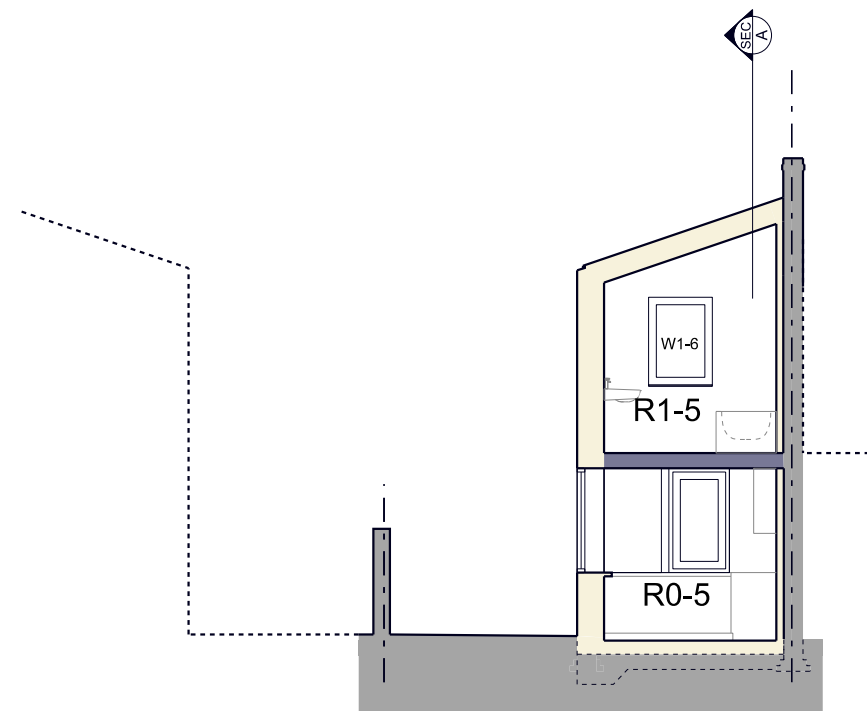

## Proposed Section DD

 

## Proposed Sections CC and DD

Drawings may be scaled for purposes of Planning.  
Any discrepancies should be reported immediately to the designer.  
If in doubt ask,  
This drawing is copyright of the designer.

These drawings are based on plans provided by others.  
The designer accepts no liability for inaccuracies.  
Check all dimensions on site before proceeding with the works.

Drawing Status:

## Planning

[illegible]

prewett  
bizley  
architects

10 Palatine Road London N16 8SX 07962 640 174  
anjanied@gmail.com

Project	
---------	--

67 Falkland Road  
London  
NW5 2XB

Drawing

Proposed Sections  
CC and DD

Scale

1:100 @ A3

Date \_\_\_\_\_

June 14

Drg. no.

109 P 22

vision