


PROPOSED PIPE SUPPORT METHOD  
NOT TO SCALE

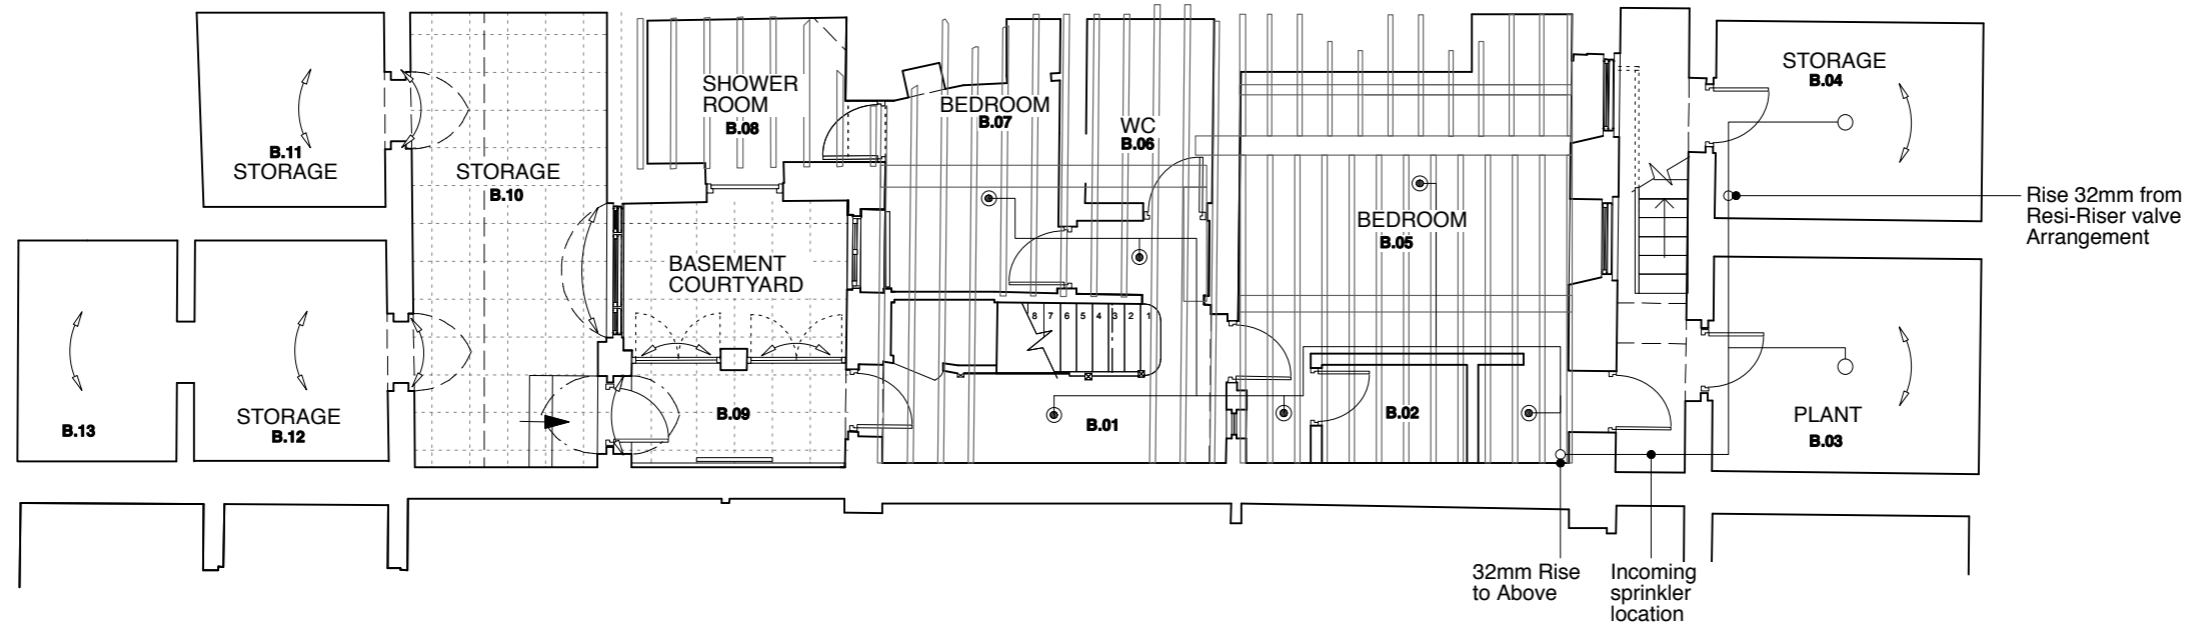

PROPOSED BASEMENT FLOOR PLAN SHOWING SPRINKLER LAYOUT ON GROUND FLOOR JOISTS

GENERAL NOTES:  
DO NOT SCALE FROM THIS DRAWING.  
ALL DIMENSIONS MUST BE CHECKED ON SITE AND ANY DISCREPANCIES VERIFIED WITH THE ARCHITECT.

CLIENT

**MR AND MRS  
MACDONAGH**

JOB TITLE

**30 GREAT JAMES ST.  
LONDON  
WC1N 3EY**

DRAWING TITLE

**BASEMENT RCP  
SHOWING SPRINKLER  
LAYOUT**

SCALE

**1:100@A3**

DATE

**09.14**

**FT ARCHITECTS LTD**

Hamilton House  
Mabledon Place  
Bloomsbury  
WC1H 9BB

020 7953 0388

www.ftarchitects.co.uk

DRAWING No.

**241\_51\_01**

REVISION

-


SCALE

0 (metres)

5



GENERAL NOTES:  
 DO NOT SCALE FROM THIS DRAWING.  
 ALL DIMENSIONS MUST BE CHECKED ON SITE AND ANY DISCREPANCIES VERIFIED WITH THE ARCHITECT.

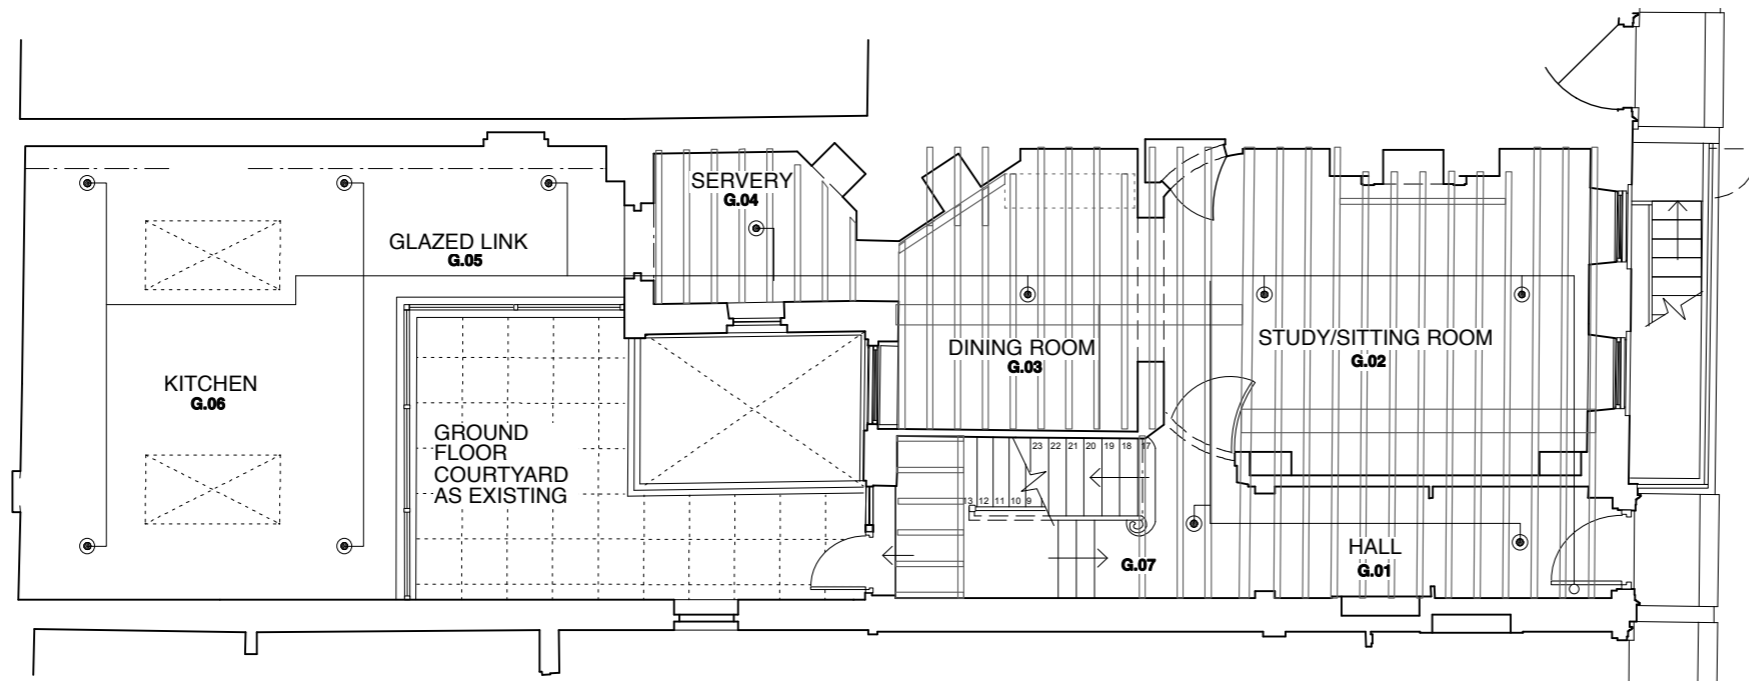

PROPOSED GROUND FLOOR PLAN SHOWING SPRINKLER LAYOUT ON FIRST FLOOR JOISTS

CLIENT

**MR AND MRS  
 MACDONAGH**

JOB TITLE

**30 GREAT JAMES ST.  
 LONDON  
 WC1N 3EY**

DRAWING TITLE

**GROUND FLOOR RCP  
 SHOWING SPRINKLER  
 LAYOUT**

SCALE

**1:100@A3**

DATE

**09.14**

**FT ARCHITECTS LTD**

Hamilton House  
 Mabledon Place  
 Bloomsbury  
 WC1H 9BB

020 7953 0388

www.ftarchitects.co.uk

DRAWING No.

**241\_51\_02**

 
REVISION

-


SCALE

0 (metres)

5



GENERAL NOTES:  
 DO NOT SCALE FROM THIS DRAWING.  
 ALL DIMENSIONS MUST BE CHECKED ON SITE AND ANY DISCREPANCIES VERIFIED WITH THE ARCHITECT.

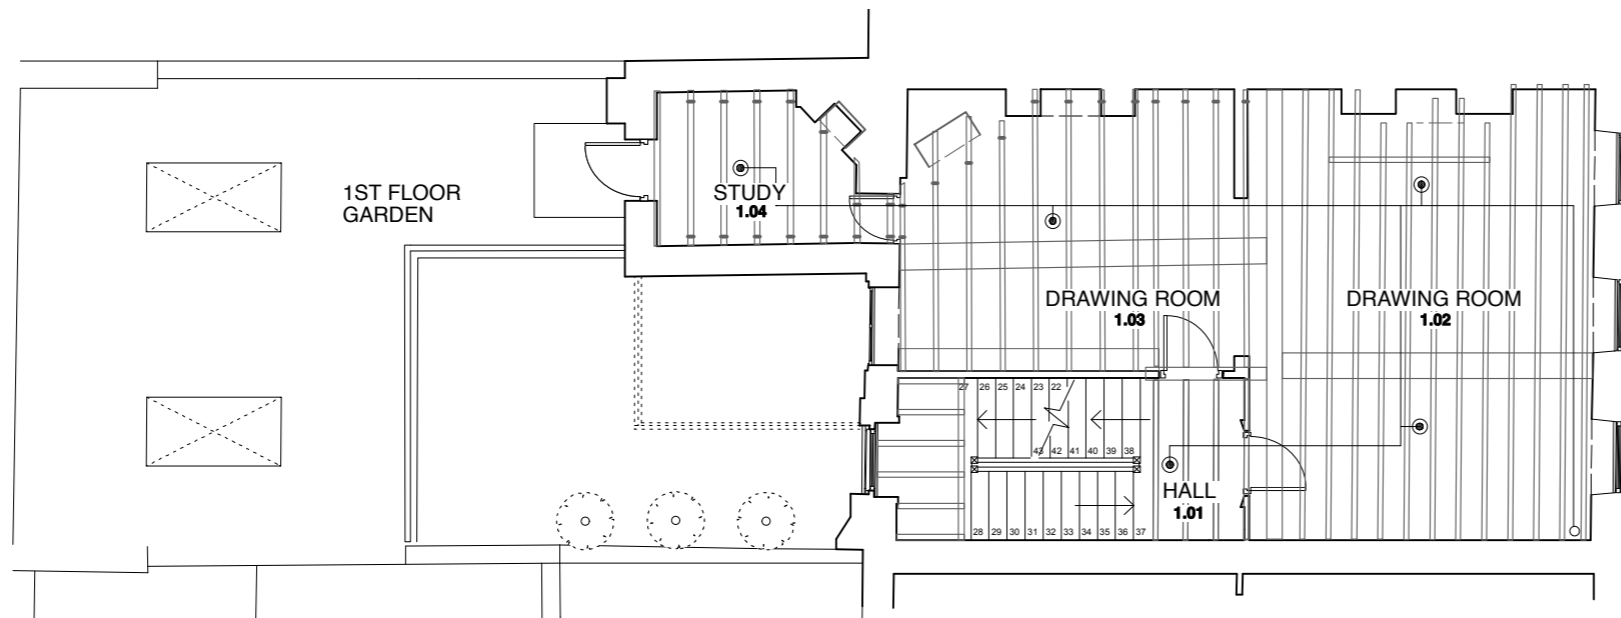

PROPOSED FIRST FLOOR PLAN SHOWING SPRINKLER LAYOUT ON SECOND FLOOR JOISTS

CLIENT

**MR AND MRS  
 MACDONAGH**

JOB TITLE

**30 GREAT JAMES ST.  
 LONDON  
 WC1N 3EY**

DRAWING TITLE

**FIRST FLOOR RCP  
 SHOWING SPRINKLER  
 LAYOUT**

SCALE

**1:100@A3**

DATE

**09.14**

**FT ARCHITECTS LTD**

Hamilton House  
 Mabledon Place  
 Bloomsbury  
 WC1H 9BB

020 7953 0388

www.ftarchitects.co.uk

DRAWING No.

 
**241\_51\_03**

REVISION


SCALE

0 (metres)

5



GENERAL NOTES:  
 DO NOT SCALE FROM THIS DRAWING.  
 ALL DIMENSIONS MUST BE CHECKED ON SITE AND ANY DISCREPANCIES VERIFIED WITH THE ARCHITECT.

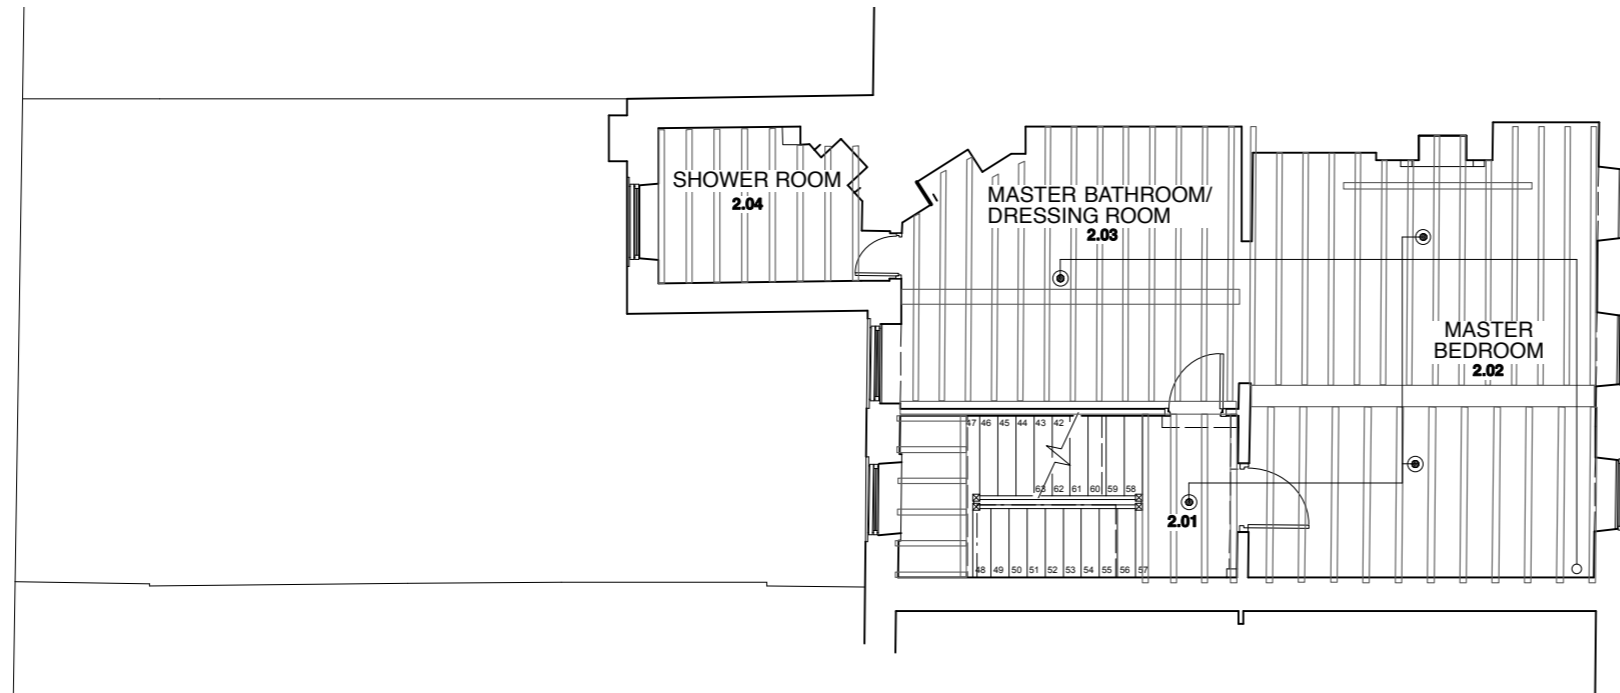

PROPOSED SECOND FLOOR PLAN SHOWING FLOOR SPRINKLER LAYOUT ON THIRD FLOOR JOISTS

CLIENT

**MR AND MRS  
 MACDONAGH**

JOB TITLE

**30 GREAT JAMES ST.  
 LONDON  
 WC1N 3EY**

DRAWING TITLE

**SECOND FLOOR RCP  
 SHOWING SPRINKLER  
 LAYOUT**

SCALE

**1:100@A3**

DATE

**09.14**

**FT ARCHITECTS LTD**

Hamilton House  
 Mabledon Place  
 Bloomsbury  
 WC1H 9BB

020 7953 0388

www.ftarchitects.co.uk

DRAWING No.

**241\_51\_04**

 
REVISION


-

SCALE

0 (metres)

5



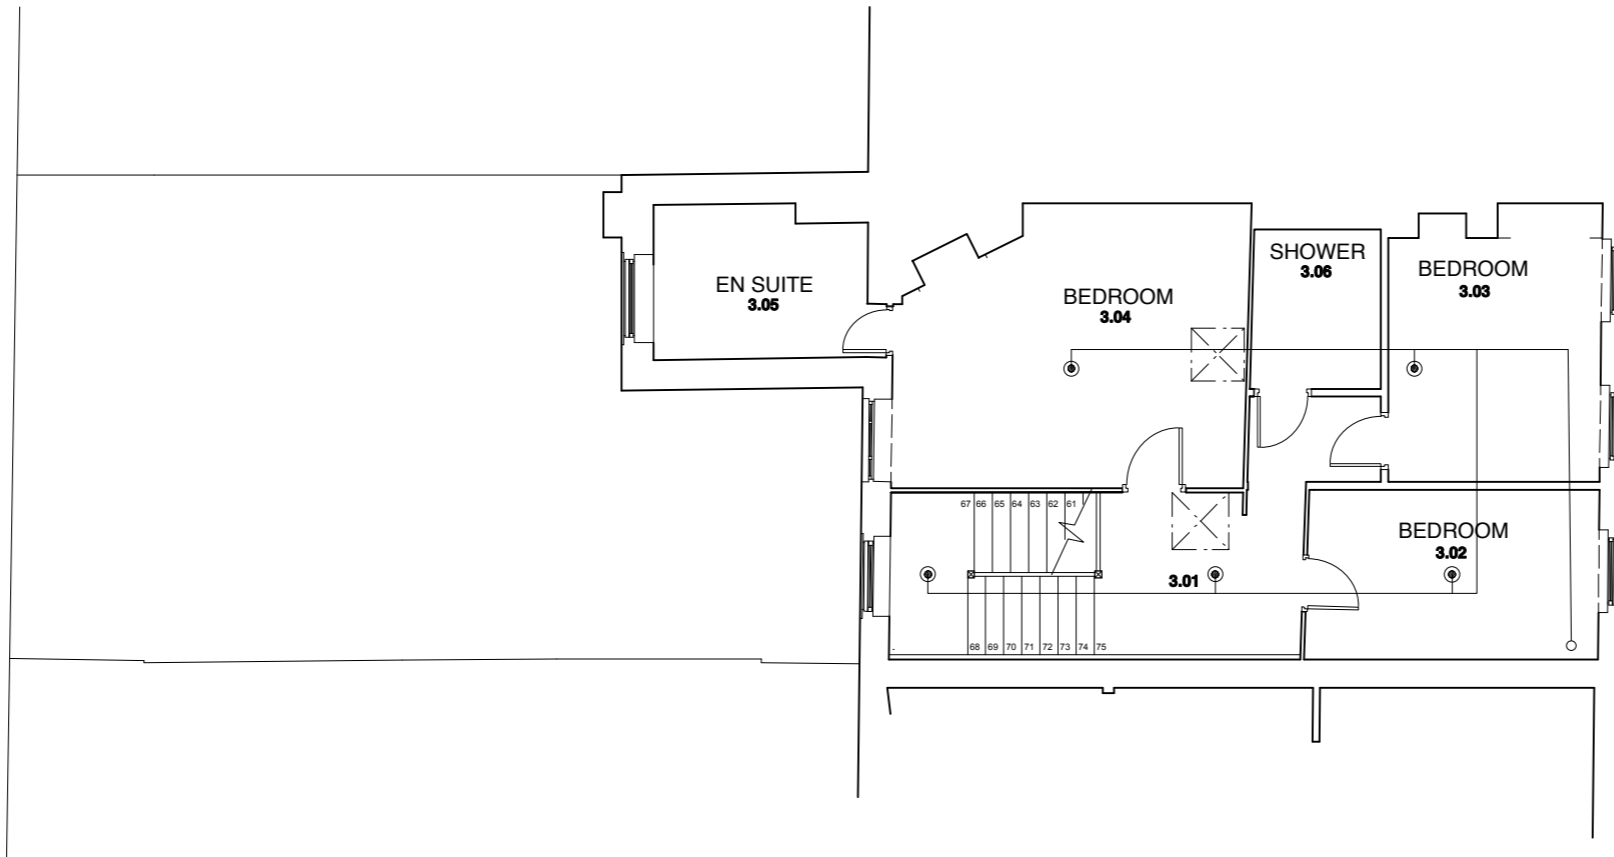

PROPOSED THIRD FLOOR PLAN SHOWING SPRINKLER LAYOUT.  
LAYOUT TO BE COORDINATED WITH ROOF JOIST LAYOUT



GENERAL NOTES:  
DO NOT SCALE FROM THIS DRAWING.  
ALL DIMENSIONS MUST BE CHECKED ON SITE AND ANY DISCREPANCIES VERIFIED WITH THE ARCHITECT.

CLIENT

**MR AND MRS  
MACDONAGH**

JOB TITLE

**30 GREAT JAMES ST.  
LONDON  
WC1N 3EY**

DRAWING TITLE

**THIRD FLOOR RCP  
SHOWING SPRINKLER  
LAYOUT**

SCALE

**1:100@A3**

DATE

**09.14**

**FT ARCHITECTS LTD**

Hamilton House  
Mabledon Place  
Bloomsbury  
WC1H 9BB

020 7953 0388

[www.ftarchitects.co.uk](http://www.ftarchitects.co.uk)

DRAWING No.

**241\_51\_05**

REVISION

-