


NOTES
 OS94 datum value 22.460m located on the junction of
 St. Dunstons and Nottingham Court on the south-east
 face. South angle.

ABBREVIATIONS


| | |
|------|-----------------------------|
| B | Bellied |
| BB | Bellied Beason |
| BL | Basement |
| BL | Basement Light |
| BT | British Telecom Cover |
| CATV | Cable Communications Cover |
| DP | Down Pipe |
| E | Electrical Inspection Cover |
| ER | Earthing Rod |
| EH | Fire Hydrant |
| G/V | Gas Valve |
| IB | Illuminated Bellied |
| IC | Inspection Cover |
| LP | Lamp Post |
| MH | Manhole |
| MH | Manhole |
| OH | Overhead |
| OB | Post Box |
| RE | Rodding Eye |
| RS | Road Sign |
| RWP | Rain Water Pipe |
| SC | Stop Cock |
| SP | Stop Pipe |
| SP | Street Light |
| TB | Traffic Signal |
| TCB | Telephone Call Box |
| TL | Traffic Light |
| TP | Telegraph Pole |
| U | Unidentified Utility |
| UL | Under Lintol |
| UL | Under Lintol Pad |
| WM | Water Meter |
| WW | Water Valve |

| | |
|--------|----------------|
| Bm L/L | Beam Level |
| C L/L | Celling Level |
| C L/L | Centre Level |
| Cn L/L | Crown Level |
| Ft L/L | Floor Level |
| Hd L/L | Head Level |
| IL | Invert Level |
| L/L | Level |
| L/L | Level |
| DL L/L | Dovetail Level |
| SP L/L | Spot Level |
| W L/L | Wall Level |


F/C *****
 C/H *****
 DH = ****
 Floor to Cill dimension
 Cill to Head dimension
 Door head height

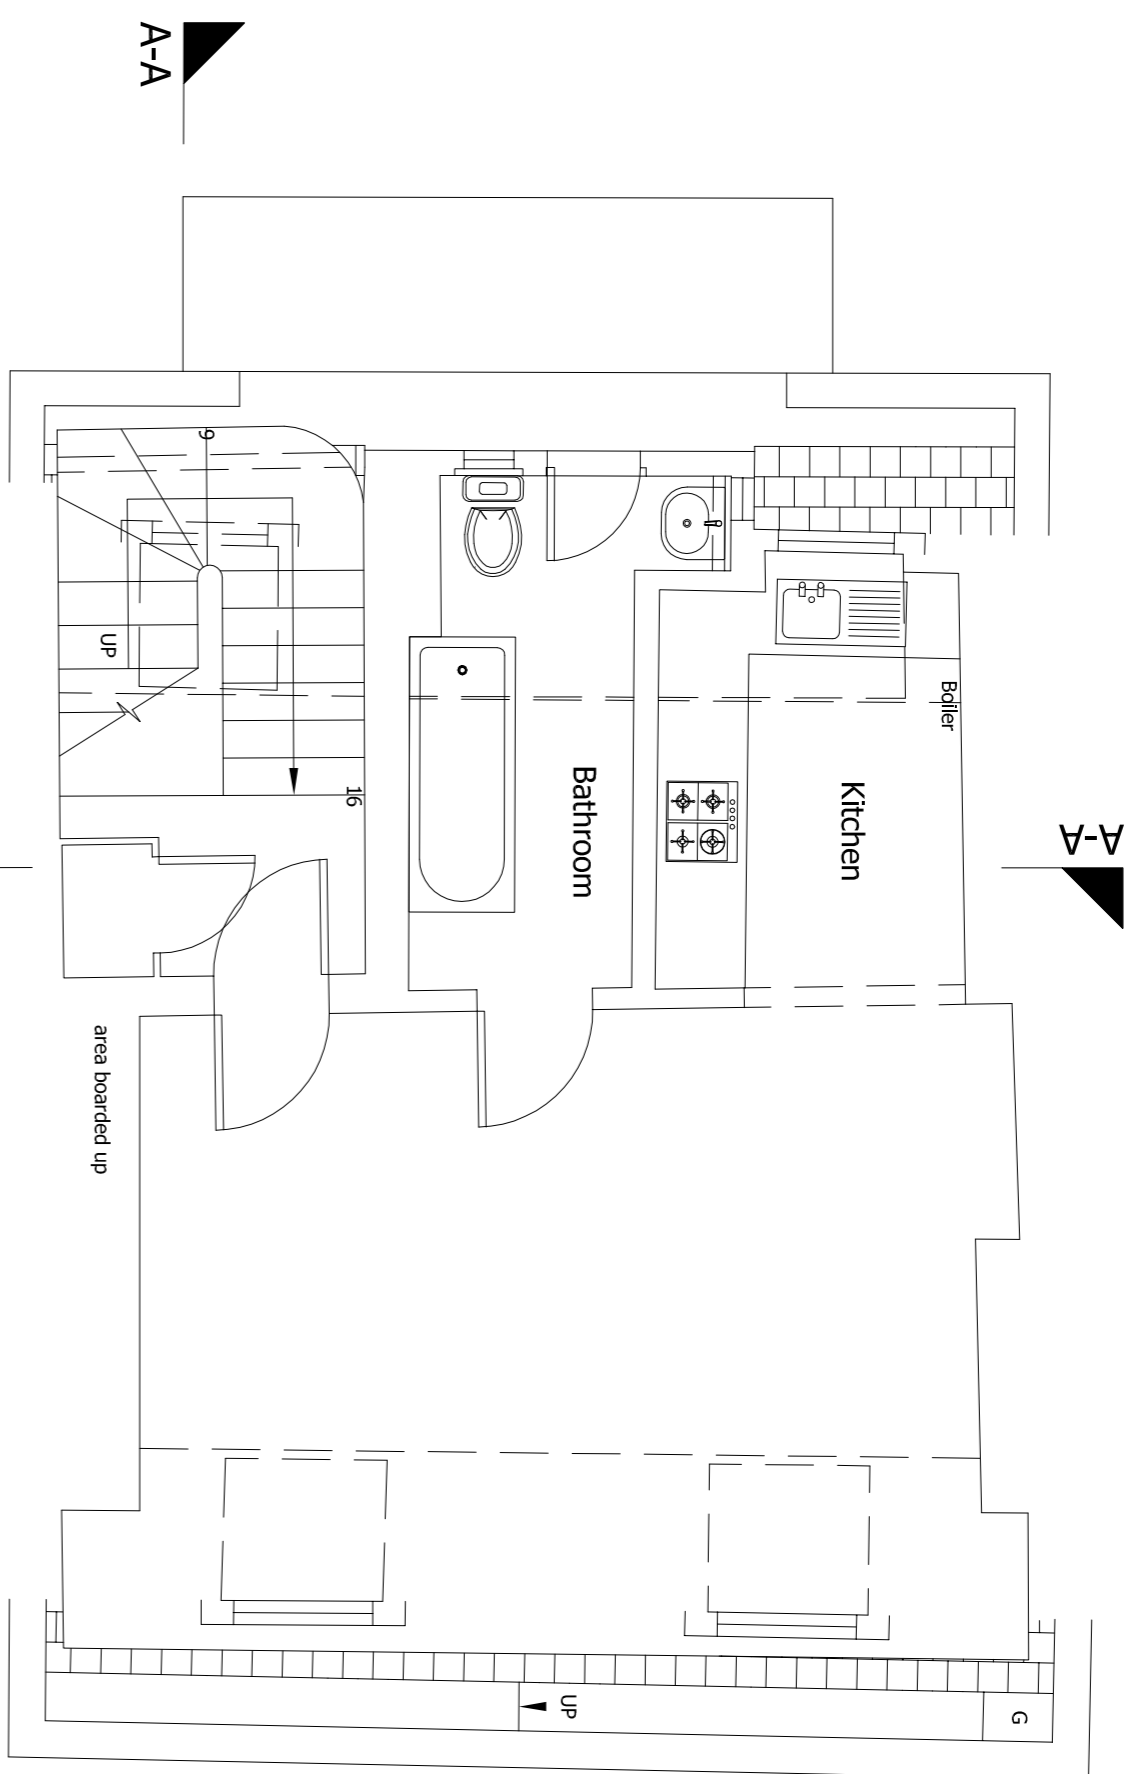


Fourth Floor Plan
 Scale 1:50

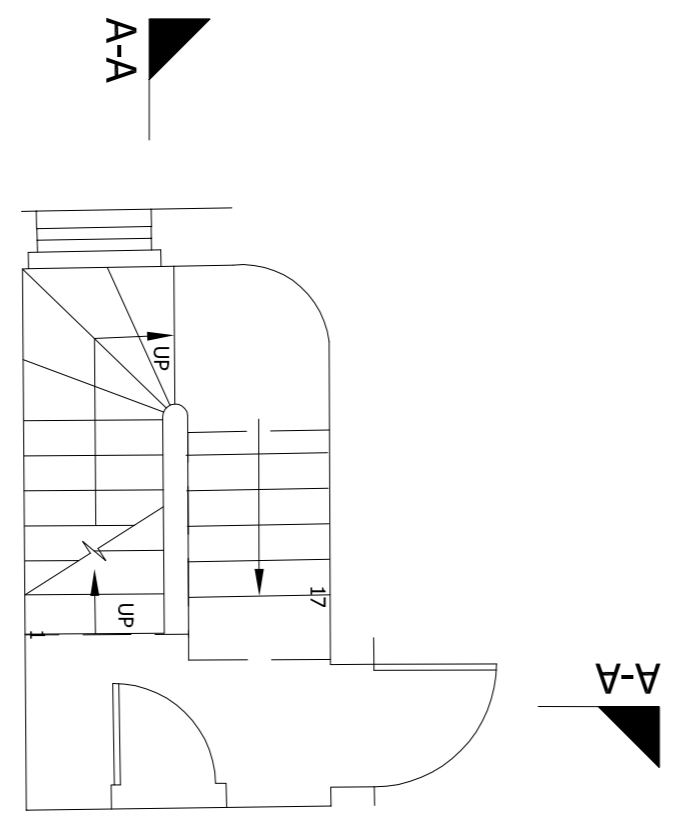


Third Floor Plan
 Scale 1:50

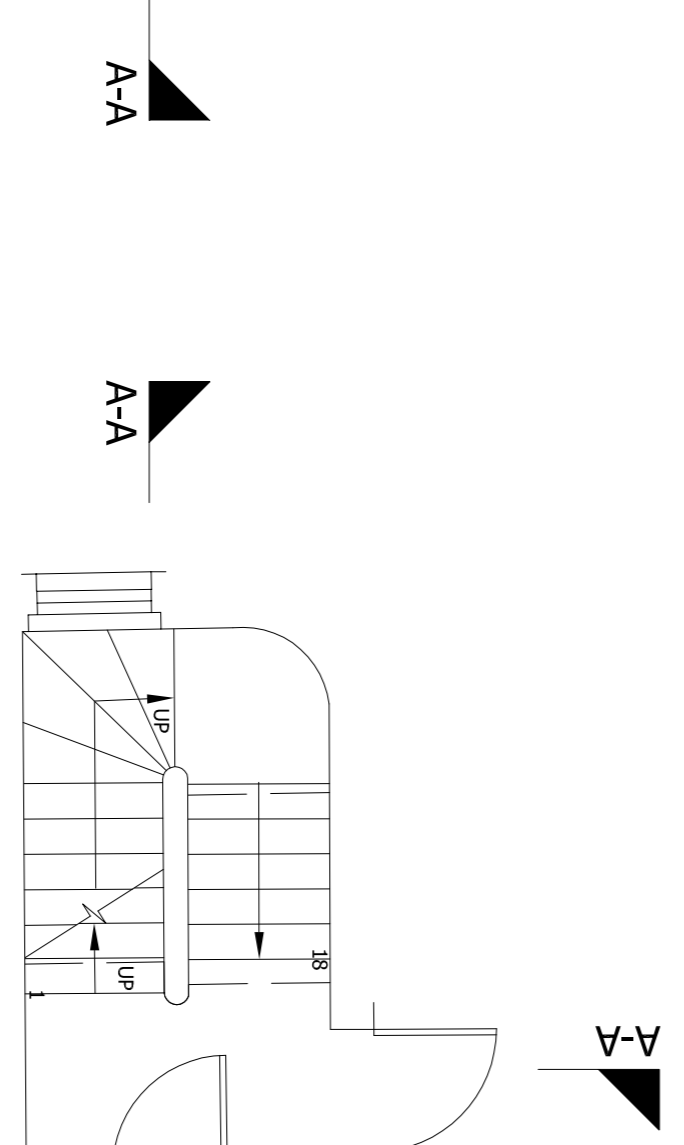

Second Floor Plan
 Scale 1:50

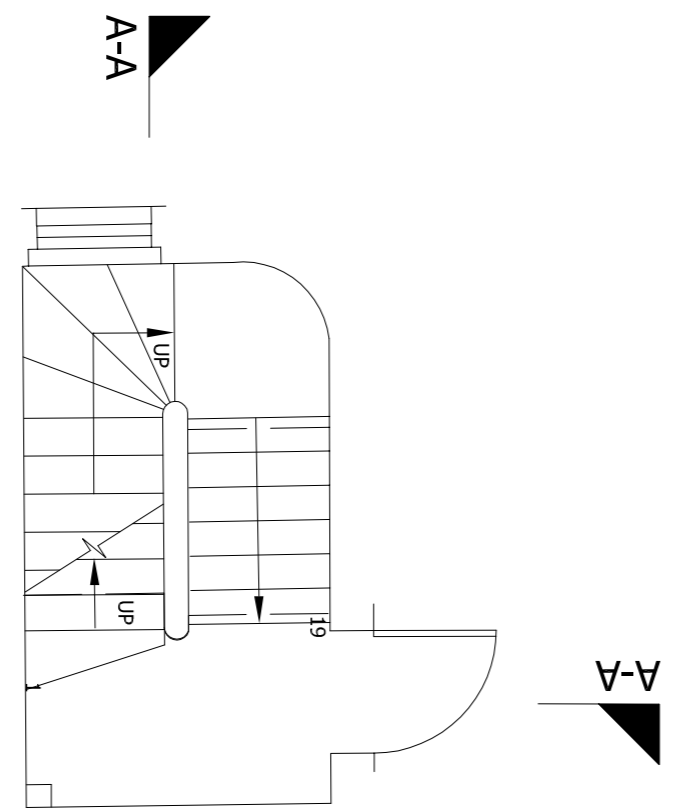

First Floor Plan
 Scale 1:50

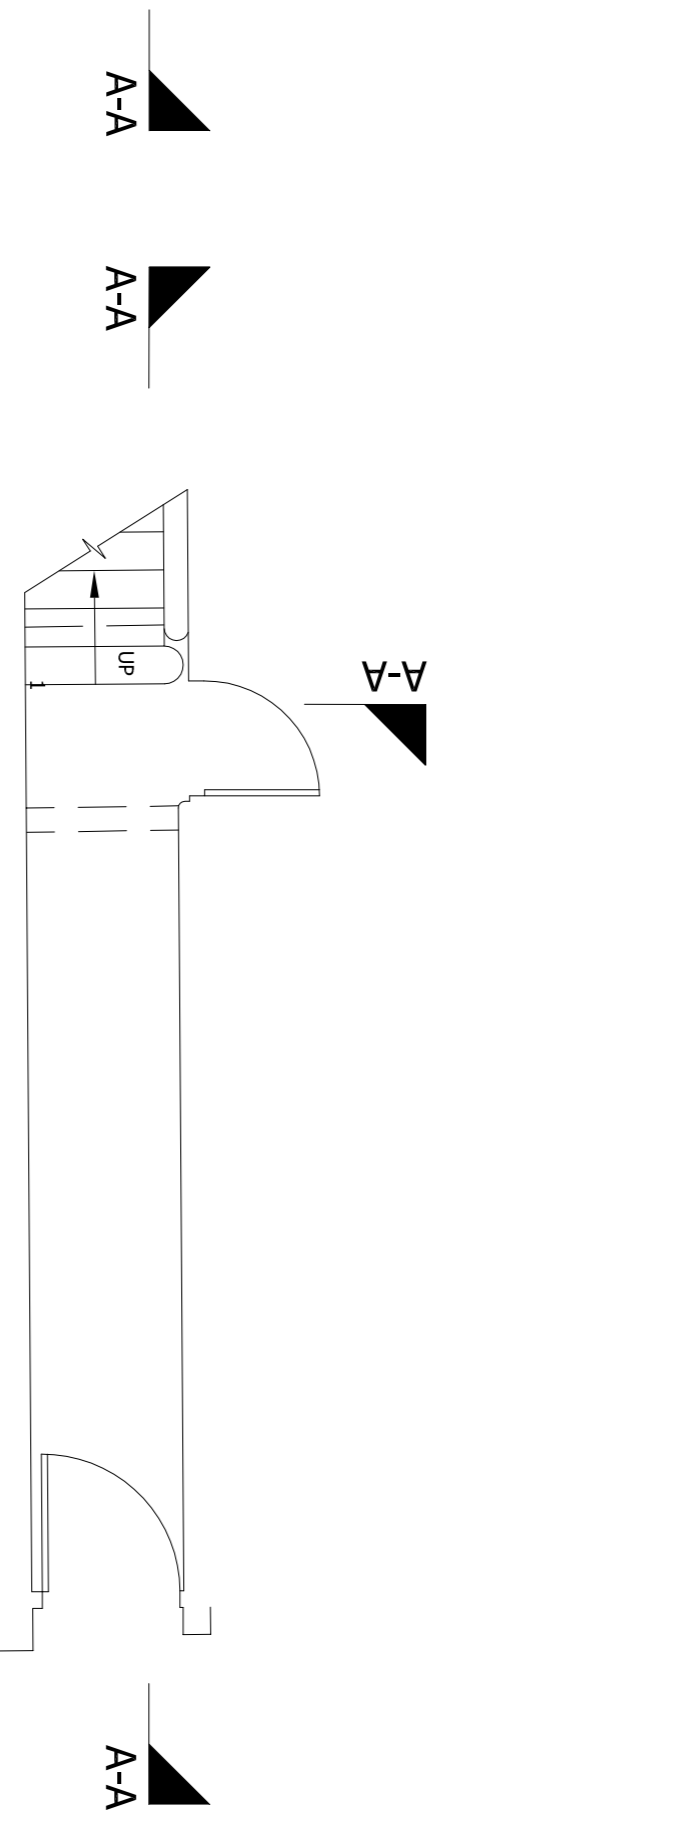

Ground Floor Plan
 Scale 1:50

Rev. A 20-08-14 Window detail to the basement amended (LRM)
 Date Description
Client
 Brooks / Murray Architects
 8-10 New North Place
 London
 EC2A 4J/A

Site Address
 3 Betterton Street
 London
 WC2H 9BH

LRM Survey Services Ltd.
 Tel: 07793 741977
 Web: www.lrm-survey.co.uk
 Email: enquiries@lrm-survey.co.uk

Existing Floor Plans
 Title
 Date Scale Surveyed Drawn
 08-09-14 1:100@A3 LRM LRM
 Drawing No. 14/BM/388/01