

COPYRIGHT ©  
 FIGURED DIMENSIONS ONLY ARE TO BE USED. FOR OTHER DIMENSIONS REFER TO CA. ALL DIMENSIONS TO BE CHECKED ON SITE PRIOR TO THE COMMENCEMENT OF WORK. DISCREPANCIES, AMBIGUITIES OR DIFFERENCES BETWEEN DRAWINGS, AND BETWEEN DRAWINGS AND SPECIFICATION OR BILLS OF QUANTITIES TO BE REFERRED TO CA WITHOUT DELAY. DO NOT SCALE THIS DRAWING

- NOTES:**
- CONTRACTOR TO INCLUDE FOR ALL SPECIAL DRAW PITS & PROPRIETARY BURIED JUNCTION BOXES TO MEET SPECIALIST CONTRACTORS REQUIREMENTS E.G. BT & CABLE TV.
  - REFER TO WALKER ASSOCIATES GENERAL ARRANGEMENT STRUCTURAL DRAWINGS FOR BUILDERSWORK PENETRATIONS FOR INCOMING AND OUTGOING SERVICES.
  - ALL PENETRATIONS/DUCTS TO COME WITH PUDDLE FLANGES.

- LEGEND:**
- W — PROPOSED NEW WATER MAINS SERVICES
  - EL — PROPOSED EXTERNAL LIGHTING BURIED DUCTS
  - GR — EXISTING BRITISH GAS MAINS GAS SERVICE
  - UKPN — UKPN HV/LV MAINS CABLES
  - C — MAIN CABLE COMPANY DUCTS
  - TW — EXISTING THAMES WATER MAINS SERVICE
  - BT — EXISTING BT SERVICE
  - G — PROPOSED NEW GAS PIPE EXTENSION
  - IW — PROPOSED IRRIGATION SERVICES
  - LV — PROPOSED NEW UKPS LV DISTRIBUTION CABLES FROM SUB-STATION
  - HV — PROPOSED NEW UKPS HV RING MAIN TO SUB STATION
  - TV — PROPOSED NEW UKPS HV RING MAIN TO SUB STATION
  - TL — PROPOSED NEW DUCTS FOR TELEPHONE/ FIBRE SERVICES
  - PVC DUCT (SIZE AS NOTED) WITH PUDDLE FLANGE
  - IRRIGATION TAP
  - CABLE DRAW PIT TYPICAL 600x600x600
  - BFGL — BELOW FINISHED GROUND LEVEL (EXTERNAL) TO TOP
  - BFBL — BELOW FINISHED FLOOR LEVEL (INTERNAL) TO TOP

Revision	Date	Description	Drawn/Checked
D	23.06.14	REVISED TENDER ISSUE TO INCORPORATE STATS QUOTATIONS	ML/SM
C	23.04.14	TENDER ISSUE	CT/SM
B	27.02.14	ISSUED FOR INFORMATION	CT/DF
A	23.01.14	ISSUED FOR INFORMATION	CT/DF

ARCHITECTS LAYOUTS

AAA5174-A-104\_A\_Site Plan Proposed

**PinnacleESP**  
 consulting engineers


Christopher Wren Yard  
 119 High Street, Croydon  
 Surrey, CR0 1QG  
 Tel: 0208 776 5500  
 Fax: 0208 776 5533  
 Email: info@pinnacle-esp.co.uk  
 Web: www.pinnacle-esp.co.uk

PROJECT:  
**PLENDER STREET**

Client:  
**Higgins**

Title:  
**PROPOSED INCOMING AND SITE SERVICES LAYOUT**

Scale: 1:200@A1  
 Drawn: CT  
 Date: DEC'13  
 Dwg.No. **P3088-ME-001**

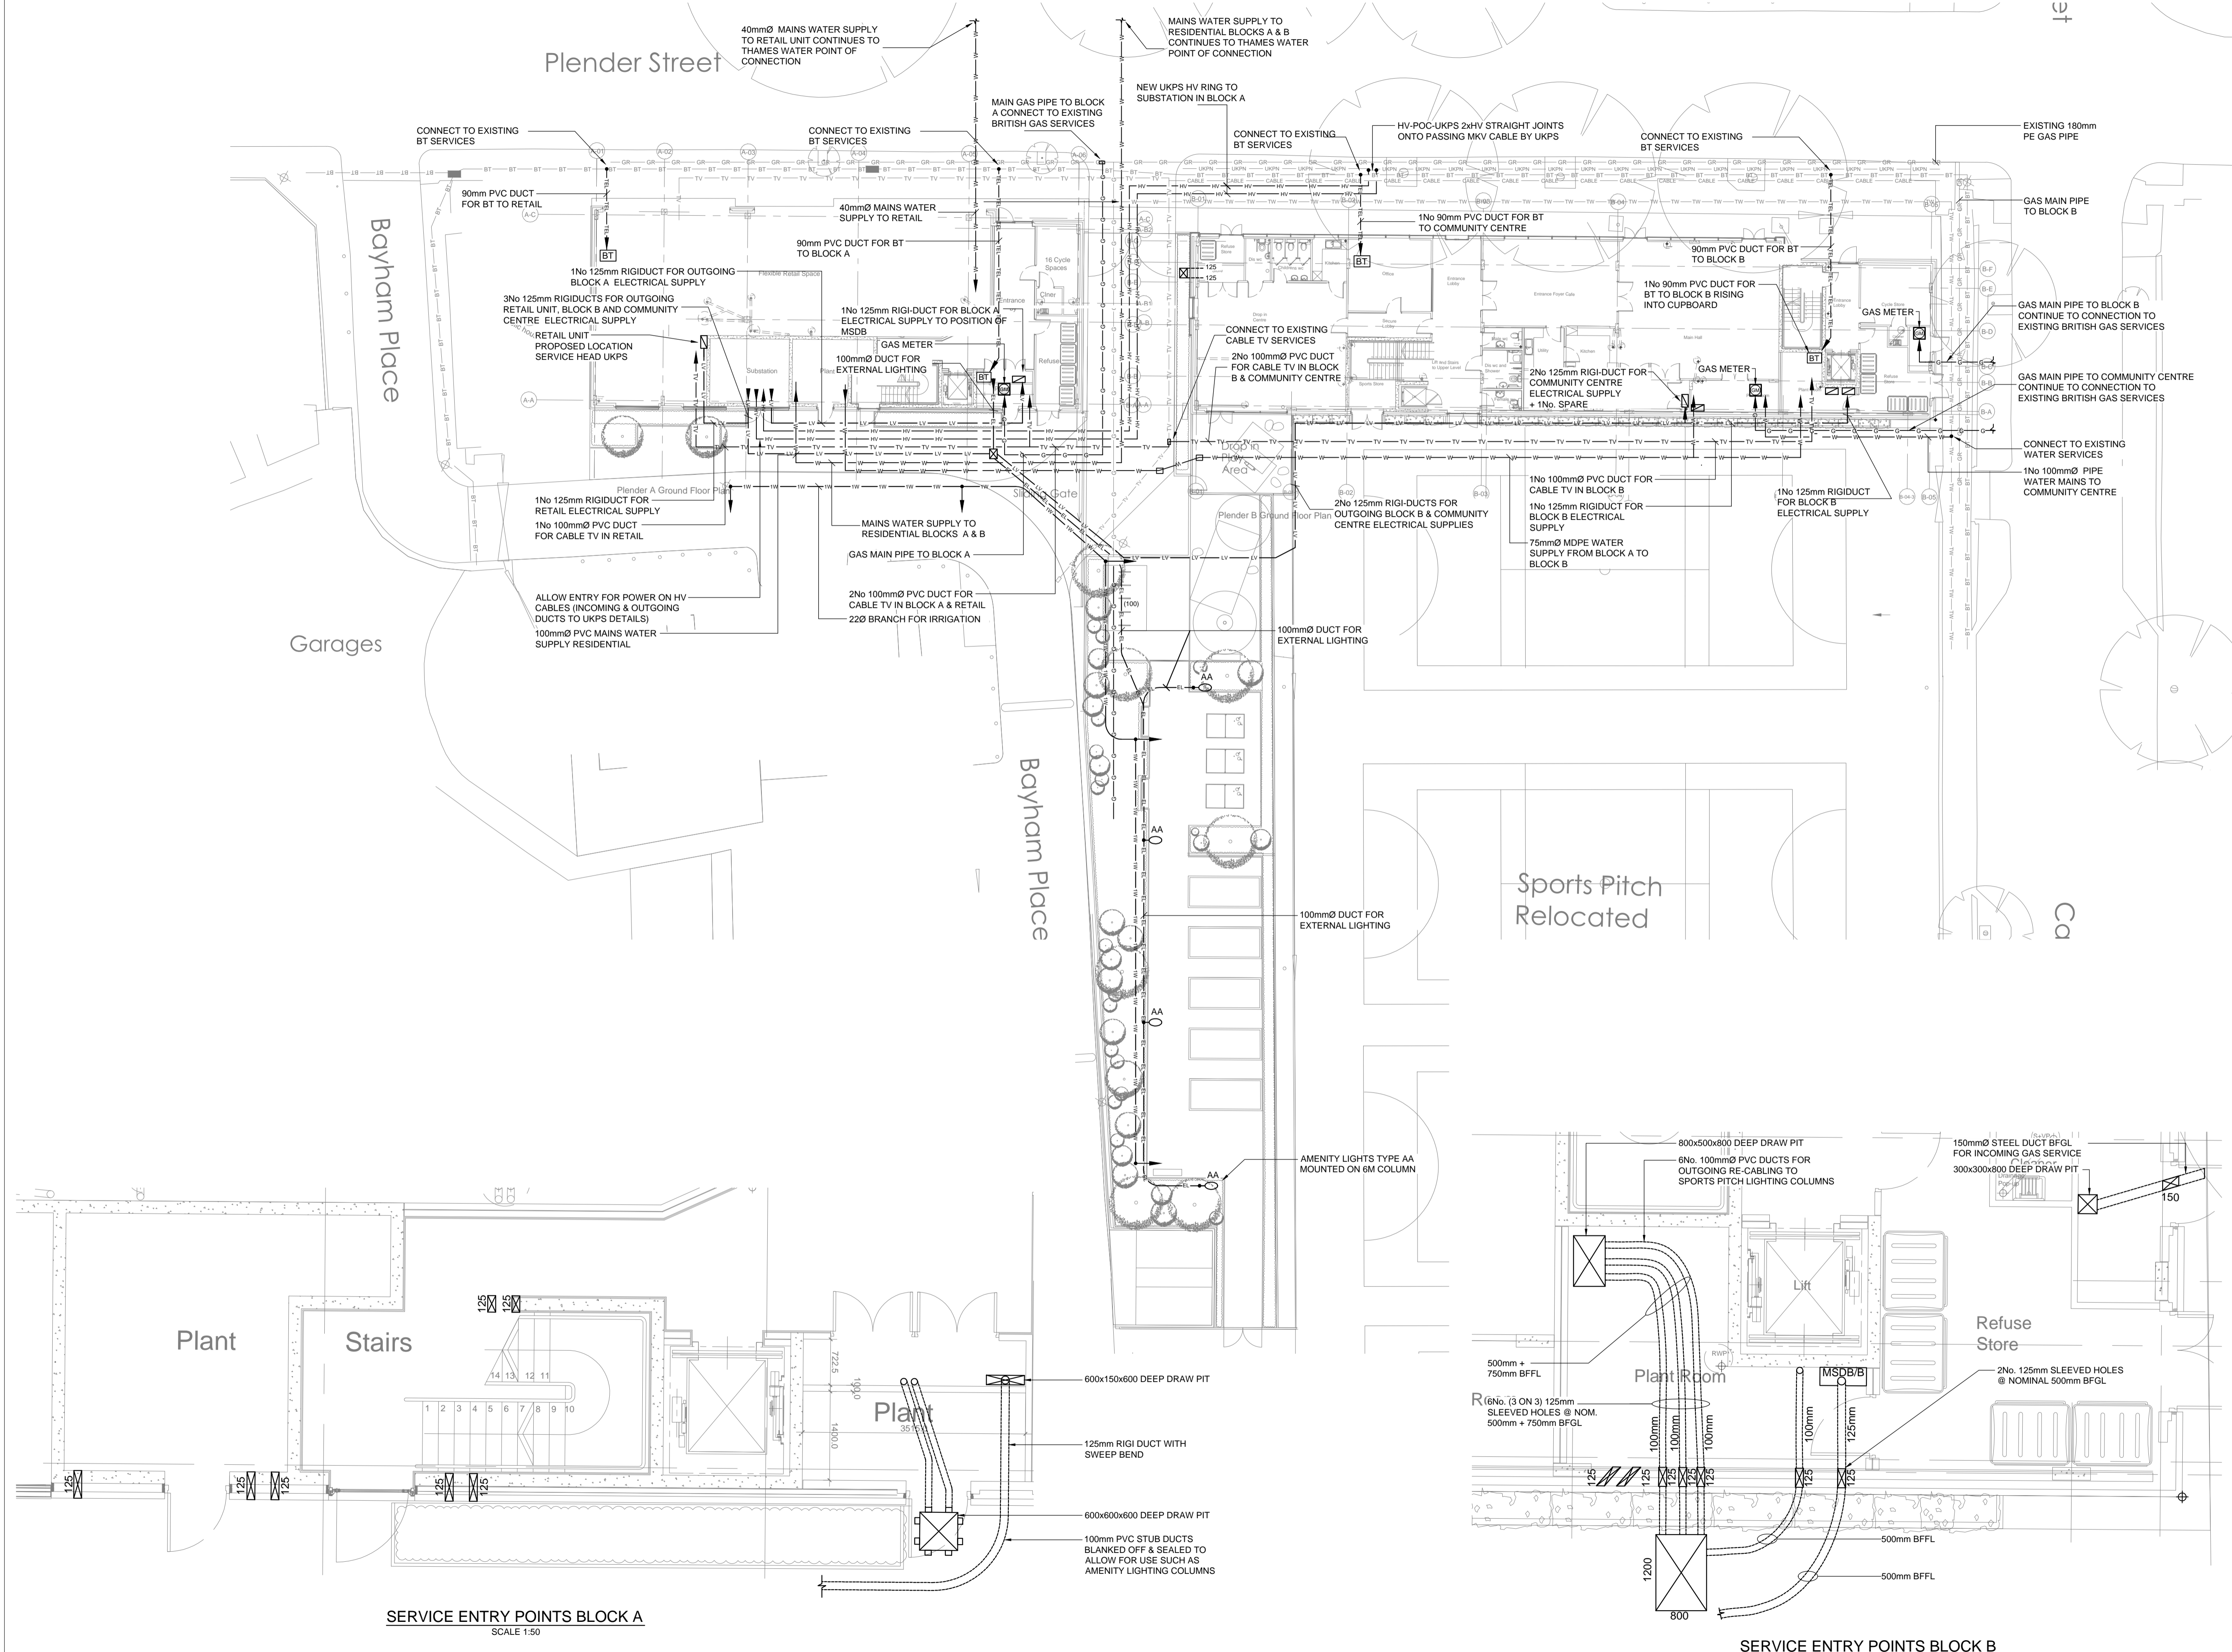

**SERVICE ENTRY POINTS BLOCK A**  
 SCALE 1:50

**SERVICE ENTRY POINTS BLOCK B**  
 SCALE 1:50

REVISION: D