


FINCHLEY ROAD

No. 374

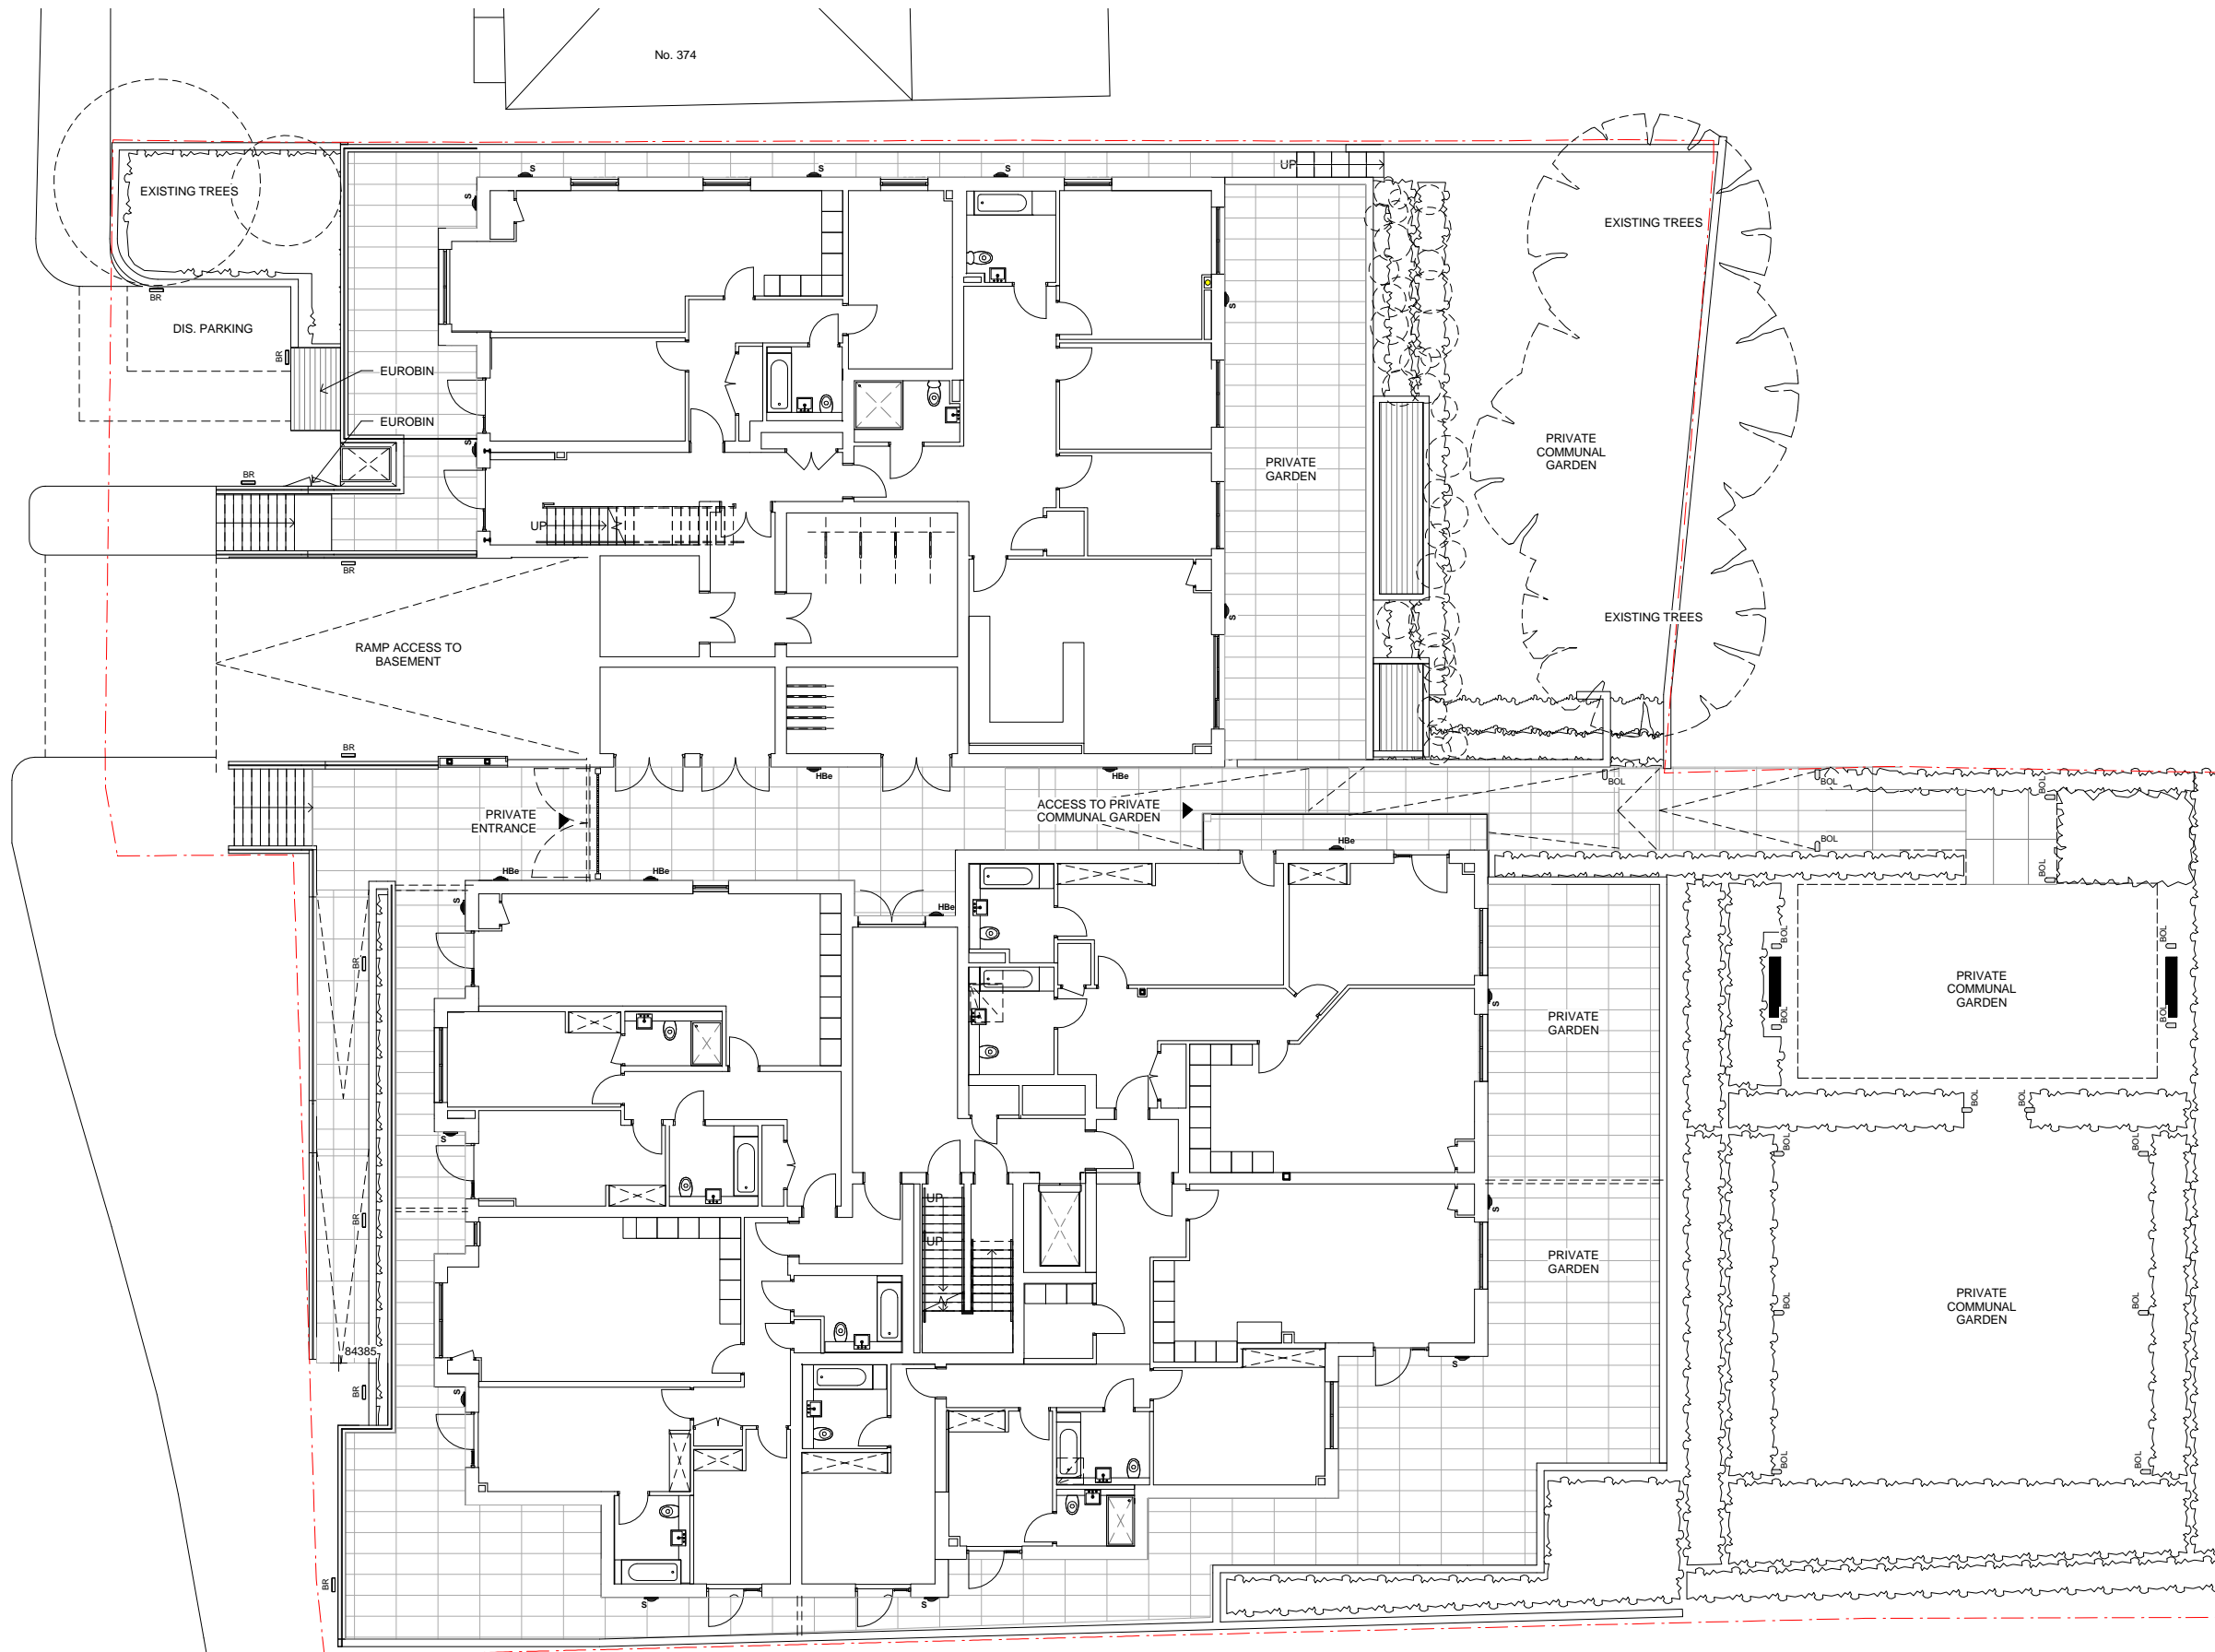


KEY - PLANNING CONDITION 15

- ASD HORIZON - EXTERNAL LIGHT FITTING
- INTALIE BRICK LED - DOWN UNDER LIGHT
- ASD HARMONY HALO WHITE - WITH/WOUT BATTERY PACK
- INCANA IP44 35 W BLACK BOLLARD LIGHT

*SEE ADDITIONAL DATA SHEET FOR FURTHER INFORMATION

KEY RESIDUAL RISK

KEY PLAN

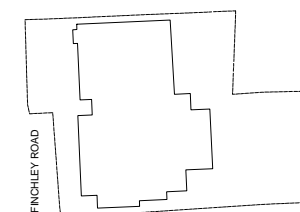

No. 366

1 GROUND FLOOR AREA PLAN - PLANNING LIGHTING

1 : 100

ORIGINATOR davidmillerarchitects WWW.DAVID-MILLER.CO.UK	DRAWING TITLE EXTERNAL LIGHTING PLAN GROUND FLOOR AND PRIVATE COMMUNAL GARDEN	STATUS FOR INFORMATION	
JOB TITLE 368 - 372 FINCHLEY ROAD, NW3 7AJ	JOB NO 282	DATE 19/11/14	CHECKED KA
SCALE 1:100 @A1		APPROVED DMA	REV
PROJECT	ORIGIN	ZONE	LEVEL
FIN	DMA	ALL	GND
TYPE	ROLE	SEQ NO	REV
GA	A3	211	A

