



N.B: New third floor glazed screen and door to be 30 minutes integrity and insulation.
 Door to be held open on magnetic hold open and connected into fire alarm system.

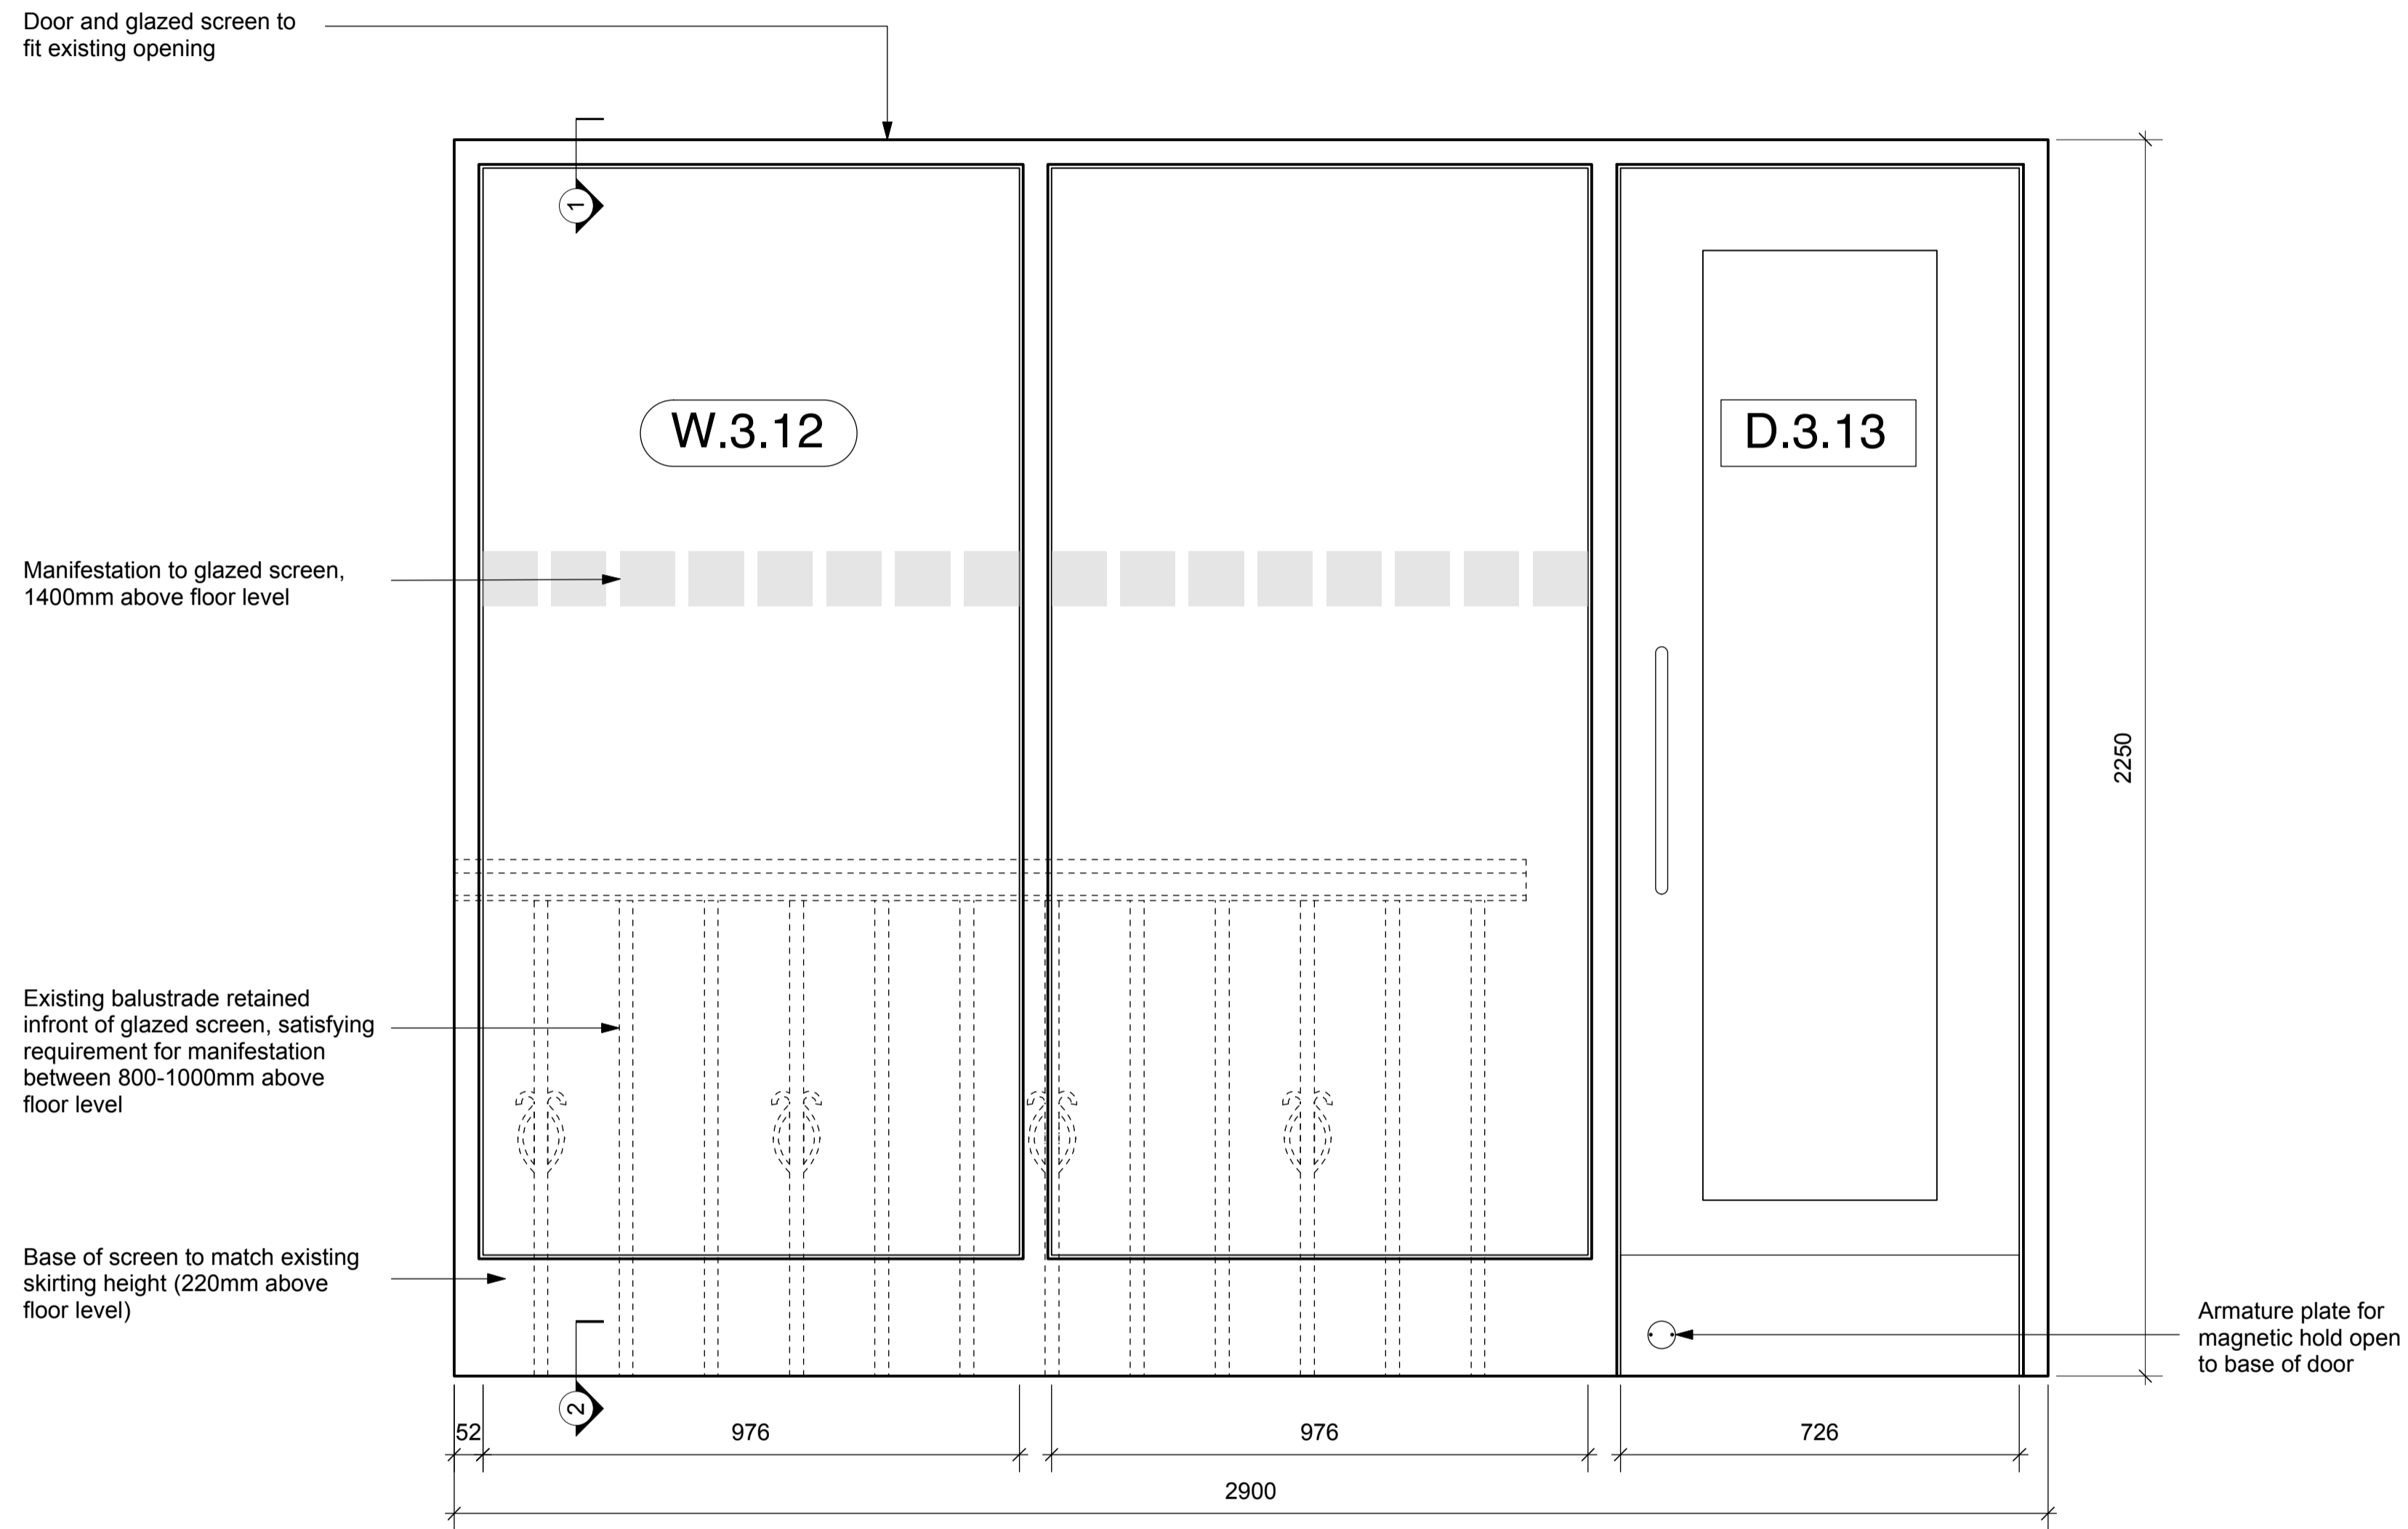

Glazed Screen Elevation
 scale 1:10

1 Glazed Screen Head Detail
 Scale 1:2

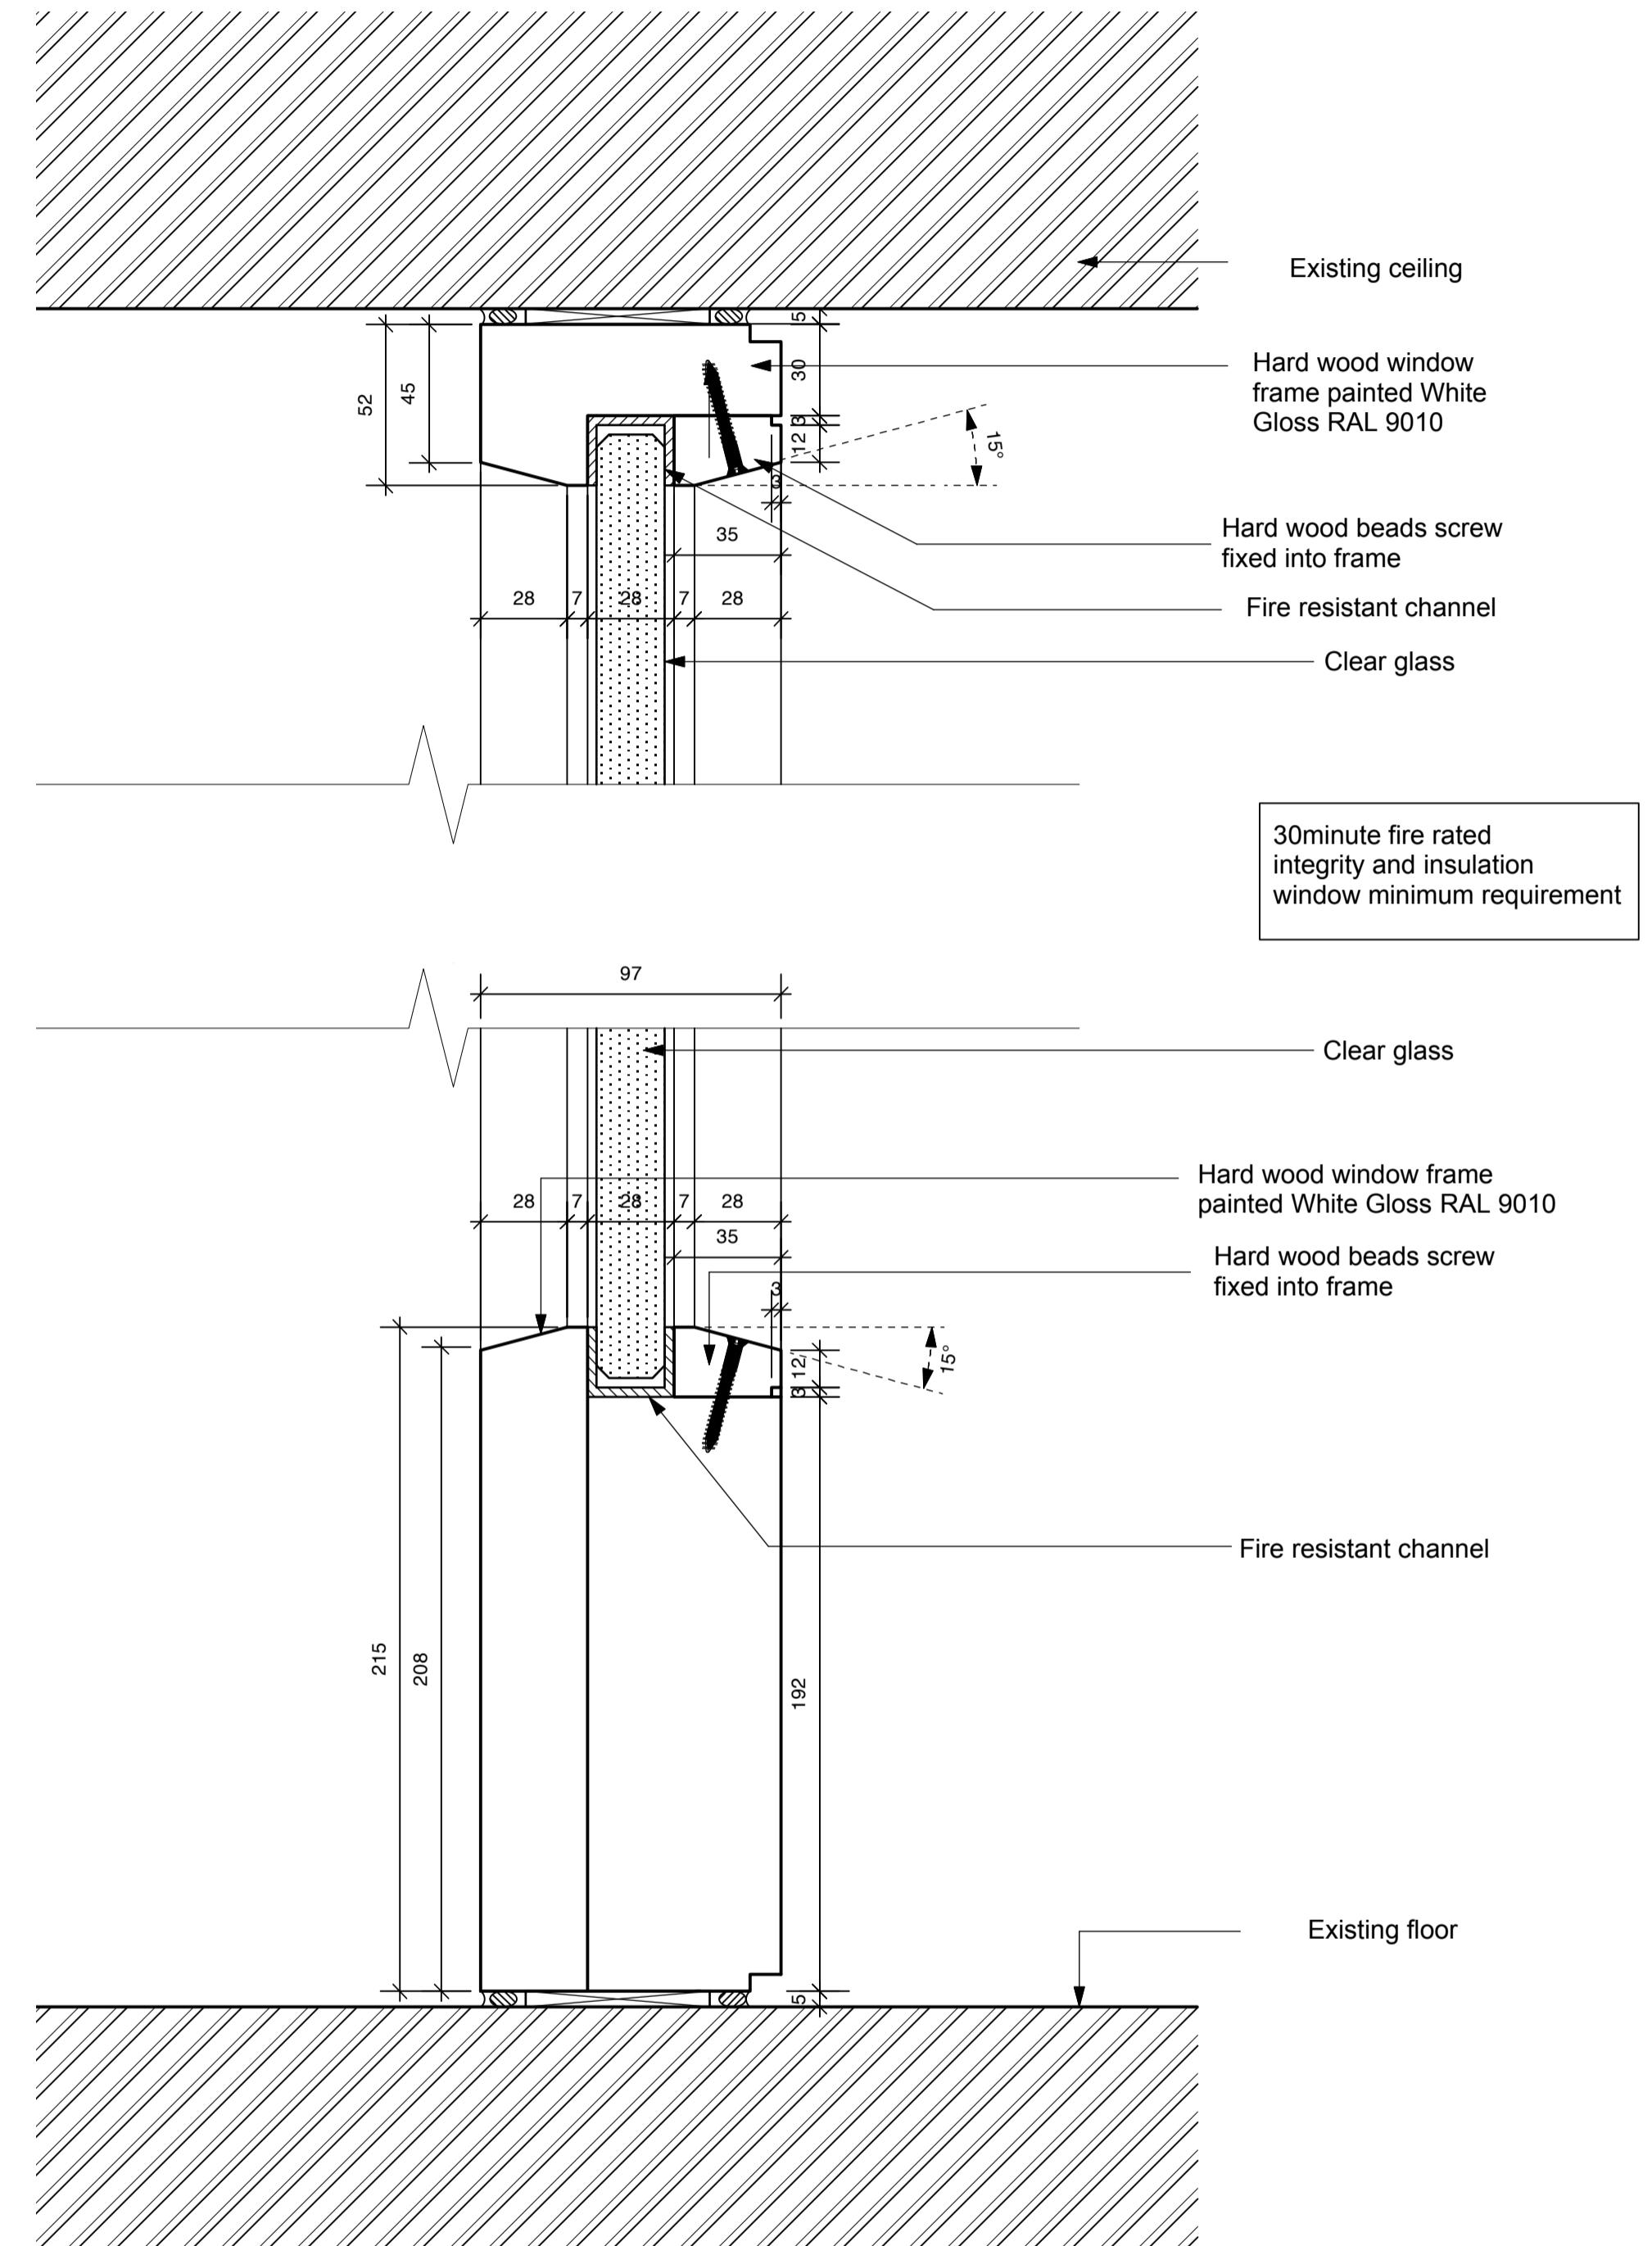

2 Glazed Screen Sill Detail
 scale 1:2

Revision	Date	Initial	Amendment
A	28 11 14	AJL	Planning issue

Notes

No dimensions are to be scaled from this drawing. The contractor / manufacturer is responsible for checking all dimensions and querying any discrepancies.

This drawing is the property of Bisset Adams Ltd.

Copyright is reserved by Bisset Adams Ltd. and the drawing is issued on condition that it is not copied, reproduced, retained or disclosed to any unauthorised person, either wholly or in part, without written consent.

	Royal Holloway, University of London 11 BEDFORD SQUARE-3-5043 30min Fire Rated Full Height Glazed Screen			
	Scale	Various	Status	Planning
	Date	12 11 14	Drawn	AJL
	Checked	---		
Drawing RL001 11 BEDFORD SQUARE-3-5043-A		71 Central Street, London EC1V 8BU		

BISSET ADAMS