




1 Typical FCU Cabinet Plan  
Scale: 1:5

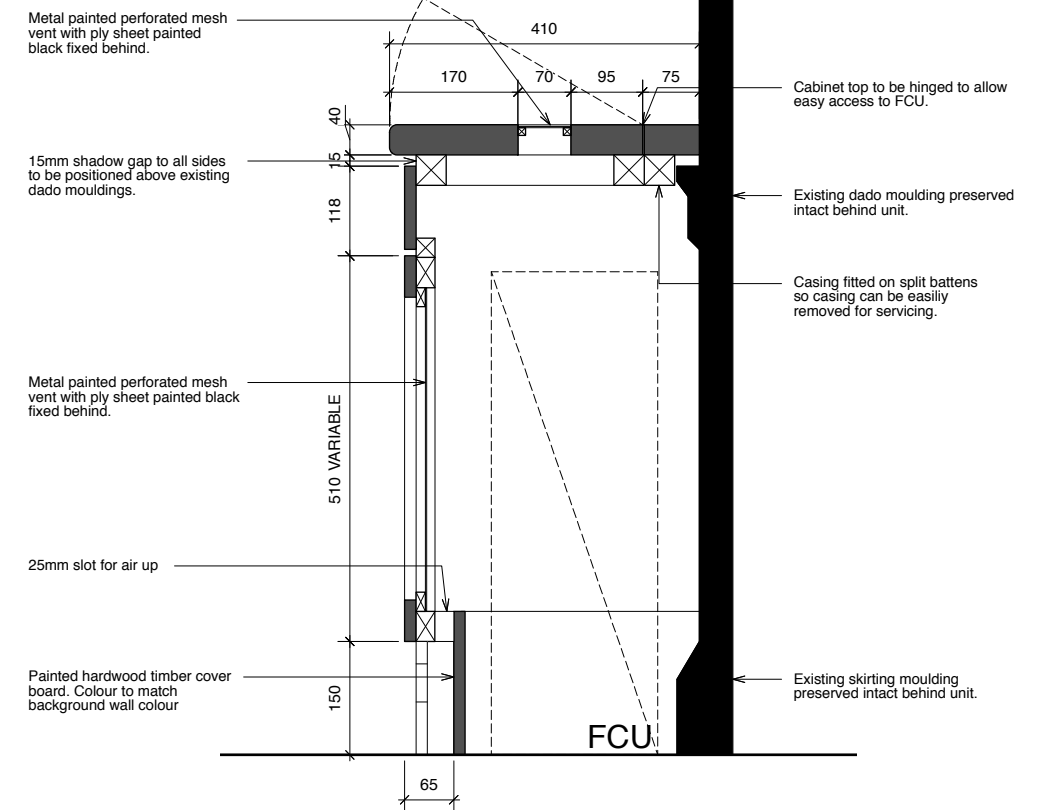

2 Section A  
Scale: 1:5

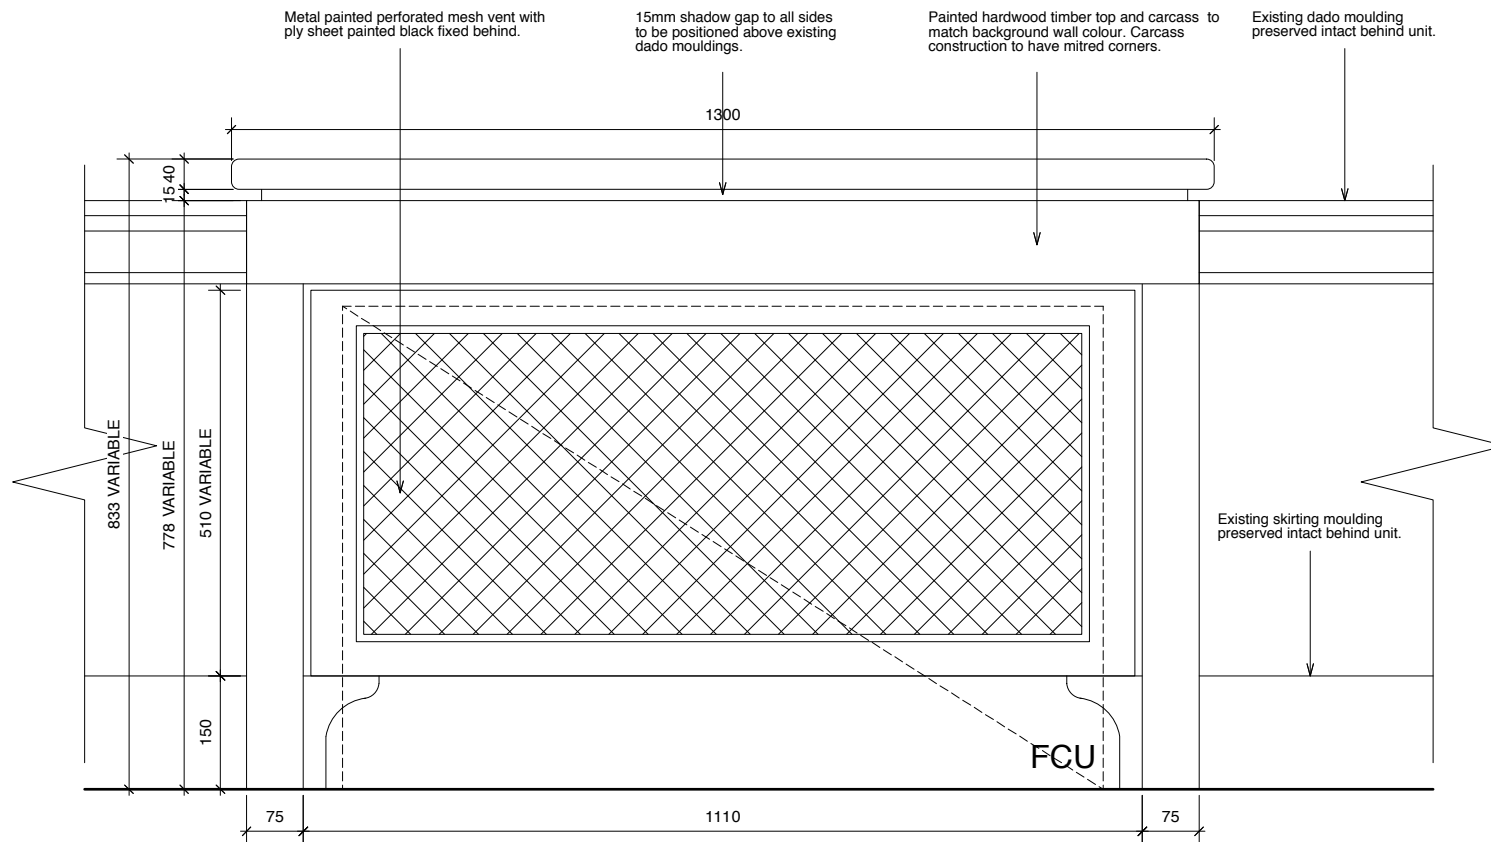

3 Front Elevation B  
Scale: 1:5

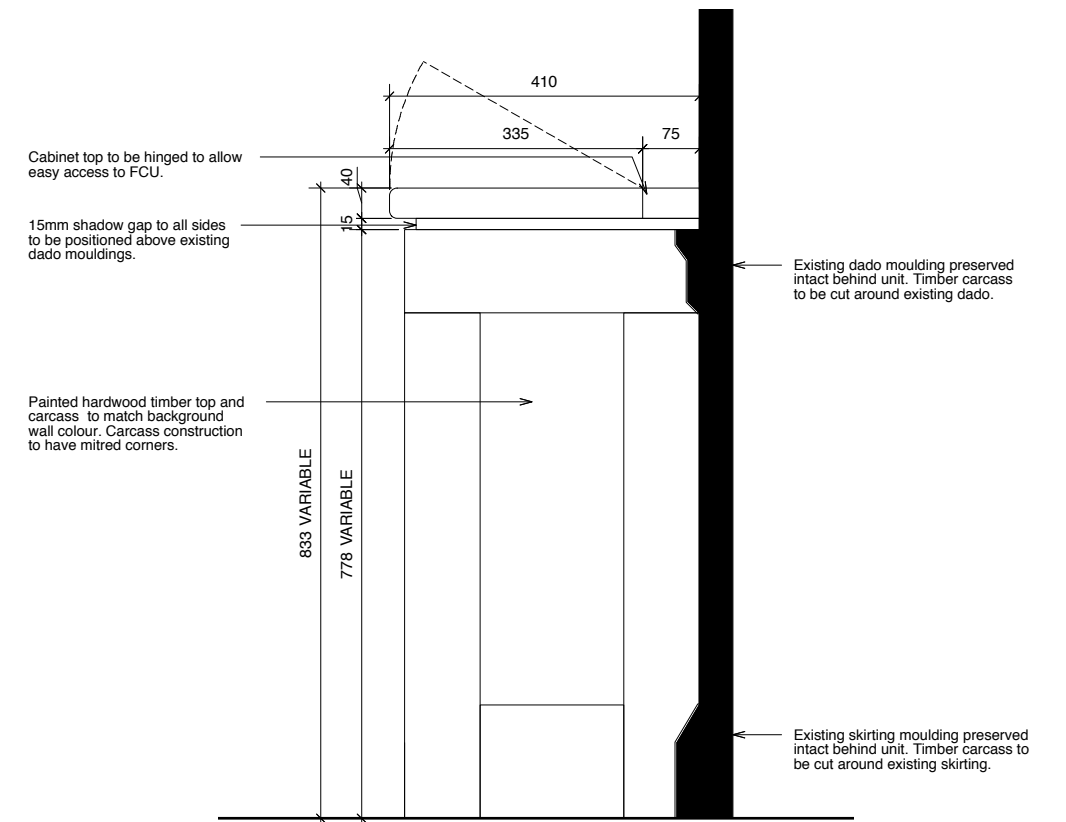

4 Side Elevation C  
Scale: 1:5

Revision	Date	Initial	Amendment
A	28.11.14	AJL	Planning issue

Notes  
No dimensions are to be scaled from this drawing. The contractor / manufacturer is responsible for checking all dimensions and querying any discrepancies.  
This drawing is the property of Bisset Adams Ltd.  
Copyright is reserved by Bisset Adams Ltd. and the drawing is issued on condition that it is not copied, reproduced, retained or disclosed to any unauthorised person, either wholly or in part, without written consent.

**Manufacturer to check all site dimensions prior to manufacture due to irregularities in the existing walls.**  
**Joinery unit to be aligned to existing dado rail. Skirting and dado rail shown indicatively. Manufacturer to check on site prior to manufacture.**

	<b>Royal Holloway, University of London</b> <b>11 BEDFORD SQUARE-3-5044</b> <b>Typical Fan Coil Unit Cabinet Detail</b>						
	Scale	1:5		Status	Planning		
	Date	14.11.14		Drawn	ED	Checked	---
	Drawing	RL001 11 BEDFORD SQUARE-3-5044-A		71 Central Street, London EC1V 8BU			