

SIGNAGE SCHEDULE - "S"					
DESIGN ID	COUNT	DESCRIPTION	RESP.	BULB	COMMENTS
SIGNAGE - DISK					
13157	1	NEW VINYL LOGO TO EXISTING SUSPENDED ROUNDEL	SBUX		SIGN RELOCATED
XS004	2	NEW LOGO TO EXISTING BLADE SIGN	SBUX		
SIGNAGE - HAND PAINTED					
XS001	1	SIGN - HANDPAINTED WORDMARK - 250MM HIGH LETTERS - COLOUR DULUX 40YY 60/103	SBUX		
XS002	1	HANDPAINTED - EST. 1971 - 90MM LETTER HEIGHT - COLOUR DULUX 40YY 60/103	SBUX		
XS003	1	HANDPAINTED - STREET ADDRESS - 90MM LETTER HEIGHT - COLOUR DULUX 40YY 60/103	SBUX		

SITE SCHEDULE - "Y"				
DESIGN ID	COUNT	DESCRIPTION	RESP.	COMMENTS
XY002	1	CUSTOM AWNING - TRADITIONAL VICTORIAN SUNBLIND	SBUX	CANVAS TO MATCH DULUX 50BG 08/021 - SAMPLE REQUIRED FROM SUPPLIER FOR SIGN OFF
SITE				
XY001	5	TIMBER PLANTERS ON LOCKABLE CASTERS - 1000L X 350W X 520H	SBUX	FINISH: LARCH TIMBER. SUPPLIER TO BE CONFIRMED
XY004	2	STARBUCKS SCREEN - BLACK WORDMARK TO ONE SIDE	SBUX	BY IGMA. LARCH TIMBER & 35MM BLACKENED METAL BOX SECTION WITH MATT LACQUER FINISH

EXTERNAL WALL TREATMENT (AREA) SCHEDULE - "Q"				
DESIGN ID	AREA	DESCRIPTION	RESP.	COMMENTS
EXTERNAL WALL TILE				
XQ001	6 m²	TILE - VICTORIAN GREENFIELD TILE 150X150MM	GC	BY ORIGINALSTYLE.COM, MATCHING VICTORIAN SKIRTING TILE AT CERTAIN LEVEL - TBC. GROUT: MAPEI 120 NERO



NATURAL OAK FINISH FOR ENTRANCE DOOR




VICTORIAN SKIRTING TILES VICTORIAN GREEN FIELD TILE 150X150 BY ORIGINALSTYLE.COM



VICTORIAN WALL TILES VICTORIAN GREEN FIELD TILE 150X150 BY ORIGINALSTYLE.COM



BRONZE IRONMONGERY TO MATCH MT0005 SUPPLIED BY GC

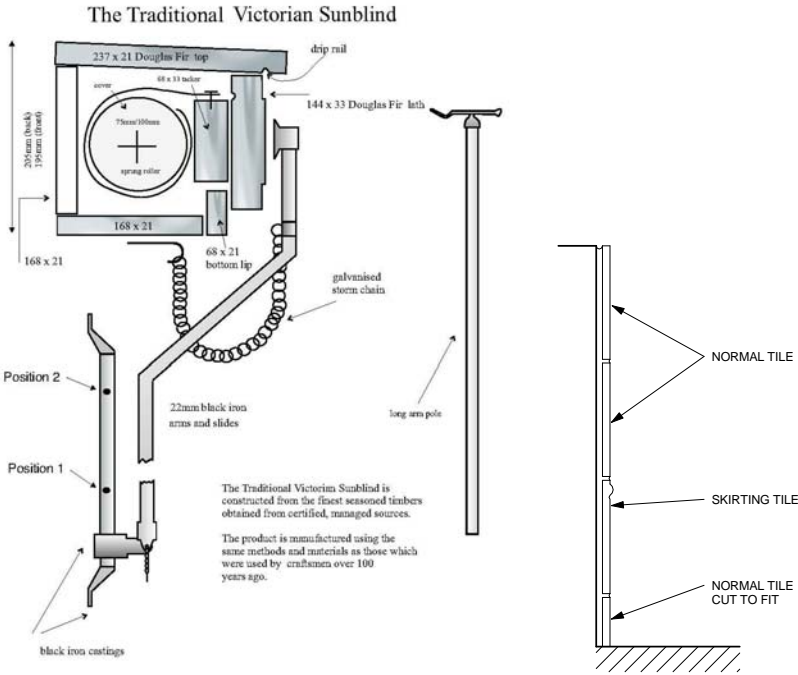

3 AWNING DETAIL
Scale: 1 : 5

5 STALL RISER TILING DETAIL
Scale: 1 : 5

SHEET NOTES

- HANDPAINTED WORDMARK ILLUMINATED BY EXISTING TROUGH LIGHT REFINISHED IN BLACK.
- 1A. HANDPAINTED TEXT.
- 1B. HANDPAINTED STREET ADDRESS.
2. EXISTING ROUNDEL NEW VINYL & SIGN RELOCATED.
3. EXISTING BLADE SIGN NEW VINYL & EXISTING TROUGH LIGHTS.
4. ENTRANCE DOORS SANDED BACK TO NATURAL OAK FINISH AND FINISH WITH CLEAR LACQUER. MATCH TO KAHRS EICHE STRAW NATURAL. NEW BRONZE IRONMONGERY TO MATCH MT0005.
5. TILED STALL RISER. TRADITIONAL STYLE GLAZED TILES. SEE WALL FINISH SCHEDULE @ I-1111 FOR QUANTITY TO BE ORDERED.
- 5A. NEW NON SLIP FLOOR TILES TO ENTRANCE. SEE FLOOR FINISH SCHEDULE @ I-1109 FOR QUANTITY TO BE ORDERED.
6. BARRIERS TIMBER FINISH BRANDED BARRIERS TO END OF SEATING AREAS FOR ADDITIONAL VISIBILITY. ITEMS REQUIRE REVIEWDUE TO LOCATION ON SOPING STREET.
- 6A. PLANTERS ON LOCKABLE CASTERS, TIMBER FINISH. ITEMS REQUIRE REVIEWDUE TO LOCATION ON SOPING STREET.
7. NEW BLACK OUTDOOR FURNITURE.
8. NEW TRADITIONAL AWNING.
9. PAINT FRONT FASCIA, PILASTERS & SHOPFRONT FRAMING - DULUX SATINWOOD WEATHERSHIELD 50BG 08/021.
- 9A. PAINT SIGNAGE FASCIA - DULUX SATINWOOD WEATHERSHIELD 00NN 05/000.
10. PAINT OUT ALARM BOX TO FASCIA (NOT THE ILLUMINATED SECTION) AS PER STOREFRONT COLOUR.

EXTERIOR ELEVATION NOTES

- GENERAL CONTRACTOR TO COORDINATE AND SCHEDULE SIGNAGE INSTALLATION WITH THE SIGNAGE CONTRACTOR PROVIDING A MINIMUM SCHEDULING NOTICE OF 4 WEEKS AND 1 WEEK PRIOR TO SCHEDULED DATE OF INSTALLATION. STARBUCKS CONSTRUCTION MANAGER TO PROVIDE GENERAL CONTRACTOR WITH SIGNAGE CONTRACTOR CONTACT INFORMATION.
- GENERAL CONTRACTOR SHALL COORDINATE WITH ELECTRICAL CONTRACTOR TO FURNISH AND INSTALL ELECTRICAL CIRCUITS INCLUDING ALL CONDUIT, WIRE, CONNECTIONS, AND BREAKER AT PANEL BOARD NECESSARY TO SERVE SIGNAGE.
- GENERAL CONTRACTOR TO PROVIDE FIRE TREATED WOOD STUD BLOCKING, OR EQUIVALENT TO SUPPORT SIGNAGE.
- SIGNAGE CONTRACTOR SHALL VERIFY SIZE AND LOCATION OF ANY AND ALL ALLOWABLE MONUMENT OR POLE SIGNAGE WITH LANDLORD AND PROVIDE SHOP DRAWING(S) PRIOR TO FABRICATION TO STARBUCKS DESIGNER FOR APPROVAL.
- SIGNAGE CONTRACTOR TO INSTALL SIGNAGE IN COMPLIANCE WITH LOCAL CODES AND OBTAIN PERMIT AND LANDLORD APPROVAL.
- SIGNAGE CONTRACTOR TO SUPPLY SHOP DRAWINGS TO STARBUCKS CONSTRUCTION MANAGER AND TO THE GENERAL CONTRACTOR AS NEEDED. GENERAL CONTRACTOR TO NOTIFY STARBUCKS CONSTRUCTION MANAGER IMMEDIATELY IF SHOP DRAWINGS OR INSTALLATION IS IN DISCREPANCY WITH STARBUCKS ARCHITECTURAL DRAWINGS.
- GENERAL CONTRACTOR TO CLEAN, PATCH AND REPAIR EXISTING EXTERIOR AS REQUIRED.



STARBUCKS COFFEE COMPANY
BUILDING 4, CHISWICK PARK
566 CHISWICK HIGH ROAD
LONDON - W4 5YE
020 8834 5000

THESE DRAWINGS AND SPECIFICATIONS ARE CONFIDENTIAL AND SHALL REMAIN THE SOLE PROPERTY OF STARBUCKS CORPORATION, WHICH IS THE OWNER OF THE COPYRIGHT IN THIS WORK. THEY SHALL NOT BE REPRODUCED (IN WHOLE OR IN PART), SHARED WITH THIRD PARTIES OR USED IN ANY MANNER ON OTHER PROJECTS OR EXTENSIONS TO THIS PROJECT WITHOUT THE PRIOR WRITTEN CONSENT OF STARBUCKS CORPORATION. THESE DRAWINGS AND SPECIFICATIONS ARE INTENDED TO EXPRESS DESIGN INTENT FOR A PROTOTYPICAL STARBUCKS STORE (WHICH IS SUBJECT TO CHANGE AT ANYTIME) AND DO NOT REFLECT ACTUAL SITE CONDITIONS. NEITHER PARTY SHALL HAVE ANY OBLIGATION NOR LIABILITY TO THE OTHER (EXCEPT STATED ABOVE) UNTIL A WRITTEN AGREEMENT IS FULLY EXECUTED BY BOTH PARTIES.

ARCHITECT OF RECORD

THIS DRAWING IS A DESIGN DEVELOPMENT DOCUMENT. SITE SPECIFIC MODIFICATIONS MADE UNDER THE RESPONSIBLE CHARGE OF THE ARCHITECT AND/OR ENGINEER-OF-RECORD WILL BE REQUIRED PRIOR TO USING THIS DOCUMENT FOR BIDDING, PERMITTING, OR CONSTRUCTION.

Revision Schedule				
Rev	Date	By	Description	

PROJECT NAME:
Starbucks - Hampstead - South End Road
PROJECT ADDRESS:
5-7 Southend Road, London NW3 2PT

STORE #: 12318
PROJECT #:
CONCEPT:
PALETTE:
ISSUE DATE:
DESIGN MANAGER:
LEED® AP:
PRODUCTION DESIGNER:
CHECKED BY:


SHEET TITLE:
EXTERIOR ELEVATIONS
SCALE: As indicated
SHEET NUMBER:
A-2001

DESIGN DEVELOPMENT ONLY - NOT INTENDED FOR CONSTRUCTION

4 MATERIAL SAMPLES
Scale: 1 : 1



1 PROPOSED FRONT ELEVATION
Scale: 1 : 25

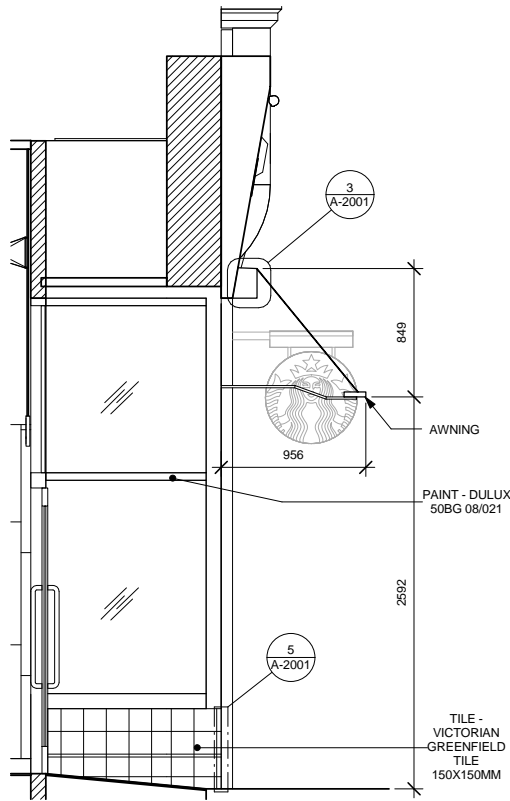

2 STOREFRONT SECTION
Scale: 1 : 25

FURNITURE SCHEDULE - "F"				
DESIGN ID	COUNT	DESCRIPTION	RESP.	COMMENTS
XF02A	1	CUSTOM BANQUETTE - L SHAPE 7420X4985MM	SBUX	FINISH: TIMBER BASE - EXPOSED GRAIN NATURAL OAK (SAMPLE REQUIRED FOR SIGN OFF). UPHOLSTERY - F0073 AGED BROWN WARM LEATHER FROM BAYERN LEDER SAUVAGE COGNAC LEATHER
XF02B	1	CUSTOM BANQUETTE - STRAIGHT 3450X605MM	SBUX	FINISH: TIMBER BASE - EXPOSED GRAIN NATURAL OAK (SAMPLE REQUIRED FOR SIGN OFF)
XF02C	1	CUSTOM BANQUETTE - U SHAPE 3000X5310MM	SBUX	FINISH: TIMBER BASE - EXPOSED GRAIN NATURAL OAK (SAMPLE REQUIRED FOR SIGN OFF)
CHAIR				
12146	20	CHAIR - CAFE SLATTED METAL SUITE WITH ARMS - BLACK MT0028	SBUX	
14714	6	CHAIR - LOUNGE CLUB WITH ROUNDED BACK - BLACK AND BROWN BLACK FLAT WD0061 F0086	SBUX	
14728	25	CHAIR - CAFE HORIZONTAL RUNGS UPHOLSTERED - NATURAL MEDIUM BROWN AND DARK BROWN FLAT WD0059 F0004	SBUX	
14850	5	CHAIR - LOUNGE BEAN - DARK TEAL WOVEN F0107	SBUX	
OTTOMAN				
14712	13	OTTOMAN - WITH WOOD BASE ROUND - 18IN 455MM - BLACK AND AGED WARM BROWN WD0061 F0073	SBUX	
TABLE				
12184	14	TABLE - BASE CAFE DOME ACCENT - 12X28IN 305X710MM - HOT ROLLED STEEL MT0011	SBUX	
12187	24	TABLE - BASE CAFE DOME ACCENT - 18X28IN 455X710MM - HOT ROLLED STEEL MT0011	SBUX	
14709	4	TABLE - TOP METAL ROUND - 18IN 450MM - HOT ROLLED STEEL MT0011	SBUX	
14710	22	TABLE - TOP METAL ROUND - 24IN 600MM - HOT ROLLED STEEL MT0011	SBUX	
14746	5	TABLE - BASE CAFE X BASE 23X28IN 580X710MM - BLACK MT0028	SBUX	
14761	10	TABLE - TOP ROUND - 18IN 455MM - GOLDEN BLONDE WD0054	SBUX	PAIRED WITH ARMCHAIRS
14852	5	TABLE - TOP WITH DECORATIVE EDGE ROUND - 24IN 610MM - BLACK WITH FLECKS CP0005	SBUX	
XF001	1	COMMUNITY TABLE TOP - 1730Lx1030Wx60T	SBUX	FINISH: GOLDEN BLONDE WD0054

SPECIALTY EQUIPMENT SCHEDULE - "E"				
DESIGN ID	COUNT	DESCRIPTION	RESP.	COMMENTS
COOLING				
10473	1	FRIDGE UNDERCOUNTER 2 DOOR - 48IN 1220MM	SBUX	
EQUIPMENT				
12508	2	BLENDER QUIET MODEL ON COUNTER	SBUX	
XE002	1	PITCHER KIT, CONSISTS OF 3 DAIRY, 1 NON-DAIRY, 1 SOY.	SBUX	SKU NO: 011008197
FOOD CASE				
12878	1	FOOD CASE - 1 BAY SELF SERVE CHILLED - 35IN 900MM	SBUX	
12912	1	FOOD CASE - 1 BAY SERVICE AMBIENT - 35IN 900MM	SBUX	
ICE				
10344	1	ICE - BIN DROP IN 90LB 40KG	SBUX	
OTHER				
10091	1	CUP DISPENSER TALL HOT VERTICAL	SBUX	
10396	1	CUP DISPENSER SHORT HOT VERTICAL	SBUX	
10791	2	CUP DISPENSER GRANDE VENTI COLD VERTICAL	SBUX	
10855	2	CUP DISPENSER GRANDE VENTI HOT VERTICAL	SBUX	
10858	1	CUP DISPENSER TALL COLD VERTICAL	SBUX	
11115	1	SOAP DISPENSER SINK MOUNTED	SBUX	
13330	1	MOBILE CUP DISPENSER CADDY	SBUX	
13584	1	CUP DISPENSER TRENTA COLD VERTICAL	SBUX	
XE003	2	FIRE EXTINGUISHER - CHROME FINISH	GC	

SITE SCHEDULE - "Y"				
DESIGN ID	COUNT	DESCRIPTION	RESP.	COMMENTS
XY002	1	CUSTOM AWNING - TRADITIONAL VICTORIAN SUNBLIND	SBUX	CANVAS TO MATCH DULUX 50BG 08/021 - SAMPLE REQUIRED FROM SUPPLIER FOR SIGN OFF
SITE				
XY001	5	TIMBER PLANTERS ON LOCKABLE CASTERS - 1000L X 350W X 520H	SBUX	FINISH: LARCH TIMBER. SUPPLIER TO BE CONFIRMED.
XY004	2	STARBUCKS SCREEN - BLACK WORDMARK TO ONE SIDE	SBUX	BY IGMA. LARCH TIMBER & 35MM BLACKENED METAL BOX SECTION WITH MATT LACQUER FINISH

LAMP SCHEDULE - "L"				
DESIGN ID	COUNT	DESCRIPTION	RESP.	COMMENTS
LAMP				
12314	2	FLOOR LAMP SPLIT METAL BASE - BLACKENED STEEL WITH LINEN SHADE MT0019 F0040	SBUX	LAMPS TO BE WIRED DIRECTLY INTO WALL ON SPUR

SHEET NOTES

- GENERAL CONTRACTOR TO REVERSE DOOR HINGE ON UNDER COUNTER REFRIGERATOR TO LEFT-HAND SWING, AS SHOWN.
- SECURE STORAGE RACKS TO WALL WHERE RELOCATED.
- PLACE FIRE EXTINGUISHER IN WORKROOM PER FIRE INSPECTOR. NEW CHROME FIRE EXTINGUISHERS TO CUSTOMER AREAS.
- SPEAKERS TO BE MOUNTED AT MAXIMUM HEIGHT T/US OF HIGH LEVEL CEILING.

FF AND E PLAN NOTES

- A. GENERAL CONTRACTOR TO SCHEDULE WITH LOCAL REFRIGERATION CONTRACTOR TO CONDUCT INITIAL FOOD CASE START-UP AND TESTING. FOR APPROVED CONTRACTOR, CONTACT VENDOR.
- B. THE SPACE IS SERVED BY THE MUNICIPAL WATER AND SEWER SYSTEM UNLESS OTHERWISE NOTED.
- C. ALL EQUIPMENT AND INSTALLATION WILL MEET NATIONAL SANITATION FOUNDATION STANDARDS OR EQUIVALENT.
- D. EQUIPMENT UNITS SHALL CONTAIN NO EXPOSED THREADS, EMBELLISHMENTS OR OVERHANGING EDGES THAT SERVE AS PLACES FOR ACCUMULATION OF DUST, DIRT AND DEBRIS.
- E. WARMING OVEN(S) SHOWN FOR PERMITTING PURPOSES. INSTALLATION AT STORE OPENING TO BE VERIFIED BY STARBUCKS CONSTRUCTION REPRESENTATIVE.
- F. EACH HAND WASHING SINK WILL HAVE A SINGLE SERVICE TOWEL AND SOAP DISPENSER, AND ALL HAND SINKS TO HAVE A COMBINATION FAUCET OR PREMIXING FAUCET.
- G. FOR PLUMBING FIXTURES, REFER TO THE PLUMBING DESIGN PLAN. FOR DATA DEVICE SCHEDULE, REFER TO THE ELECTRICAL DESIGN PLAN



STARBUCKS COFFEE COMPANY
BUILDING 4, CHISWICK PARK
566 CHISWICK HIGH ROAD
LONDON - W4 5YE
020 8834 5000

THESE DRAWINGS AND SPECIFICATIONS ARE CONFIDENTIAL AND SHALL REMAIN THE SOLE PROPERTY OF STARBUCKS CORPORATION, WHICH IS THE OWNER OF THE COPYRIGHT IN THIS WORK. THEY SHALL NOT BE REPRODUCED (IN WHOLE OR IN PART), SHARED WITH THIRD PARTIES OR USED IN ANY MANNER ON OTHER PROJECTS OR EXTENSIONS TO THIS PROJECT WITHOUT THE PRIOR WRITTEN CONSENT OF STARBUCKS CORPORATION. THESE DRAWINGS AND SPECIFICATIONS ARE INTENDED TO EXPRESS DESIGN INTENT FOR A PROTOTYPICAL STARBUCKS STORE (WHICH IS SUBJECT TO CHANGE AT ANYTIME) AND DO NOT REFLECT ACTUAL SITE CONDITIONS. NEITHER PARTY SHALL HAVE ANY OBLIGATION NOR LIABILITY TO THE OTHER (EXCEPT STATED ABOVE) UNTIL A WRITTEN AGREEMENT IS FULLY EXECUTED BY BOTH PARTIES.


ARCHITECT OF RECORD
THIS DRAWING IS A DESIGN DEVELOPMENT DOCUMENT. SITE SPECIFIC MODIFICATIONS MADE UNDER THE RESPONSIBLE CHARGE OF THE ARCHITECT AND/OR ENGINEER-OF-RECORD WILL BE REQUIRED PRIOR TO USING THIS DOCUMENT FOR BIDDING, PERMITTING, OR CONSTRUCTION.

Revision Schedule				
Rev	Date	By	Description	

PROJECT NAME:
Starbucks - Hampstead - South End Road
PROJECT ADDRESS:
5-7 Southend Road, London NW3 2PT


STORE #: 12318
PROJECT #:
CONCEPT:
PALETTE:
ISSUE DATE:
DESIGN MANAGER:
LEED® AP:
PRODUCTION DESIGNER:
CHECKED BY:

SHEET TITLE:
FF AND E PLAN
SCALE: 1 : 50
SHEET NUMBER:
I-1105

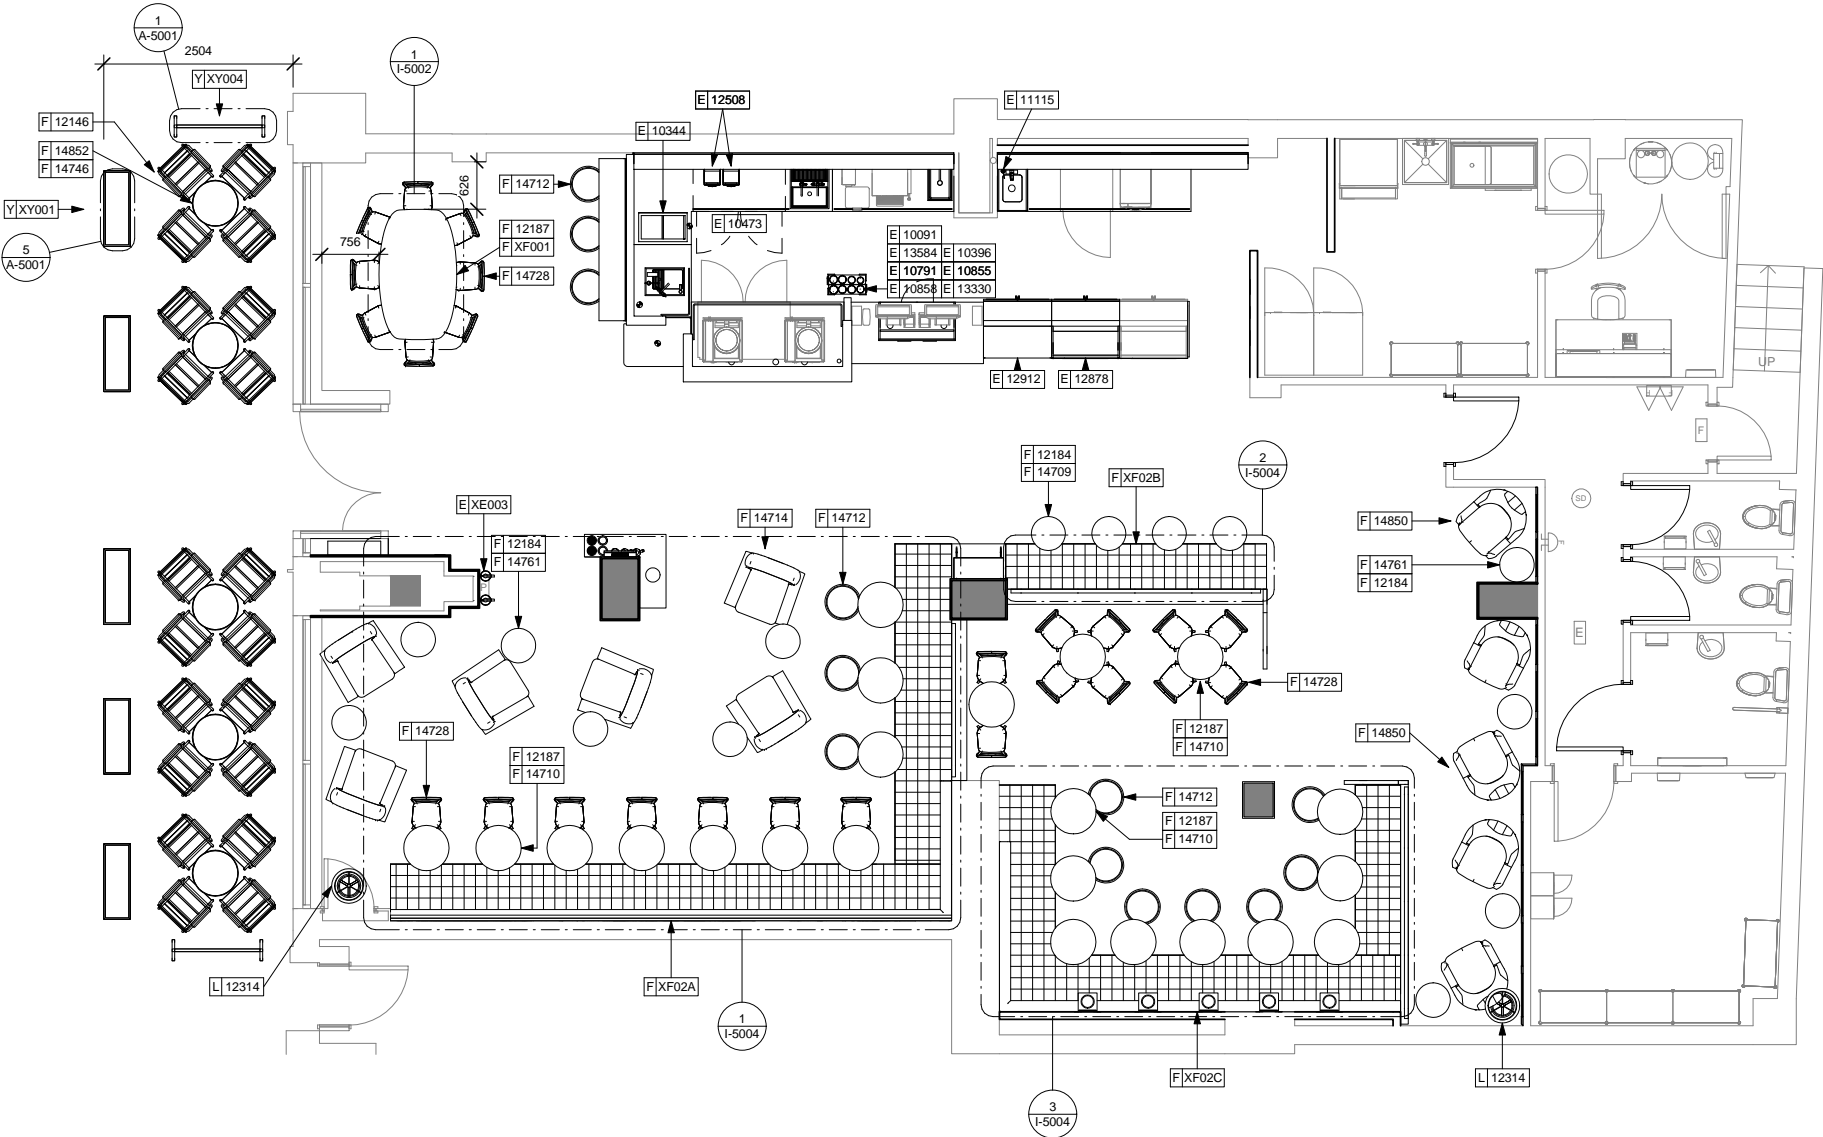


1 GROUND FLOOR - FURNITURE, FIXTURES, AND EQUIPMENT PLAN
Scale: 1 : 50

C:\1 Projects\Hampstead\DD set\12318 - Hampstead Southend Road - DID set - Rev. 0 - 02-11-2014.rvt
01/12/2014 21:19:07

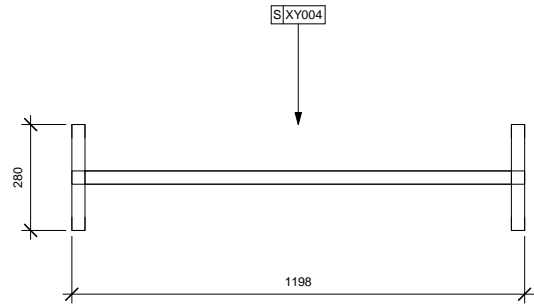


1 CUSTOM SCREEN PLAN DETAIL

Scale: 1 : 10

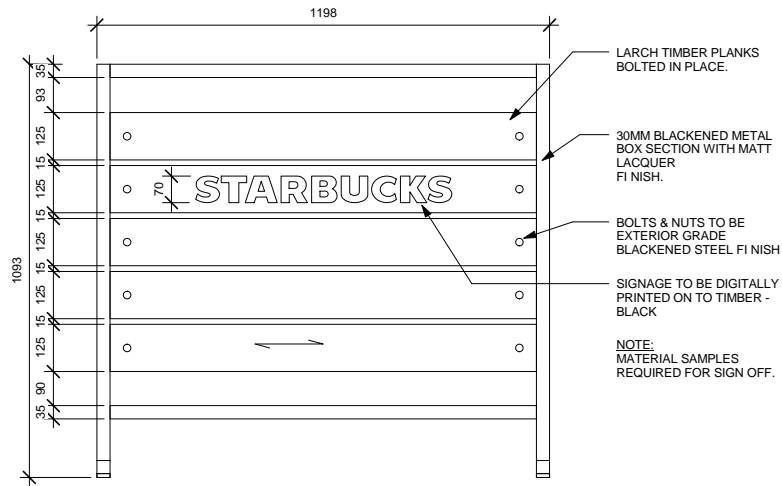

2 CUSTOM SCREEN FRONT ELEVATION

Scale: 1 : 10

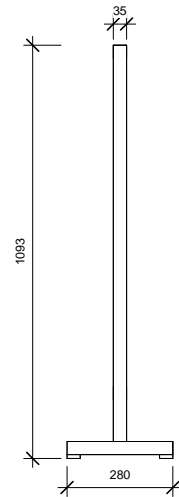


3 CUSTOM SCREEN END ELEVATION

Scale: 1 : 10




4 CUSTOM SCREEN 3D VIEW

Scale:

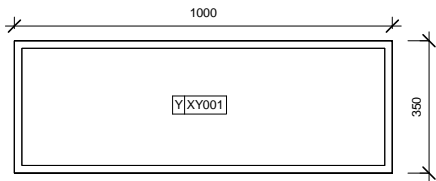


5 PLANTER DETAIL PLAN

Scale: 1 : 10

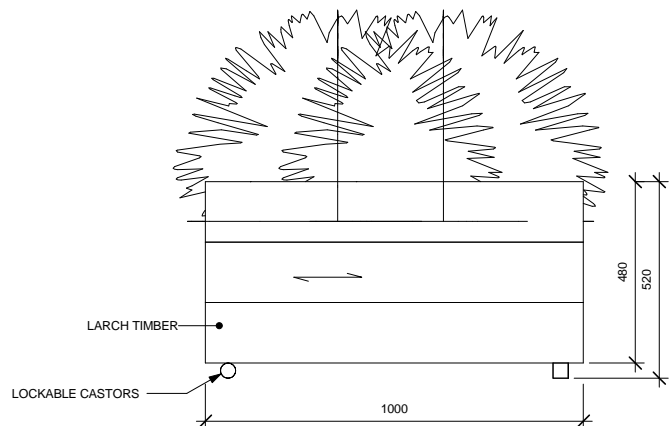


6 PLANTER FRONT ELEVATION

Scale: 1 : 10

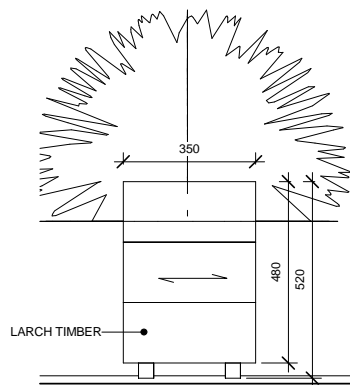

7 PLANTER SIDE ELEVATION

Scale: 1 : 10

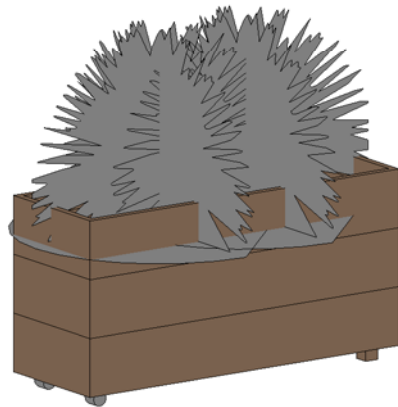

8 PLANTER 3D VIEW

Scale:



STARBUCKS COFFEE
COMPANY
BUILDING 4, CHISWICK PARK
566 CHISWICK HIGH ROAD
LONDON - W4 5YE
020 8834 5000

THESE DRAWINGS AND SPECIFICATIONS ARE
CONFIDENTIAL AND SHALL REMAIN THE SOLE
PROPERTY OF STARBUCKS CORPORATION,
WHICH IS THE OWNER OF THE COPYRIGHT IN
THIS WORK. THEY SHALL NOT BE REPRODUCED
(IN WHOLE OR IN PART), SHARED WITH THIRD
PARTIES OR USED IN ANY MANNER ON OTHER
PROJECTS OR EXTENSIONS TO THIS PROJECT
WITHOUT THE PRIOR WRITTEN CONSENT OF
STARBUCKS CORPORATION. THESE DRAWINGS
AND SPECIFICATIONS ARE INTENDED TO
EXPRESS DESIGN INTENT FOR A
PROTOTYPICAL STARBUCKS STORE (WHICH IS
SUBJECT TO CHANGE AT ANYTIME) AND DO NOT
REFLECT ACTUAL SITE CONDITIONS. NEITHER
PARTY SHALL HAVE ANY OBLIGATION NOR
LIABILITY TO THE OTHER (EXCEPT STATED
ABOVE) UNTIL A WRITTEN AGREEMENT IS FULLY
EXECUTED BY BOTH PARTIES.

ARCHITECT OF RECORD
THIS DRAWING IS A DESIGN DEVELOPMENT
DOCUMENT. SITE SPECIFIC MODIFICATIONS
MADE UNDER THE RESPONSIBLE CHARGE OF
THE ARCHITECT AND/OR ENGINEER-OF-
RECORD WILL BE REQUIRED PRIOR TO USING
THIS DOCUMENT FOR BIDDING, PERMITTING,
OR CONSTRUCTION.

Revision Schedule			
Rev	Date	By	Description

PROJECT NAME:
Starbucks - Hampstead - South End Road
PROJECT ADDRESS:
5-7 Southend Road, London NW3 2PT

STORE #: 12318
PROJECT #:
CONCEPT:
PALETTE:
ISSUE DATE:
DESIGN MANAGER:
LEED® AP:
PRODUCTION DESIGNER:
CHECKED BY:

SHEET TITLE:
SITE DETAILS
SCALE: 1 : 10
SHEET NUMBER:
A-5001

DESIGN DEVELOPMENT ONLY - NOT INTENDED FOR CONSTRUCTION