


Notes

1. Do not scale the drawing
2. This drawing to be read in conjunction with all other Architects and Engineers drawings and specifications including outline structural specification
3. All dimensions are in millimetres unless noted otherwise
4. Any discrepancies between structural and architectural setting out dimensions must be brought to the attention of the Architect and Engineers
5. For notes to drainage refer to J2171-C-099 and J271-C-100

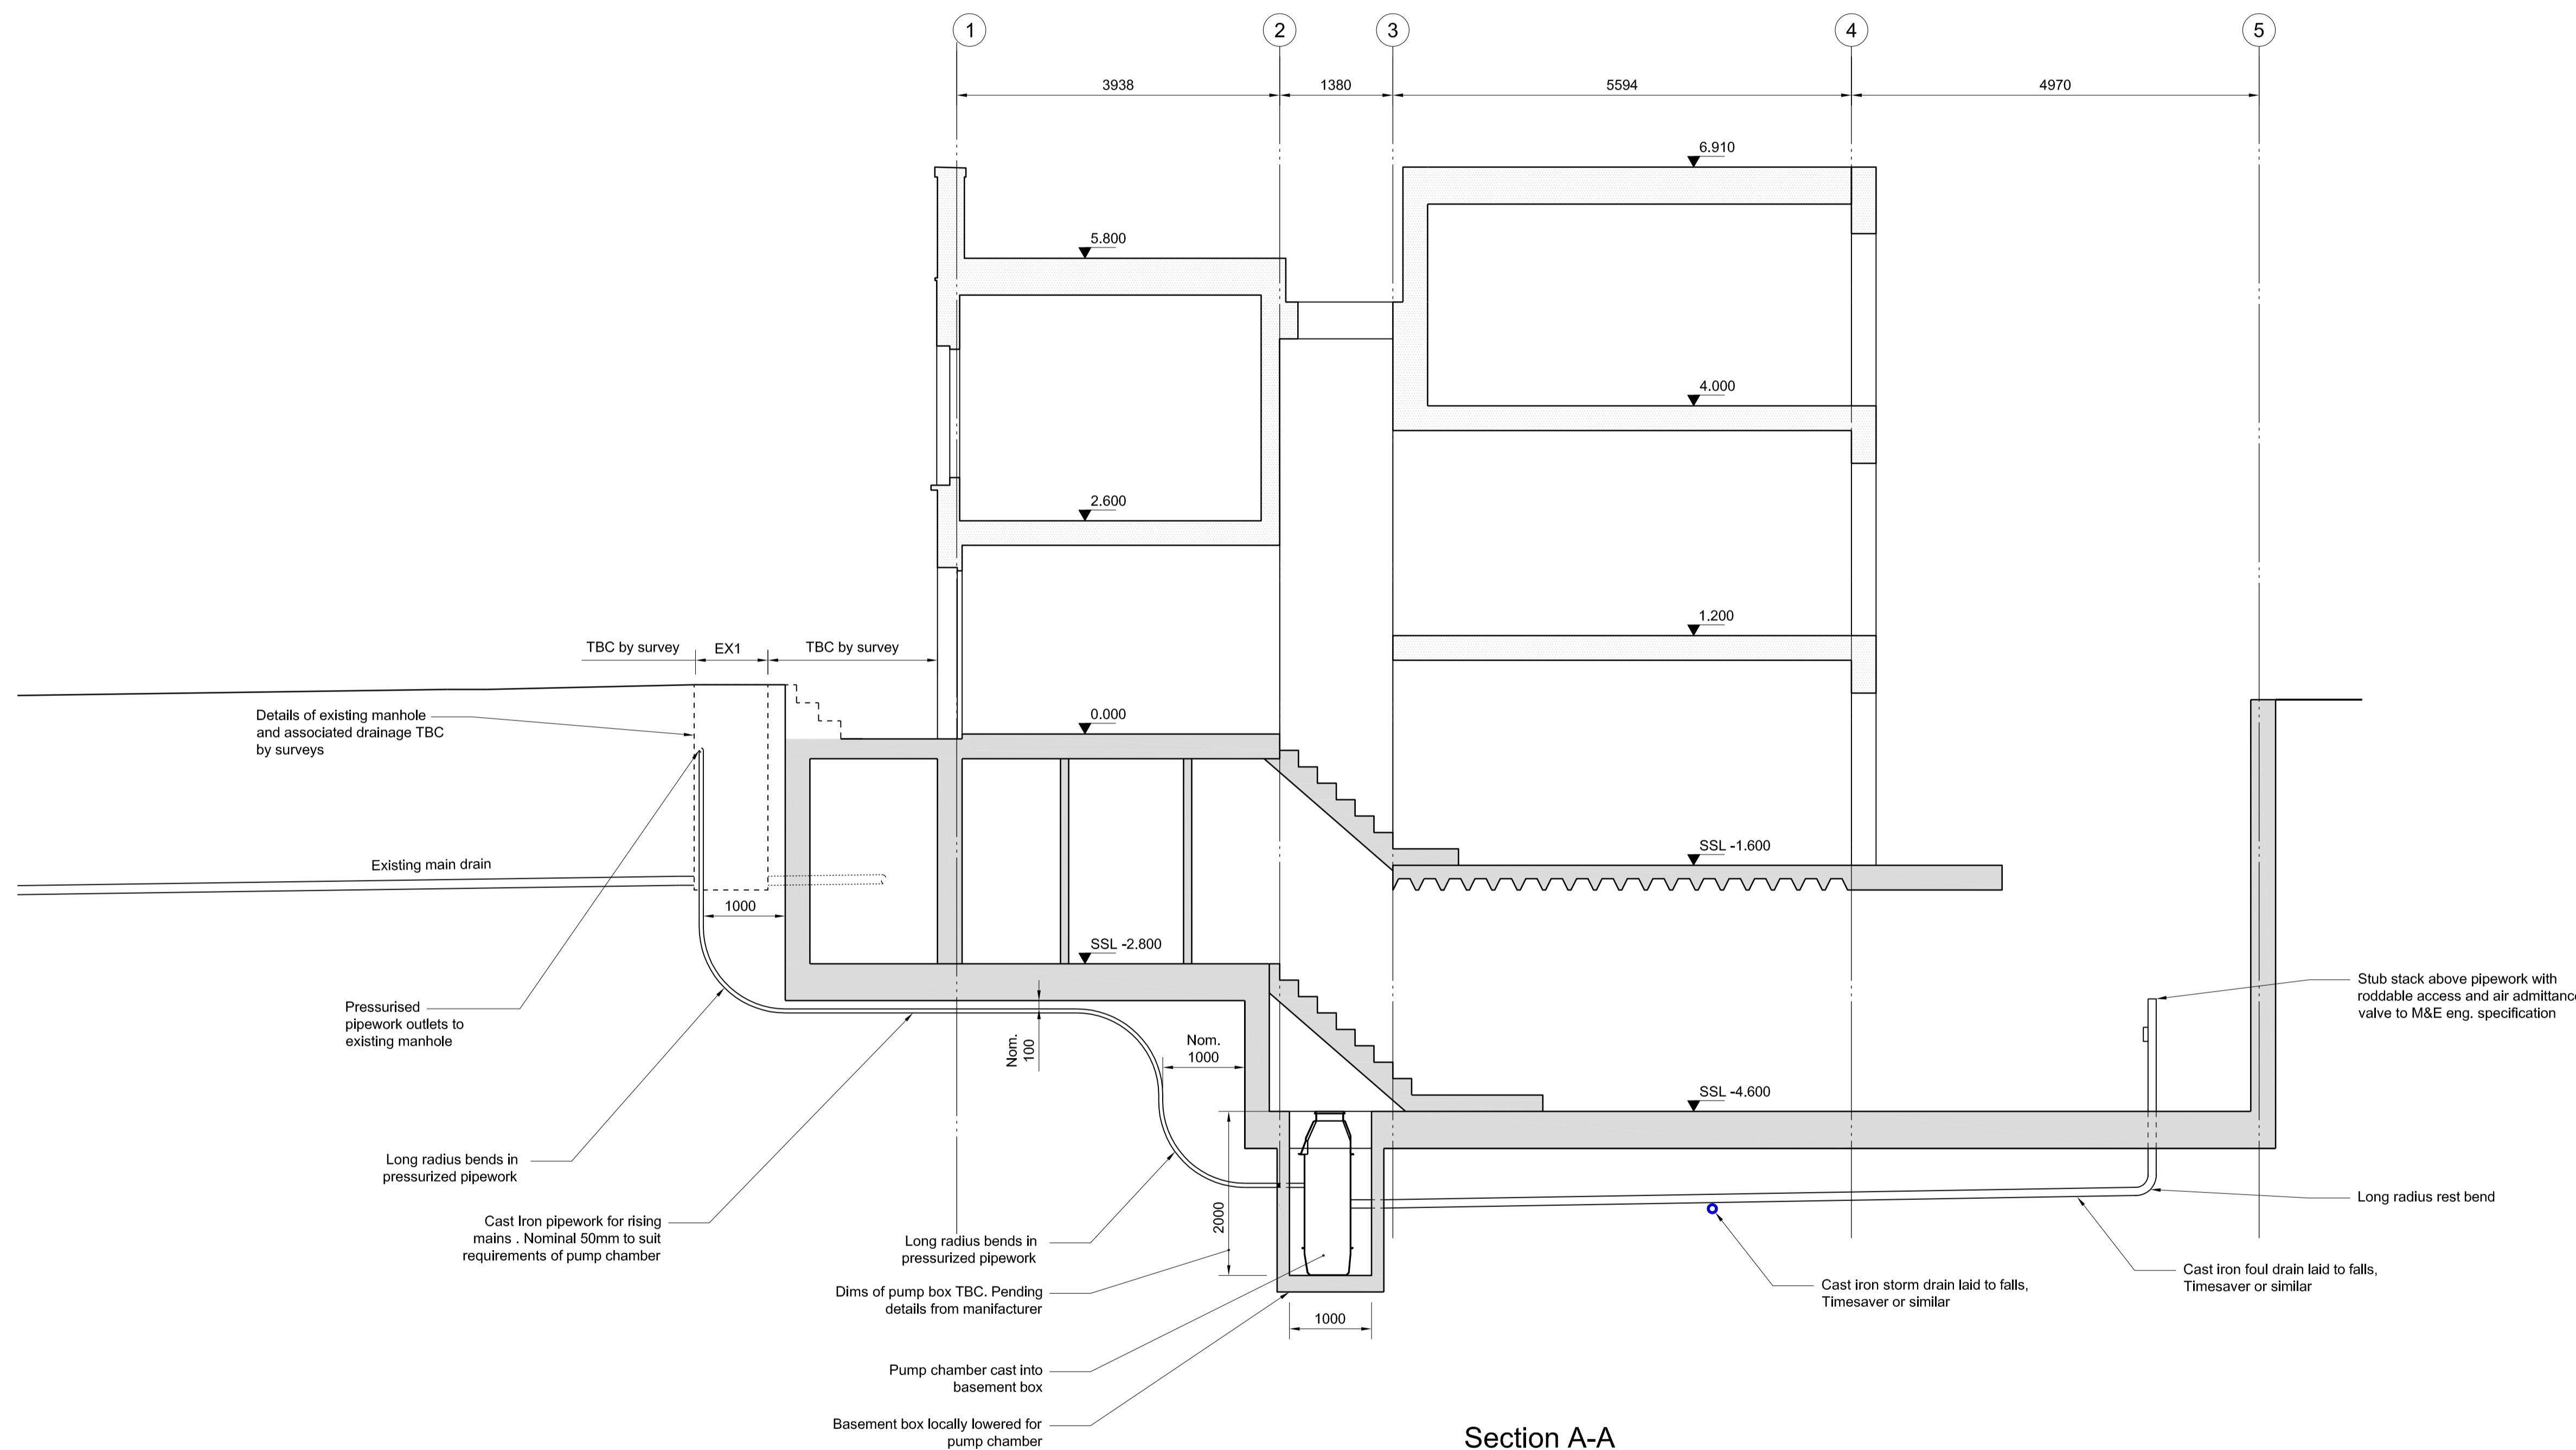

Section A-A

P1	27.11.14	Preliminary Issue	FC	JA
Rev	Date	Description	Drm	App

**WEBB YATES** ENGINEERS  
 44-46 Scrutton Street  
 London EC2A 4HH  
 020 3696 1550  
 www.webbyates.co.uk  
 info@webbyates.co.uk

Project **4b Parkhill Road**

Drawing Title **Drainage Layout Section A**

Drawing Status **Preliminary**

Drawn by	Checked by	Sheet size	Scale
FC	JA	A1	1:50

Drawing Number	Revision
J2171-C-200	P1