


THIS DRAWING IS UNDER COPYRIGHT AND NO PORTION SHOULD BE USED WITHOUT PRIOR CONSENT. USE FIGURED DIMENSIONS ONLY. ALL FIGURED DIMENSIONS SHOWN ARE TAKEN FROM FINISHED SURFACES. ALL DIMENSIONS AND LEVELS MUST BE CHECKED ON SITE AND ANY INCONSISTENCIES REPORTED IMMEDIATELY TO US PRIOR TO PUTTING WORKS IN HAND.


REVISIONS:		
CODE:	DATE:	DESCRIPTION:
A	08.03.13	Additional fenestration detail to rear elevation & extract ductwork to be painted out as per specification
B	14.03.13	Revised ductwork layout
C	25.11.13	Revised proposed position of condenser units and removal of steelwork
D	25.06.14	Drawings updated with LLD survey drawings
E	17.12.14	Removal of steelwork from higher level roof

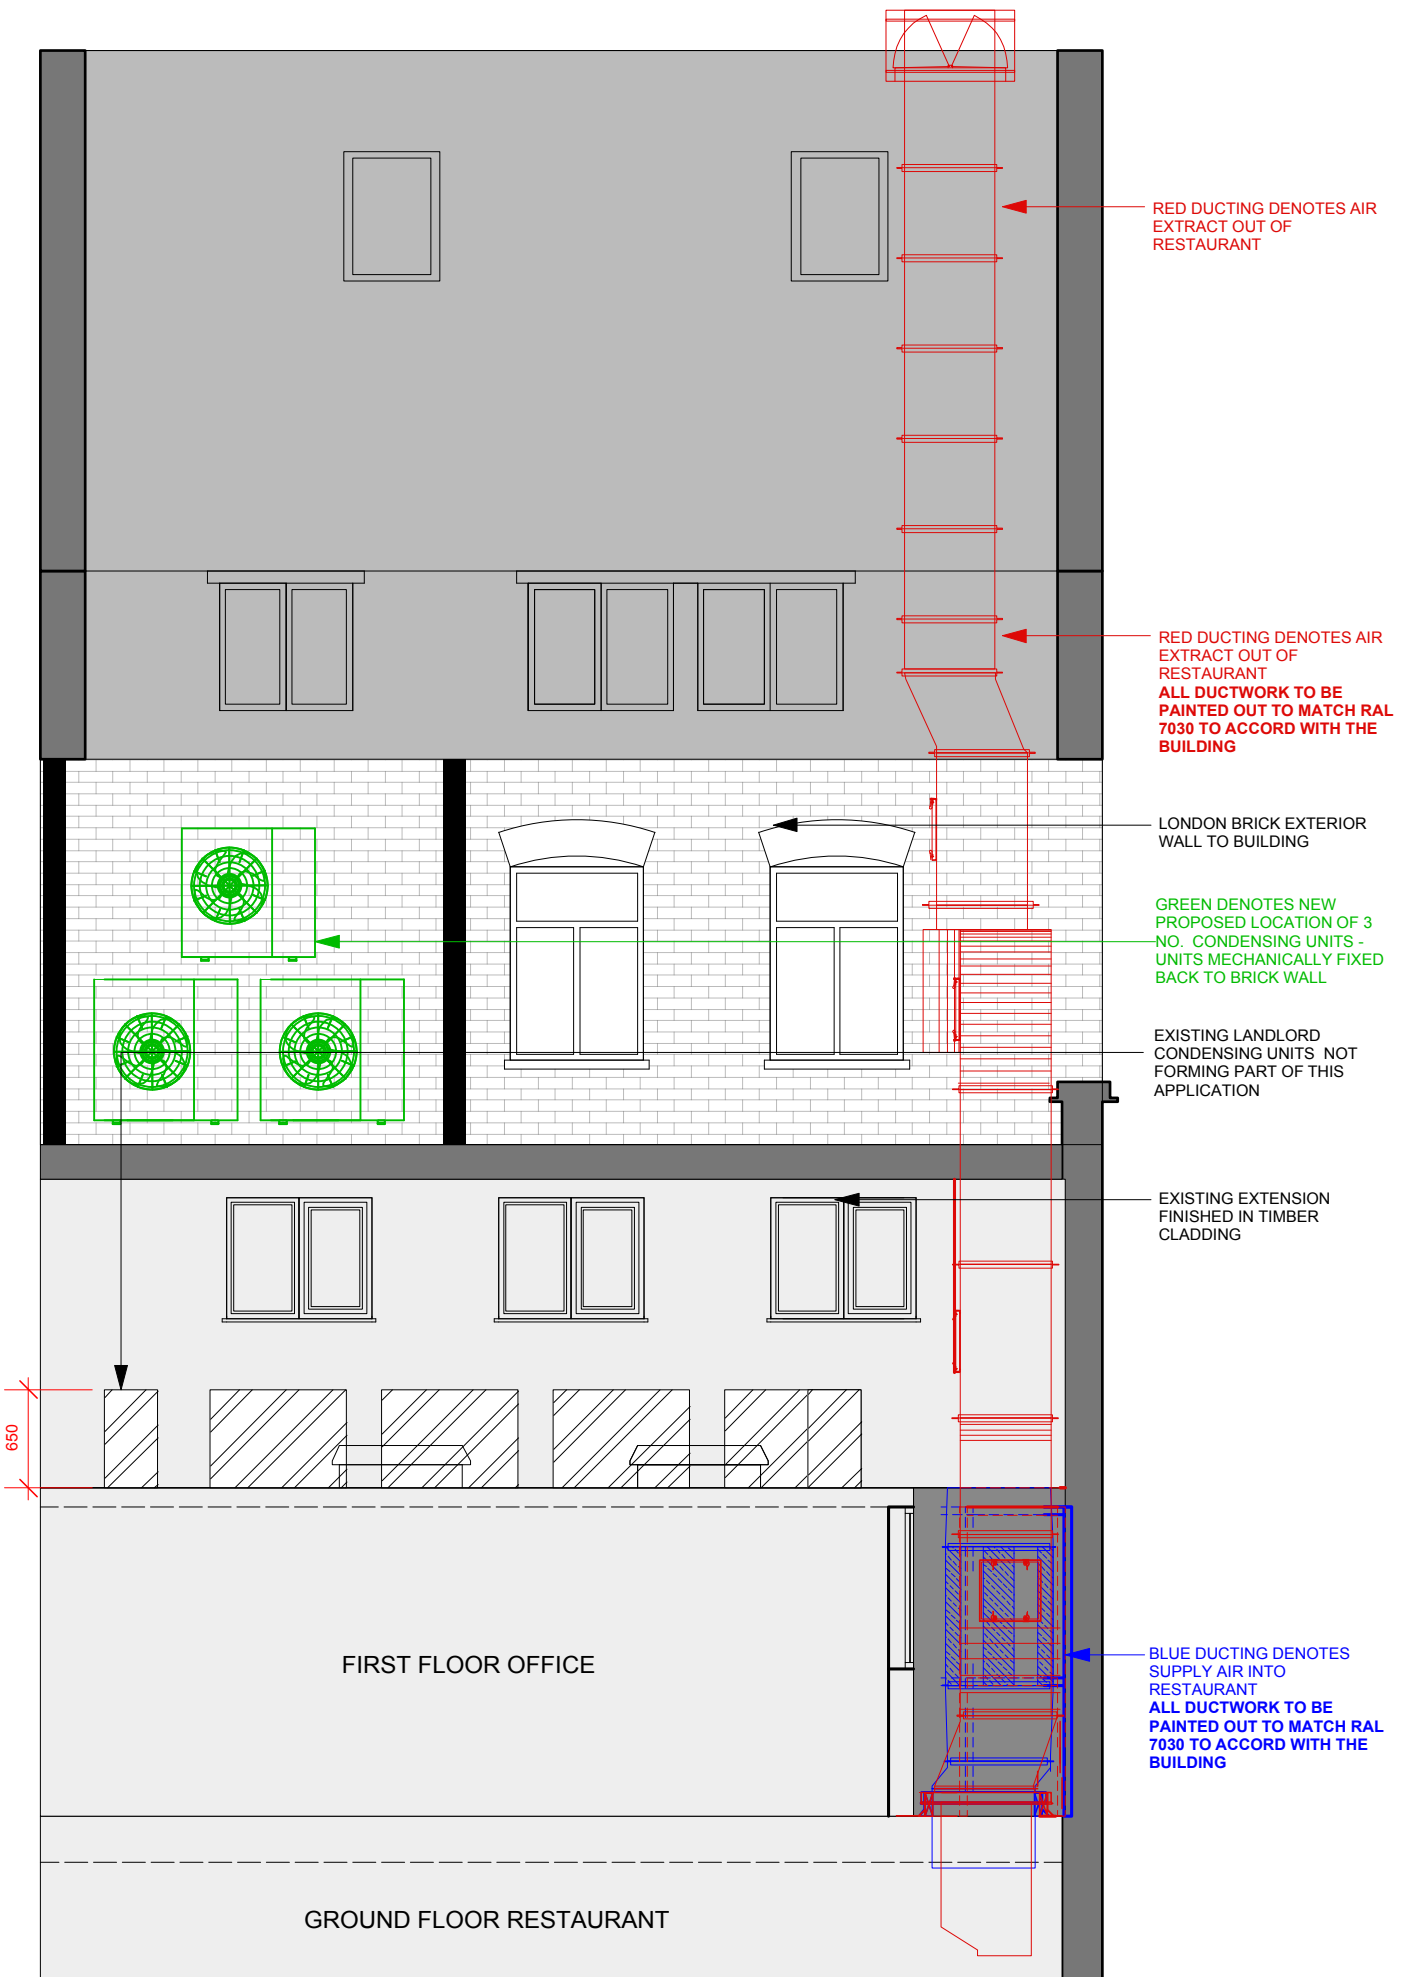

789 - ELEVATION BB
SCALE 1:50 @ A3



789 - ELEVATION CC
SCALE 1:50 @ A3

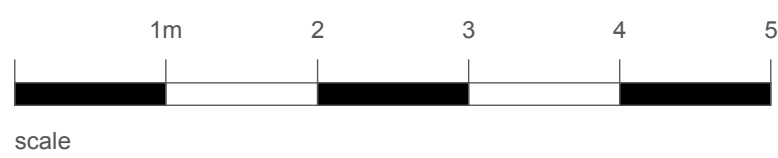

B3 DESIGN JERS B3 Designers Ltd
Unit 3, 51 Derbyshire Street,
London, E2 6HQ.
Tel: +44 (0)20 7729 8111
Fax: +44 (0)20 7729 8124

PROJECT NO: 789 CLIENT/PROJECT: BUBBLEDOGS

DATE: 14.01.2012 DRAWN: KJM CHECKED: MB SCALE: 1:25 @ A1
1:50 @ A3

TITLE: ELEVATION BB & CC

DWG. NO: 789-B3-16PRP-03 REV: E