

THIS DRAWING IS UNDER COPYRIGHT AND NO PORTION SHOULD BE USED WITHOUT PRIOR CONSENT. USE FIGURED DIMENSIONS ONLY. ALL FIGURED DIMENSIONS SHOWN ARE TAKEN FROM FINISHED SURFACES. ALL DIMENSIONS AND LEVELS MUST BE CHECKED ON SITE AND ANY INCONSISTENCIES REPORTED IMMEDIATELY TO US PRIOR TO PUTTING WORKS IN HAND.

REVISIONS:		
CODE:	DATE:	DESCRIPTION:
A	08.03.13	Extract ductwork to be painted out as per specification
B	14.03.13	Revised ductwork layout
C	16.09.13	Revised ductwork layout - Condensers and screen
D	25.11.13	Revised proposed position of condenser units and removal of steelwork
E	25.06.14	Drawings updated with LLD survey drawings
F	17.12.14	Removal of steelwork from higher level roof


FAN SILENCER & PARROTS BEAK FOR INTAKE
ALL DUCTWORK TO BE PAINTED OUT TO MATCH RAL 7030 TO ACCORD WITH THE BUILDING

EXISTING LANDLORD CONDENSING UNITS NOT FORMING PART OF THIS APPLICATION


RED DUCTING DENOTES AIR EXTRACT OUT OF RESTAURANT
ALL DUCTWORK TO BE PAINTED OUT TO MATCH RAL 7030 TO ACCORD WITH THE BUILDING

ACOUSTIC ENCLOSURE AS PER NOISE ASSESSMENT DOCUMENTATION

GREEN DENOTES NEW PROPOSED LOCATION OF 3 NO. CONDENSING UNITS - UNITS MECHANICALLY FIXED BACK TO BRICK WALL

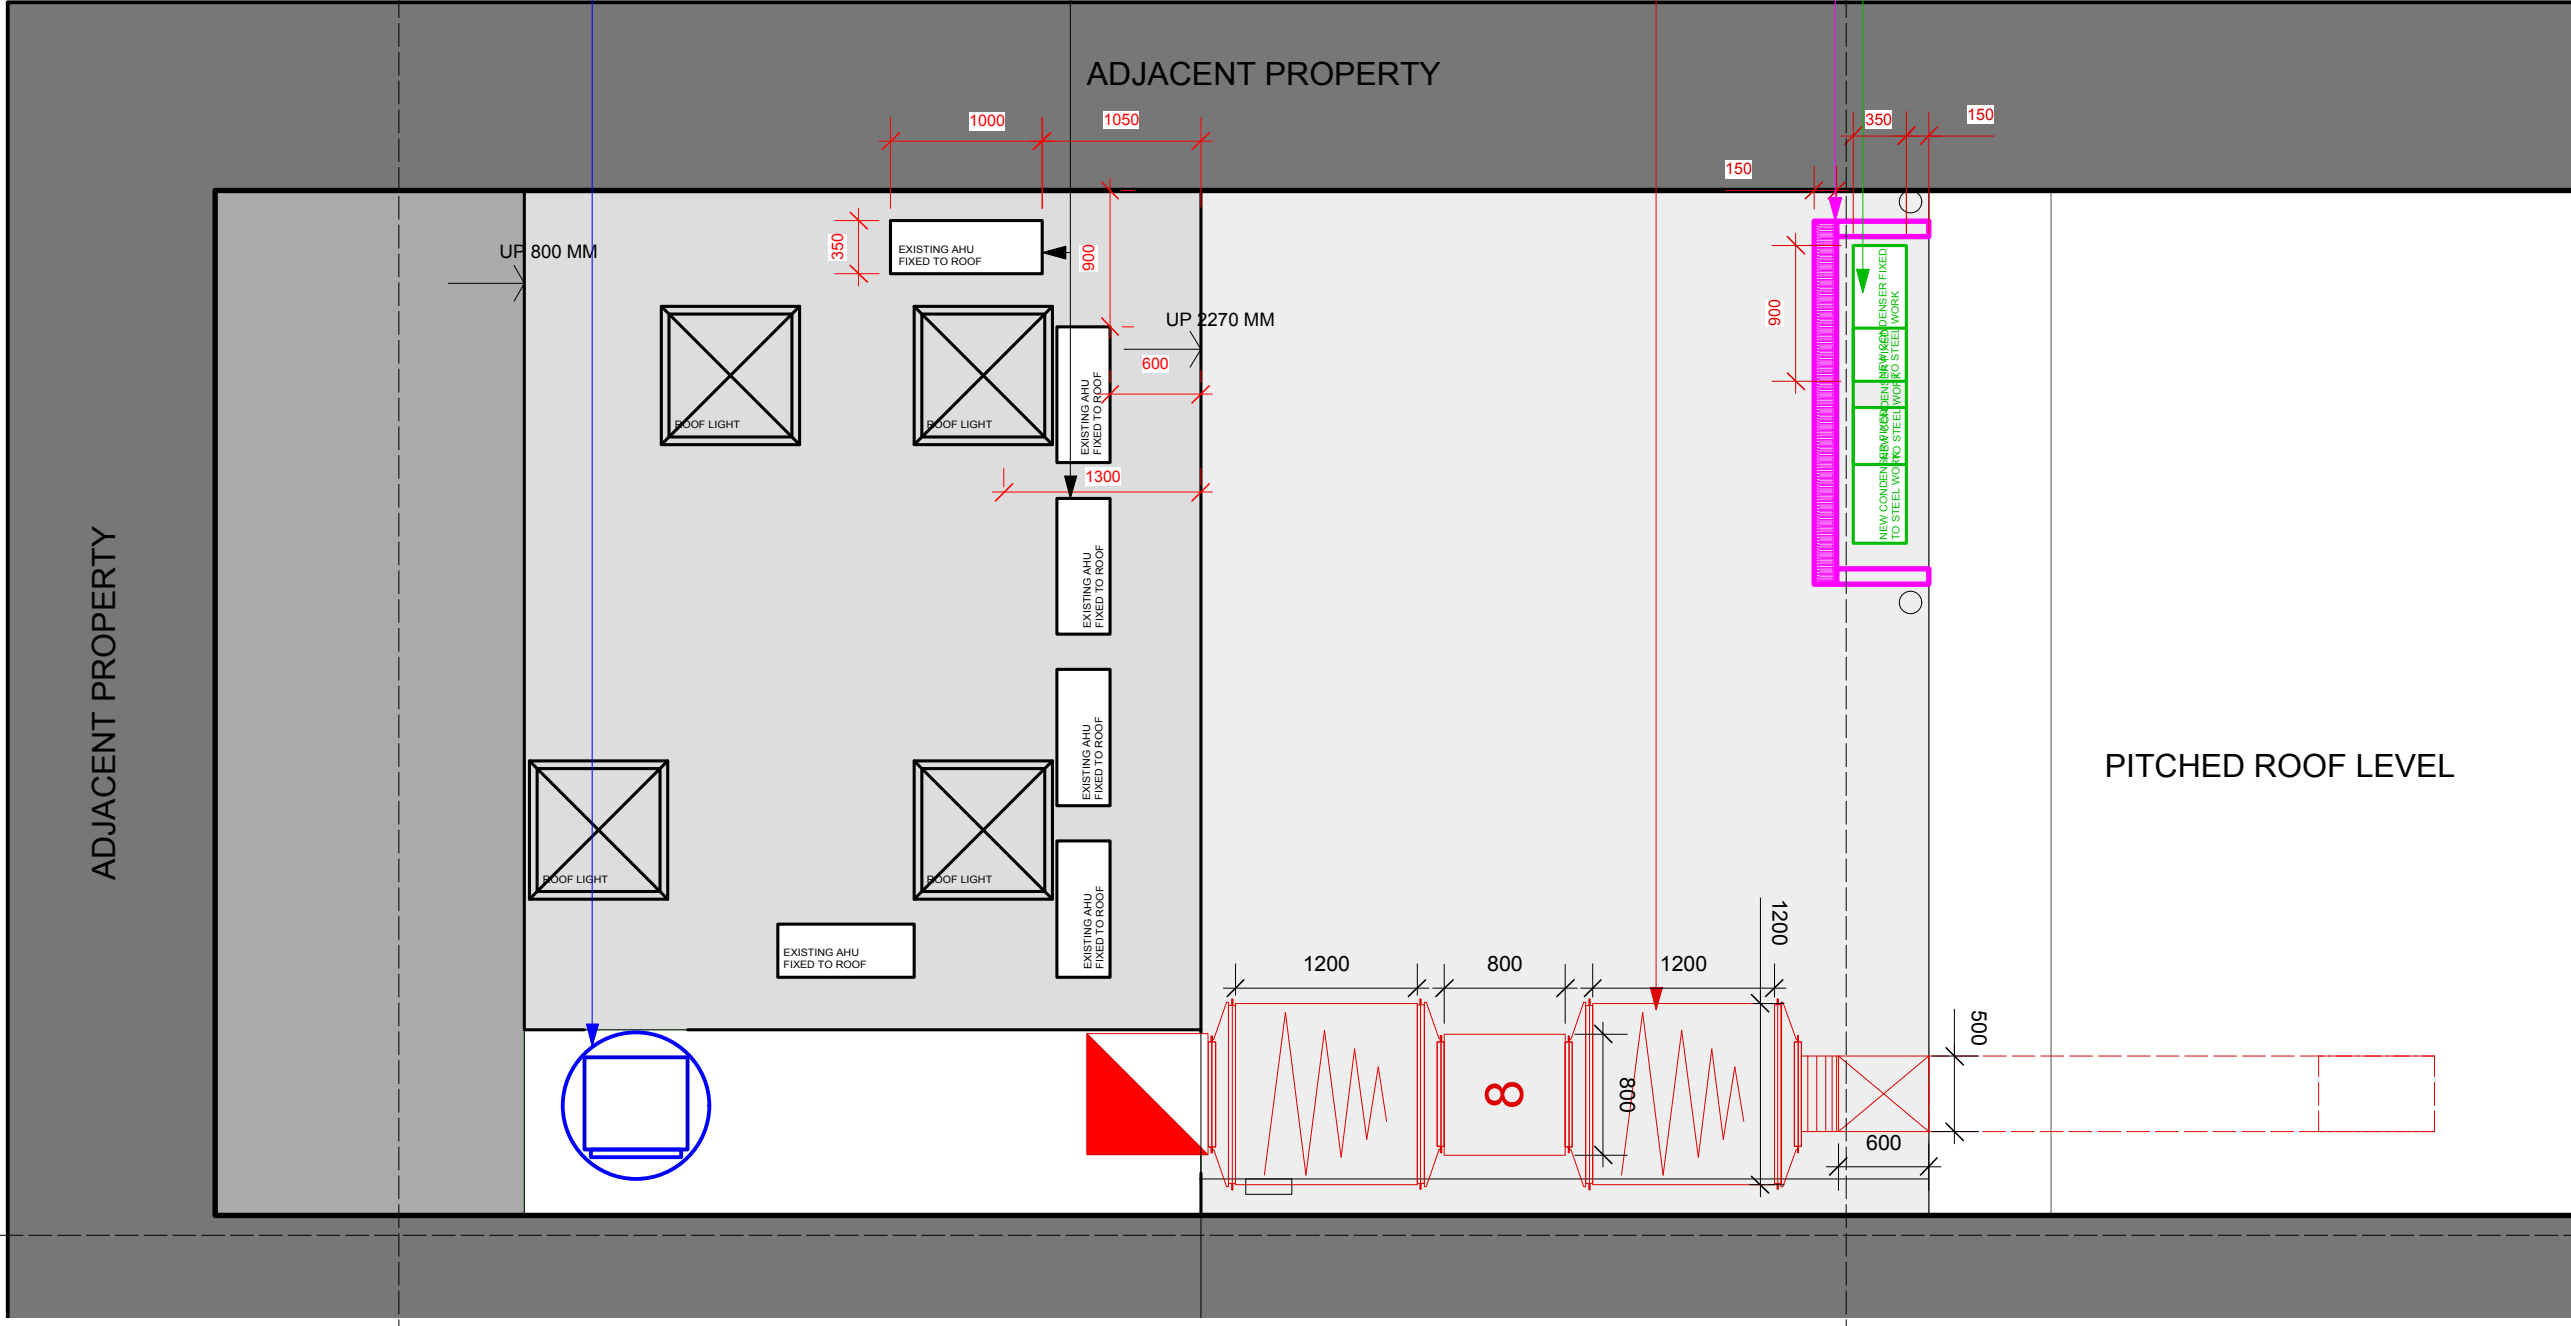

789 - ROOF PLAN
SCALE 1:50 @ A3

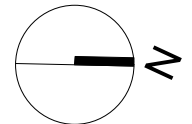

B3 DESIGNERS B3 Designers Ltd
Unit 3, 51 Derbyshire Street,
London, E2 6HQ.
Tel: +44 (0)20 7729 8111
Fax: +44 (0)20 7729 8124

PROJECT NO: 789 CLIENT/PROJECT: BUBBLEDOGS

DATE: 14.01.2012 DRAWN: KJM CHECKED: MB SCALE: 1:25 @ A1
1:50 @ A3

TITLE: PLANNING DRAWING
ROOF PLAN

DWG. NO: 789-B3-16PRP-01 REV: F