



NOTES

1. THIS DRAWING SHALL BE READ IN CONJUNCTION WITH THE SPECIFICATION FOR PUBLIC HEALTH SERVICES INSTALLATION AND ALL ASSOCIATED PUBLIC HEALTH DRAWINGS LISTED THEREIN.
2. ALL PUBLIC HEALTH SERVICES DRAWINGS SHALL BE READ IN CONJUNCTION WITH ALL ASSOCIATED ARCHITECTURAL STRUCTURAL MECHANICAL AND ELECTRICAL SERVICES DRAWINGS.
3. THE CONTRACTOR SHALL CHECK AND VERIFY ALL DIMENSIONS ON SITE PRIOR TO COMMENCING CONSTRUCTION.

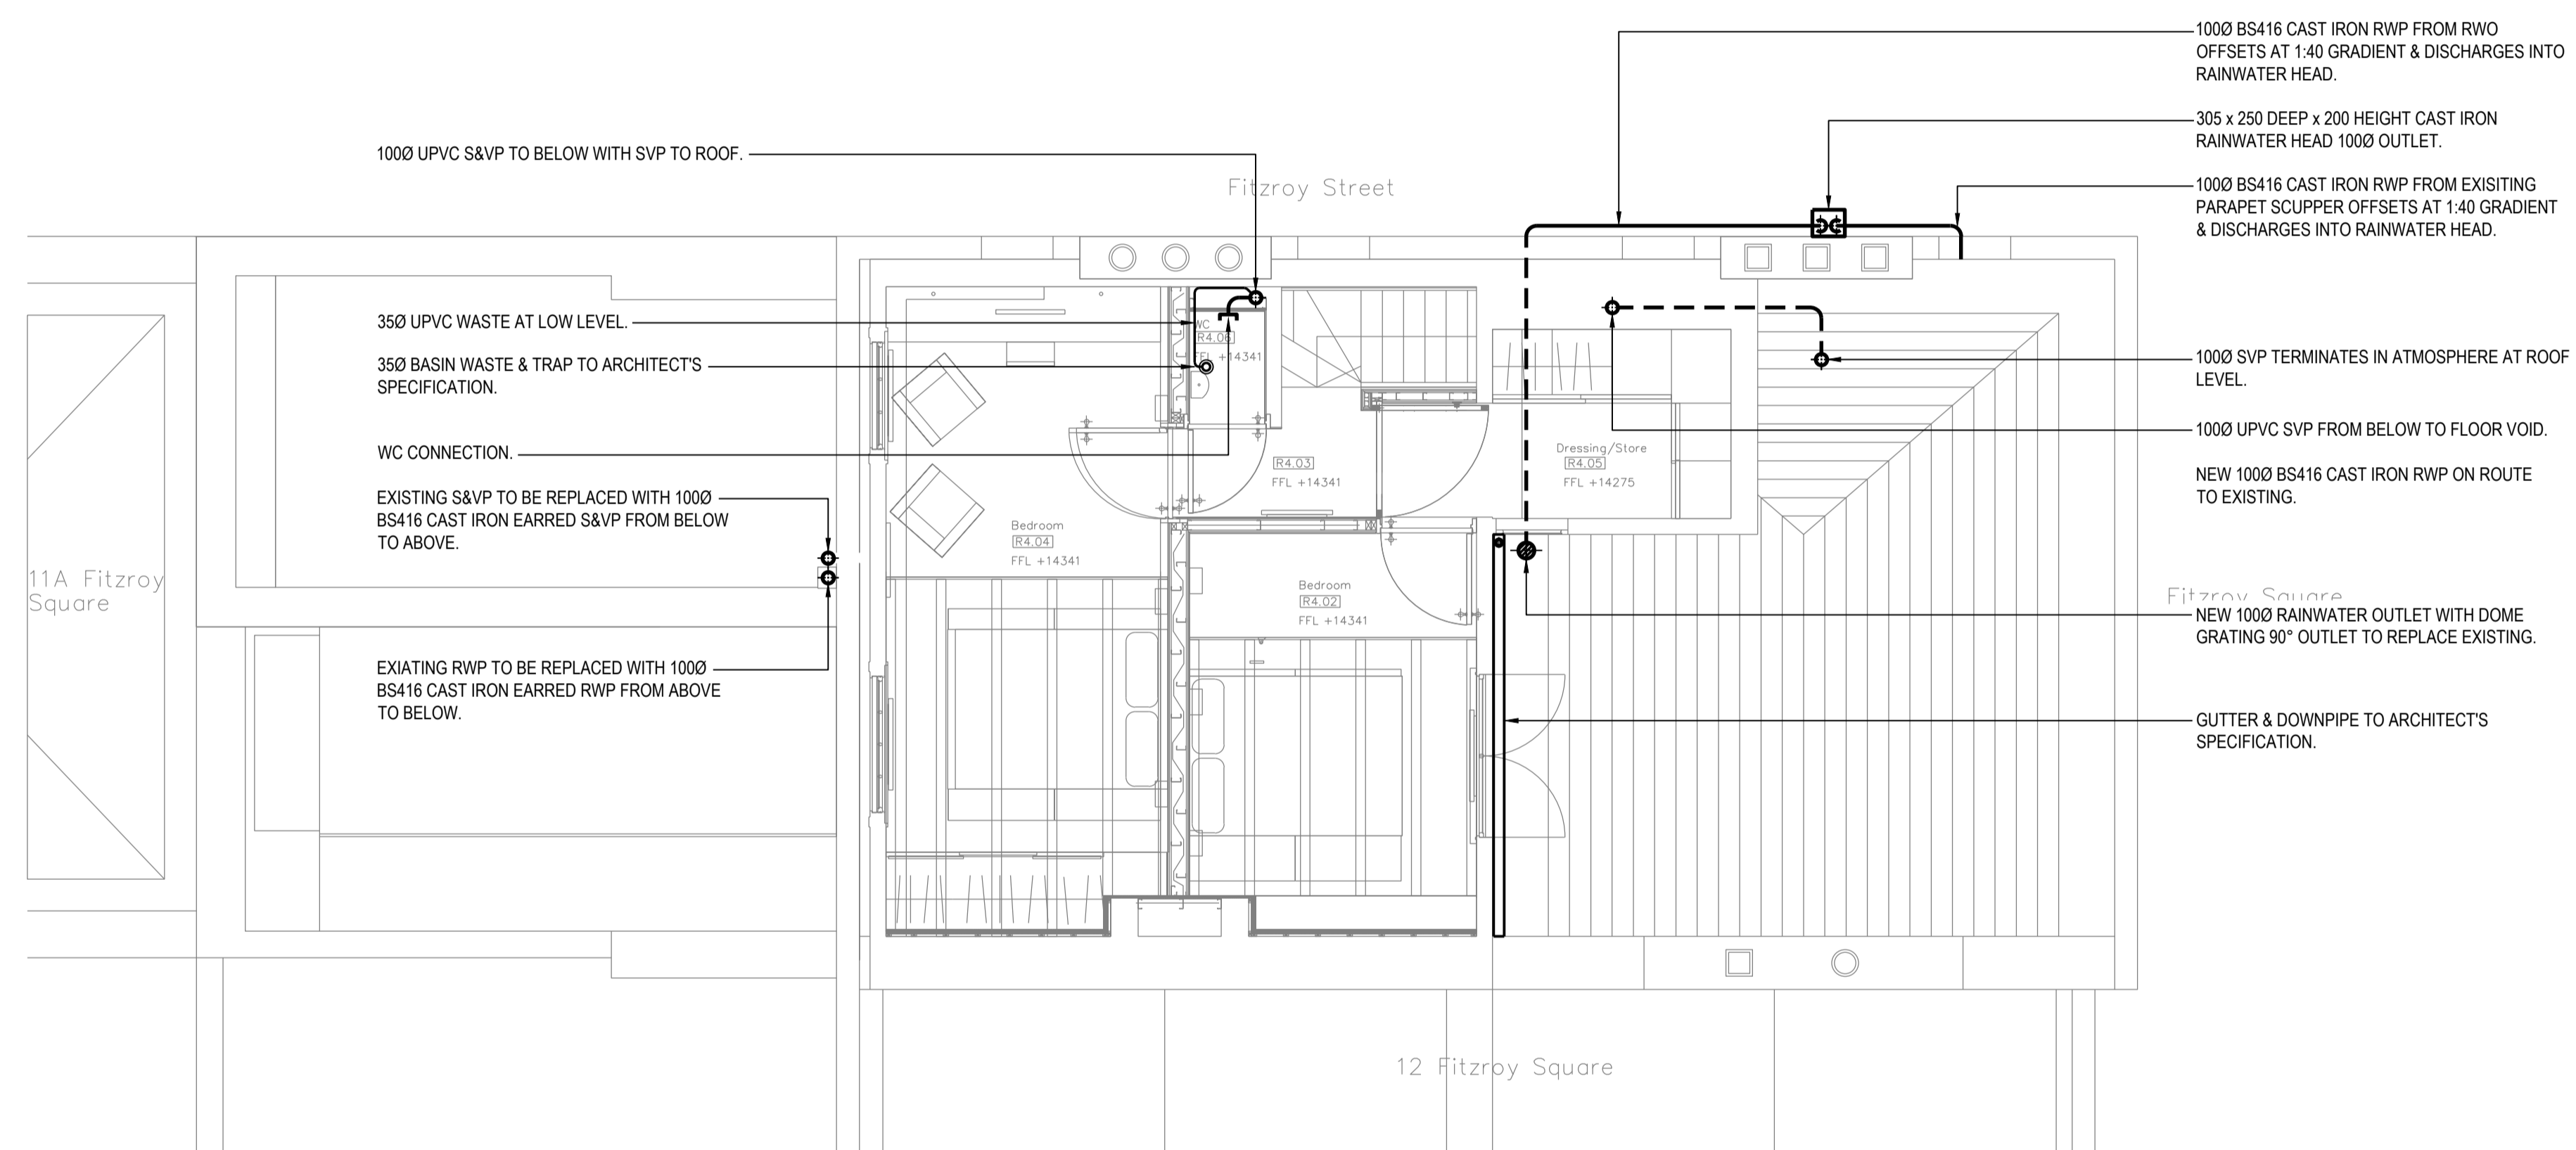

REV.	DATE	DESCRIPTION
P1	AUG 14	FOR PLANNING

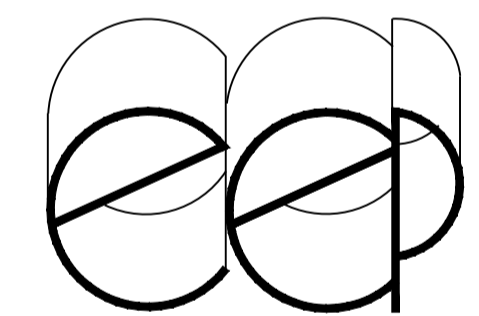

ENVIRONMENTAL
ENGINEERING
PARTNERSHIP
CONSULTING ENGINEERS

The Chapel House,
High Street, West Wycombe,
Buckinghamshire,
HP14 3AG
United Kingdom
Telephone: +44 (0)1494 464544
Facsimile: +44 (0)1494 464282
E-mail: consulting@eep.co.uk

CLIENT	RICHARD & JUDITH GREER	
PROJECT	11 FITZROY SQUARE LONDON	
TITLE	FOURTH FLOOR SOIL, WASTE, VENTILATING & RAINWATER DRAINAGE LAYOUT	
DRAWN	M.S.	SCALE 1:50@A1
CHECKED	R.D.	DATE APRIL 2013
DRAWING No.	3128/PH/06	REVISION P1