


**4 LG.29 ELEVATION**


1:50

ELEVATION REPEATED TO ROOM LG.28

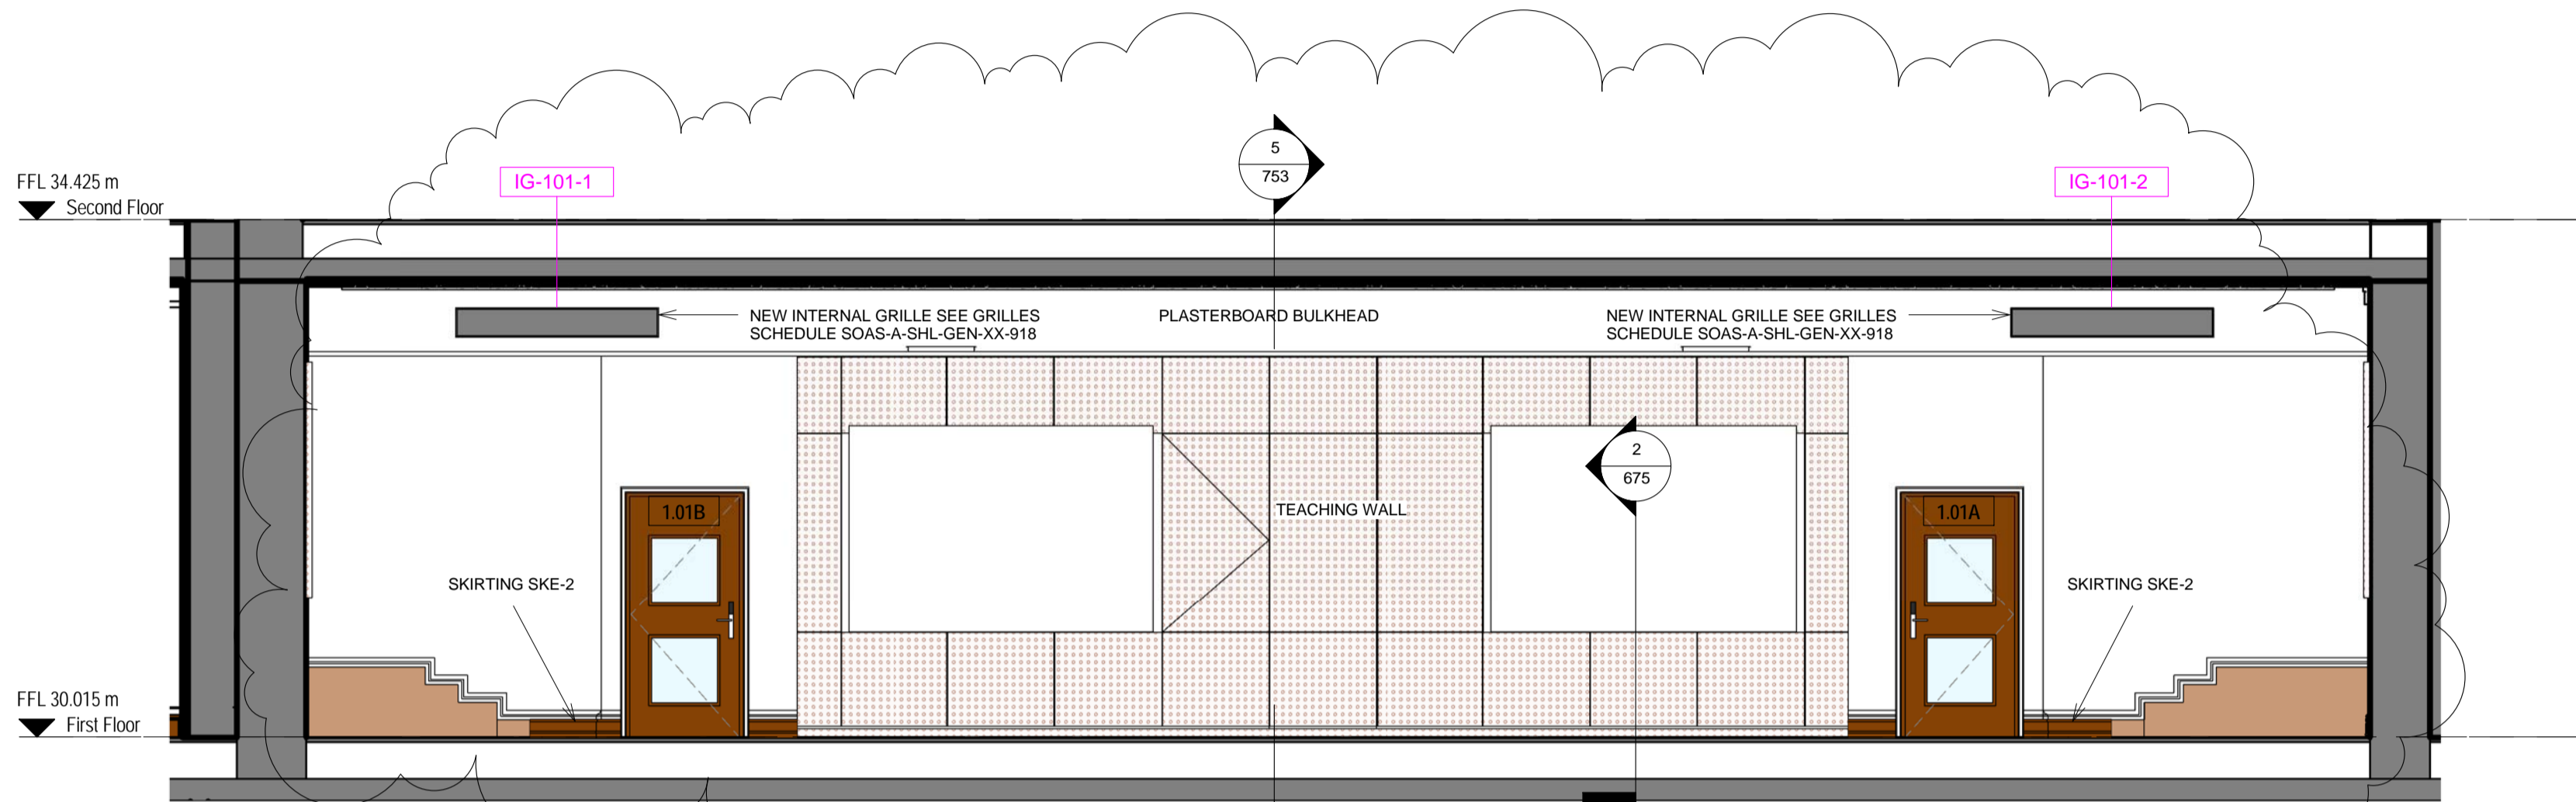


**1 1.01 INTERNAL ELEVATION**

1:50

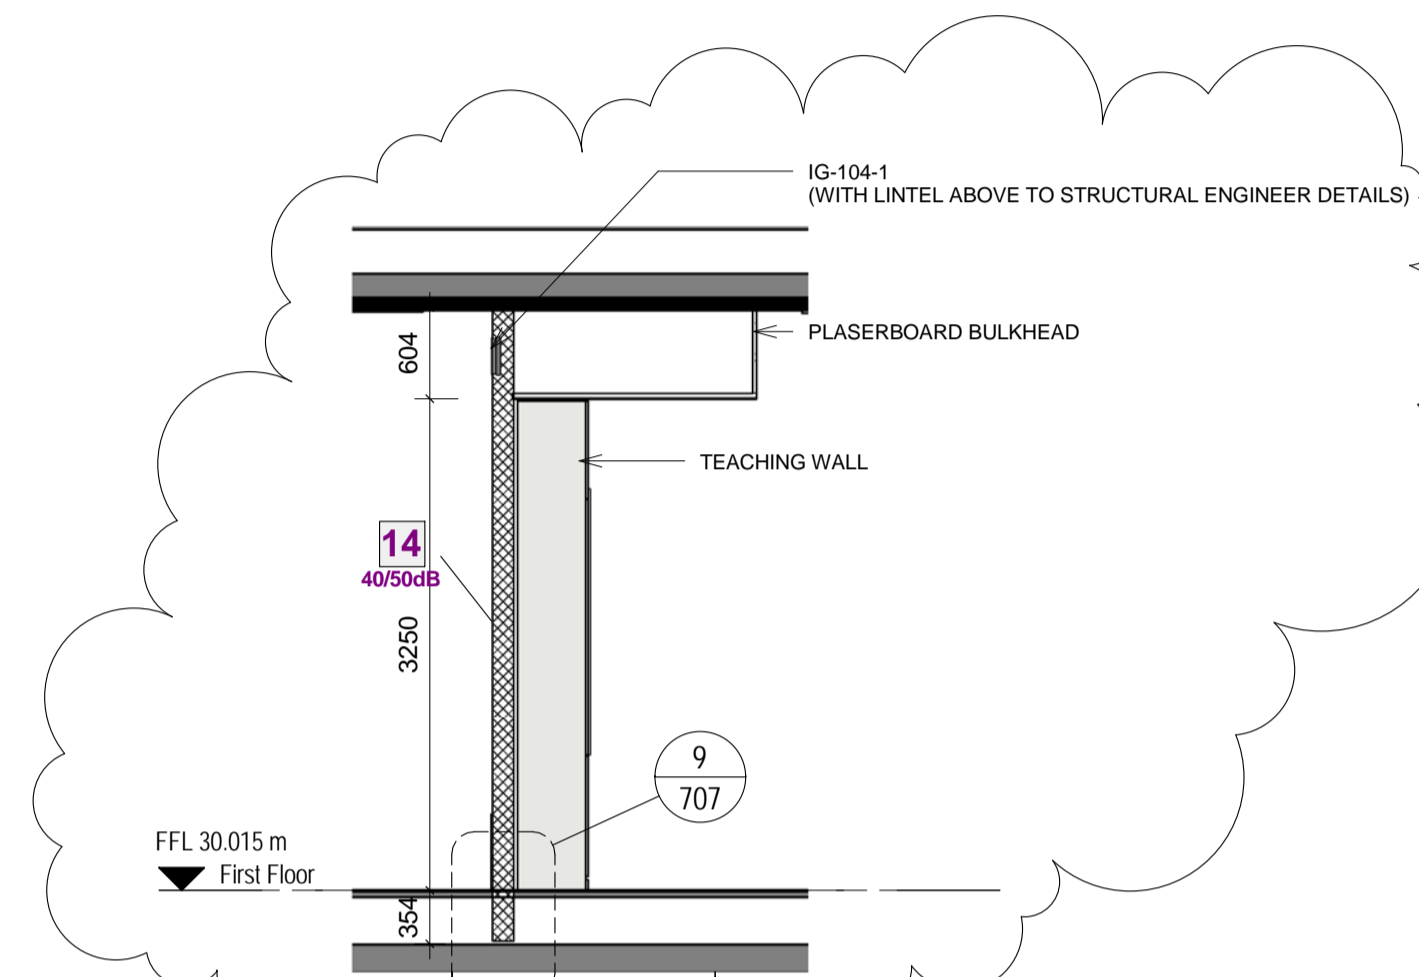


**5 1.01 SECTION**

1:50

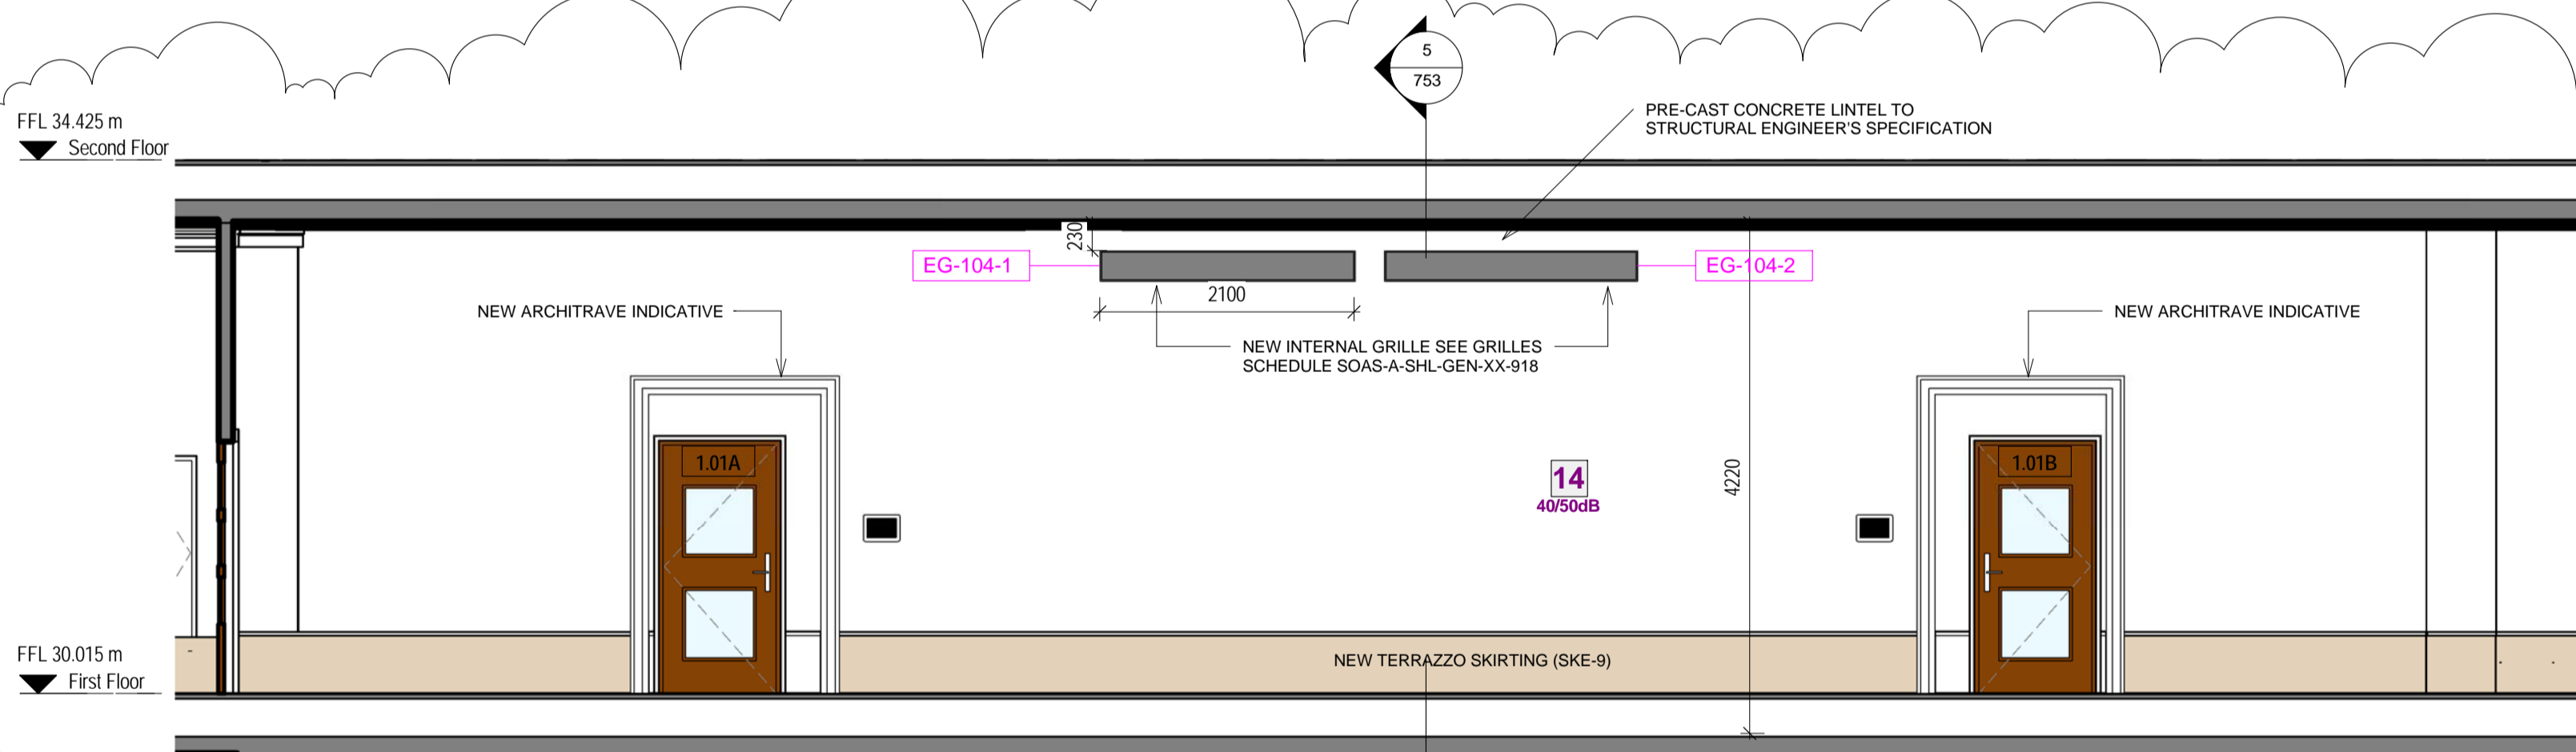


**2 1.04 INTERNAL ELEVATION**

1:50

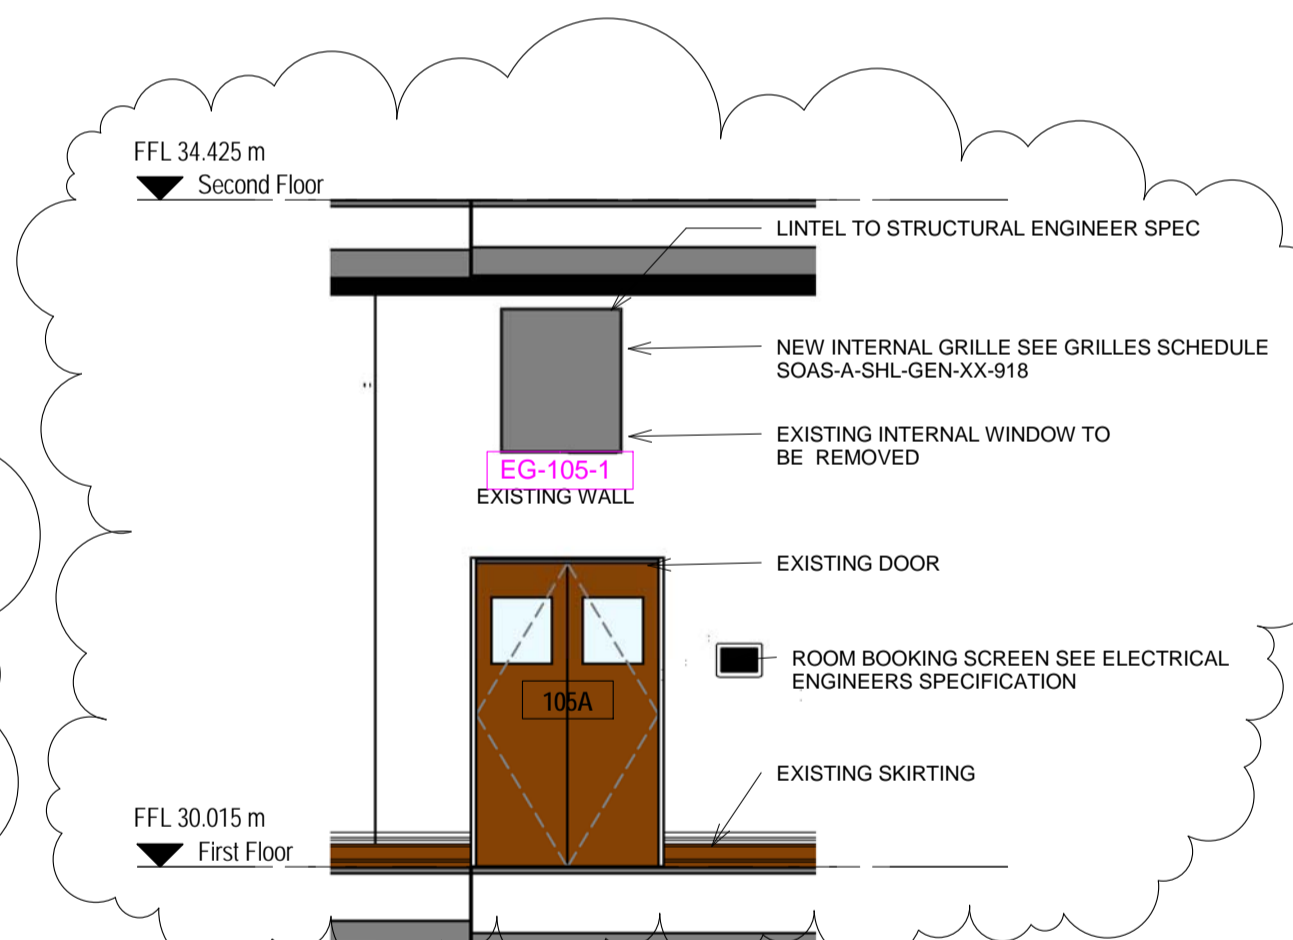


**6 CORRIDOR 1.13 DOOR 105A**

1:50

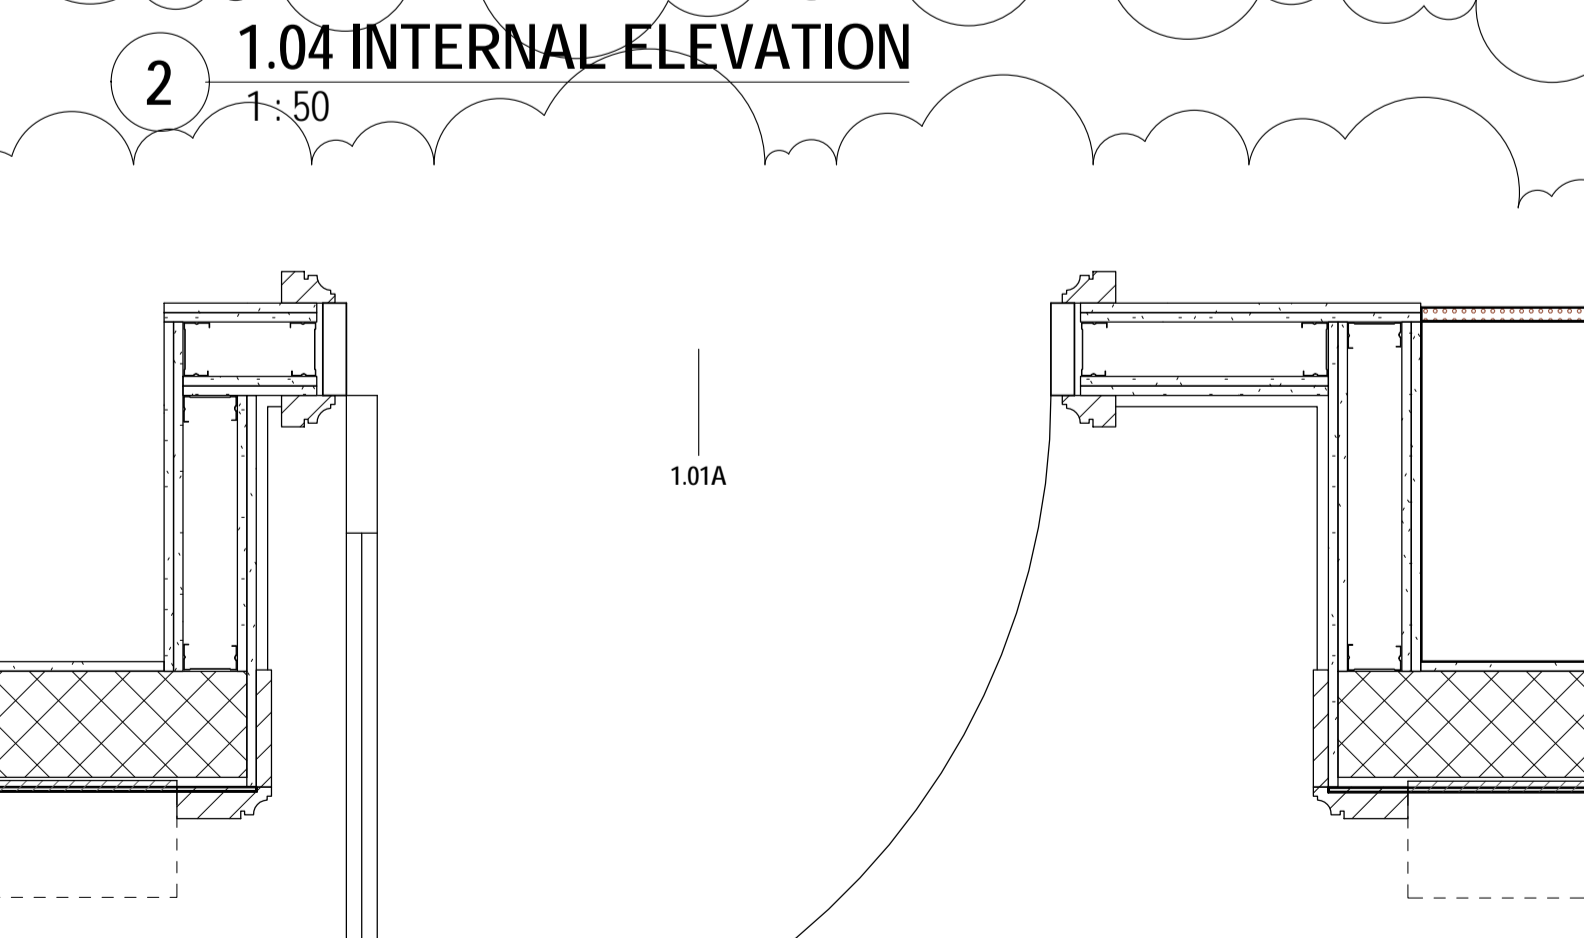


**3 DETAIL PLAN AT 1.01**

1:10

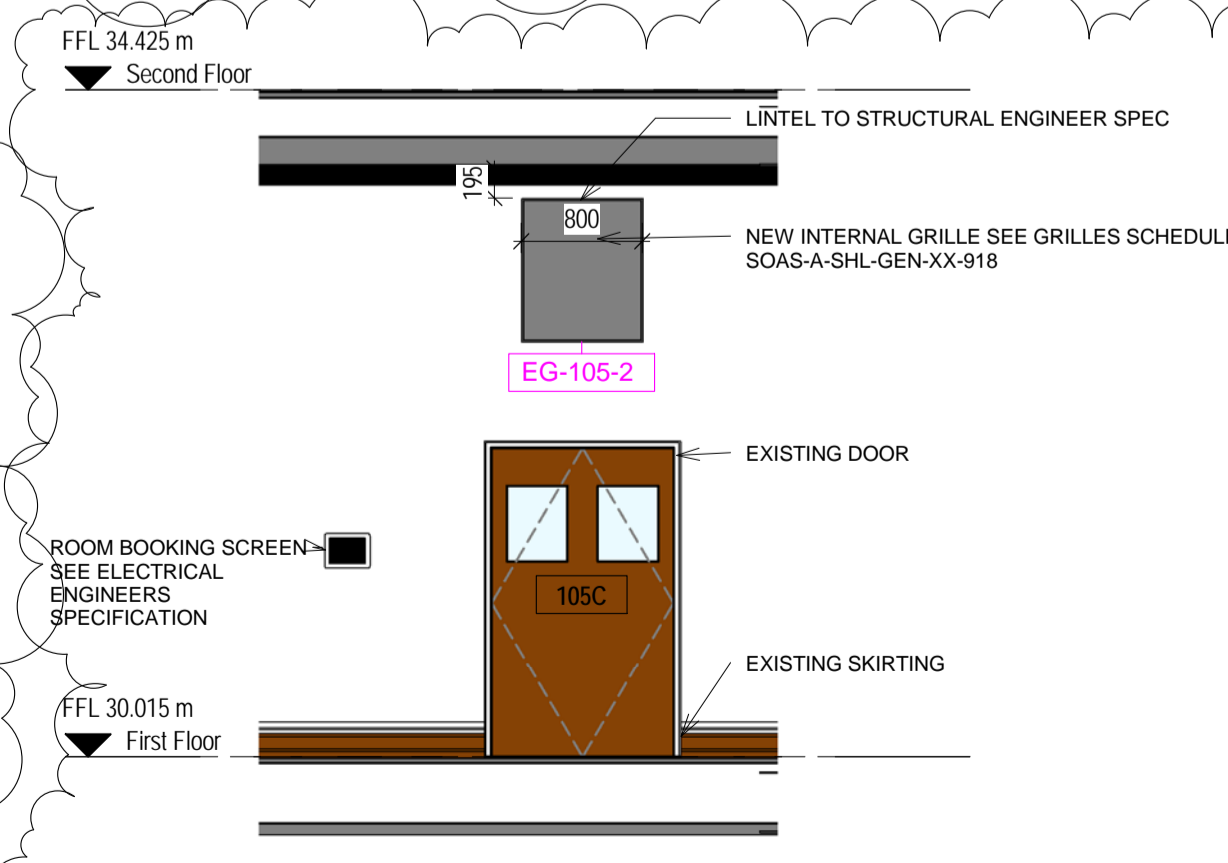


**7 CORRIDOR 1.13 DOOR 105C**

1:50

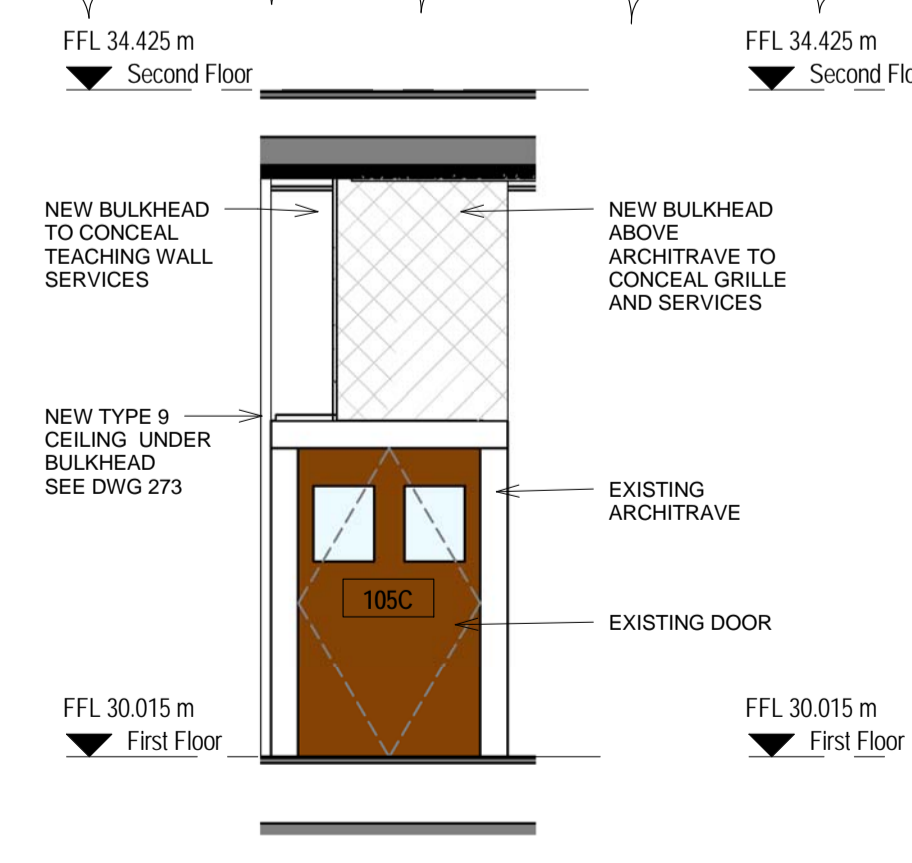

**8 1.05 BULKHEAD ELEVATION**

1:50

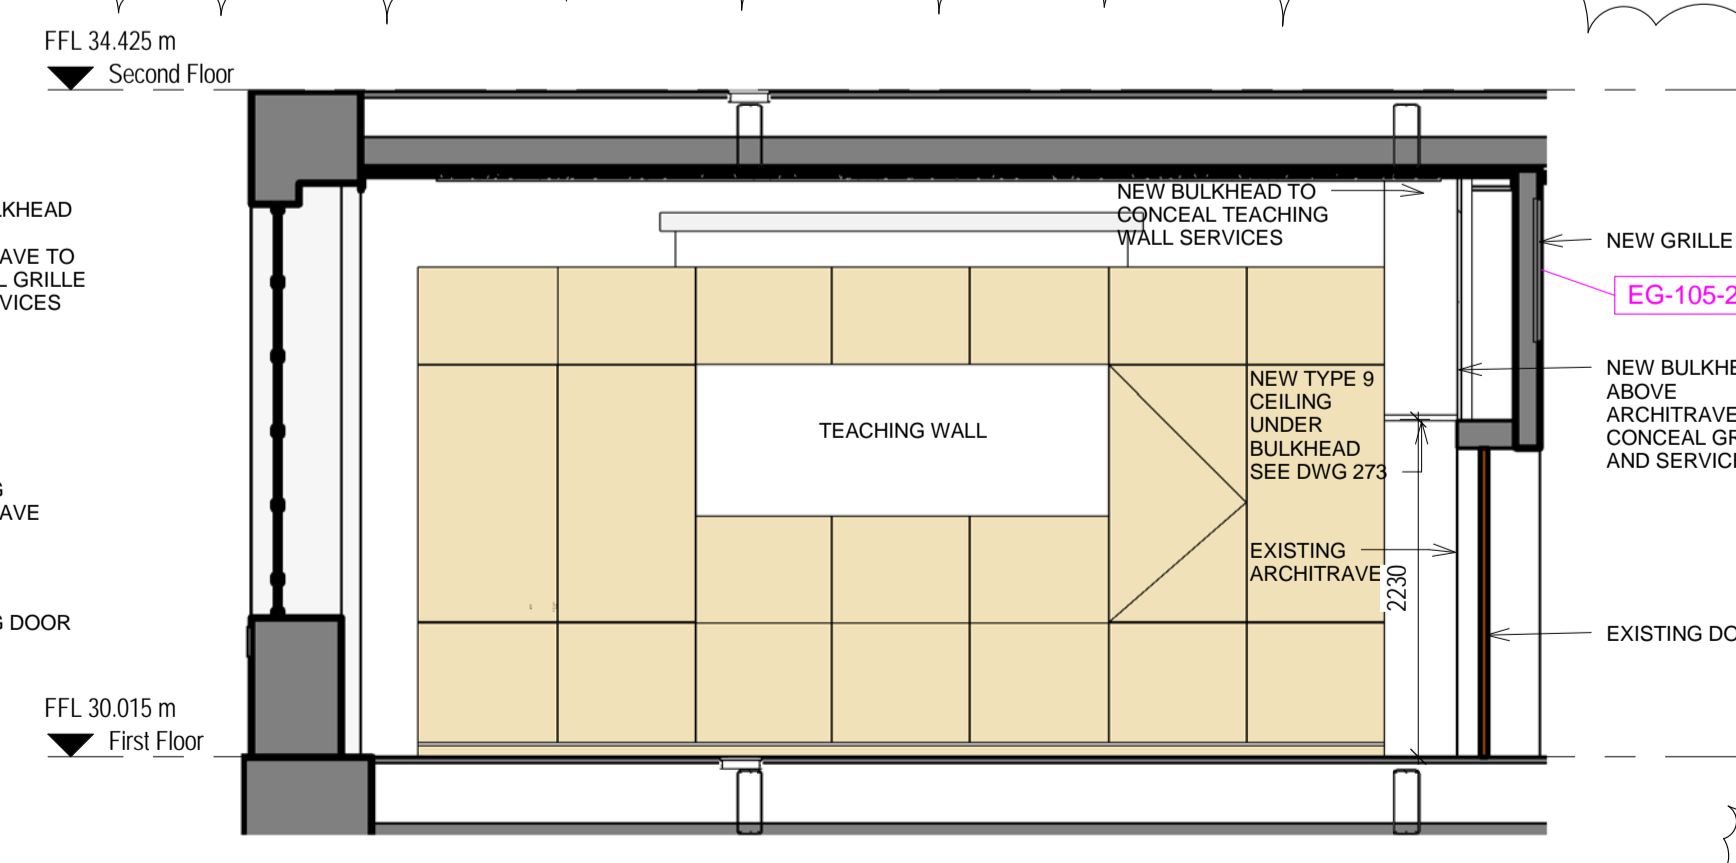

**9 1.05 INTERNAL ELEVATION**

1:50

© COPYRIGHT Mace Group  
NOT TO BE REPRODUCED WITHOUT WRITTEN PERMISSION.  
BECAUSE OF POSSIBLE SCALING ERRORS IN ELECTRONIC AND HARD COPY REPRODUCTION DO NOT SCALE FOR CONSTRUCTION PURPOSES.  
ALL DIMENSIONS TO BE CHECKED & VERIFIED ON SITE PRIOR TO CONSTRUCTION.

**Safety first. Second nature.**

Safety, Health and Environment Information

The significant unusual hazards / risks associated with this type of work are noted as:

CONSTRUCTION		
CI	CDM32	FIXING TO HOLLOW POTS
CII		
OPERATION AND MAINTENANCE		
OI		NONE
OII		
DISMANTLING/DEMOLITION		
DI		NONE
DII		

NOTE - TO BE READ IN CONJUNCTION WITH RISK REGISTER


NOTES:

1. FOR NEW INTERNAL GRILLES REFER TO INTERNAL GRILLES DRAWING SOAS-A-SHL-GEN-XX-918

2. ALL GRILLES AND LOUVRES DIMENSIONS TO BE FULLY CHECKED ON SITE BY THE MECHANICAL SUB-CONTRACTOR BEFORE STARTING MANUFACTURE

IG-105-3 GRILLES TAGS REFER 28731-SOAS-A-SHL-GEN-XX-918 AND MECHANICAL SCHEDULE 28731-SOAS-M-SHL-VNT-XX-001

REV	DATE	DESCRIPTION	AM	LT/GM	DWN	CHK/APP
3	05.12.14	REVISIONS SINCE CONTRACT DWG T1: GRILLES AMENDED, REFERENCES & NOTES ADDED, SKIRTINGS & DOORS UPDATED, BOOKING SCREENS ADDED, LEVELS UPDATED, ELEVATIONS 7, 8, 9 ADDED, DETAIL PLAN 3 ADDED, ELEVATION 10.26 OMITTED.	GM	EF/MD		
2	14.11.14	GRILLES AMENDED & REFERENCES ADDED, LEVELS CHANGED, BULKHEAD ELEVATIONS ADDED	GM	LT/GC		
1	03.10.14	CONSTRUCTION ISSUE	AM	LT/GM		

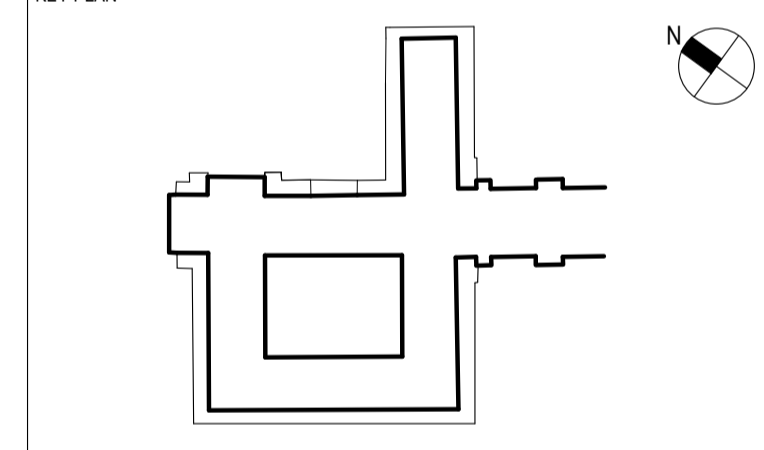

PROJECT STATUS: **CONSTRUCTION**

CLIENT: **GRAHAM CONSTRUCTION**

**mace**  
155 Moorgate, London, EC2M 6XB  
www.macegroup.com

PROJECT TITLE: **SOAS INTO SENATE HOUSE MALET STREET LONDON, WC1E 7HU**

DRAWING TITLE: **PROPOSED DRY WALL PARTITIONS**

PROJECT NO.	DRAWN BY	DATE			
28731	JB	09/12/13			
CHK BY	DATE				
LT	09/12/13				
APPD BY	DATE				
	09/12/13				
PROJECT CODE	DISC.	VIEW TYPE	VIEW CAT.	LEVEL	DWG. NO.
SOAS - A - ELE - GEN - ZZ					753
SHEET NO.	SCALE	ORIG. SHEET SIZE	REV.		
1 of 1	As indicated	@ A1	C 3		

INFORMATION HANDLING CLASSIFICATION: **UNRESTRICTED**