


**NOTES**  
 CONTRACTORS MUST VERIFY ALL DIMENSIONS ON SITE BEFORE COMMENCING ANY WORK OR SHOP DRAWINGS. FIGURED DIMENSIONS ARE TO BE USED IN PREFERENCE TO SCALED DIMENSIONS. IF THIS DRAWING EXCEEDS THE QUANTITIES TAKEN IN ANY WAY, THE ARCHITECTS ARE TO BE INFORMED BEFORE THE WORK IS INITIATED.  
 SEIFERT COPYRIGHT

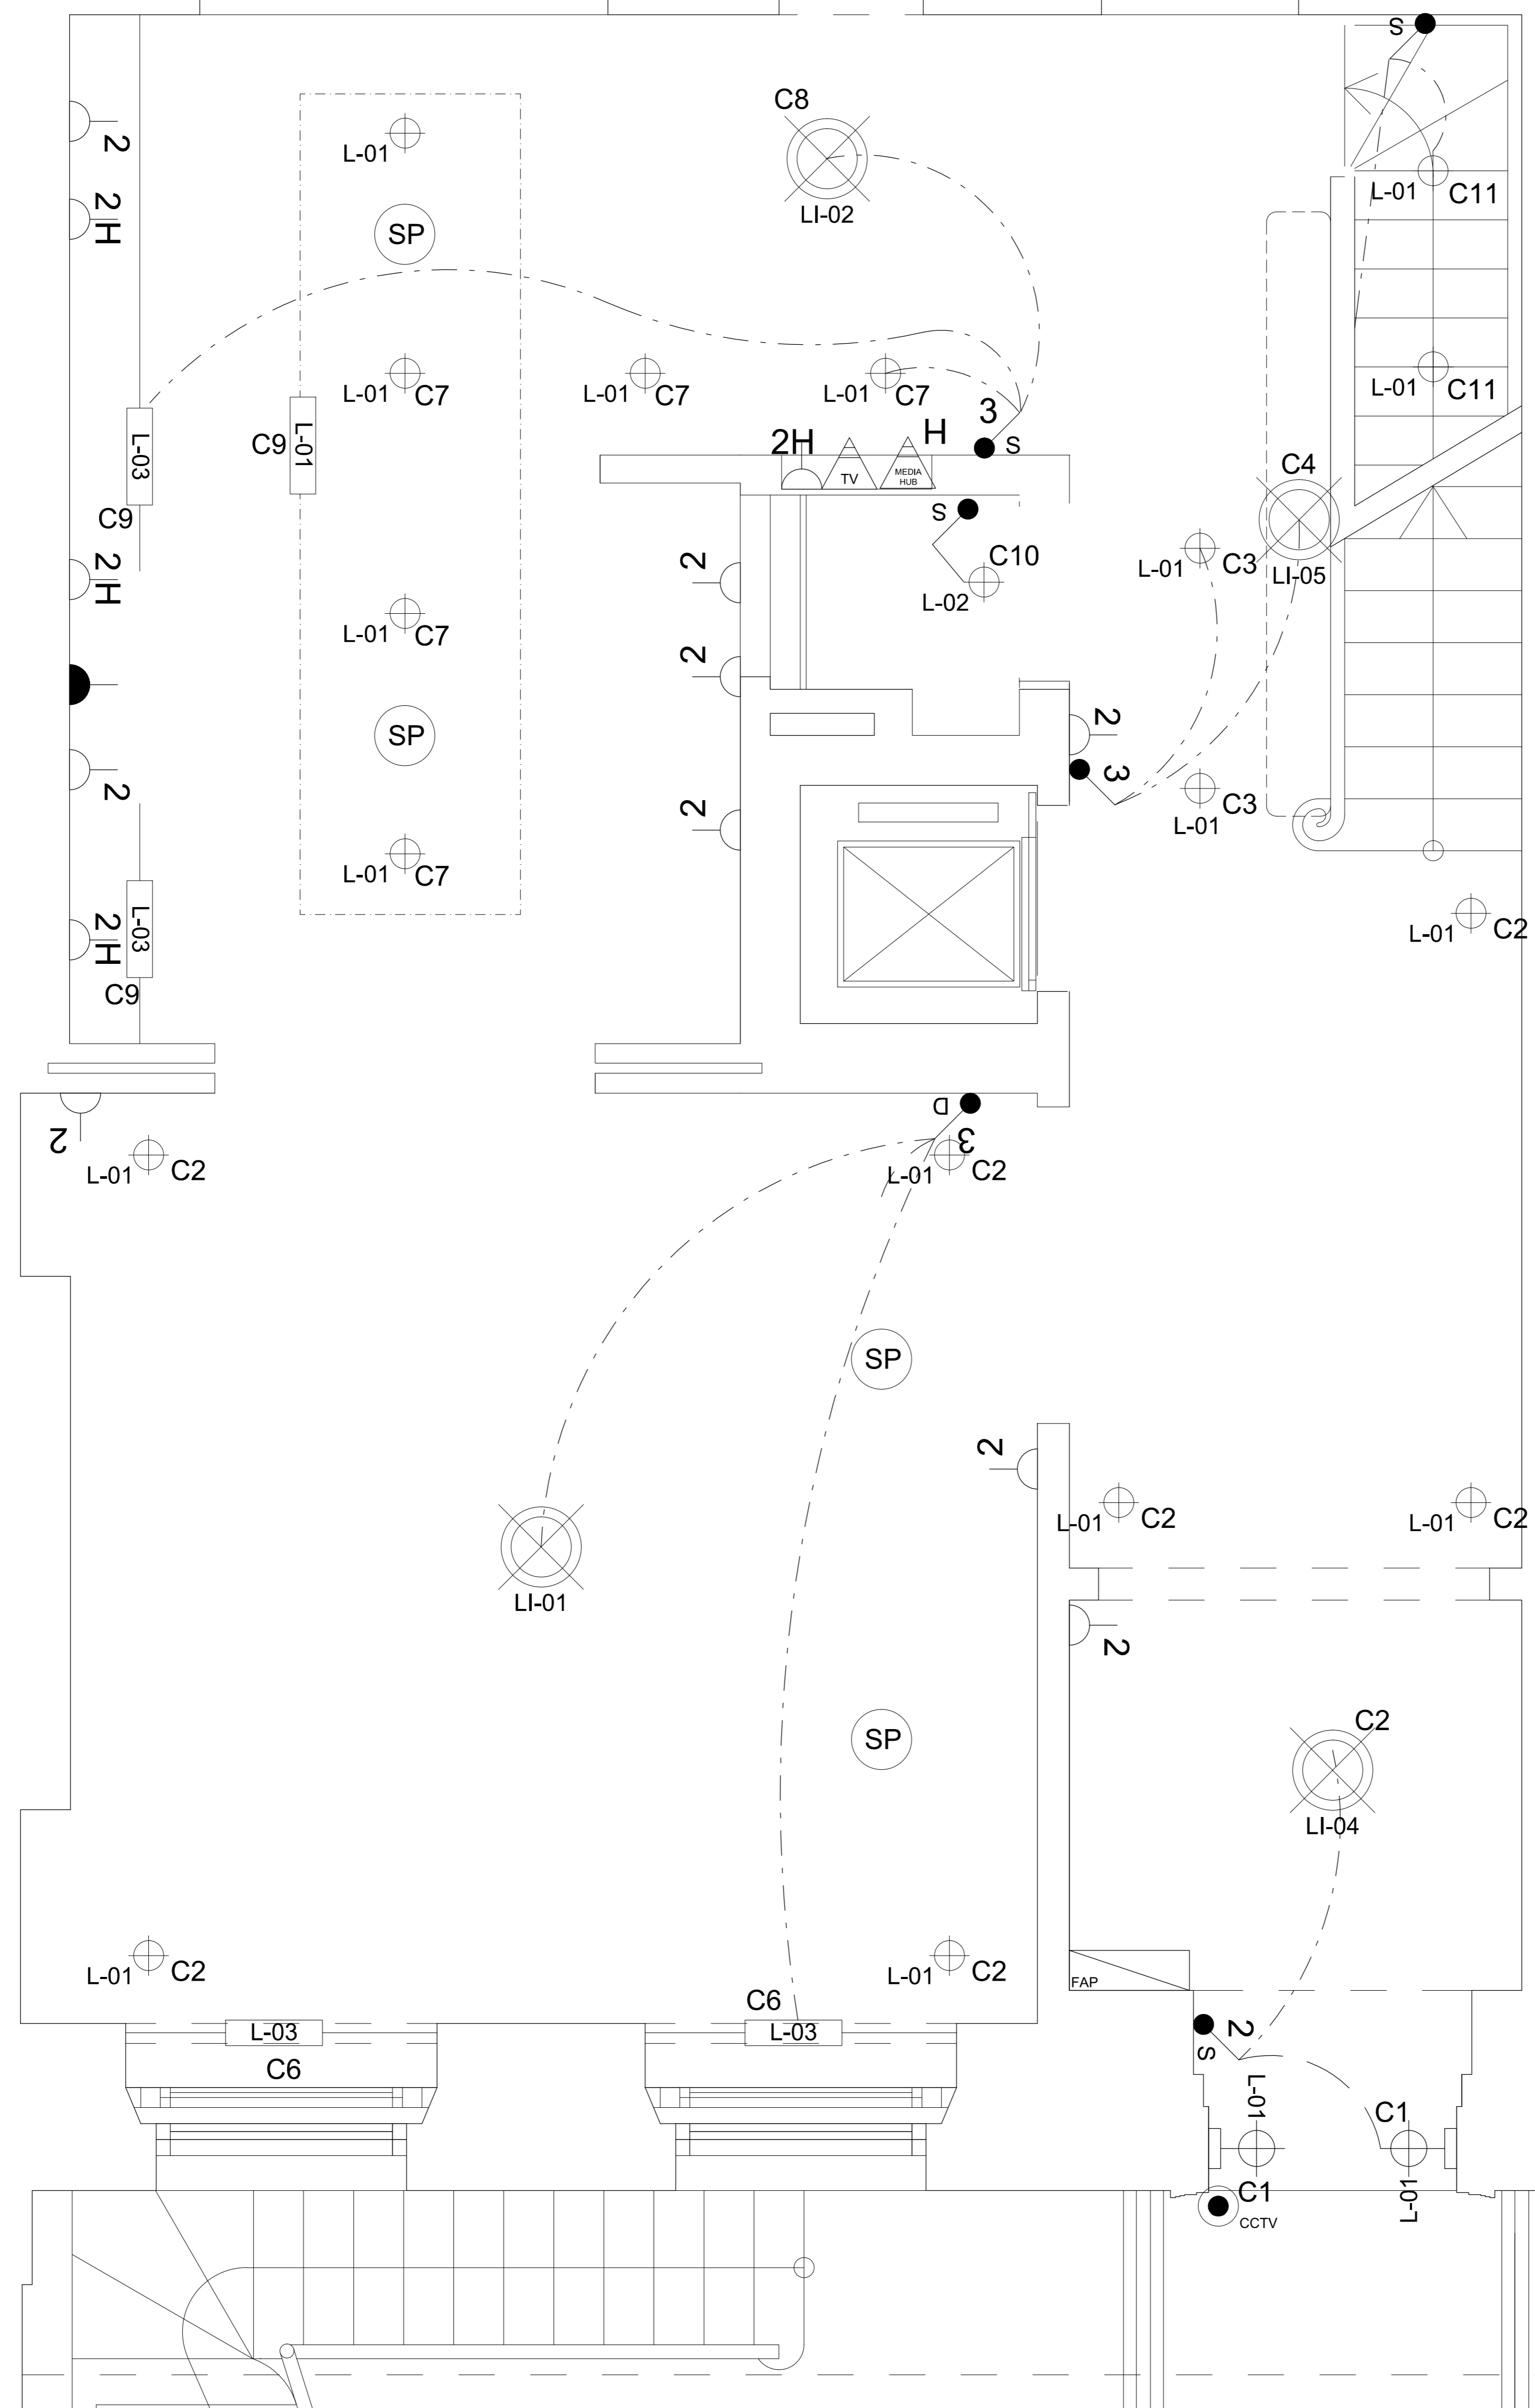

**CIRCUIT LEGEND - GROUND FLOOR -**

- C1 - SPOTS LIGHTS TO OUTSIDE LIGHTS
- C2 - SPOT LIGHTS TO ENTRANCE
- C3 - SPOT LIGHTS TO HALLWAY
- C4 - CHANDELIER TO HALLWAY
- C5 - SPOT LIGHTS TO DINING ROOM
- C6 - LED LIGHTS TO COFFER/ CURTAINS TO DINING ROOM
- C7 - SPOT LIGHTS TO KITCHEN
- C8 - PENDANT TO KITCHEN
- C9 - LED LIGHTS TO COFFER AND UNDERNEATH CABINETS TO KITCHEN
- C10 - SPOT TO WC
- C11 - SPOT LIGHT TO BASEMENT & LED TO STAIR BALUSTRADE

REV.	DESCRIPTION	DATE	INIT.

**NOTES**

1. THE DRAWING SHOW DESIGN INTENT ONLY. ALL DIMENSIONS TO BE CHECKED ON SITE PRIOR TO CONSTRUCTION OR PRODUCTION. CONSTRUCTION DETAILS TO BE CONFIRMED BY CONTRACTOR/ MANUFACTURER BY SUBMITTING SHOP DRAWINGS FOR DESIGNER'S APPROVAL.
2. DESIGN / DRAWING IS NOT TO BE SCALED FOR PRODUCTION AND CONSTRUCTION PURPOSES
3. ALL DISCREPANCIES AND OMISSIONS ON SITE MUST BE REPORTED TO DESIGNER FOR THEIR COMMENTS OR APPROVAL PRIOR TO COMMENCING WORK.
4. ALL ELECTRICAL, LIGHTING, HVAC AND PLUMBING ISSUES TO BE REFERRED TO ENGINEER'S DRAWINGS PRIOR TO COMMENCEMENT OF WORKS.
5. THE DESIGNS ARE SUBJECT TO APPROVAL BY STATUTORY AUTHORITIES AND ANY NECESSARY ALTERATIONS SHOULD BE MADE IF REQUIRED TO COMPLY WITH STATUTORY REQUIREMENTS.
6. ALL DESIGN CONCEPTS AND DRAWINGS ARE THE PROPERTY OF SIGMA ARCHITECTURE AND INTERIORS AND COVERED BY COPYRIGHT. NO REPRODUCTIONS, ADAPTATIONS AND/OR COPIES MAY BE MADE WITHOUT WRITTEN PERMISSION BY SIGMA.

© SIGMA SEIFERT INTERIORS 2014



4 Duke's Mews  
 London  
 W1U 3ET  
 T: 020 7935 6984  
 F: 020 7486 8507  
 www.sigma-architects.com

STATUS **PLANNING**

CLIENT **John Seifert**

JOB **5 Chester Terrace  
 Regents Park, NW1**

TITLE **GROUND FLOOR PLAN  
 PROPOSED  
 LOW LEVEL  
 ELECTRICALS**

SCALE **A1 @ 1:20** DATE **11/11/14**

DRAWING No. **S17044-302** REVISION No. **-**