

**GENERAL NOTES**


FOR CONSTRUCTION PURPOSES DO NOT SCALE. VERIFY ALL DIMENSIONS AND LEVELS ON SITE. CONFIRM ALL SETTING OUT DIMENSIONS.  
 SHOULD CONDITIONS ON SITE VARY FROM INFORMATION SUPPLIED REPORT TO ARCHITECT IMMEDIATELY.  
 THIS DRAWING TO BE READ IN CONJUNCTION WITH ALL RELEVANT CONSULTANTS DRAWINGS AND SPECIFICATIONS.  
 MATERIALS AND WORKMANSHIP TO BE TO RELEVANT BRITISH STANDARDS AND CODES OF PRACTICE AND MANUFACTURERS WRITTEN RECOMMENDATIONS WHERE APPLICABLE, UNLESS SPECIFICALLY NOTED OTHERWISE.  
 ALL WORKS TO BE EXECUTED WITH DUE CARE AND DILIGENCE SO AS NOT TO IMPAIR THE STABILITY OF THE BUILDING, ADJACENT WORKS, SITE PERSONNEL OR THIRD PARTIES. ALL IN ACCORDANCE WITH HSE DIRECTIVES AND RECOMMENDATIONS AND THE CDM REGULATIONS CURRENTLY IN FORCE.

**REVDATE INTLS AMENDMENT**

7 7 7


- ELECTRICAL KEY**
- 1-WAY LIGHT SWITCH
  - 2-WAY LIGHT SWITCH
  - SURFACE MOUNTED LUMINAIRE
  - LOW VOLTAGE RECESSED DOWNLIGHTER
  - DOUBLE 13A OUTLET
  - DOUBLE 13A OUTLET AT WORKTOP LEVEL
  - FUSED SPUR WITH ILLUMINATED SWITCH AT WORKTOP LEVEL
  - COOKER CONTROL WITH ILLUMINATED SWITCH AT WORKTOP LEVEL
  - TV POINT
  - PHONE POINT
  - ENTRY PHONE
  - SMOKE DETECTOR
  - SMOKE DETECTOR WITH SOUNDER
  - HEAT DETECTOR

NOTE:  
 ELECTRICAL LAYOUT IS DIAGRAMMATIC ONLY. EXACT LOCATIONS TO BE AGREED ON SITE PRIOR TO INSTALLATION

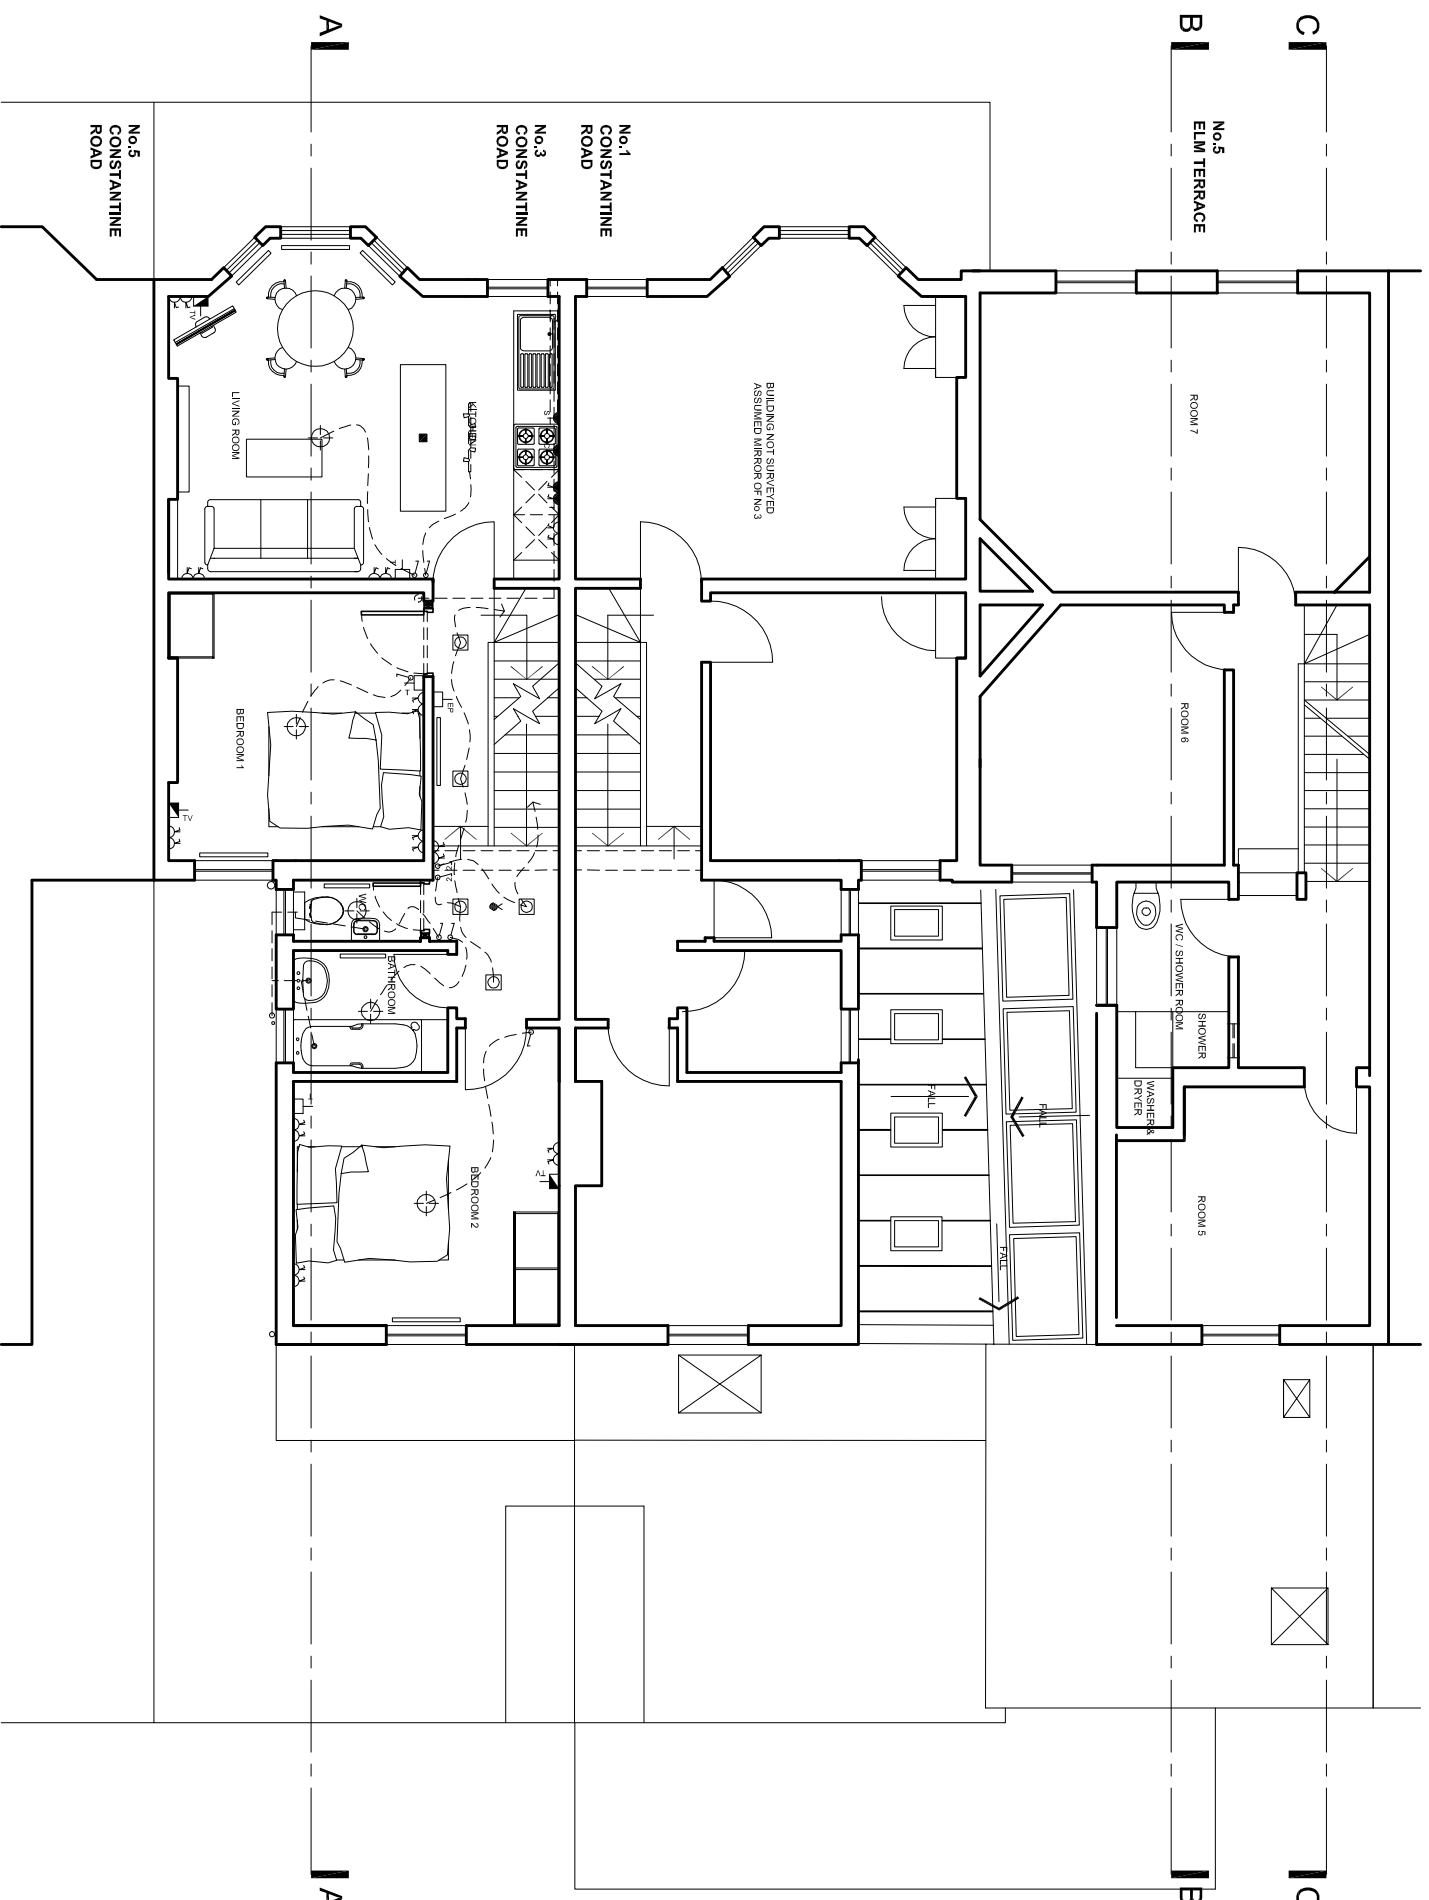

NOTE: No. 5 ELM TERRACE & No. 1 CONSTANTINE ROAD AS EXISTING

**PRELIMINARY**

 

DRAWING TITLE

**PROPOSED FIRST FLOOR PLAN**

PROJECT : DENTAL PRACTICE ALTERATIONS AND EXTENSION  
 LOCATION : 5 ELM TCE & 1-3 CONSTANTINE ROAD, LONDON, NW3 2LL  
 CLIENT : DR LINDA GREENWALL  
 DATE : NOV 14  
 SCALE : 1:100@A3  
 COURTE : BPMU  
 JOB No. : 2803 DWG No. : L(2)02 REV :

