

GENERAL NOTES:

1. Do not scale off this drawing, use figured dimensions only. All dimensions and levels to be checked on site and Owen Architects to be notified of any discrepancies immediately. Issued only for purpose indicated.
2. The drawing is to be read in conjunction with consultants drawings and specifications.
3. This drawing is copyright of GOK and may not be copied, altered or reproduced in any way or passed to a third party without written permission from GOK.
4. The main contractor should be conversant with the statutory obligations under the CDM regulations.
5. The dimensions shown on this drawing have been based on the measurements provided by an independent survey company.
6. For setting out refer to elevations or to be confirmed by GOK Studios

SCHEDULES FOR REFERENCING:


1. ALL FACE PLATES TO BE SPACED 20mm APART
2. ALL CRESTRON SWITCHES TO BE 1550mm FROM FFL TO CENTER OF SWITCH
3. ALL LITRON PANELS AND GENERAL SWITCHES TO BE 1250mm FROM FFL TO CENTER OF SWITCH UNLESS OTHERWISE NOTED ON DRAWINGS/
4. FOR WALL LIGHT AND PICTURE LIGHT FITTINGS REFER TO ELEVATIONS
5. ALL CABINERY SMALL POWER LOCATED WITHIN CABINERY AT 200mm FROM TOP EDGE OF SKIRTING TO CENTER OF FACE PLATE /OR TILL FURTHER NOTATION/
6. SMALL POWER LOCATED WITHIN FLOOR BOX TO BE RECESSED INTO FLOOR. REFER TO SMALL POWER DRAWING FOR SETTING OUT PURPOSES ONLY
7. UNDERFLOOR HEATING AND FCU UNITS TO BE CO-ORDINATED WITH M&E CONSULTANTS, REFER TO RELATED DRAWING

SCHEDULES FOR REFERENCING:

1. Refer to Owen Architects schedules
2. Refer to Services Engineers for Services

REVISIONS

Rev	Date	Description	Drawn	Chkd
TP0	11-02-15	TOWN PLANNING ISSUE	SC	HO
TP1	12-02-15	TOWN PLANNING ISSUE	SC	
TP2	17-02-15	TOWN PLANNING ISSUE	SC	
TP3	18-02-15	TOWN PLANNING ISSUE	SK	

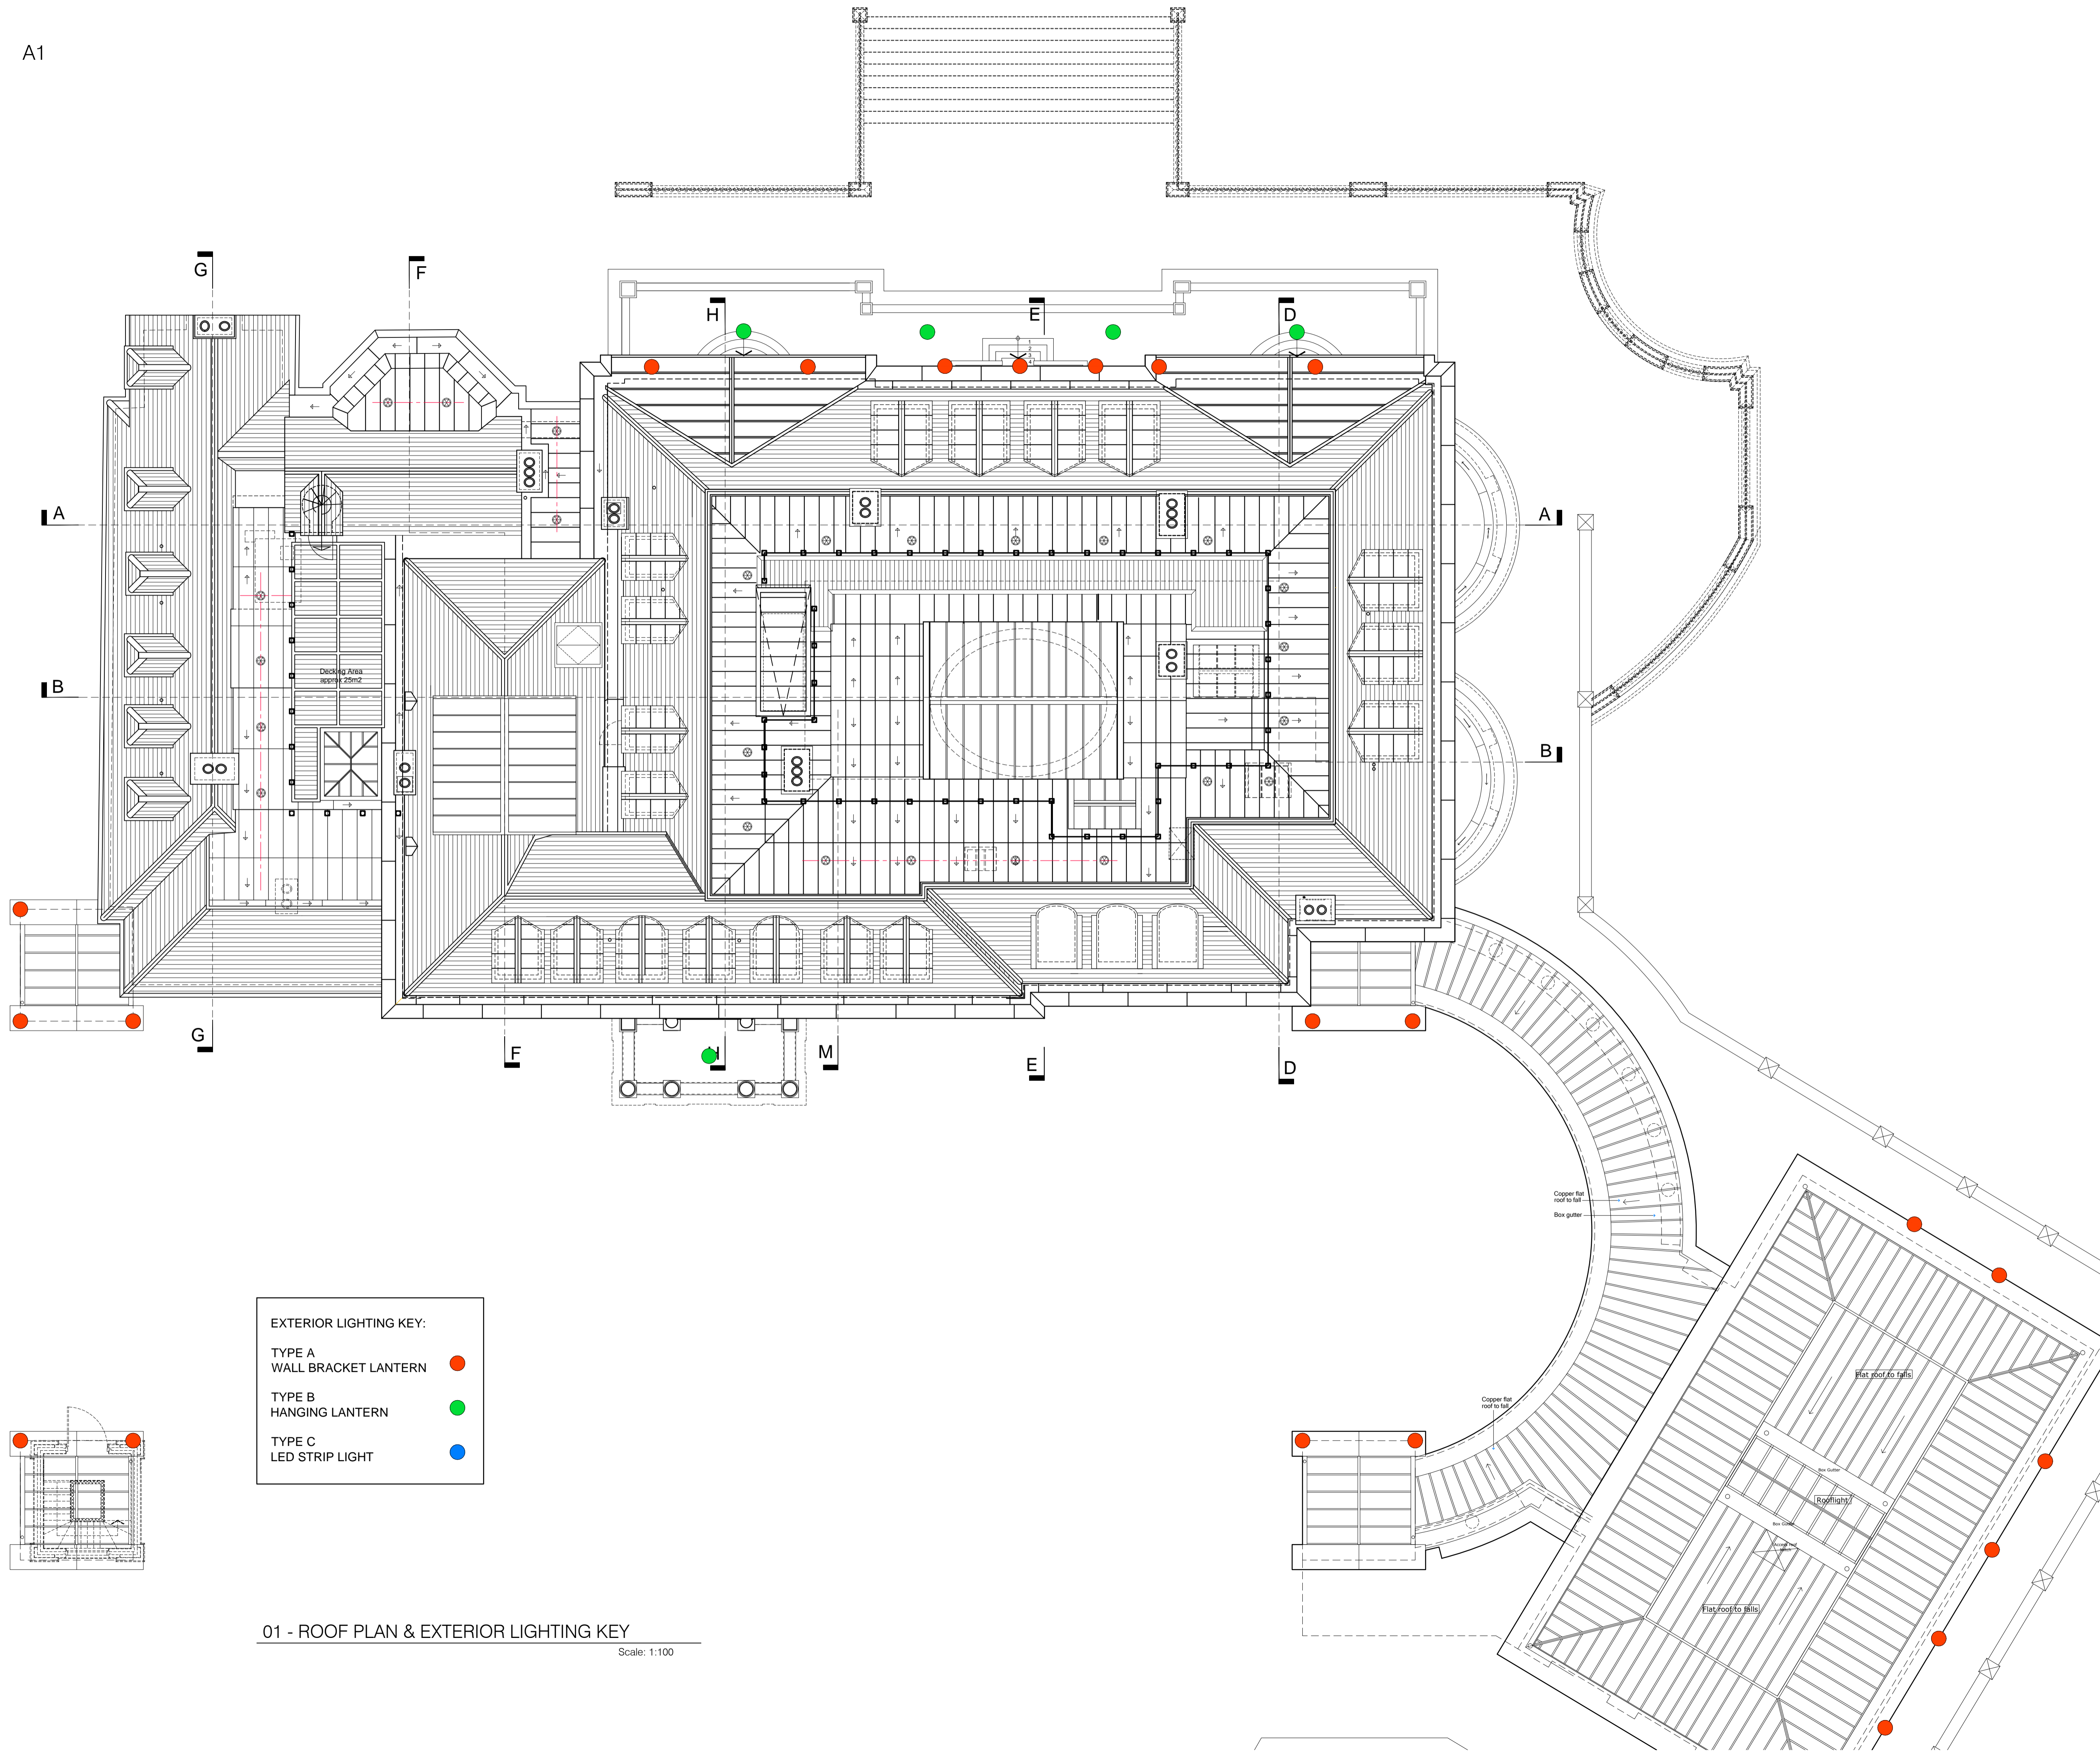

EXTERIOR LIGHTING KEY:

- TYPE A WALL BRACKET LANTERN ●
- TYPE B HANGING LANTERN ●
- TYPE C LED STRIP LIGHT ●

01 - ROOF PLAN & EXTERIOR LIGHTING KEY
Scale: 1:100

INFORMATION

Owen Architects
 Gate House
 1 St John's Square
 London
 EC1M 4DH
 +44 (0) 20 7608 2888 T
 +44 (0) 20 7608 0758 F
 info@owenarchitects.co.uk

PROJECT: 363			
DRAWING TITLE: LOCATION PLAN OF ALL EXTERNAL LIGHTING			
DATE: 11-02-15	DRAWN: SC	SCALE: 1:100@A1	
PRJ. No: 363	SERIES: 22	DRAWING No: 701	REV: TP3