


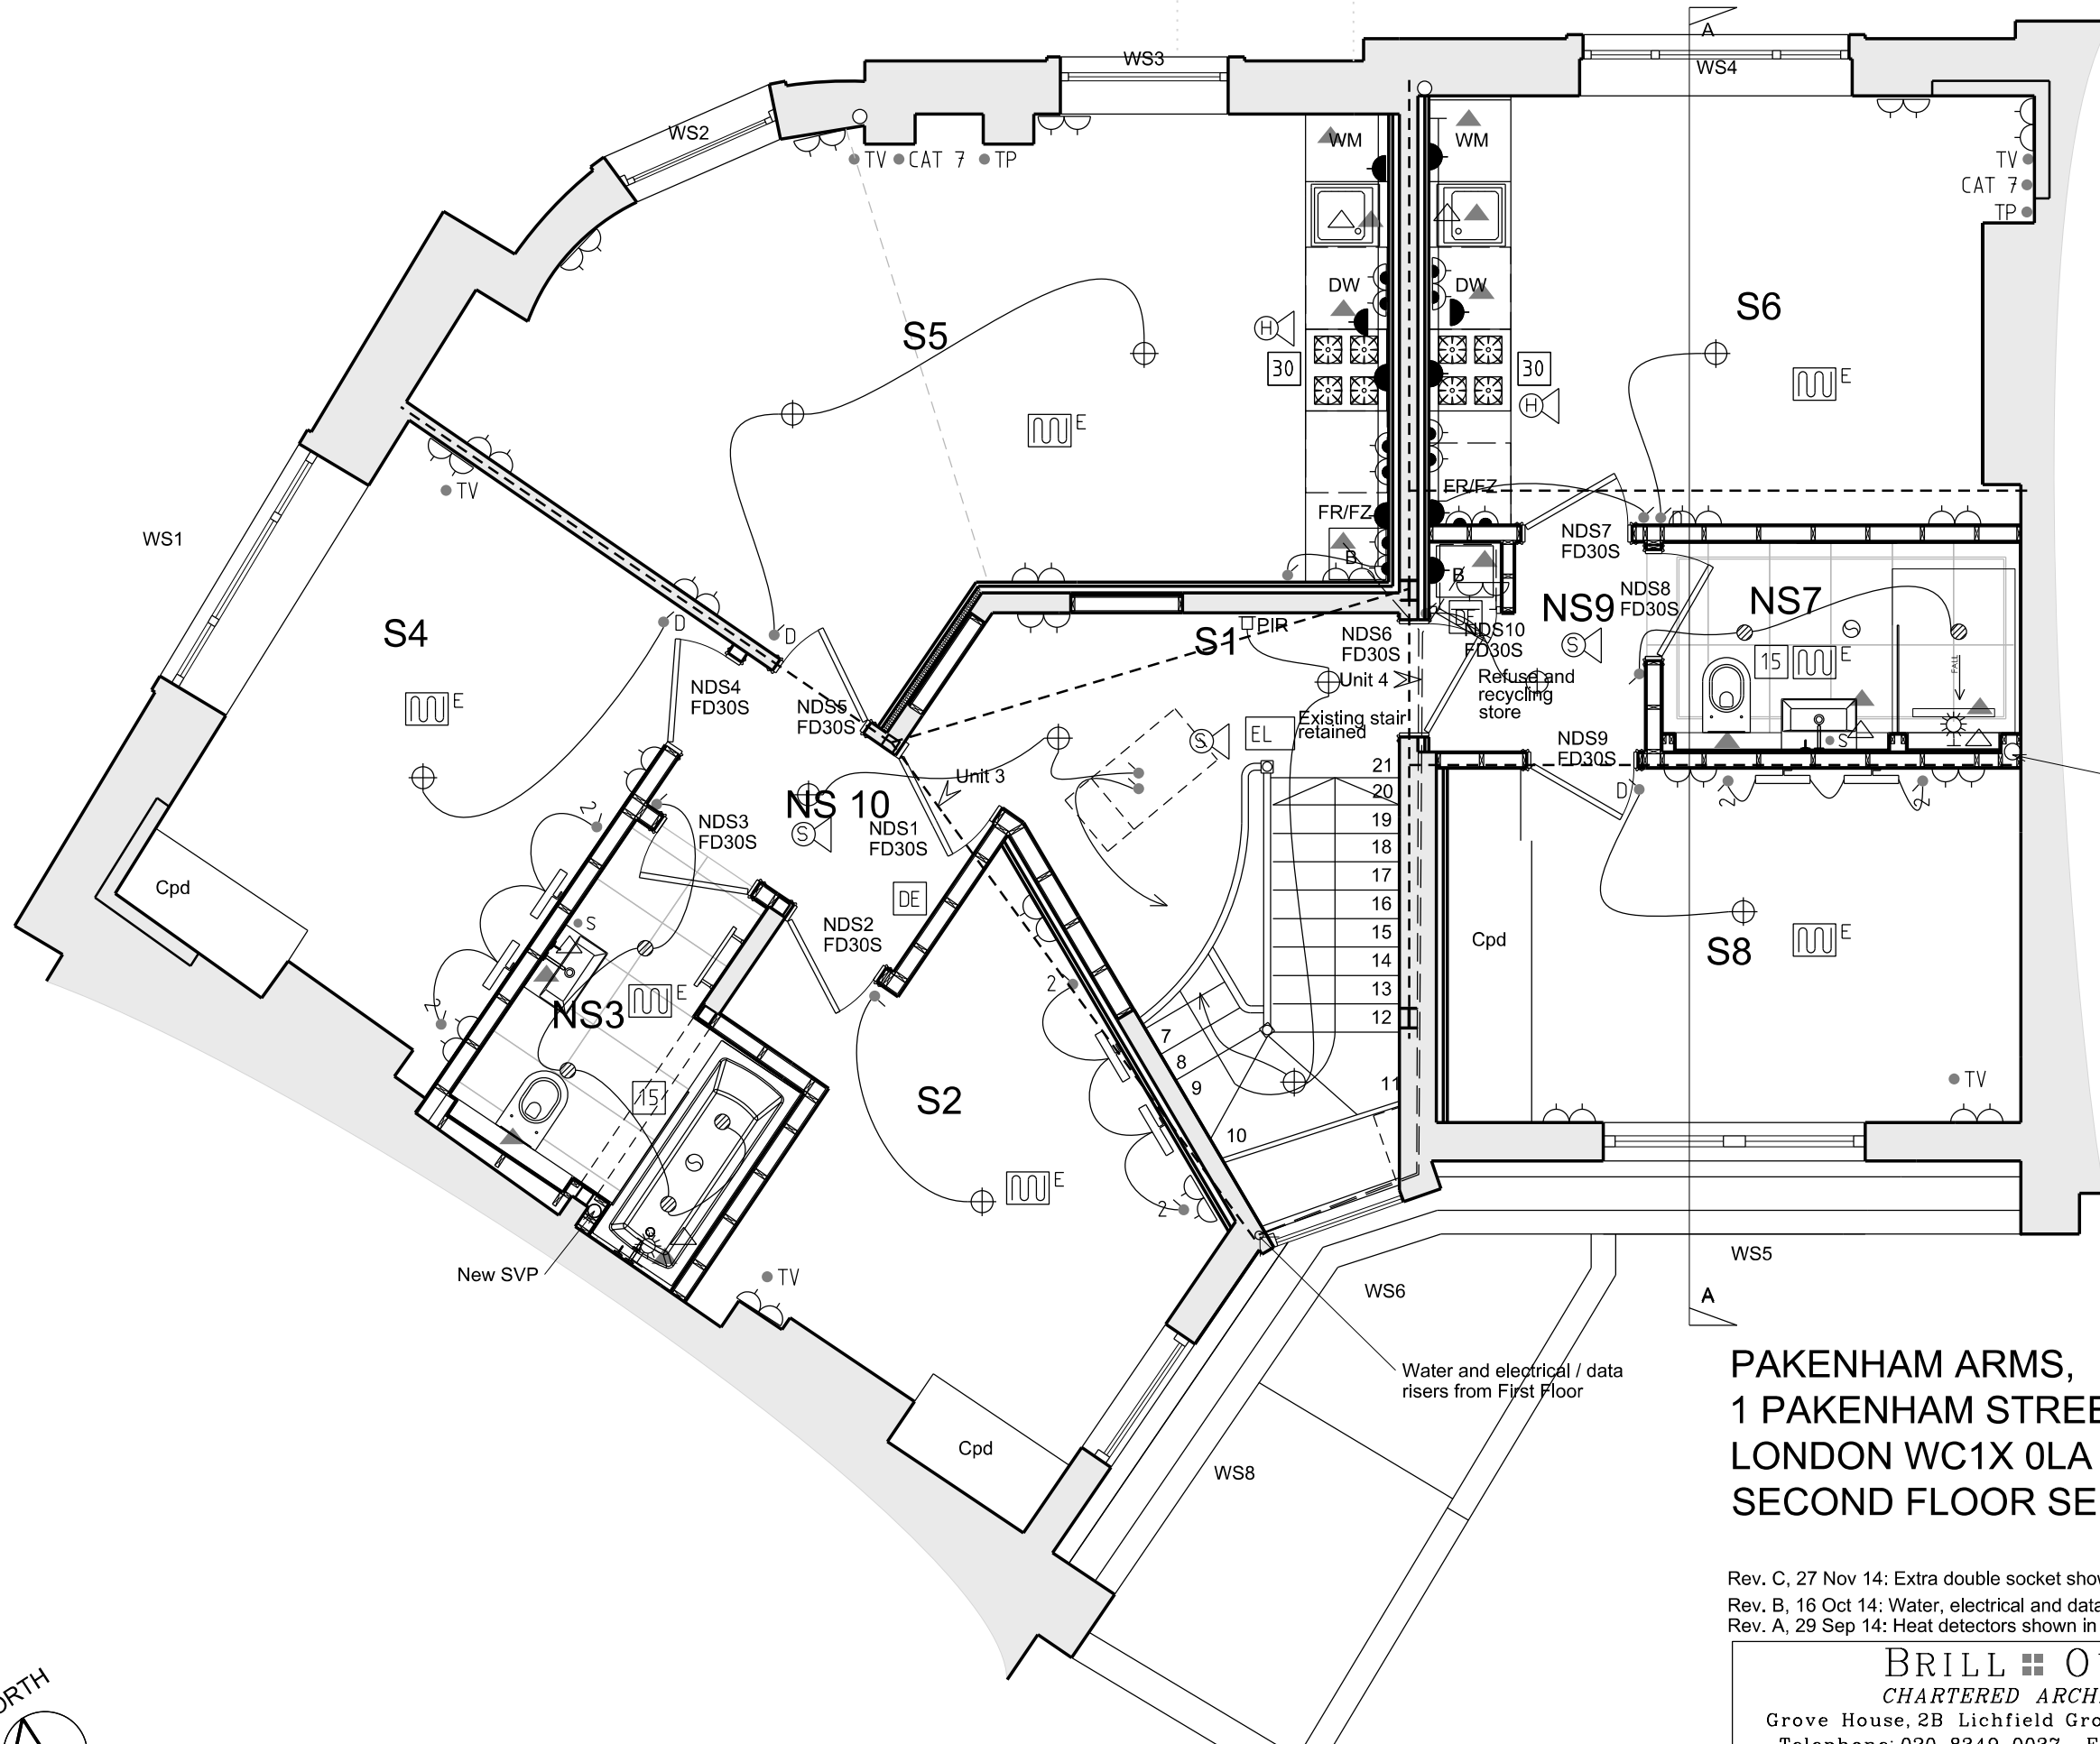

NOTE: All services to run within existing voids. No original joists or rafters to be disturbed.

PAKENHAM ARMS,
1 PAKENHAM STREET,
LONDON WC1X 0LA
SECOND FLOOR SERVICES PLAN

Rev. C, 27 Nov 14: Extra double socket shown in boiler cupboards.
Rev. B, 16 Oct 14: Water, electrical and data riser shown.
Rev. A, 29 Sep 14: Heat detectors shown in Kitchens.

BRILL ■ OWEN CHARTERED ARCHITECTS Grove House, 2B Lichfield Grove, London N3 2JP Telephone: 020 8349 0037 Fax: 020 8349 0092 E-mail: architects@brillowen.co.uk		SCALE 1:50
DATE Mar 14	DRAWN LQ	DRG.NO. 13/808/C60 C

