
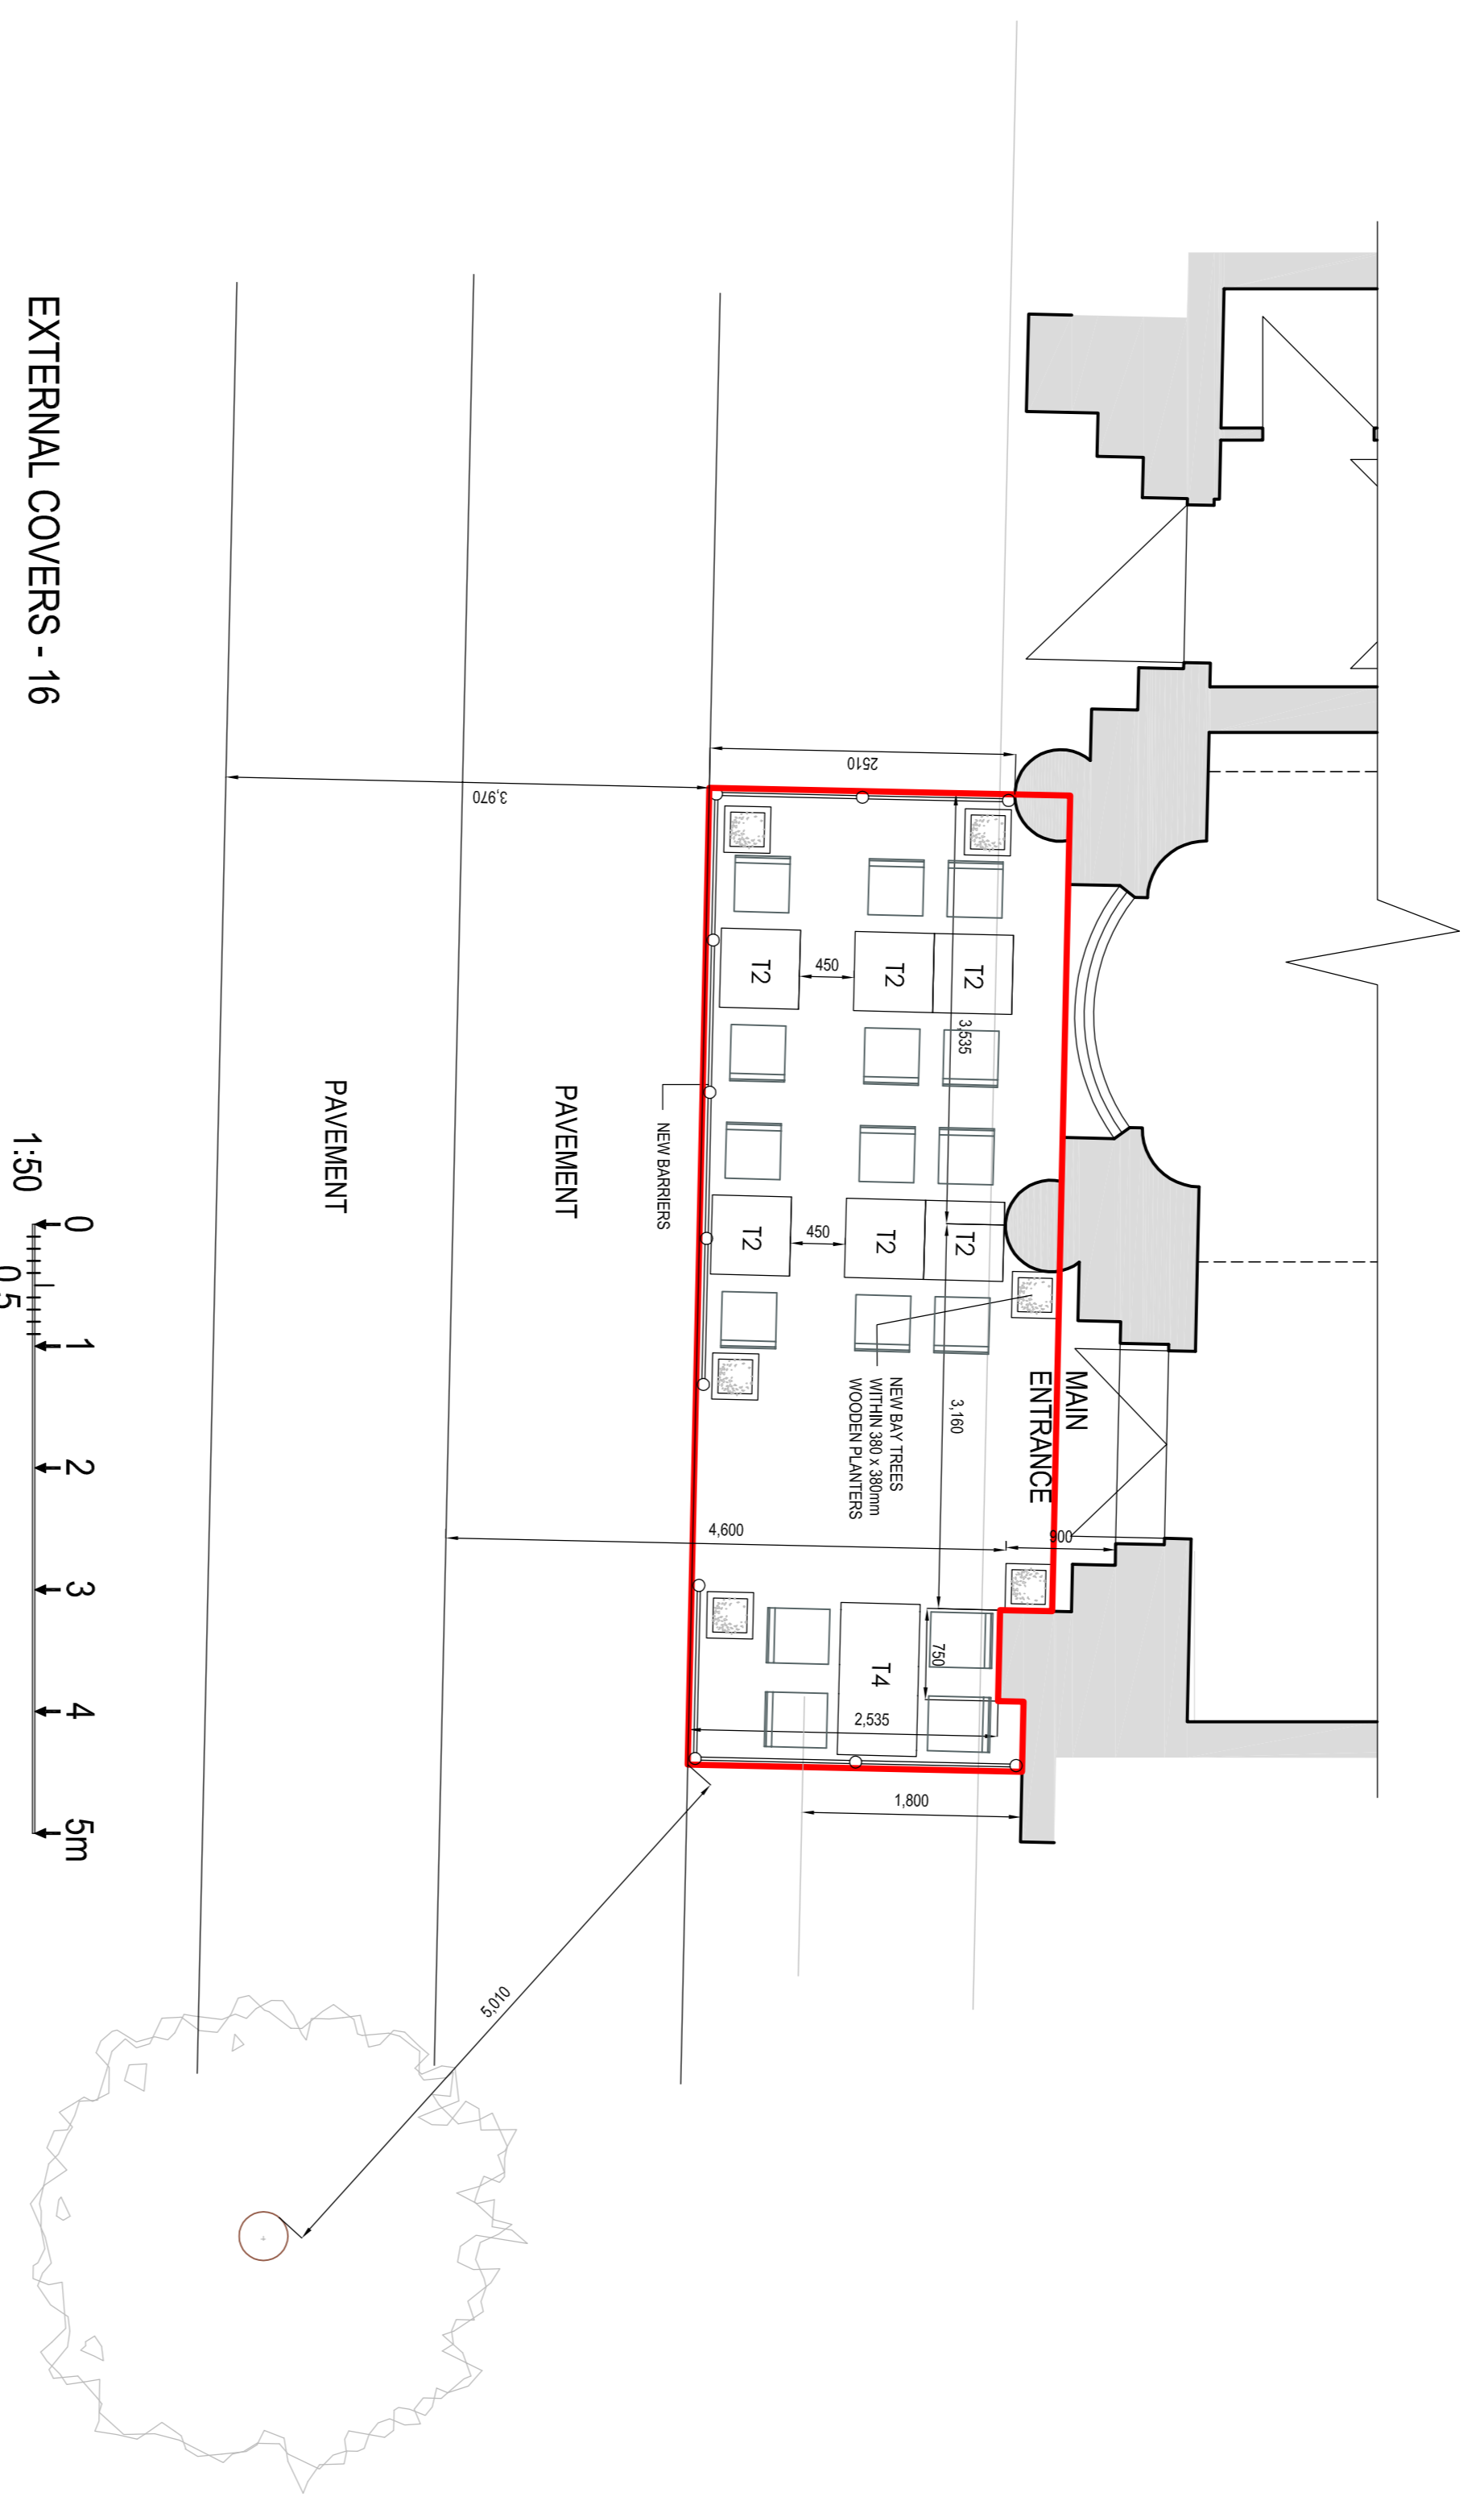


GENERAL NOTES

ALL DIMENSIONS TO BE CHECKED ON SITE PRIOR TO COMMENCEMENT OF WORKS - PLEASE REPORT ANY DISCREPANCIES TO THE ARCHITECT.
 THIS DRAWING HAS BEEN PRODUCED FOR THE PURPOSES OF PLANNING AND PERMITS ONLY AND IS NOT INTENDED TO BE A FULL WORKING DRAWING.
 THIS DRAWING IS TO BE READ IN CONJUNCTION WITH ANY OTHER SPECIFICATIONS, SCHEDULES OF WORK AND STATEMENTS OF WORK DETAILS AS APPROPRIATE.
 THIS DRAWING IS THE COPYRIGHT OF PUMP HOUSE DESIGNS AND ANY FURTHER REPRODUCTION OF THE PLANS NOT PERMITTED WITHOUT OBTAINING PRIOR CONSENT.

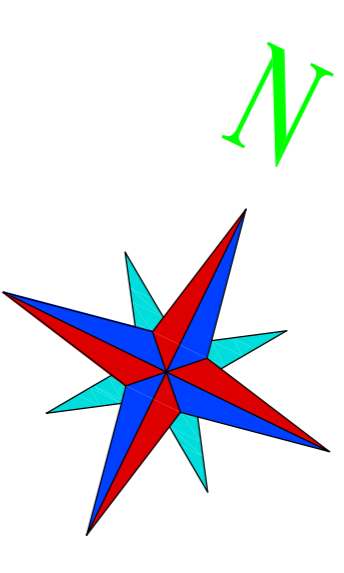

EXTERNAL COVERS - 16

SYMBOLS INDICATED ARE INDICATIVE AS EXISTING FIRE ALARM SYSTEM AND EMERGENCY LIGHTING TO BE RETAINED SUBJECT TO SERVICING / COMMISSIONING

REV	DATE	DESCRIPTION
H	18/01/2013	EXTERNAL AREA REVISED
G	14/01/2013	EXTERNAL AREA REVISED
E	14/01/2013	CLIENT AMENDMENTS
D	14/01/2013	LAYOUT AMENDED
C	14/01/2013	SEATING REVISED
B	14/01/2013	DIMENSIONS AMENDED
A	14/01/2013	EXTERNAL AREA

BILL'S RESTAURANTS
 42 KINGSWAY
 LONDON
 WC2B 6EX

LICENSING PLAN - EXTERNAL

DRAWN BY - M ADAMS
 DATE - JANUARY 2013
 SCALE - 1:50 @ A1

DRAWING No. 4239 / 503 / G

This drawing is the property of CHAMELEON REFURISHMENTS LTD. It may not be duplicated or disclosed in any form for any purpose except as outlined in writing by the architect. This drawing is for site use only and should not be used in preference to small scale drawings. Contractor to verify all site dimensions, levels and sewer invert levels or connection points before any work commences. Any errors or omissions are to be reported to the designer. If in doubt ask the architect. This drawing is to be read in conjunction with the relevant consultants and/or specialist drawings/documents and any discrepancies or variations are to be notified to the designer before the attached work commences.
 © 2009 CHAMELEON REFURISHMENTS LTD.
 All rights reserved.

CHAMELEON
 REFURISHMENTS LTD
 CHAMELEON REFURISHMENTS
 211 Millers Lane, London W12 8PP
 Tel: 0208 749 1200 Fax: 0208 749 1201
 Email: info@chameleonrefurishments.co.uk

Pumphouse
 DESIGNS
 Architectural Consultants
 Pump House Yard
 The Green
 Sedlescombe
 TN33 0DN
 T: 01424 871120
 F: 01424 870198
 info@pumphousedesigns.co.uk
 www.pumphousedesigns.co.uk