




# Basement

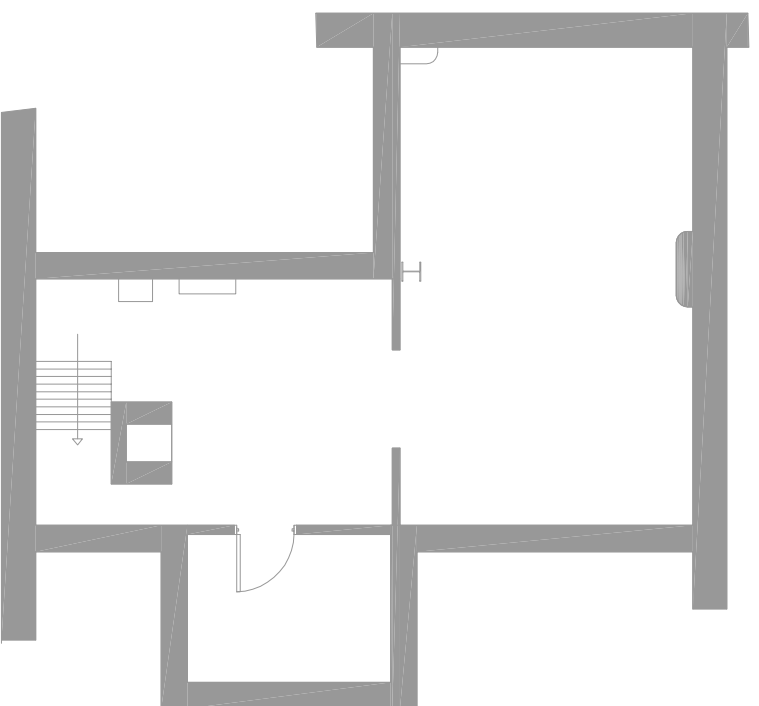


# Ground Floor

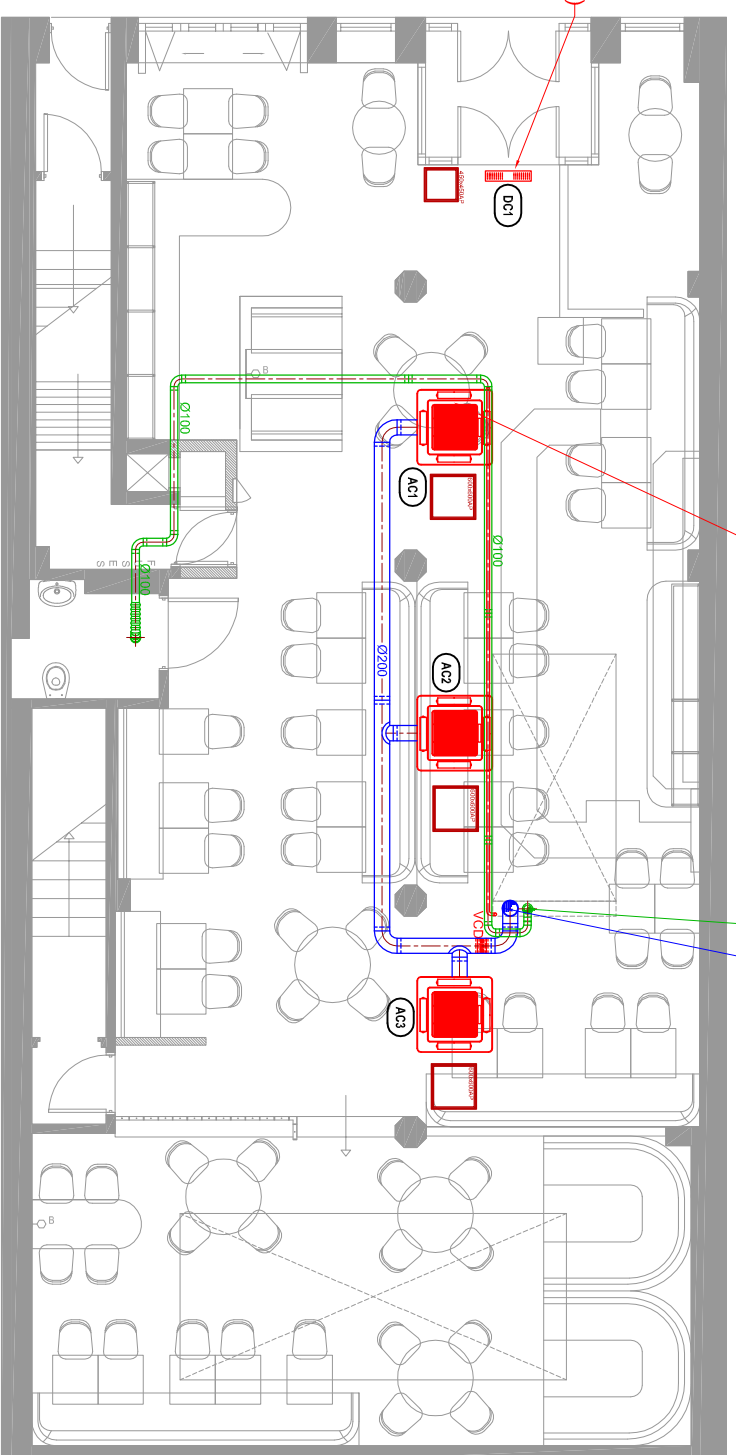

# First Floor

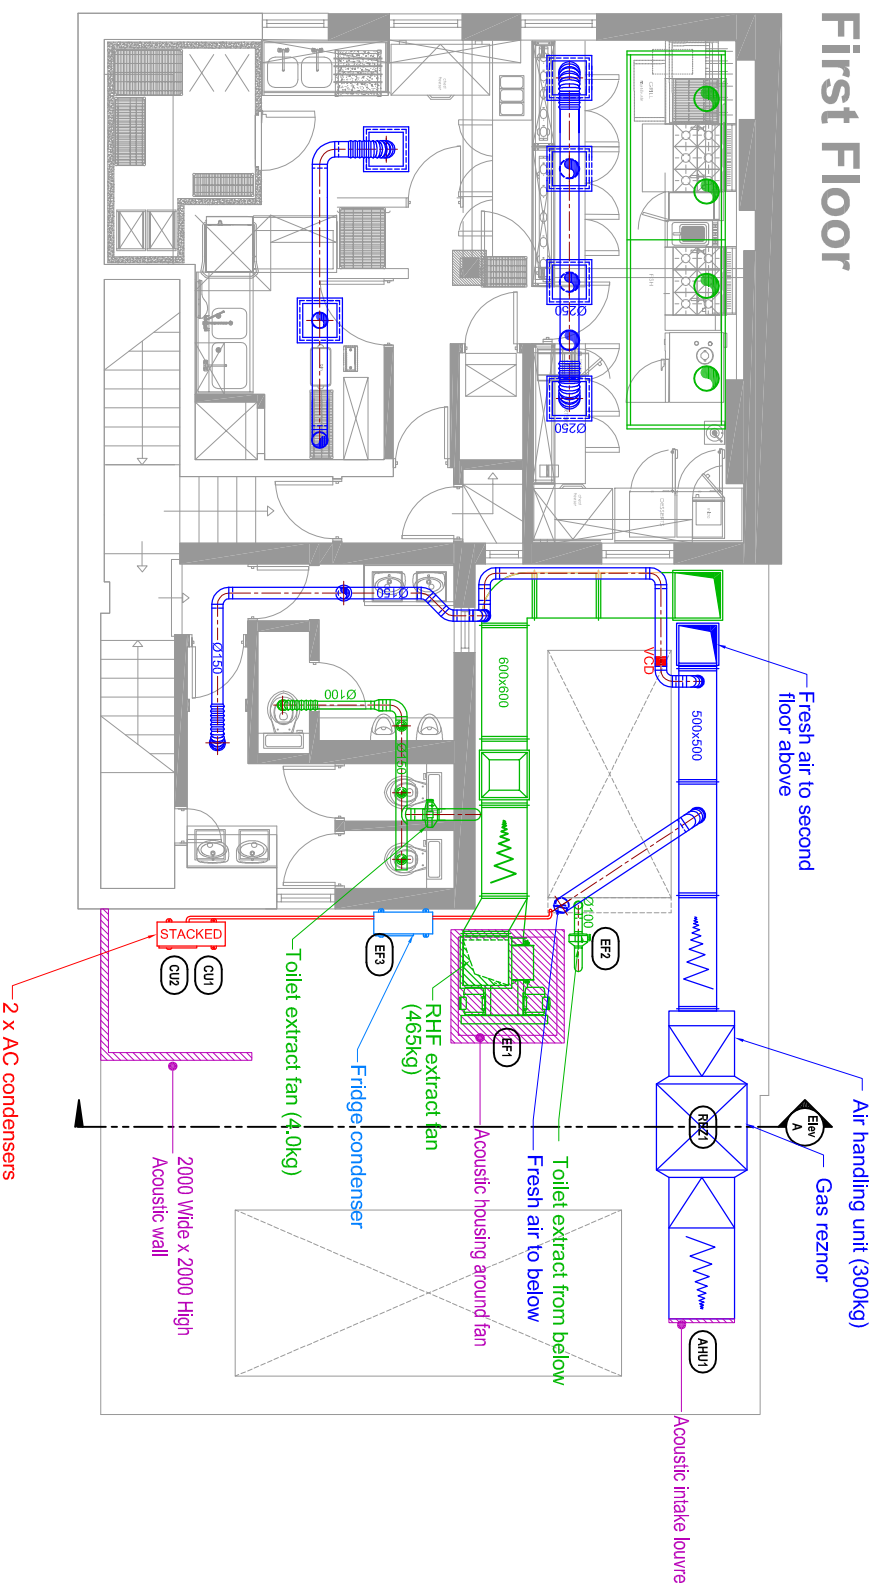

# Second Floor

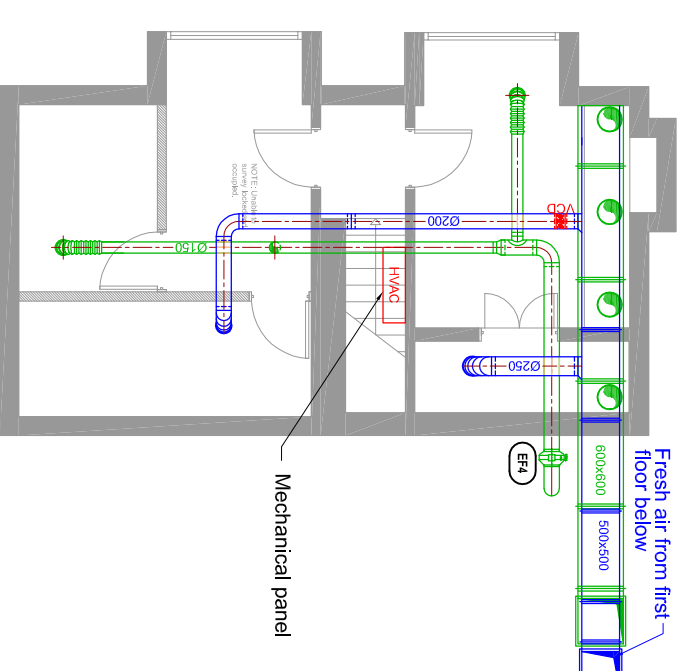

No.	Date	Rev	Revision Description	By	Chd
1	13/02/15	CS	Attenuators added, WC extract		
H	28/08/14	RF	Added acoustic intake louvre.		
G	27/08/14	RF	Revised AC noise.		
F	28/08/14	RF	Added acoustic housing.		
E	07/03/12	DH	As Filled		
D	30/01/12	SC	Canopy move 100mm to the		
C	25/01/12	SC	As per architect removal. Amendments		
B	19/01/12	SC	to A/C approval		
A	11/01/12	SC	Amendments to ventilation		
			scheme, catering layout added		
			Reviewed architects layout		

Project :  
**CÔTE**  
 Cote Restaurant  
 Camden  
 London

Drawing Title :  
**VENTILATION LAYOUT**  
 Basement, Ground,  
 First & Second Floor

Drawing No.:  
**COT10-01**  
 Scale: @A1 = 1:50 @A3 = 1:100  
 Drawn By: DAN  
 Date: 01-12-11

**chappman**  
 ventilation

Unit 2, Mill Lane  
 Wilton, Gosport, City  
 of Southampton, Hants  
 SO9 4LW  
 Tel: 01703 272888 Fax: 01703 252601  
 Email: info@chappmanventilation.co.uk  
 Web: www.chappmanventilation.co.uk

Copyright of this drawing resides with Chappman Ventilation Limited