


2 GROUND FLOOR - FURNITURE, FIXTURES, AND EQUIPMENT PLAN  
Scale: 1 : 50

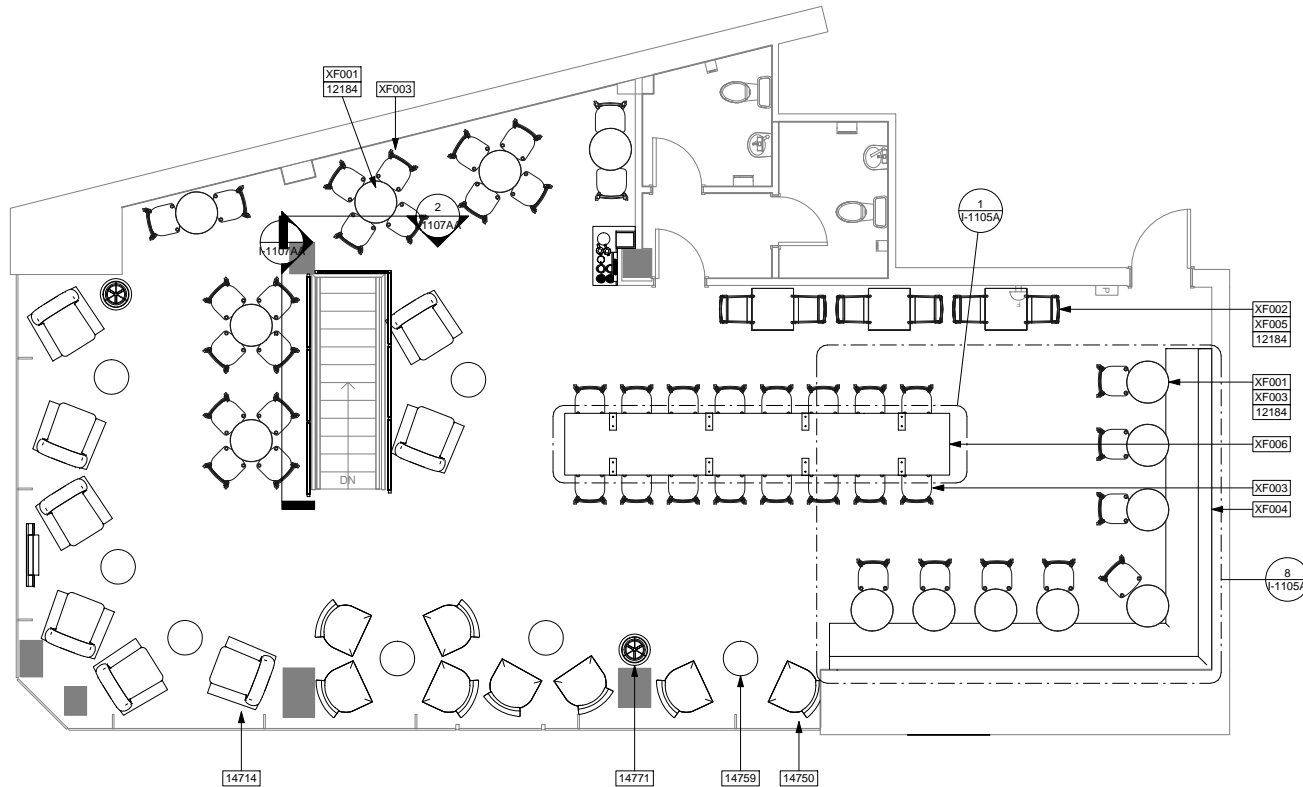

1 1ST FLOOR - FURNITURE, FIXTURE, AND EQUIPMENT PLAN  
Scale: 1 : 50

**SHEET NOTES**

1. ALL RETAINED AND RELOCATED ITEMS INDICATED IN BLUE. GENERAL CONTRACTOR TO SCHEDULE WITH LOCAL REFRIGERATION CONTRACTOR TO CONDUCT INITIAL FOOD CASE START-UP AND TESTING. FOR APPROVED CONTRACTOR, CONTACT VENDOR.
2. THE SPACE IS SERVED BY THE MUNICIPAL WATER AND SEWER SYSTEM UNLESS OTHERWISE NOTED.
3. ALL EQUIPMENT AND INSTALLATION WILL MEET NATIONAL SANITATION FOUNDATION STANDARDS OR EQUIVALENT.
4. EQUIPMENT UNITS SHALL CONTAIN NO EXPOSED THREADS, EMBELLISHMENTS OR OVERHANGING EDGES THAT SERVE AS PLACES FOR ACCUMULATION OF DUST, DIRT AND DEBRIS.
5. WARMING OVEN(S) SHOWN FOR PERMITTING PURPOSES. INSTALLATION AT STORE OPENING TO BE VERIFIED BY STARBUCKS CONSTRUCTION REPRESENTATIVE.
6. EACH HAND WASHING SINK WILL HAVE A SINGLE SERVICE TOWEL AND SOAP DISPENSER, AND ALL HAND SINKS TO HAVE A COMBINATION FAUCET OR PREMIXING FAUCET.
7. FOR PLUMBING FIXTURES, REFER TO THE PLUMBING DESIGN PLAN. FOR DATA DEVICE SCHEDULE, REFER TO THE ELECTRICAL DESIGN PLAN

**FF AND E PLAN NOTES**

FURNITURE SCHEDULE - "F"				
DESIGN ID	COUNT	DESCRIPTION	RESP.	COMMENTS
12184	21	Table - Cafe Base - 12x28in - Hot Rolled Steel	SBUX	
XF005	3	RETAINED EXISTING SQUARE CAFE TABLE	SBUX	INDICATED IN BLUE
<b>BANQUETTE</b>				
XF004	1	BANQUETTE : CREST LEATHER COLLECTION TWO CAMBRIDGE MUSHROOM - PLINTH TO MATCH EXISTING SKIRTING FINISH	SBUX	SEE FF AND DETAILS FOR DIMENSIONS
<b>CHAIR</b>				
12146	12	CHAIR - CAFE SLATTED METAL SUITE WITH ARMS - BLACK MT0028	SBUX	
12181	4	CHAIR - STOOL 29IN 735MM INDUSTRIAL - DISTRESSED DARK BROWN PRESSBOARD WD0012	SBUX	
14714	8	CHAIR - LOUNGE CLUB WITH ROUNDED BACK - BLACK AND BROWN BLACK FLAT WD0061 F0086	SBUX	
14750	8	CHAIR - LOUNGE ARMLESS WITH NAILHEAD BACK - SEPIA WOVEN F0102	SBUX	
14752	2	CHAIR - LOUNGE BEAN - DEEP GREEN PLUSH F0399	SBUX	
14753	3	CHAIR - LOUNGE BEAN - BLACK SPECKLED PATTERN F0104	SBUX	
XF002	6	RETAINED TUBULAR METAL UPHOLSTERED IN RED	SBUX	INDICATED IN BLUE
XF003	56	RETAINED EXISTING CAFE CHAIRS	SBUX	INDICATED IN BLUE
<b>COMMUNITY TABLE</b>				
XF006	1	COMMUNITY TABLE - 5610 X 900MM	SBUX	SEE DETAILS @ I-1105A - WD0054 TOP SURFACE WITH MT0019 LEGS
<b>TABLE</b>				
12184	3	TABLE - BASE CAFE DOME ACCENT - 12X28IN 305X710MM - HOT ROLLED STEEL MT0011	SBUX	
14746	6	TABLE - BASE CAFE X BASE 23X28IN 580X710MM - BLACK MT0028	SBUX	
14759	7	TABLE - OCCASIONAL X BASE WITH ROUND TOP - 20IN 500MM - GOLDEN BLONDE WD0054	SBUX	
14761	3	TABLE - TOP ROUND - 18IN 455MM - GOLDEN BLONDE WD0054	SBUX	
14766	6	TABLE - TOP ROUND - 24IN 610MM - BLACK WD0061	SBUX	
XF001	18	Retained Existing Table Top	SBUX	INDICATED IN BLUE
XF007	1	RETAINED PERCH TABLE WITH LEGS	SBUX	INDICATED IN BLUE

SPECIALTY EQUIPMENT SCHEDULE - "E"				
DESIGN ID	COUNT	DESCRIPTION	RESP.	COMMENTS
<b>COOLING</b>				
10267	1	FRIDGE UNDERCOUNTER 1 DOOR - 27IN 685MM	SBUX	
10473	1	FRIDGE UNDERCOUNTER 2 DOOR - 48IN 1220MM	SBUX	
14065	1	FRIDGE UNDERCOUNTER 2 DOOR WITH LOCK - 48IN 1220MM		
<b>EQUIPMENT</b>				
10724	1	GRINDER GRINDMASTER		
10856	2	BREWER SERVER SOFT HEAT		
12407	1	OVEN TURBOCHEF NEXT GENERATION		
12508	2	BLENDER QUIET MODEL ON COUNTER		
12694	3	ESPRESSO MACHINE MASTRENA		
XE001	1	TALLBOY MULTIDECK PRO 1200	SBUX	
<b>FOOD CASE</b>				
12912	1	FOOD CASE - SERVICE AMBIENT - 35IN 900MM - SST		
<b>ICE</b>				
10344	1	ICE - BIN DROP IN 90LB 40KG		
<b>OTHER</b>				
10314	1	SCALE DIGITAL WITH ADJUSTABLE DISPLAY MOUNT		
11115	1	SOAP DISPENSER SINK MOUNTED		
<b>STORAGE</b>				
10416	1	WORKROOM WIRE SHELVING		
10462	1	WORKROOM WIRE SHELVING POSTS		
10698	1	MOP RACK WITH 3 HOLDERS		



**Starbucks Coffee Company**  
Building 4, Chiswick Park  
566 Chiswick High Road  
London, W4 5YE

These Drawings and Specifications are confidential and shall remain the sole property of Starbucks Corporation, which is the owner of the copyright in this work. They shall not be reproduced (in whole or in part), shared with third parties or used in any manner on other projects or extensions to this project without the prior written consent of Starbucks Corporation. These drawings and specifications are intended to express Design Intent for a prototypical Starbucks store (which is subject to change at anytime) and do not reflect actual site conditions. Neither party shall have any obligation nor liability to the other (except as stated above) until a written agreement is fully executed by both parties.

**Architect of Record**

This drawing is a Design Development Document. Site specific modifications made under the responsible charge of the Architect and/or Engineer-of-Record will be required prior to using this document for Bidding, Permitting, or Construction.

**Revision Schedule**

Rev	Date	By	Description

Project Name:  
**STARBUCKS - NEW OXFORD STREET**  
112-116 NEW OXFORD STREET,  
LONDON, WC1A 1HH

Store #: 12214  
Project #: 08163-035  
Concept: MCS  
Palette: REG MODERN  
Issue Date: 19 - 02 - 2015  
Design Manager: LEON FIELDING  
LEED® AP: N/A  
Production Designer: GD / EVOLVE  
Checked by: LF

Sheet Title:  
**FF AND E PLAN**

Scale: 1 : 50

Sheet Number:  
**I-1105**

Design Documents Only - Not Intended for Construction