


NOTE: XD-TYPE FITTINGS TO BE PROVIDED WITH J-BOLT BASE UNIT TO BE MOUNTED USING CONCRETE POUR, SUITABLE CONCRETE SLURRY BASE TO BE PROVIDED BY CONTRACTOR AND CONCEALED FROM VIEW AS APPROPRIATE.

NOTE: XB INGROUND UP LIGHTS SUPPLIED WITH INSTALLATION SLEEVE AND REMOTE DRIVER WITHIN IP67 ENCLOSURE. LUMINAIRE ETO BE MANUFACTURERS INSTRUCTIONS.

NOTE TYPE XD AND XA LOCAL TO BIN STORE TO BE PIR OPERATED..

NOTE: XA SURFACE MOUNTED WALL LUMINAIRE AFFIXED TO GATE POST.

NOTE: ALLOWANCE TO BE MADE FOR LIGHTING WITHIN BIN STORE. DETAIL TO BE PIR OPERATED.

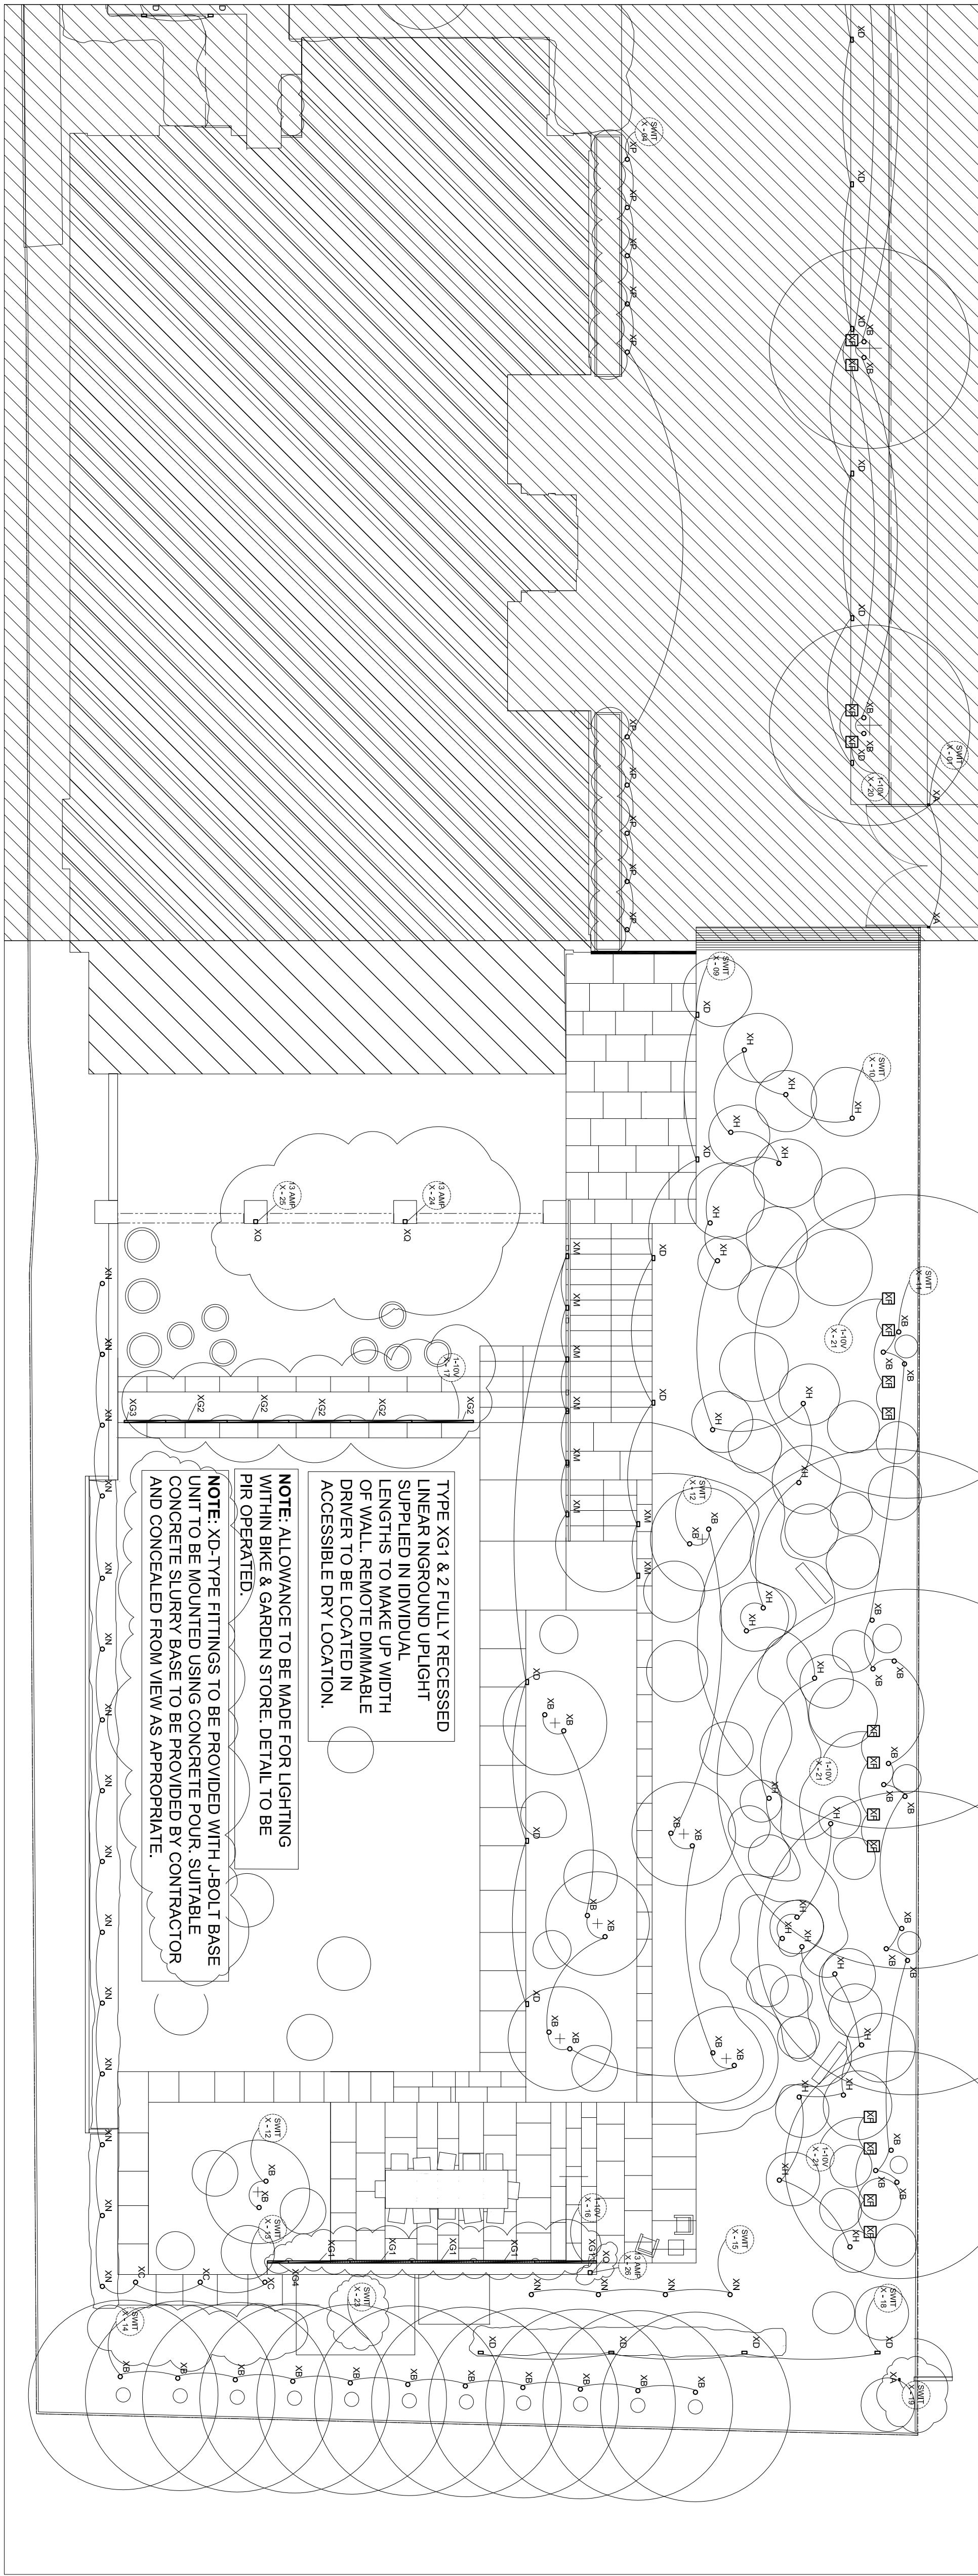

TYPE XG1 & 2 FULLY RECESSED LINEAR INGROUND UP LIGHT SUPPLIED IN INDIVIDUAL LENGTHS TO MAKE UP WIDTH OF WALL. REMOTE DIMMABLE DRIVER TO BE LOCATED IN ACCESSIBLE DRY LOCATION.

NOTE: ALLOWANCE TO BE MADE FOR LIGHTING WITHIN BIKE & GARDEN STORE. DETAIL TO BE PIR OPERATED.

NOTE: XD-TYPE FITTINGS TO BE PROVIDED WITH J-BOLT BASE UNIT TO BE MOUNTED USING CONCRETE POUR, SUITABLE CONCRETE SLURRY BASE TO BE PROVIDED BY CONTRACTOR AND CONCEALED FROM VIEW AS APPROPRIATE.

TYPE A - SURFACE MOUNTED WALL IP RATED WALL LUMINAIRE WITH INTEGRAL DRIVER

TYPE XB - FULLY RECESSED IP67 INGROUND UP LIGHT LUMINAIRE WITH REMOTE DRIVER

TYPE XC - FULLY RECESSED IP67 INGROUND UP LIGHT LUMINAIRE WITH REMOTE DRIVER

TYPE XD - EXTERIOR ILLUMINATED BOLLARD

TYPE XF - TREE MOUNTED IP RATED LED PROJECTOR WITH INTEGRAL DRIVER. DIMMABLE SOURCE.

TYPE XG1 & 2 - FULLY RECESSED LINEAR LED UP LIGHT LUMINAIRE WITH REMOTE DIMMABLE DRIVER.

TYPE XH - IP RATED SPIKE MOUNTED PROJECTOR 1200. FITTINGS TO OPERATE OFF SINGLE REMOTE DRIVER.

TYPE XI - IP RATED BATTEN LUMINAIRE INTEGRATED WITH BIKE AND BIN STORES.

TYPE XM - RECESSED IP RATED LED WALL LUMINAIRE. REMOTE DRIVER.

TYPE XN - IP RATED SPIKE MOUNTED PROJECTOR 1200. FITTINGS TO OPERATE OFF SINGLE REMOTE DRIVER.

TYPE XP - RECESSED INGROUND IP RATED LED MARKER LIGHTS. REMOTE DRIVER.

A - REVISIONS CLOUDED		13.01.15	EH
REVISION	DATE	BY	

NOTE:
This drawing is to be used in conjunction with PRITCHARDTHEMIS LTD specification schedule.

THIS DRAWING IS THE PROPERTY OF PRITCHARDTHEMIS LTD.
All copyright is reserved and the drawings is issued on the condition that it is not copied, reproduced, retained or disclosed to any unauthorised person without the consent of PRITCHARDTHEMIS LTD.

All electrical work associated with this drawing is to be in accordance with the latest edition of IEE wiring regulations.

CLIENT:
MR AND MRS NATSIS

PROJECT:
TEMPLEWOOD AVENUE

DRAWING TITLE:
LANDSCAPE LIGHTING LAYOUT

DRAWING NO.: PTL473-p06
JOB NO.: PTL473

SCALE: 1:100
DATE: 17.12.14

REVISION NO.: A
BY: EH

prichard themis
lighting design

3rd floor
2, Pavilion
e23a 5lp
t: 03 44 (0) 2076 600 700
f: 03 44 (0) 2076 600 701
e: info@prichardthemis.com