



NOTES
 1. This drawing must not be scaled
 2. The contractor is to check all dimensions on site

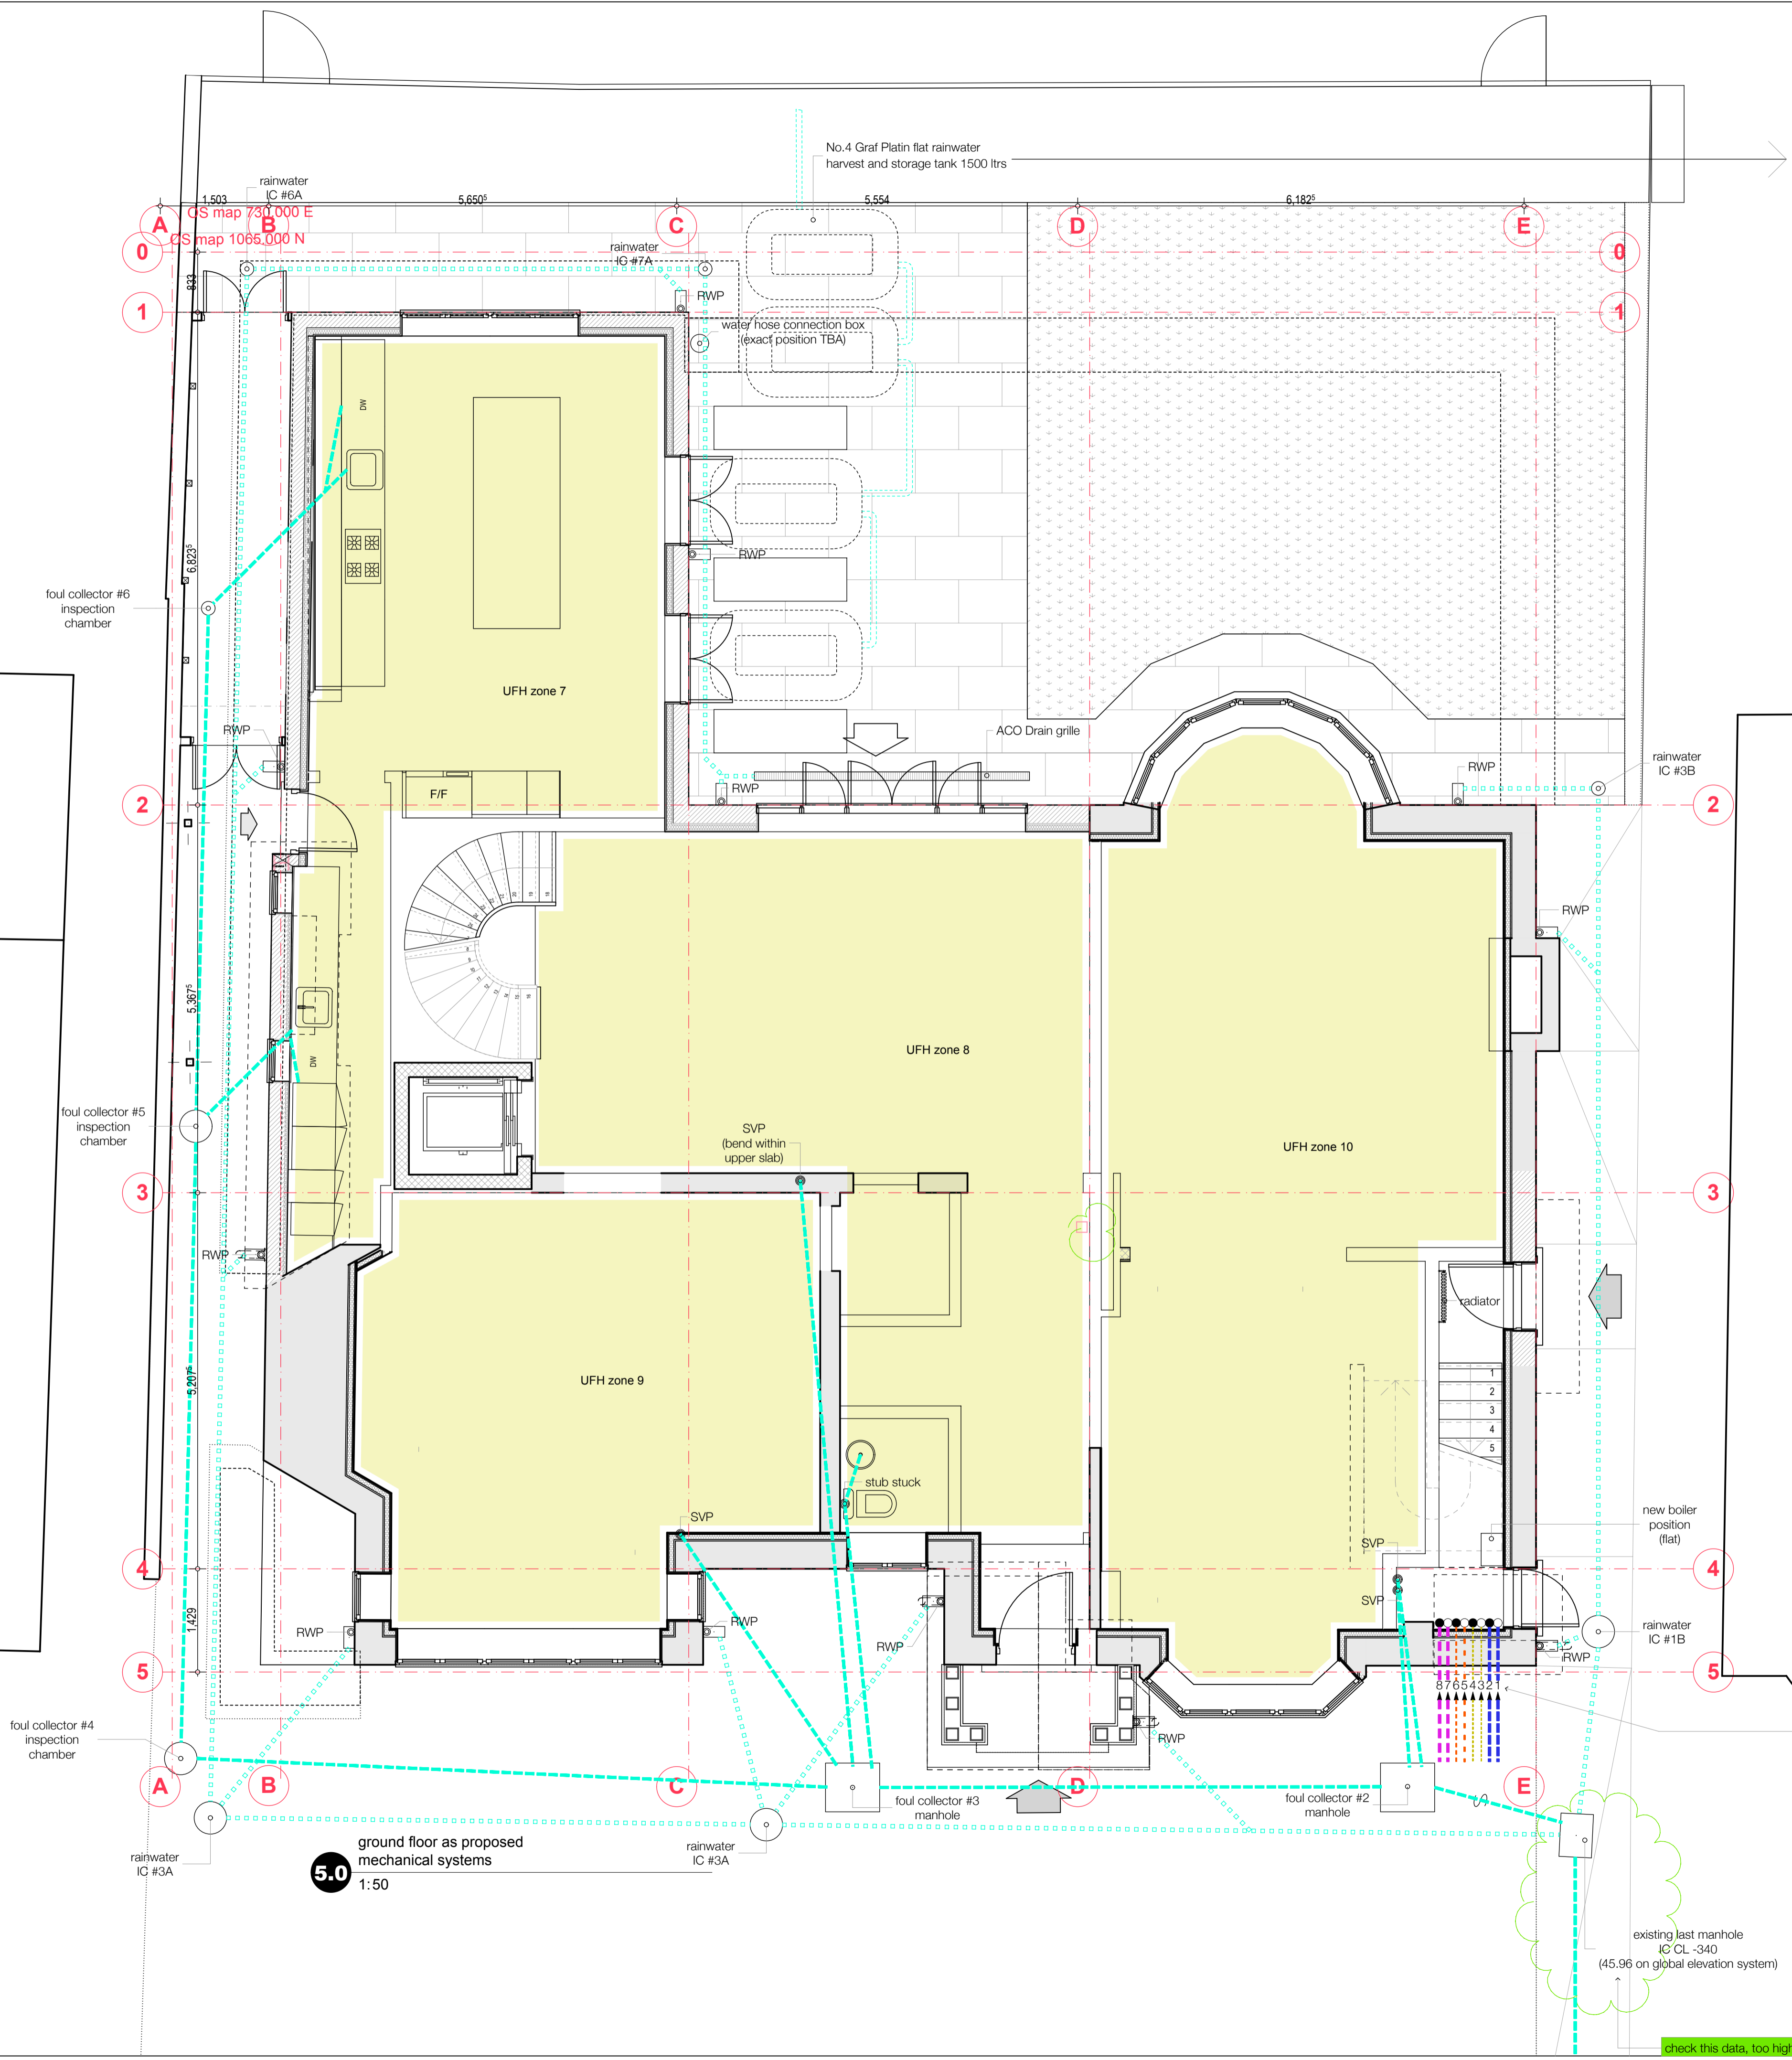

	D GRAF Regenwasser Flachtank Platin 1500 L		Artikel-Nr. article no. 390000
	GB GRAF Platin flat tank 1500 L	ES GRAF Depósito de poco profundidad Platin 1500 L	FR GRAF Cuve à enterrer Platine 1500 L

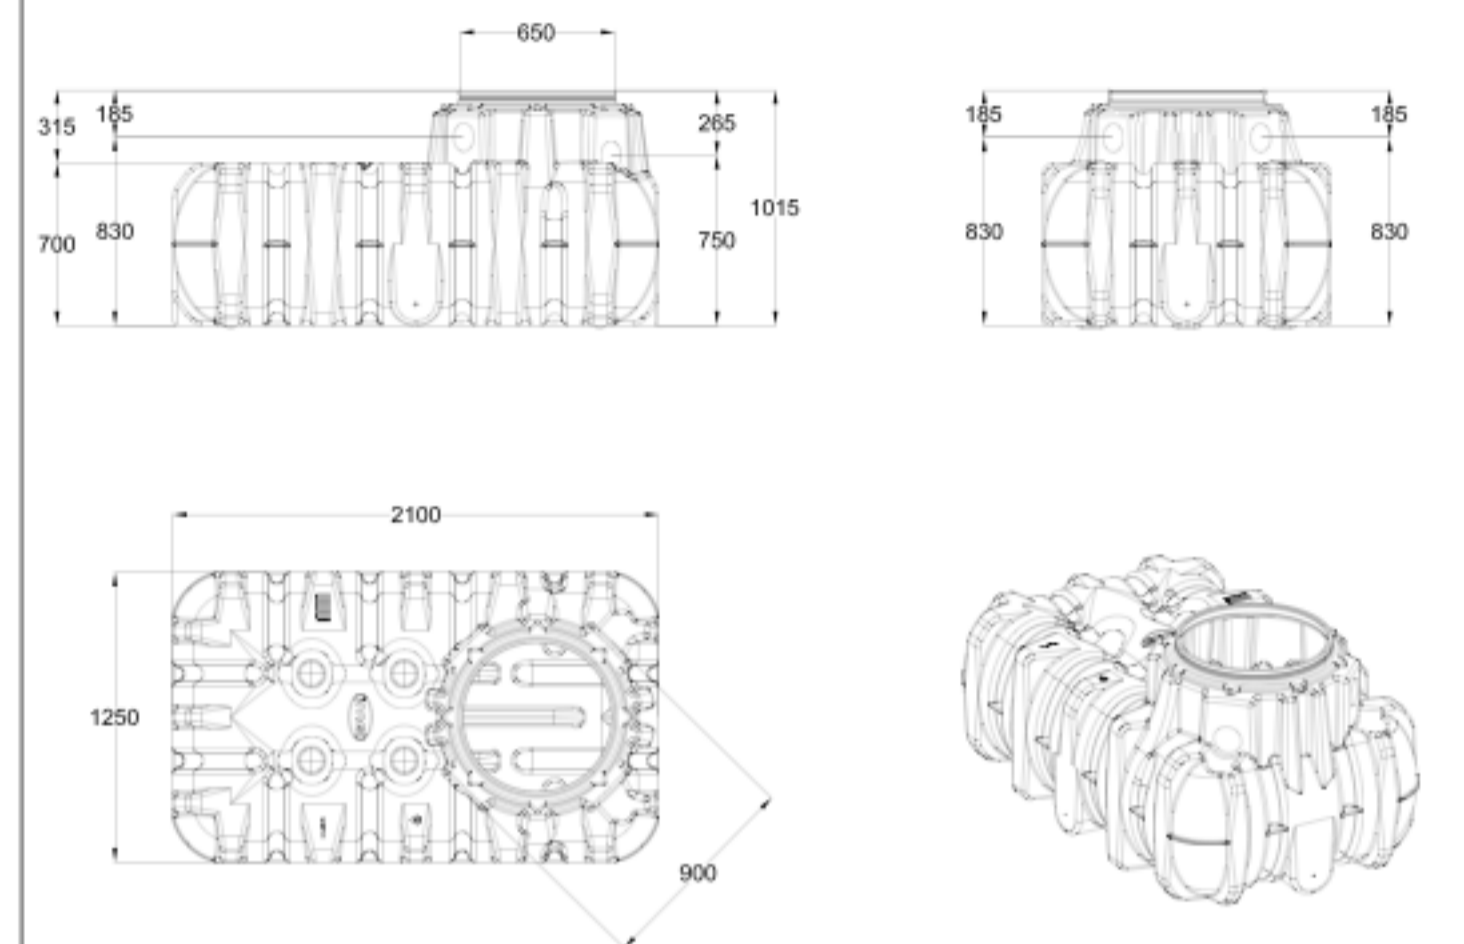

Otto Graf GmbH Carl-Zeiss-Str. 2-6 DE-79331 Teningen Germany info@graf.info www.graf.info	Zeichnungsinformation drawing information		Artikelinformation article information
	gezeichnet drawn NRE	Gewicht weight ca. 82 kg	
	Datum date 29.11.12		
	Toleranz tolerance +/- 3 %		Alle Maßangaben in mm all dimension in mm

- SERVICES SUPPLY
1. new water supply to house
 2. new water supply to flat
 3. new gas supply to house
 4. new gas supply to flat
 5. new electric 3 Phase supply to house
 6. new electric Single Phase supply to flat
 7. ø 100mm duct for future cable & data supply to house
 8. ø 100mm duct for future cable & data supply to flat

dwg type	mechanical systems
dwg status	F - production information
Sacks Maguire Architects	
155A Regents Park Road London NW1 8BB	tel 020 7722 9298 fax 020 7586 9059
Project 56 Elsworth Road, London NW3 3BU	
Client Mr Lasha Papashvili	
Title ground floor plan	
scale see each drw	drawn MF
job number	drawing number
477	MEC 003
date 13/03/2015	issue
	p