



Ordnance Survey, (c) Crown Copyright 2013. All rights reserved. Licence number 100022432

 
1 SITE LOCATION PLAN
1:1000

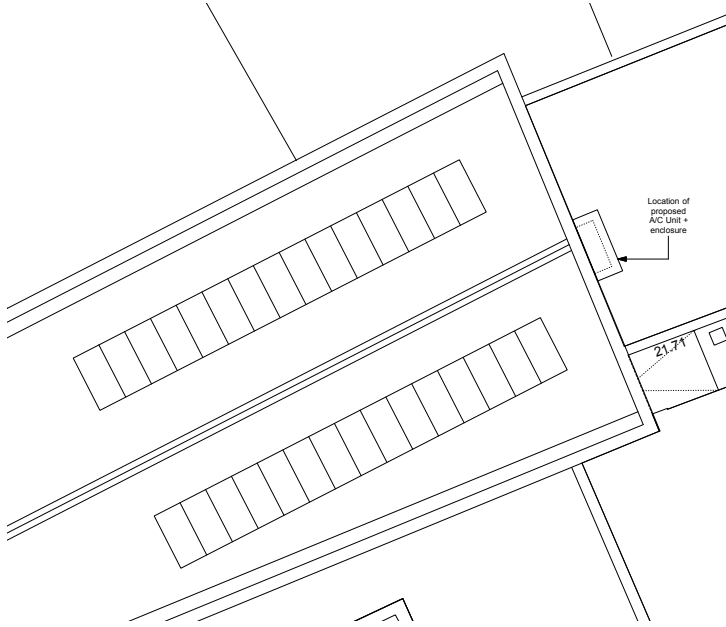

2 A/C UNIT LOCATION
1:100

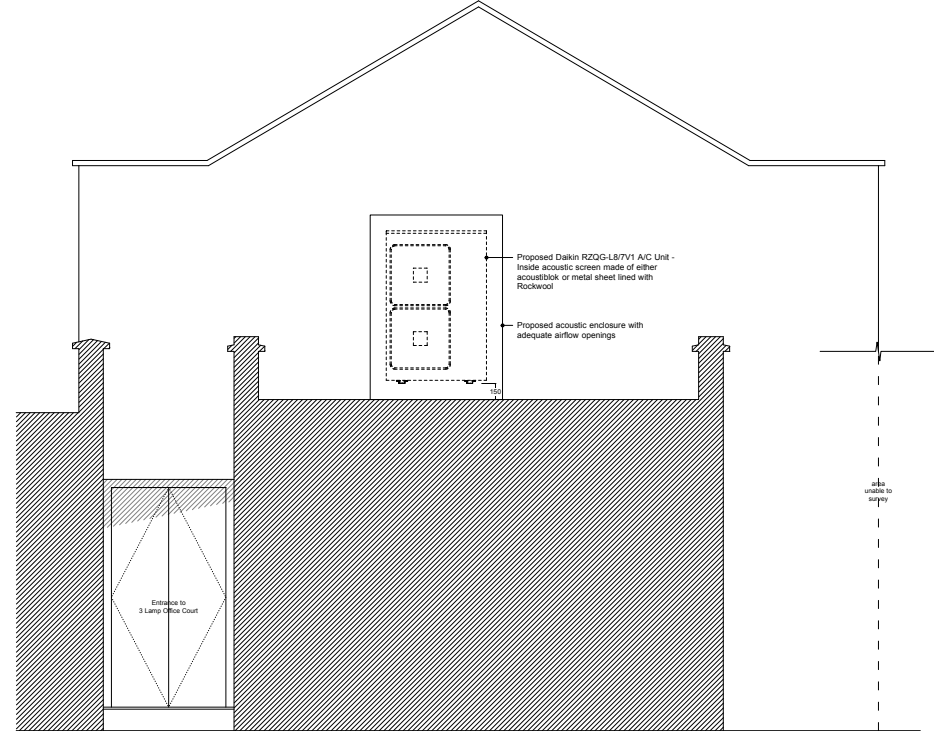

3 EAST ELEVATION
1:50



Ben Pentreath & Associates <small>49 Lamb Conduit St, London WC1N 3NG telephone 0207 430 2424 benpentreath.com</small>	
Project: 3 LAMP OFFICE COURT - A/C UNIT LOCATION	
Title: PROPOSED DRAWINGS	
Dwg No: A-100	Rev: A/c -
Scale: 1:50@A3	Drawn by: MU
Date: 04.15	Checked by: RI
<small>All designs © Ben Pentreath Ltd/Ben Pentreath & Associates 2014 Not to be reproduced without permission</small>	