


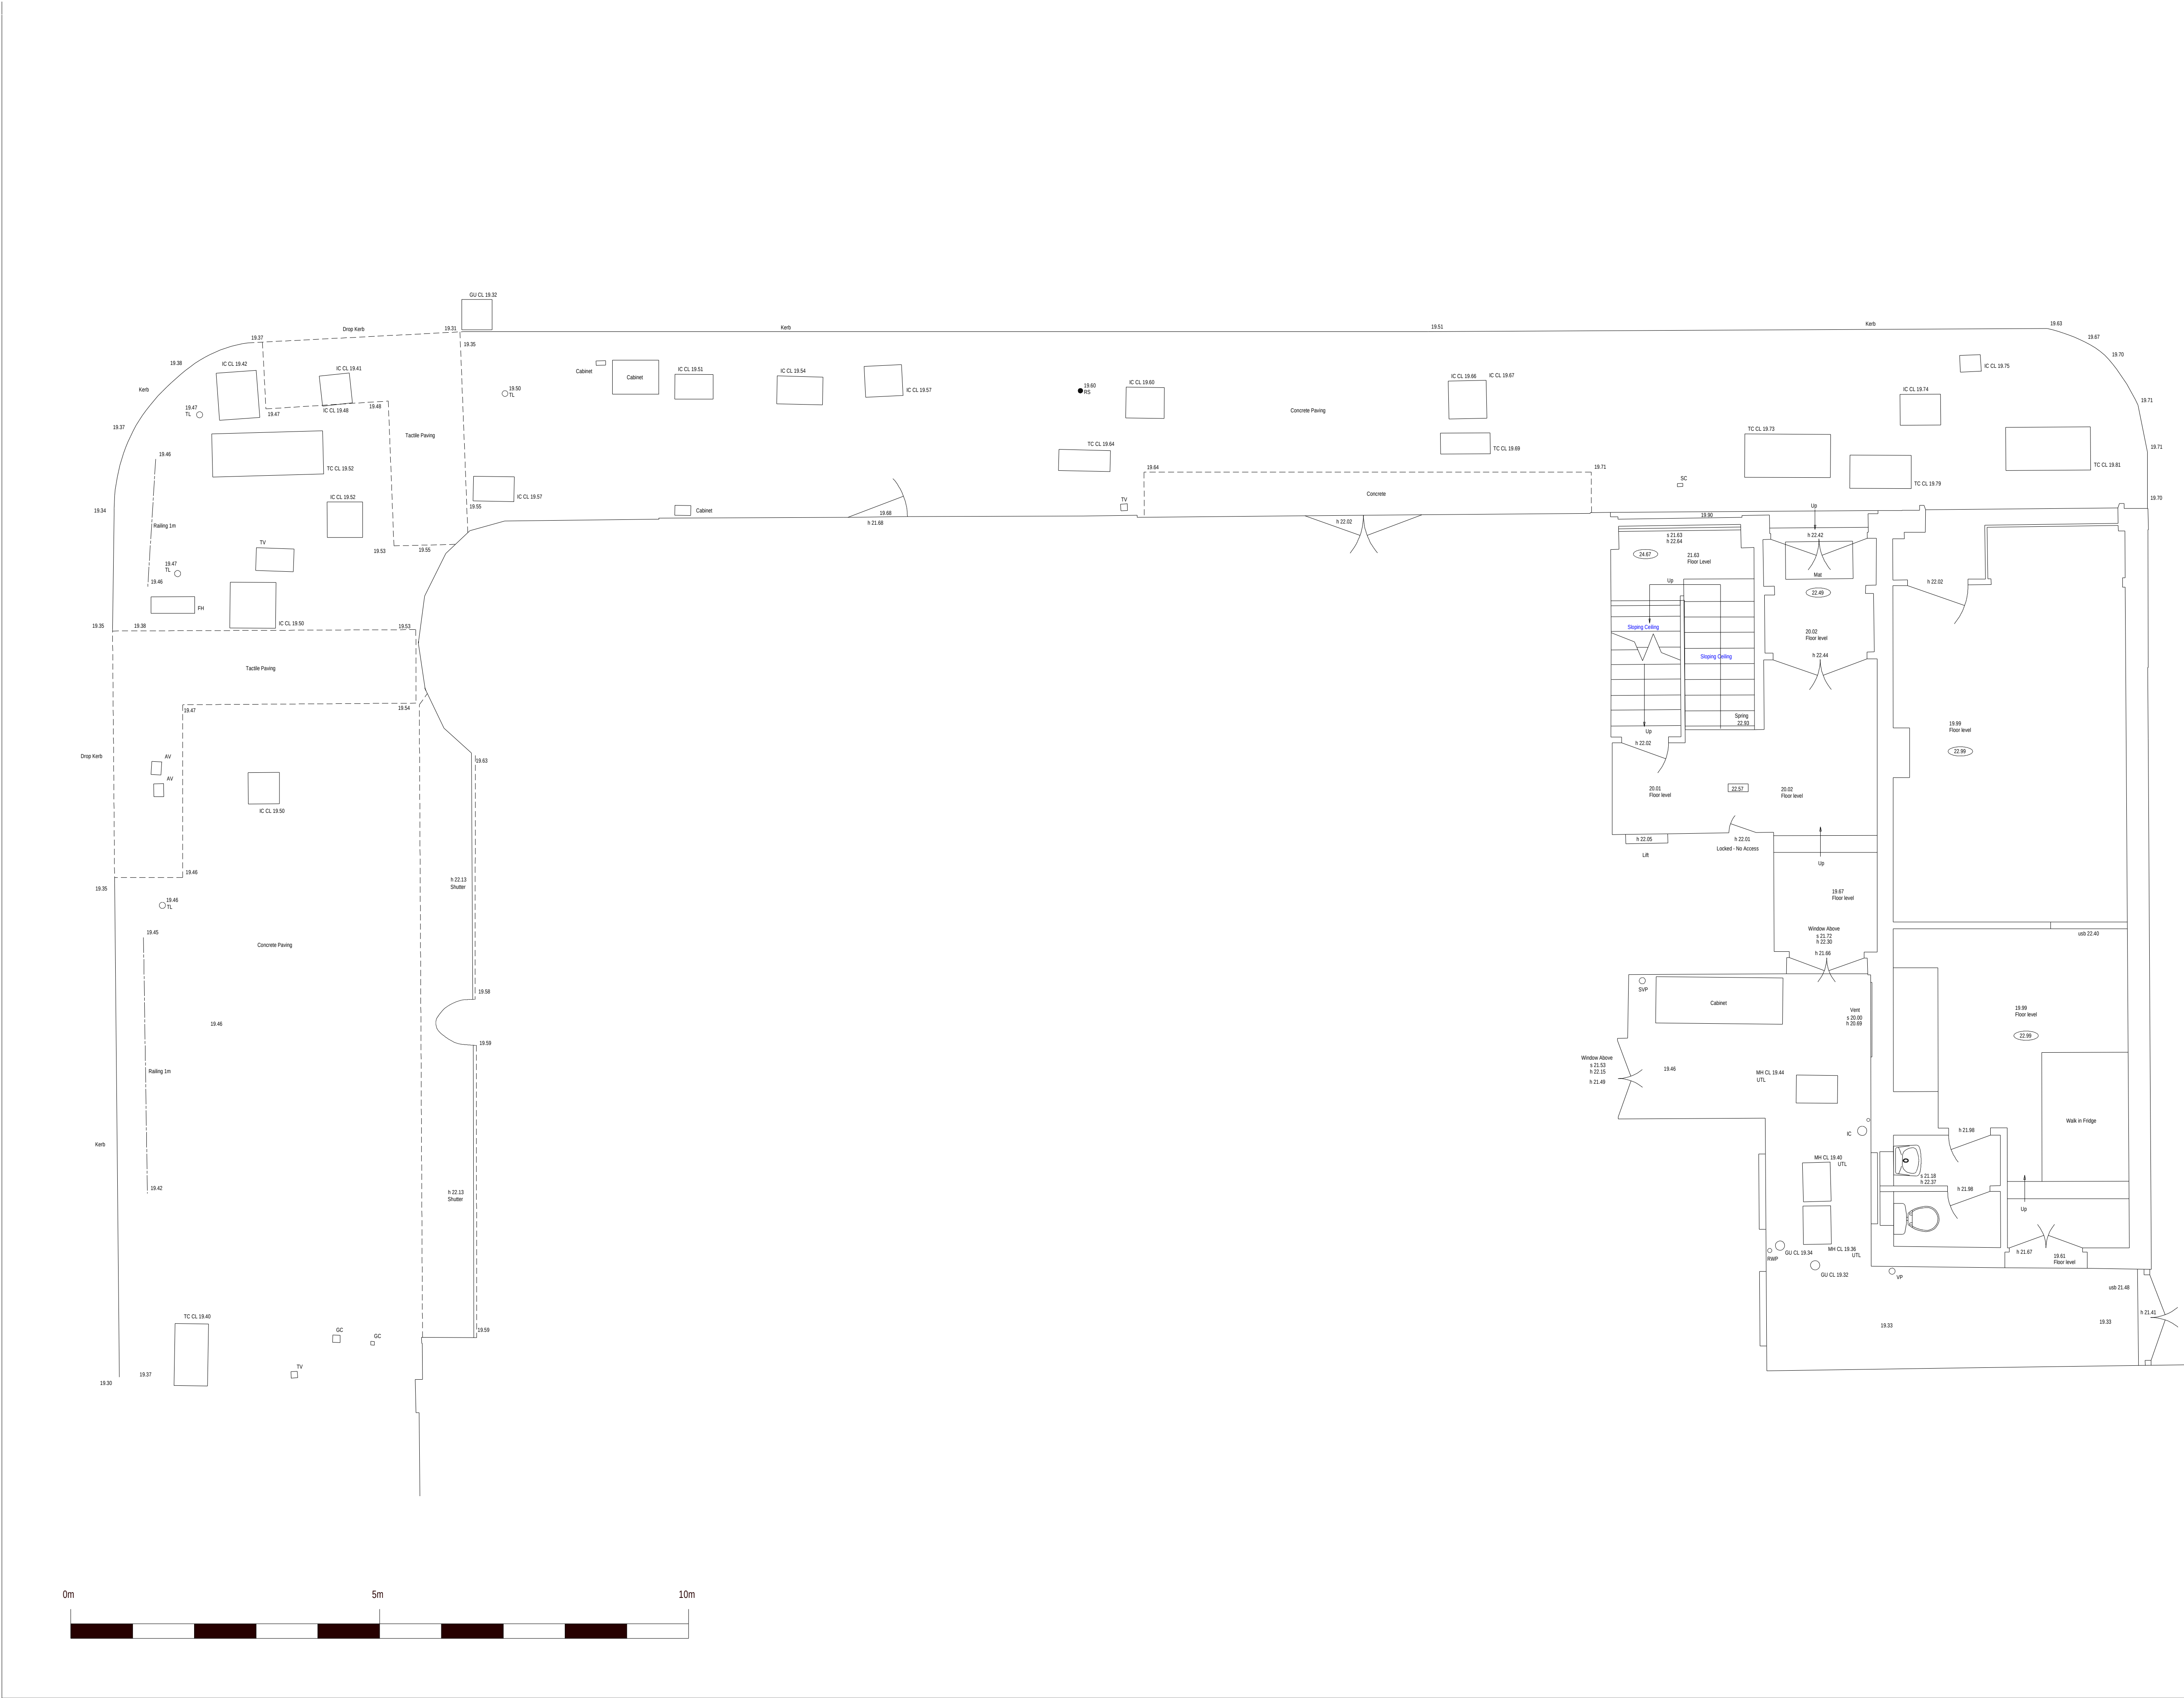

NOTES

1 LEVELS ARE RELATED TO STATION ONE.

ASSUMED LEVEL 20.00 METRES.

2 SURVEY HAS BEEN CARRIED OUT TO AN ACCURACY COMMENSURATE WITH A 1:50 SCALE DRAWING.

ABBREVIATION LIST

ELECTRICS

AC AIR CONDITIONING VENTS OR EQUIPMENT
DP DOUBLE PLUG
ELS EMERGENCY LIGHT SWITCH
EP ELECTRIC POINT
ESM ELECTRIC SWITCH MACHINE
FA FIRE ALARM
FS FUSED ELECTRIC SWITCH
JB JUNCTION BOX
L LIGHT
LCB LIFT CALL BUTTON
LS LIGHT SWITCH
SP SINGLE PLUG
WL WALL LIGHT

WHERE THESE ARE FOLLOWED BY A MEASUREMENT, THIS IS THE HEIGHT FROM FLOOR.

GENERAL

AC AIR CONDITIONING VENTS OR EQUIPMENT
ER EARTHING ROD
GU GULLY
IC INSPECTION COVER
MH MANHOLE
ST STANCHION
SVP SOIL AND VENT PIPE

±1.00 SILL LEVEL
h 1.00 HEAD LEVEL
u/s 1.00 LEVEL OF UNDERSIDE OF BEAM
u/s 1.00 LEVEL OF UNDERSIDE OF DUCTING
u/s 1.00 LEVEL OF UNDERSIDE OF PIPE
u/s 1.00 UNDERSIDE LEVEL

±2.48 CEILING LEVEL
±2.14 FALSE CEILING LEVEL

NO.	DATE	DETAILS

REVISIONS

NO. DATE DETAILS

KND SURVEYS LTD

74 WATCHET LANE
HOLMER GREEN
HIGH WYCOMBE
BUCKINGHAMSHIRE
HP15 6UG

Tel: 01494 718453
Fax: 01494 717576
e-mail: enquiry@kndsveys.com

CLIENT

SEYMAC 80 LTD
4A LYNDRIST GARDENS
LONDON
NW3 5NR

JOB TITLE

122 - 126 KILBURN HIGH ROAD
NW6

DRAWING TITLE

SITE SURVEY & GROUND FLOOR PLAN

DRAWING No.	DRAWN BY	DATE
K 07 07 G	RJG	07 NOV 2007

SURVEYED BY	SCALE
RJG / PSW	1:50