

LIGHTING LEGEND

REF	SYMBOL	DESCRIPTION
A		Downlight
B		Directional Downlight
C		Floor Recessed Uplight
D		LED Striplight - Warm White
E		Chandelier Point


Disclaimer

The contractor is to check all dimensions on site and inform the contract administrator/project manager of any discrepancies.

All work is to comply in every aspect with the Building Regulations, Codes of Practice and British Standards.



This drawing is to be read in conjunction with all other contract drawings and specifications.

This drawing is copyrighted and must not be reproduced in any format or disclosed to any third party without the written consent of Tuffin Ferraby Taylor LLP.

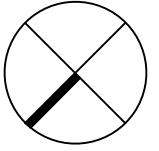

rev date details

 by

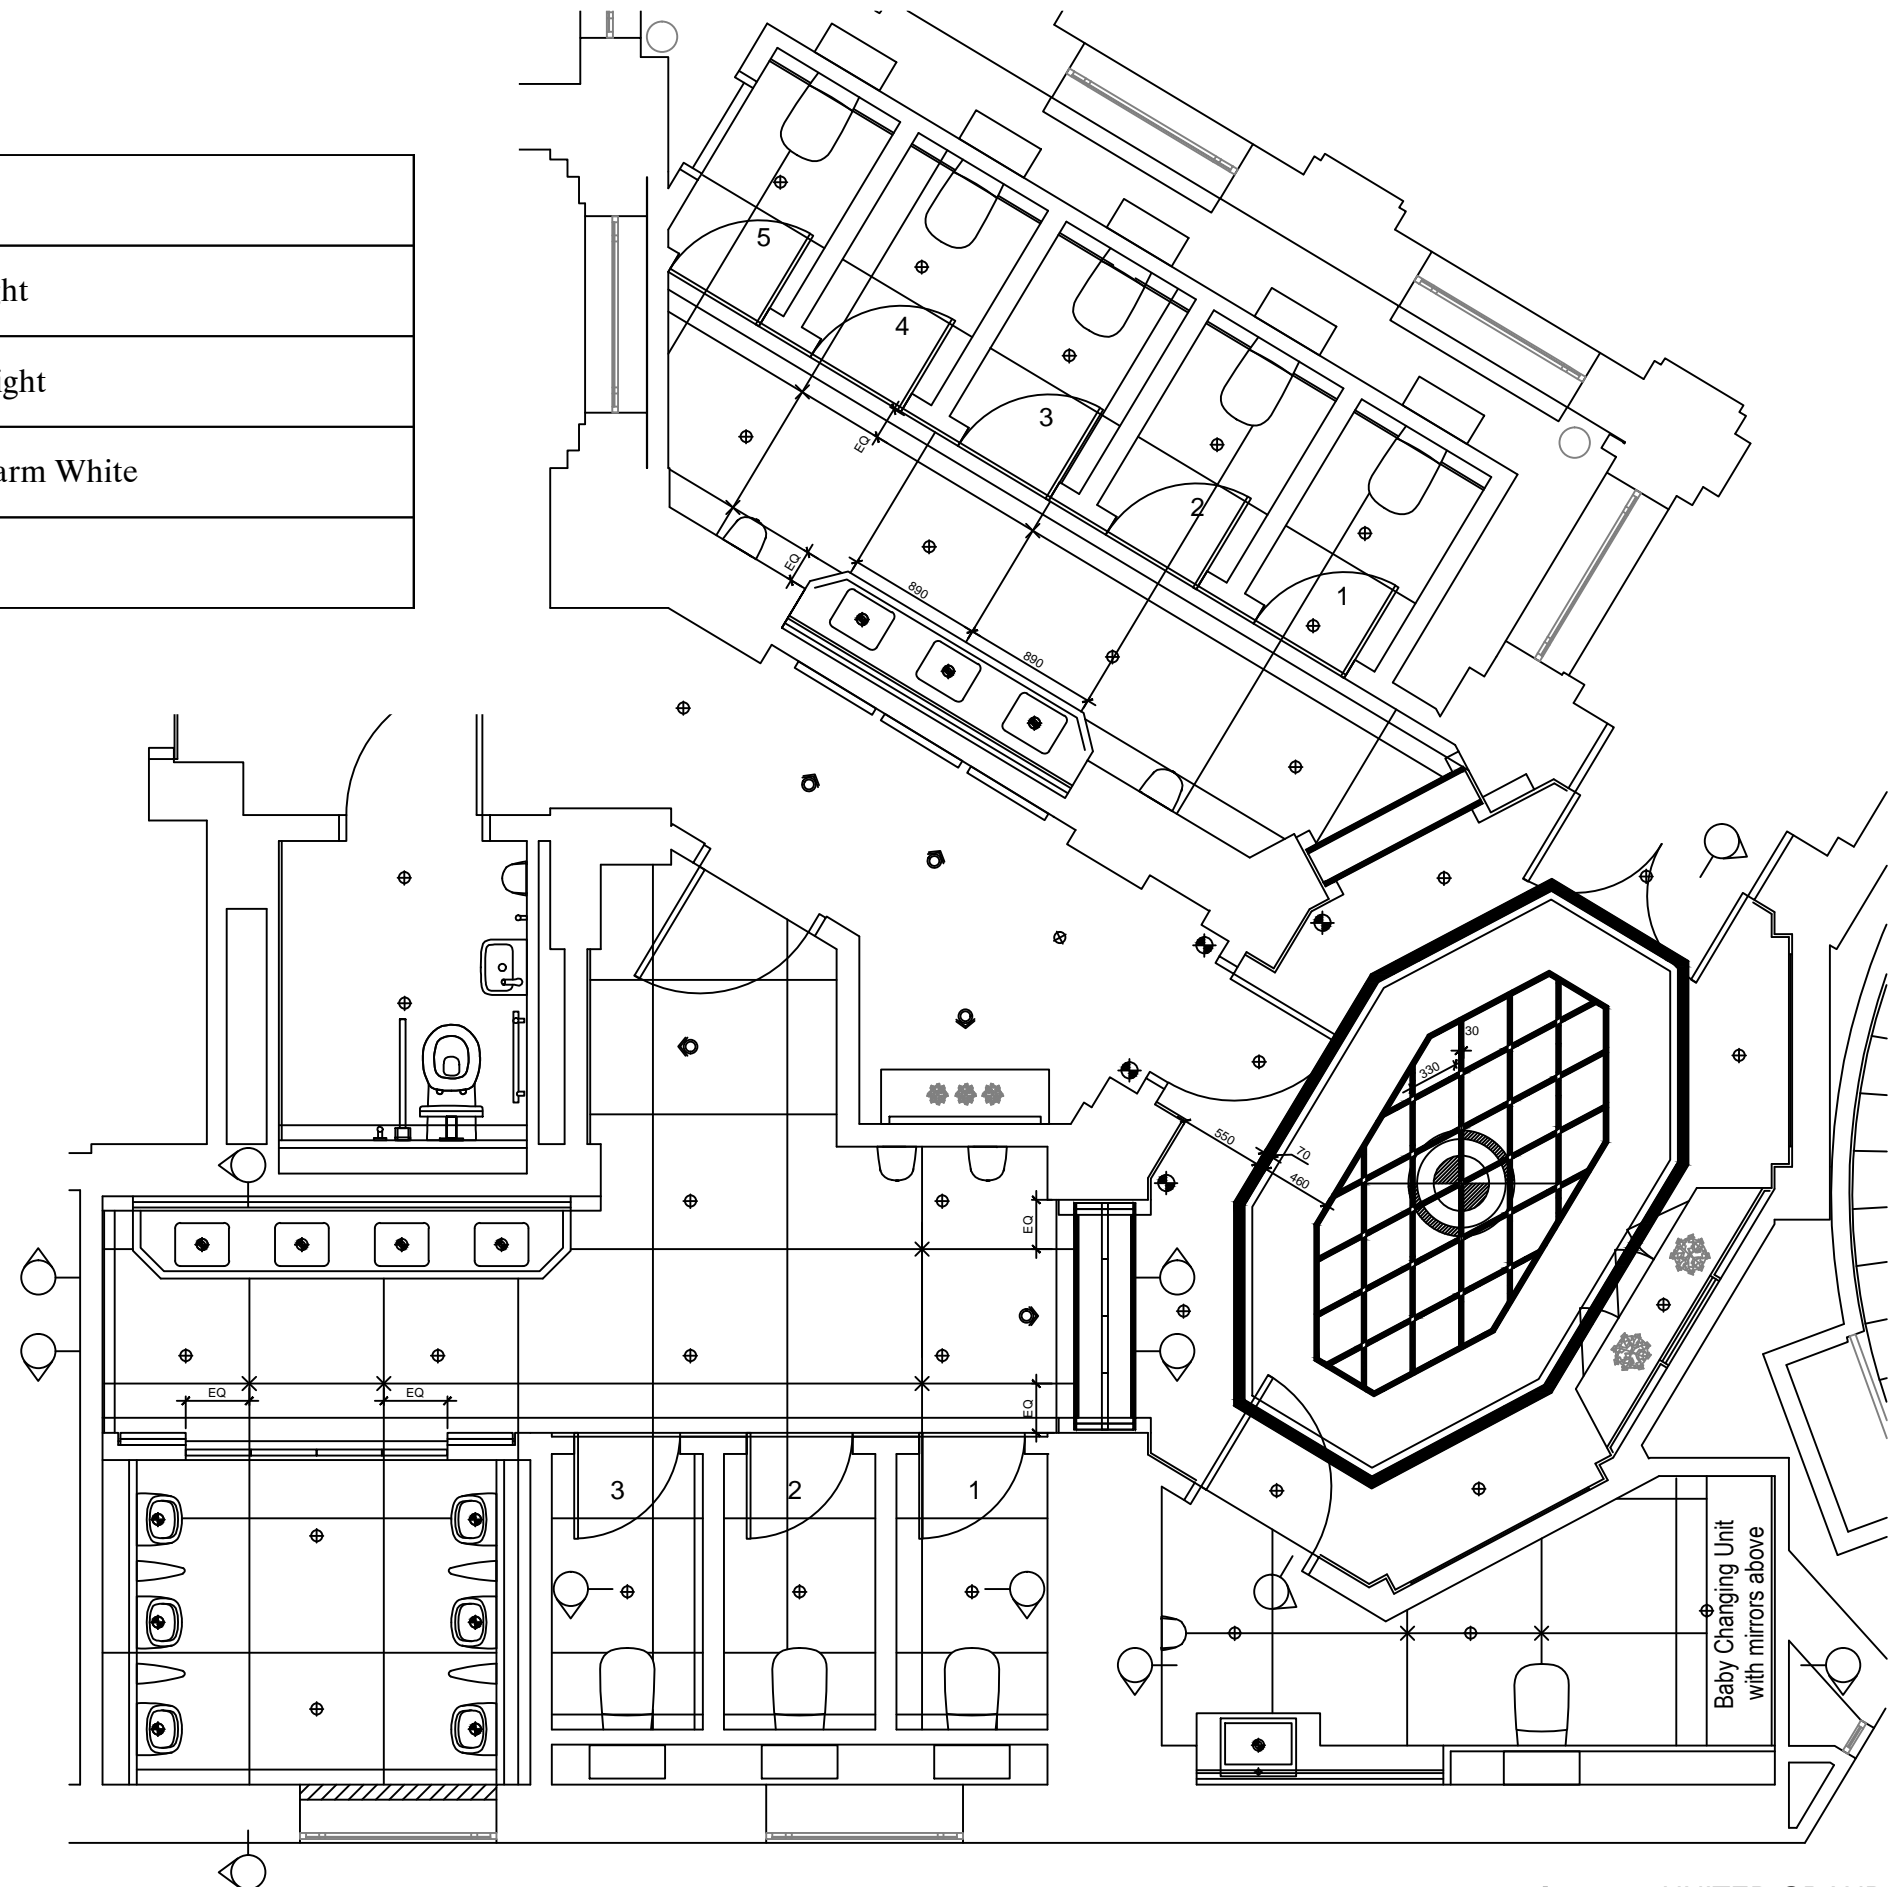

SCALE 1:50

CLIENT UNITED GRAND LODGE OF ENGLAND DRAWN JSI
 PROJECT Freemasons' Hall, 60 Great Queen St WC2B 5AZ SCALE A3 1:50
 DRAWING Proposed First Floor Reflected Ceiling Plan DATE APR 2015



PROJECT No. DRAWING No. REV
 25611 RCP01