 



1 GROUND FLOOR LICENSING
1:100@A3 / 1:50@A1



- EMERGENCY LIGHTING SYSTEM**
An independant self-contained non-maintained sytem, type XOA180, will be installed in accordance with BS 5266-1:2011, Emergency Lighting - Part 1 : Code of Practice for Emergency Lighting of premises other than cinemas and certain other specified premises for entertainment, and BS EN 50172 : 2004, BS 5266-8 : 2004 Lighting Applications - Emergency Lighting. Luminaires will be located in the apprxiamate positions inmdicated on this drawing. All signs and notices will comply with BS 5499 : Part 1 - Fire Safety Notices and Graphic Symbols.
- | | | | |
|--|-------------------------------------|--|---------------------------------|
| | 3 hr maintained exit legend | | 3 hr maintained external light |
| | 3 hr maintained exit light & legend | | 3 hr non-maintained flood light |
| | 3 hr non-maintained light | | Fire fighting equipment |
| | 3 hr non-maintained LED light | | |

- FIRE ALARM SYSTEM**
A Fire Alarm system will be installed to BS 5839 : Part 1, 2002 & A2 : 2008 Code of Practice for system design, installation, commissioning and maintenance, comprising of devices as indicated. The system category to be a L4 system.
- | | | | |
|--|--------------------|--|-----------------------------|
| | Fire Alarm Panel | | Indicator For Void detector |
| | Magnetic Door Hold | | Indicates Void Detector |
| | Manual Call Point | | Sounder |
| | Heat Detector | | Zenon Beacon |
| | Smoke Detector | | Sounder Bases |

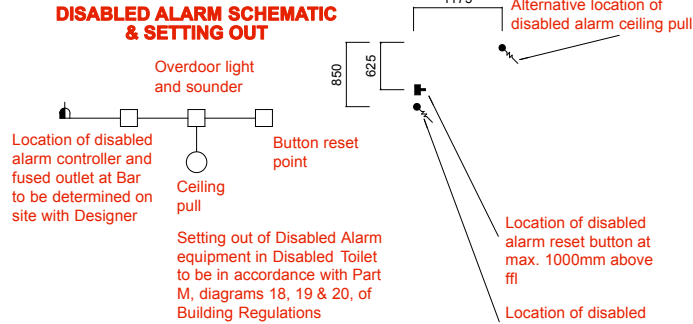

The location and type of any fire safety and any other fire safety equipment is shown as at present. This may be varied from time to time with the agreement of the fire officer or after a fire risk assessment.

----- Licensable Area

Revisions

A - 03.02.14 - Issued for Licensing

Project

BOTTLED OG

Client

BREWDOG

Drawing Title

EXISTING GROUND FLOOR PLAN

Scale

1:100@A3/1:50@A1

Date Created

22.01.14

Drawing Number

14001/801

Revision

A

Revision Date

03.02.14

Drawn By

DF

Checked By

BMS

Do not scale from drawing, all dims to be checked on site. Report omissions and discrepancies to the architect immediately



Michaelis Boyd Associates
108 Palace Gardens Terrace
London W8 4RT

44 20 7221 1237

hello@michaelisboyd.com
michaelisboyd.com