




DO NOT SCALE THIS DRAWING
 THIS DRAWING IS TO BE READ IN CONJUNCTION WITH ALL OTHER RELEVANT ARCHITECTS AND STRUCTURAL ENGINEERS DRAWINGS
 ALL DIMENSIONS TO BE CHECKED ON SITE PRIOR TO COMMENCEMENT OF WORKS AND ANY DISCREPANCIES ARE TO BE REPORTED TO THE ARCHITECT.

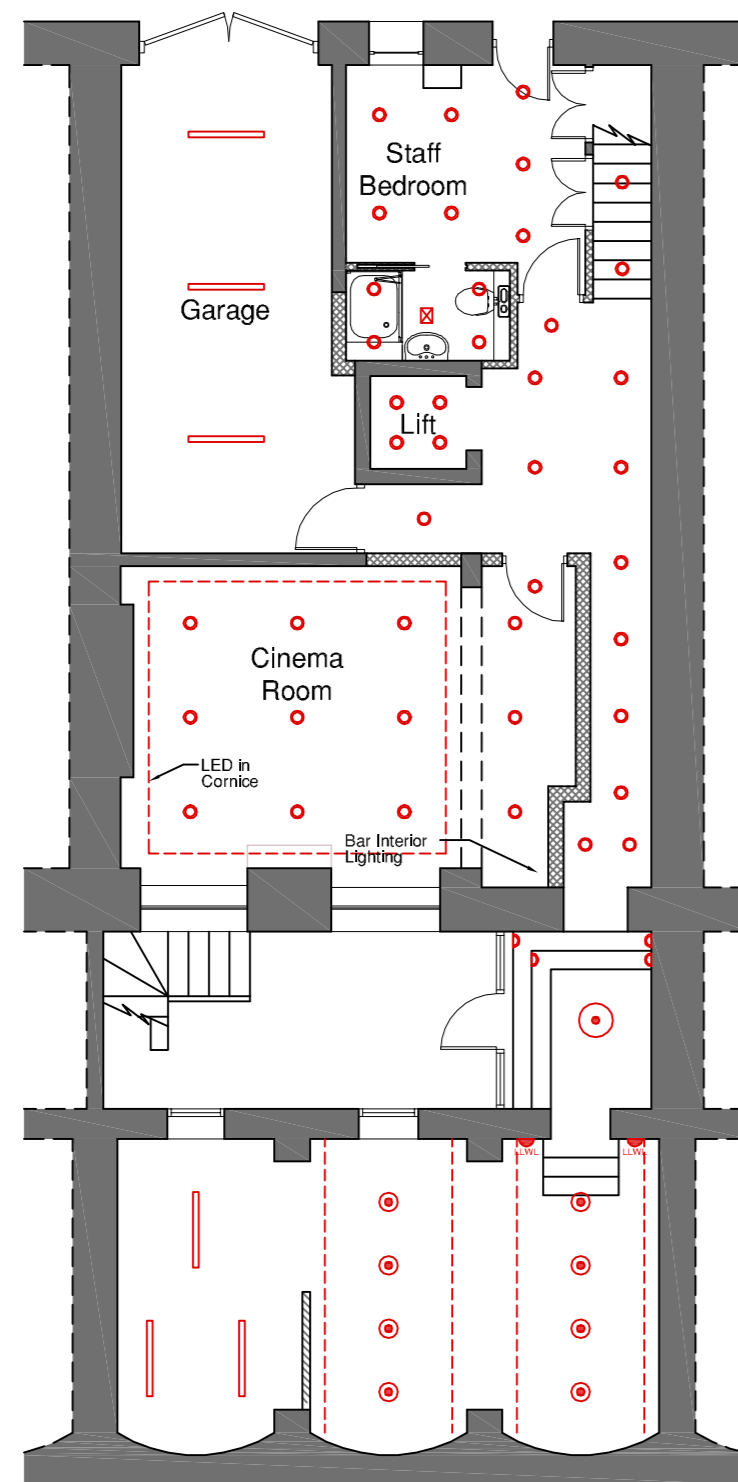

Proposed Lower Ground Floor

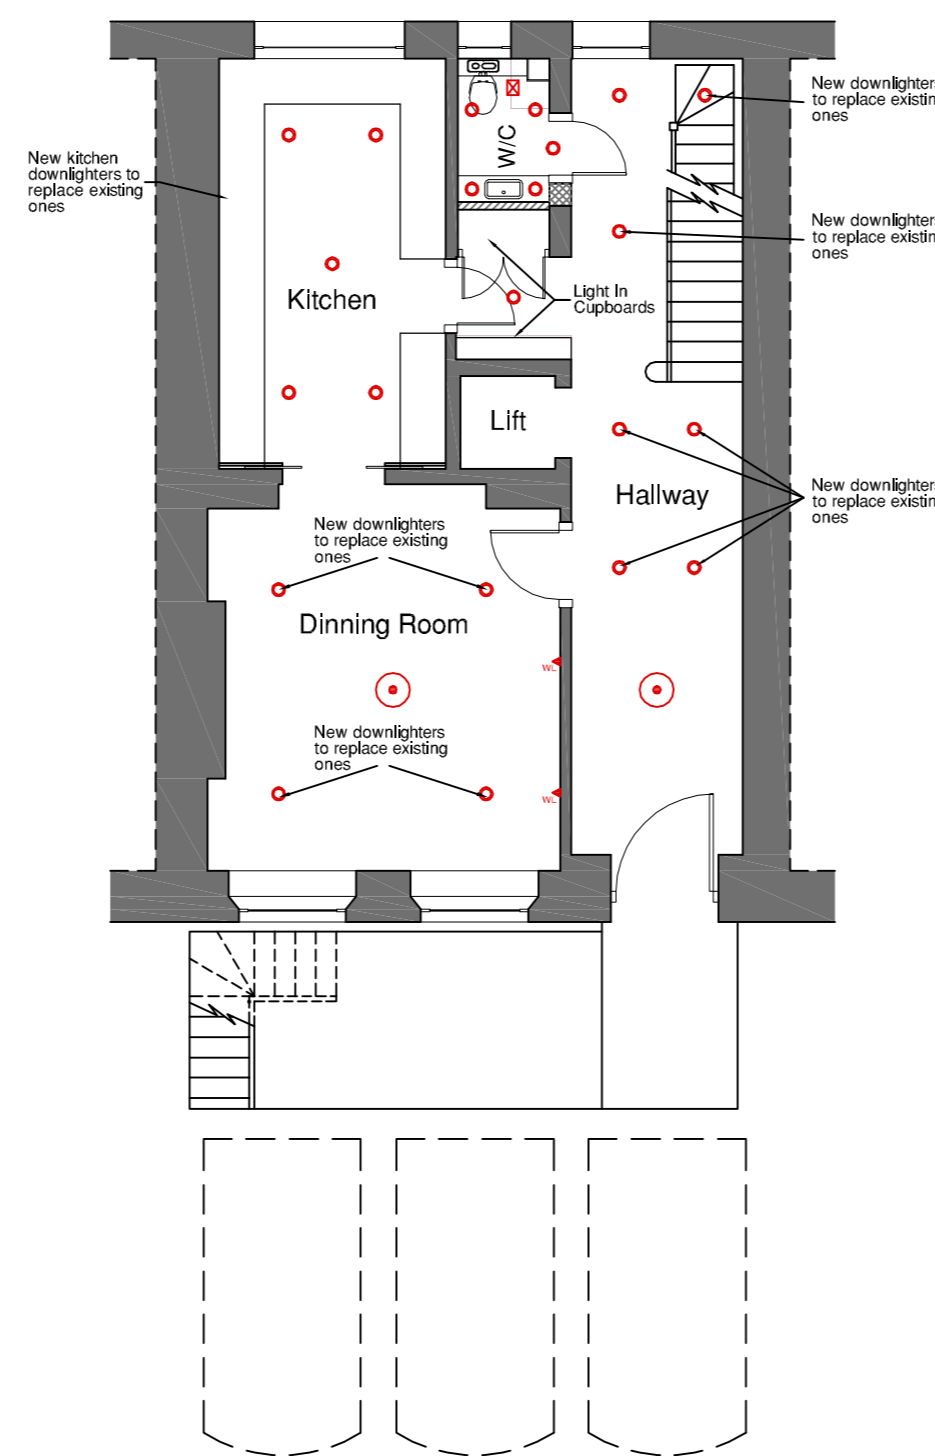


Proposed Ground Floor

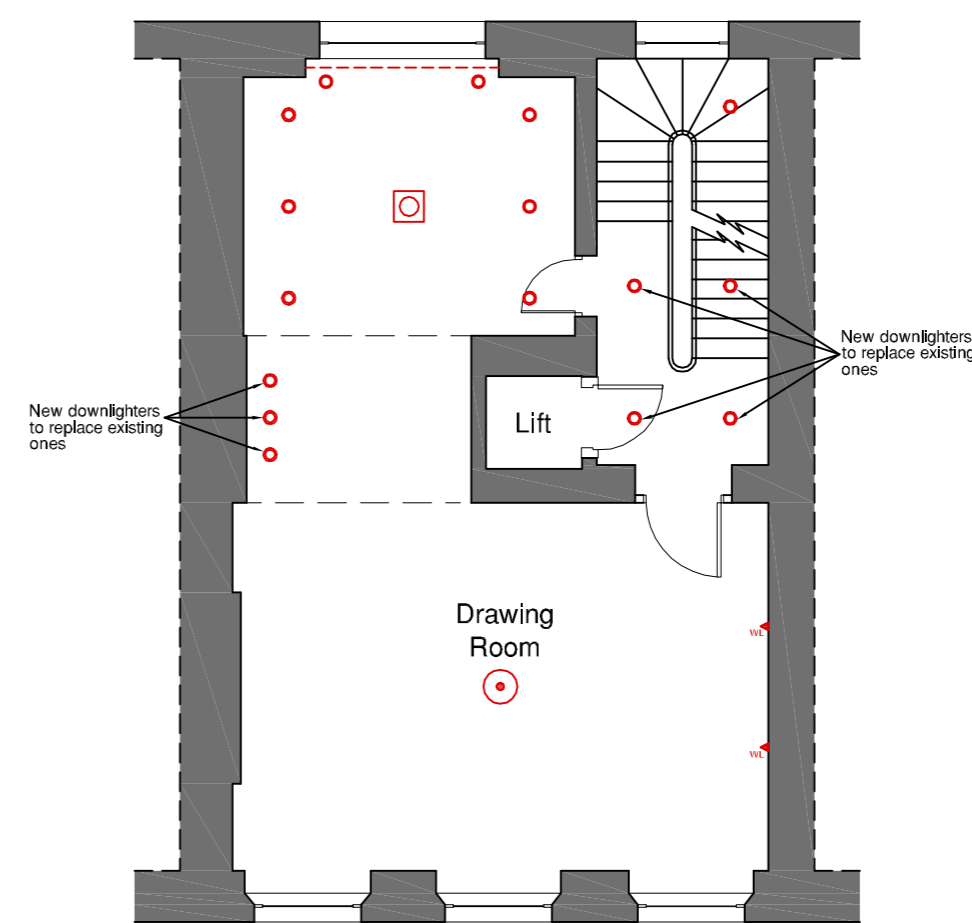


Proposed First Floor


- KEY
- Low Voltage Downlighters
 - ⊙ Surface Mounted Ceiling Lights
 - ⊕ Chandelier / Pendant Lighting
 - ▬ Low Level Wall Lighting
 - ◁ In wall/tread stair lighting
 - ▬ Tube Lighting
 - ◁ Internal Wall Lighting
 - ⊠ In ceiling extractor fan
 - ⊞ Recessed ceiling lighting
 - - - LED Strip Lighting

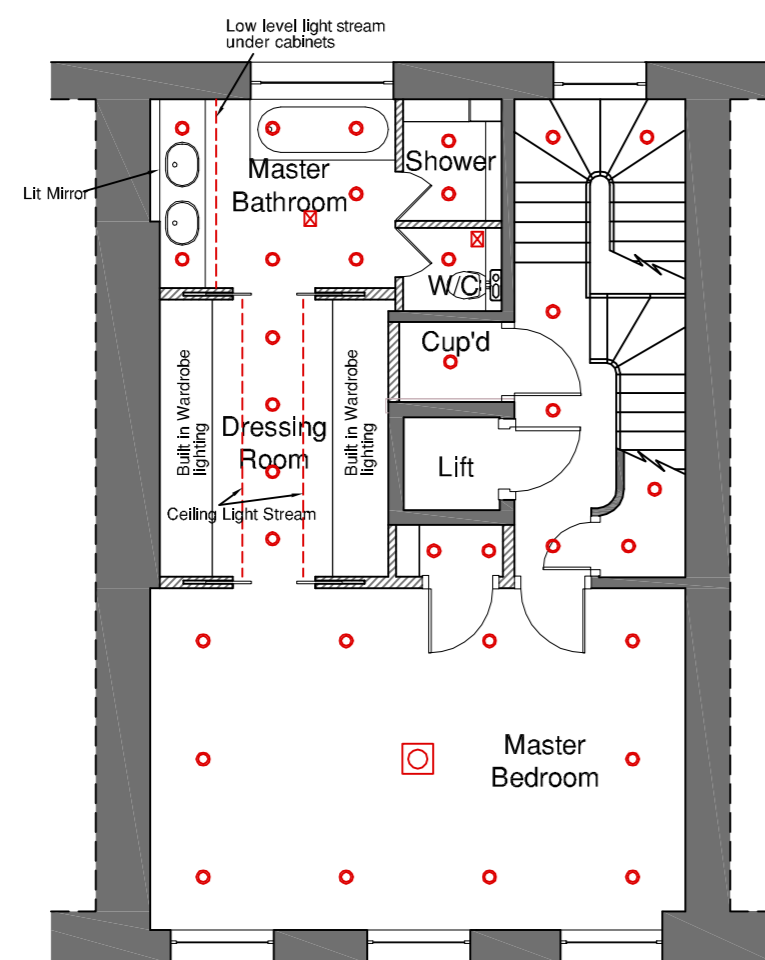

Proposed Second Floor

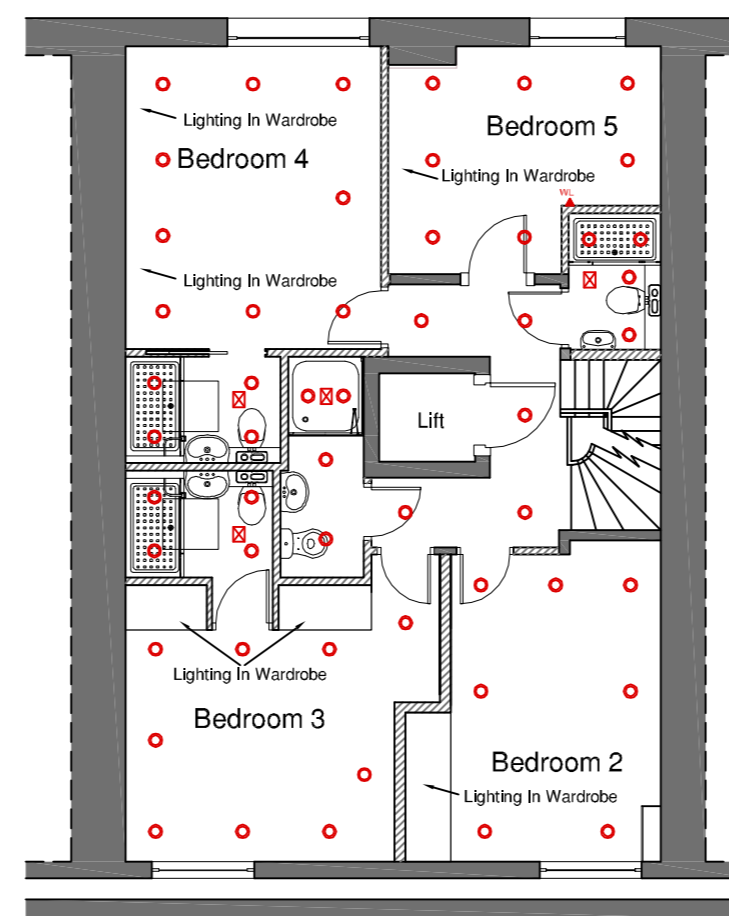

Proposed Third Floor

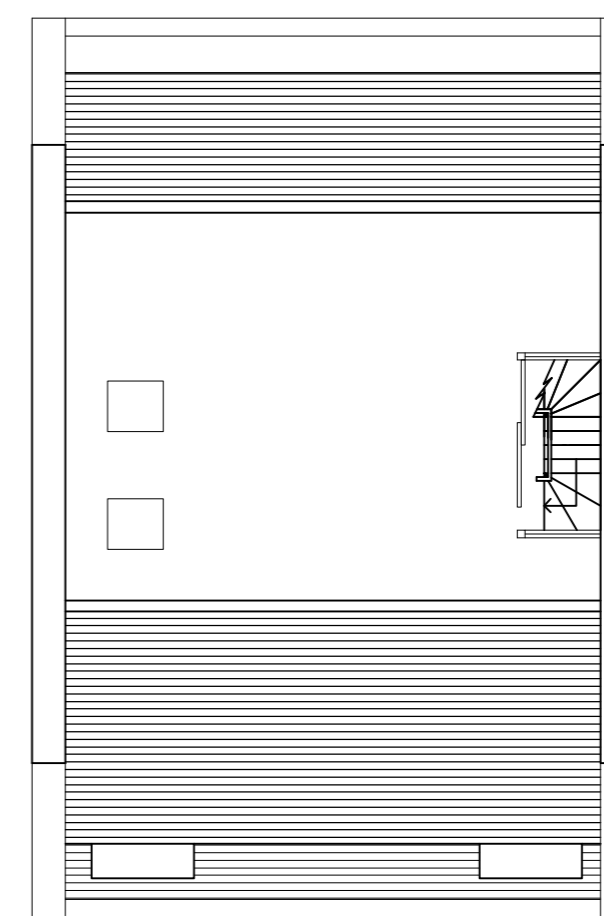

Proposed Roof Plan

REVISIONS	DATE	INITIAL
PURPOSE OF ISSUE: - PLANNING		

CLIENT _____

PROJECT
 33 CHESTER TERRACE
 REGENTS PARK
 LONDON

SUBJECT
 PROPOSED FLOOR PLANS
 LIGHTING LAYOUTS

DATE	DRAWN
APRIL 2015	
SCALE	CHECKED
1:100 @ A2	
DRAWING NO.	REV.
3193_PC01	C

