

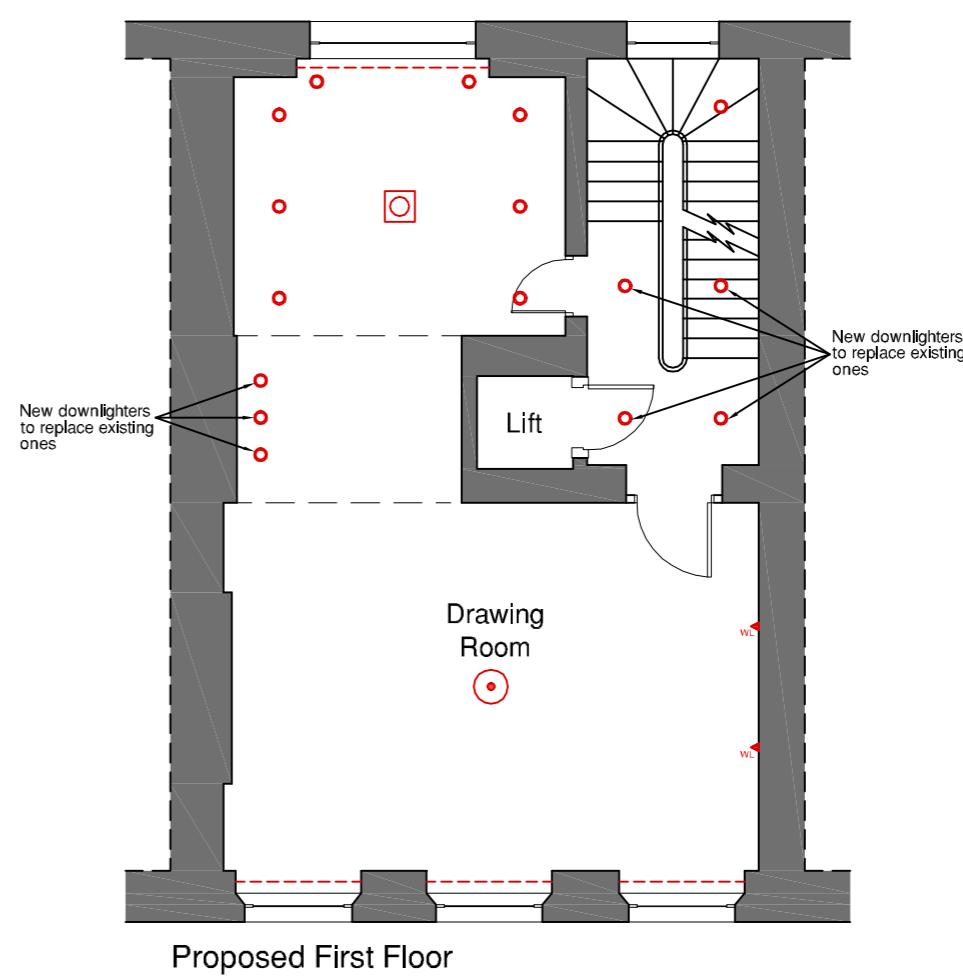
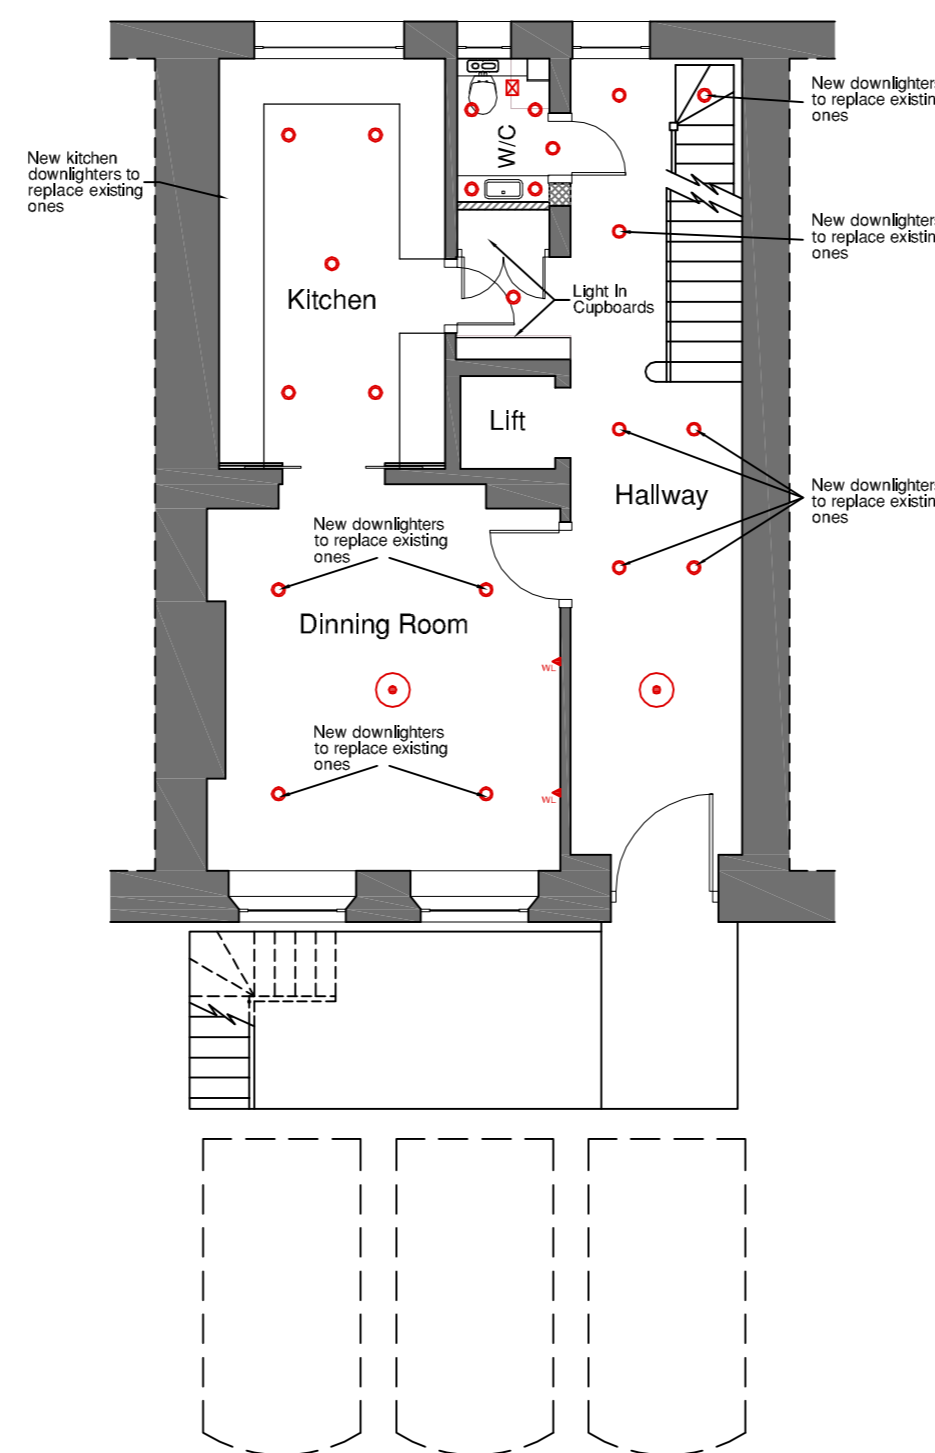
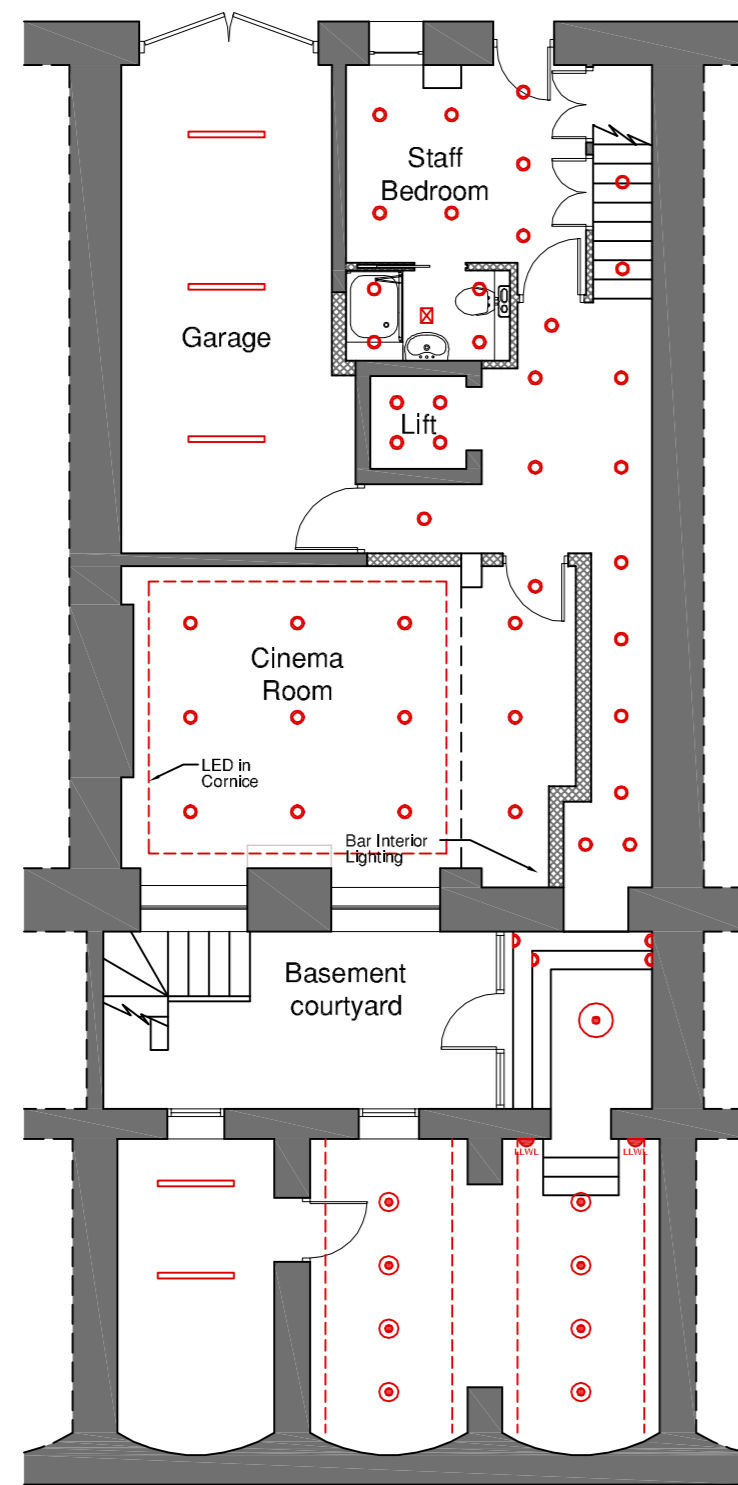
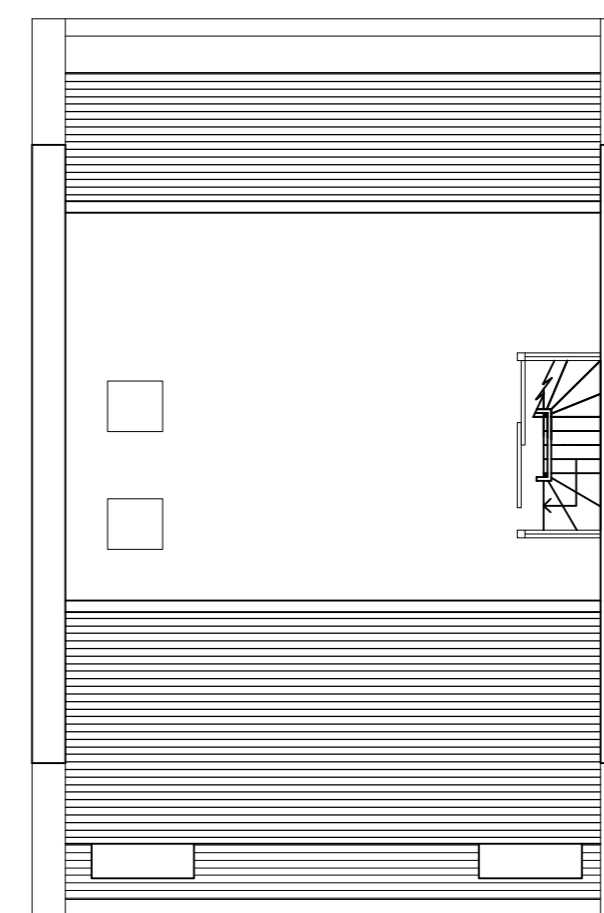


DO NOT SCALE THIS DRAWING  
 THIS DRAWING IS TO BE READ IN CONJUNCTION WITH ALL OTHER RELEVANT ARCHITECTS AND STRUCTURAL ENGINEERS DRAWINGS  
 ALL DIMENSIONS TO BE CHECKED ON SITE PRIOR TO COMMENCEMENT OF WORKS AND ANY DISCREPANCIES ARE TO BE REPORTED TO THE ARCHITECT.

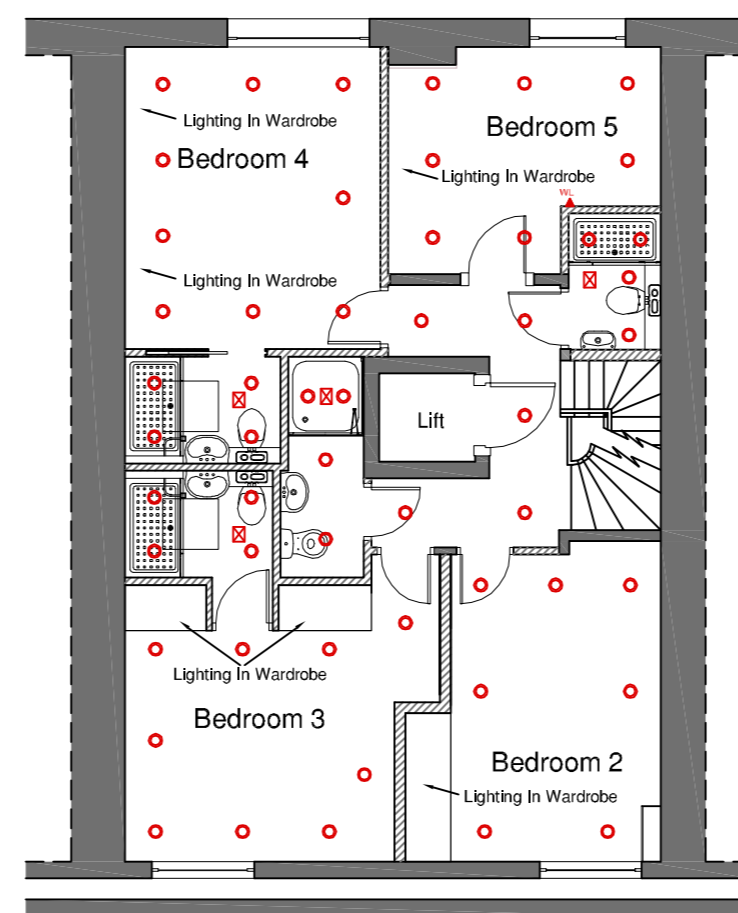

- KEY
- Low Voltage Downlighters
  - ⊙ Surface Mounted Ceiling Lights
  - ⊕ Chandelier / Pendant Lighting
  - ▬ Low Level Wall Lighting
  - ◀ In wall/tread stair lighting
  - ▬ Tube Lighting
  - ◀ Internal Wall Lighting
  - ⊗ In ceiling extractor fan
  - ⊞ Recessed ceiling lighting
  - - - LED Strip Lighting

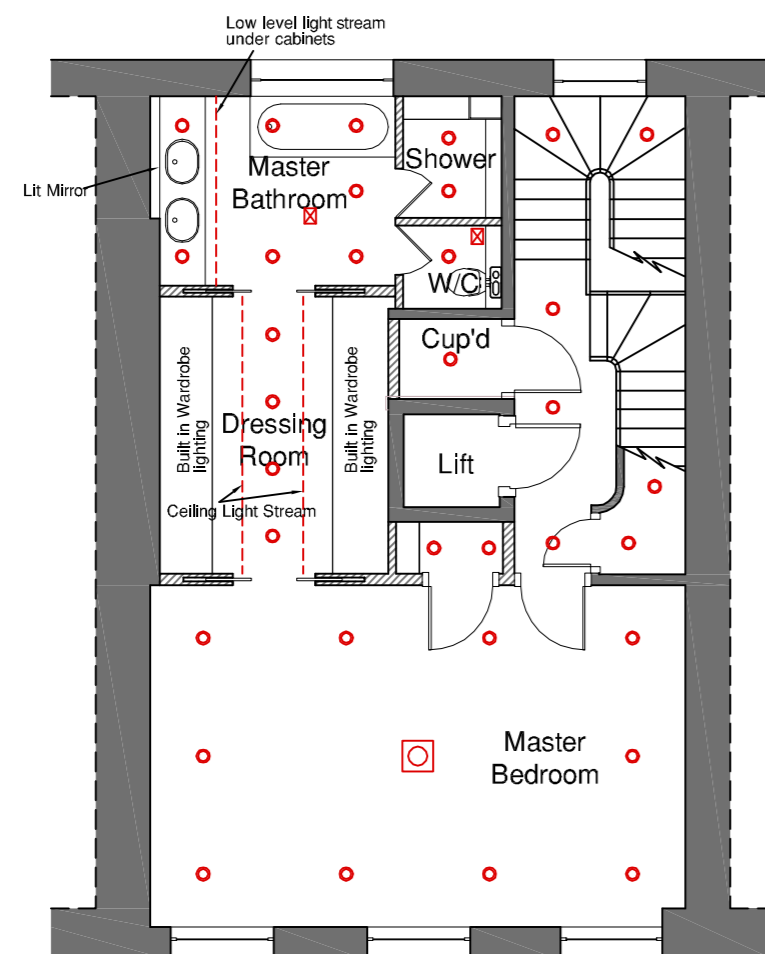

REVISIONS DATE INITIAL  
 PURPOSE OF ISSUE: - **PLANNING**

CLIENT \_\_\_\_\_  
 PROJECT 33 CHESTER TERRACE  
 REGENTS PARK  
 LONDON

SUBJECT PROPOSED FLOOR PLANS  
 LIGHTING LAYOUTS

| DATE                  | DRAWN   |
|-----------------------|---------|
| APRIL 2015            |         |
| SCALE 1:100 @ A2      | CHECKED |
| DRAWING NO. 3193_PC02 | REV. B  |