


THIS DRAWING IS PROTECTED BY COPYRIGHT. FIGURED DIMS. ONLY TO BE TAKEN FROM THIS DRAWING. ALL DIMENSIONS TO BE CHECKED ON SITE AND ANY DISCREPANCIES REPORTED TO THE ARCHITECT IMMEDIATELY.

| Rev | Date | Description |
|-----|------|-------------|
| | | |

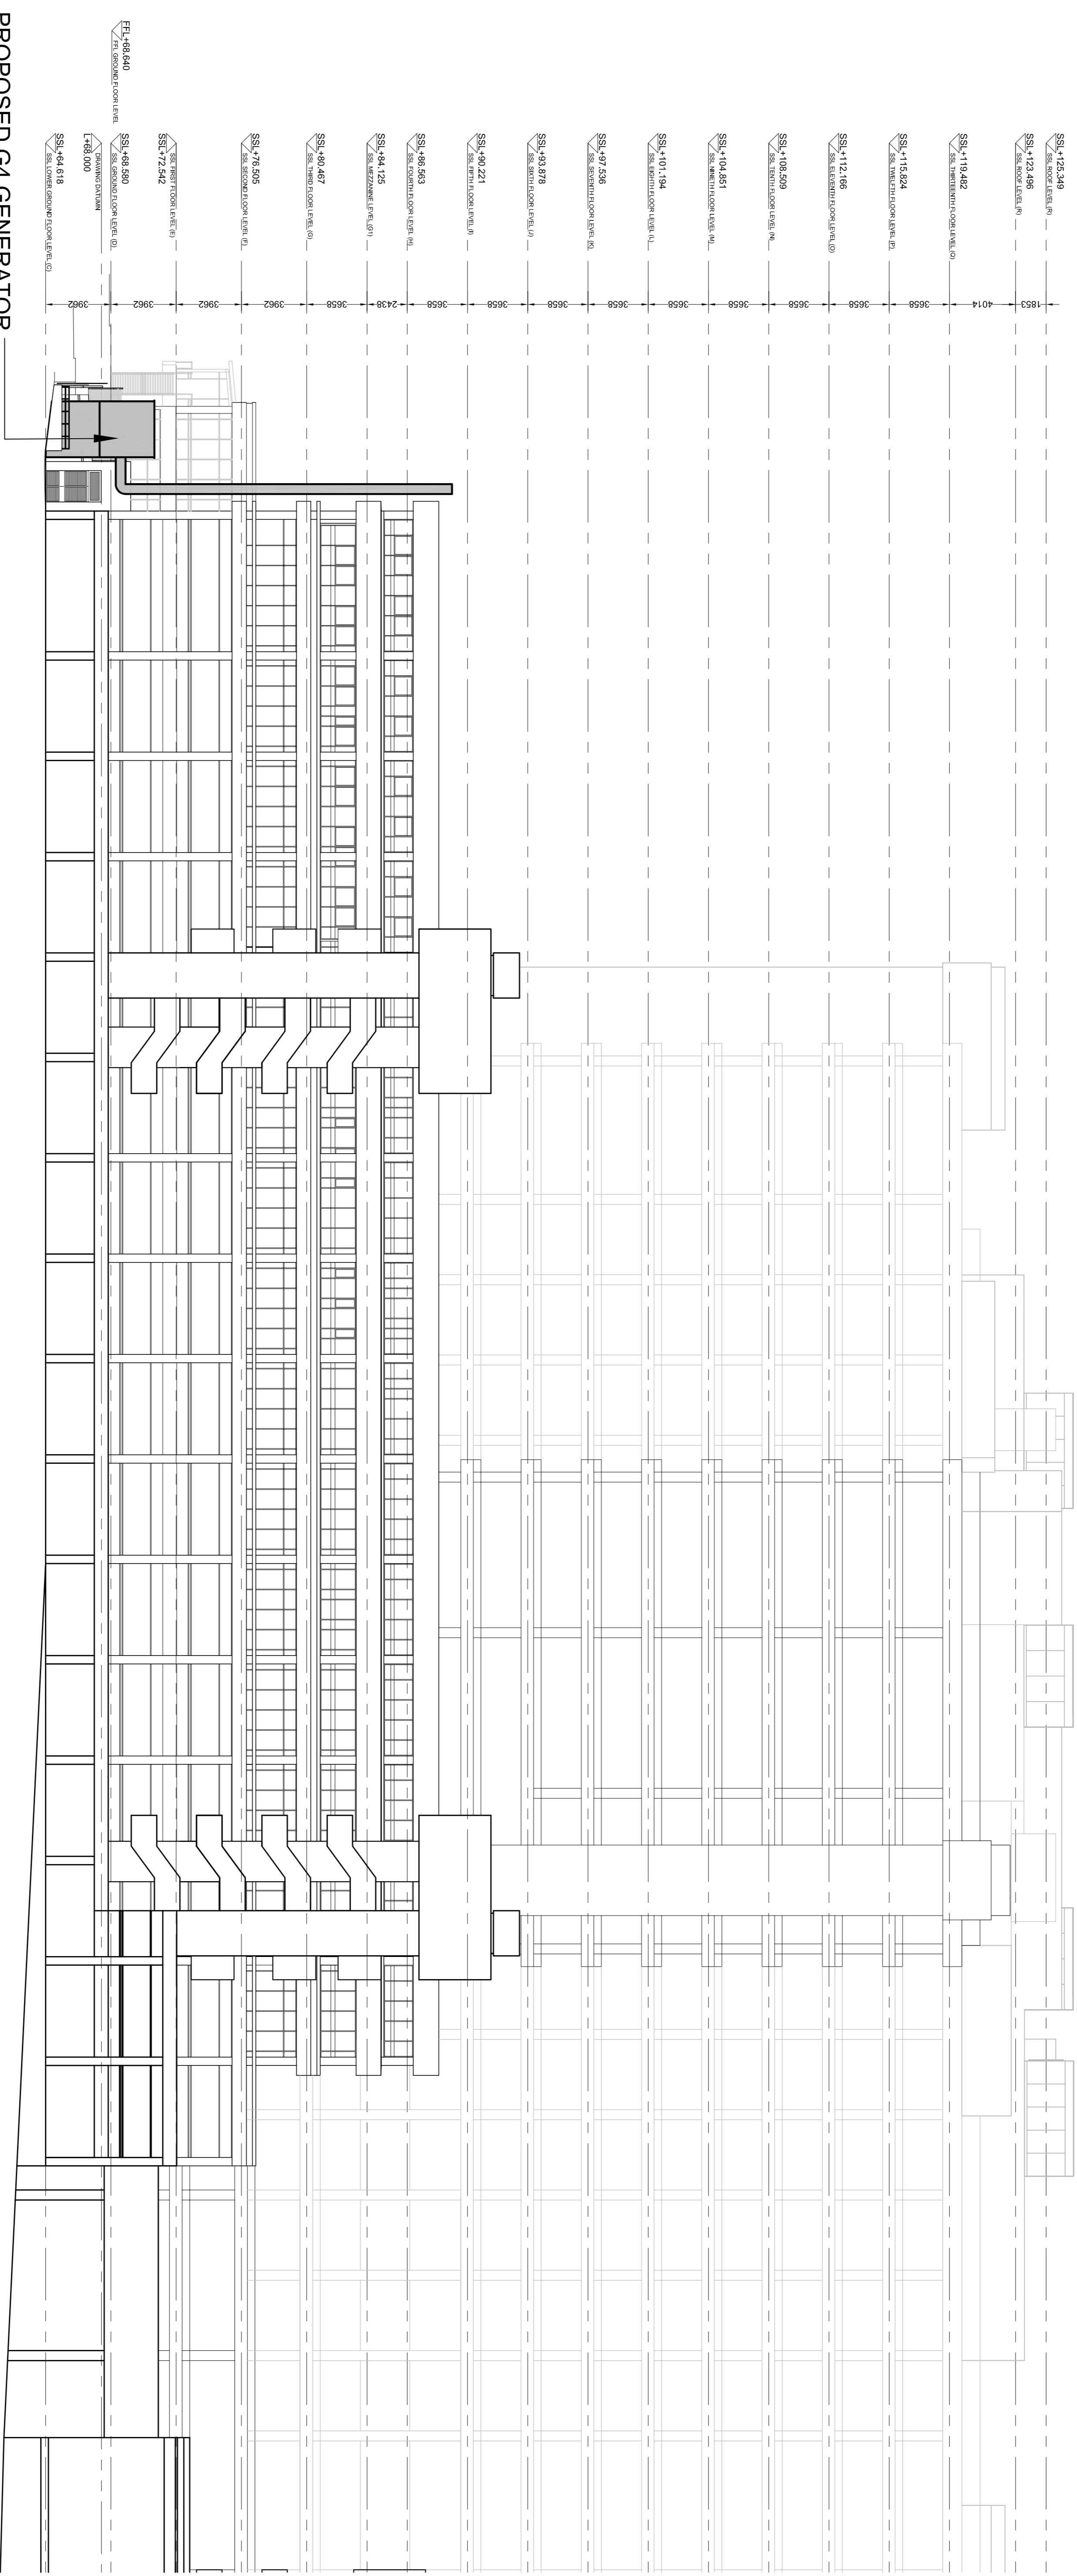


PROPOSED G4 GENERATOR & FLUE

PROPOSED EAST ELEVATION

Royal Free London NHS Foundation Trust
Emergency Generator (G4)
FOR PLANNING

Proposed East Elevation

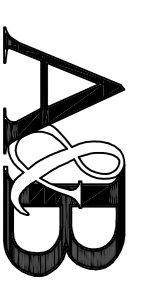

ANSELL & BAILEY LLP
Tel: 020 7387 0141
Fax: 020 7387 7460
architect@ansellandbailey.com
CHARTERED ARCHITECTS
24-32 Stephenson Way, London, N1M 2HD

1:200@A1
SCALE
Feb 2015
DATE
15005
JOB NUMBER
(02)004
DRAWING NUMBER
1
REV