


LEGEND

AC	Access Door	HL	High Level
ASP	Anti-Syphon Pipe	LL	Low Level
DW	Dishwasher	FA	From Above
FG	Floor Gully	FB	From Below
FW	Foul Water	TA	To Above
RE	Rodding Eye	TB	To Below
RW	Rainwater		
RWO	Rainwater Outlet	FFL	Finished Floor Level
RWP	Rainwater Pipe		
SF	Soil Float	Ø	Diameter
SK	Sink		
SP	Soil Pipe		
SIS	Stub Stack		
SVP	Soil Vent Pipe		
VP	Vent Pipe		
WC	Water Closet		
WHB	Wash Hand Basin		
WP	Waste Pipe		
WM	Washing Machine		

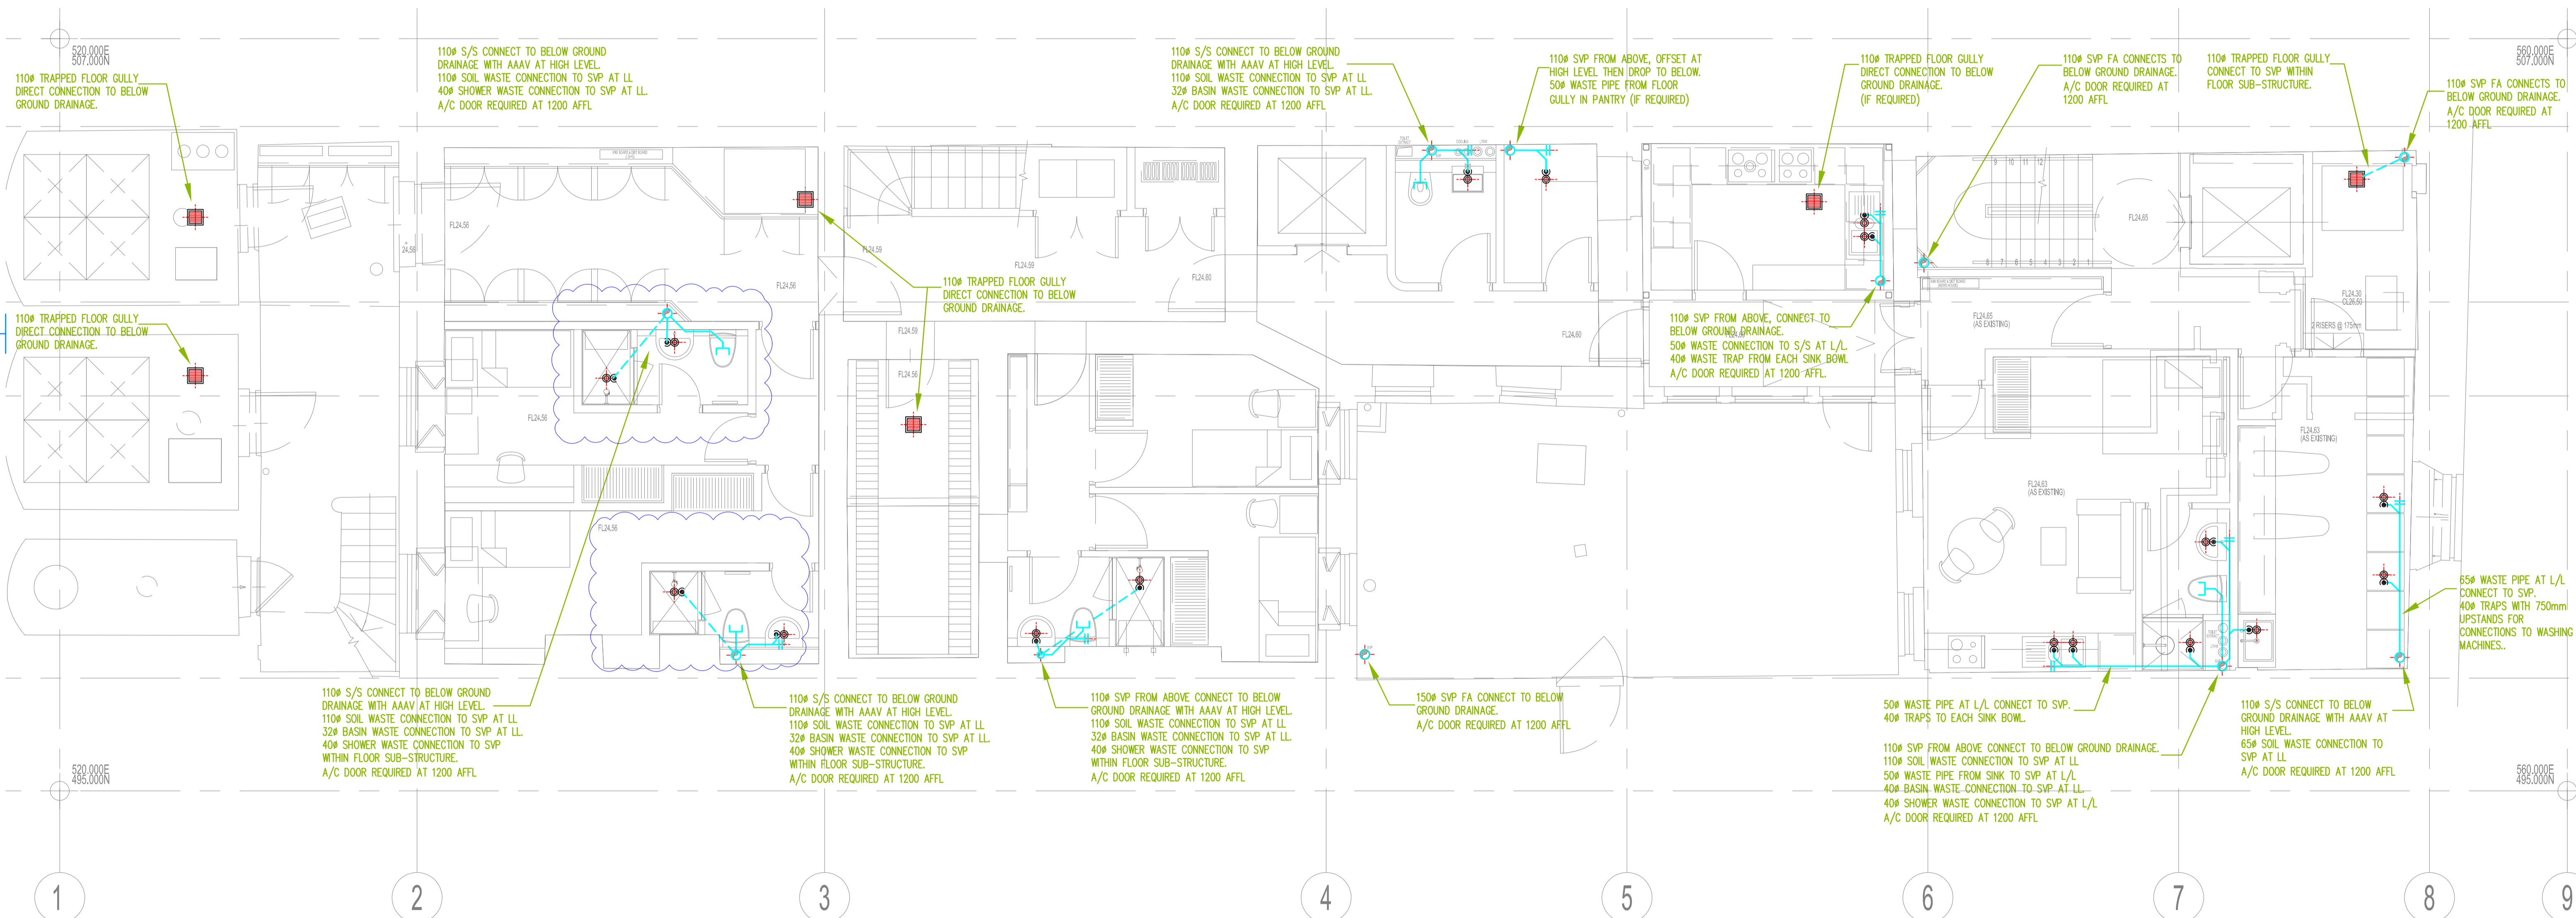

Index	Description	Drawn & Click by	Rev'd by	Date
D4	XREF UPDATED AND LAYOUT AMENDED TO SUIT	TW	-	JUN 15
D3	XREF UPDATED AND LAYOUT AMENDED TO SUIT	TW	-	MAY 15
D2	AMENDMENT FOLLOWING COMMENTS	TW	-	MAY 15
D1	PRELIMINARY ISSUE FOR COMMENT	TW	-	MAY 15

**General Notes:**

- The drawing does not necessarily show all the information needed to interpret the design intent or the construction details.
- The drawing contains information from more than one source and must be read in conjunction with all relevant specifications.
- Any apparent drafting errors and differences between other drawings and specifications shall be brought to our attention.

**Project Notes:**

1) Background Xref Reference - BDP Dwg No. P2005698(15)AP121\_Rev C

**CDM Pre-Construction Information**

The following information is provided in pursuance of Regulations 11 (6) of the CDM Regulations 2007:

**Architect**  
BDP ARCHITECTS  
16 BREWHOUSE YARD  
CLERKENWELL  
LONDON, EC1V 4LJ

**Client**  
RER LONDON LTD.  
JAMES HOUSE, THIRD FLOOR  
1 BABMAES STREET  
LONDON, SW1Y 6HF

**Project Title**  
42 BEDFORD SQUARE  
LONDON

**Drawing Title**  
ABOVE GROUND DRAINAGE LAYOUT  
LOWER GROUND FLOOR LEVEL

www.hoarelea.com

**HOARE LEA**

**STAGE D**

Drawn by	Designed by	Reviewed by
TR	TW	TW
Project No	Date	Scale @ A1
0209223	May 2015	1:50
DRAWING NUMBER		Revision
0209223-HL-XX-B0-GA-P-523-B001		D4