


- NOTES:
1. The drawing does not necessarily show all the information needed to interpret the design intent or the construction details.
 2. The drawing contains information from more than one source and must be read in conjunction with all relevant specifications.
 3. Any apparent drafting errors and differences between other drawings and specifications shall be brought to our attention.
 4. Xref Reference - BDP Dwg No. P2005698(15)AP021_Rev D

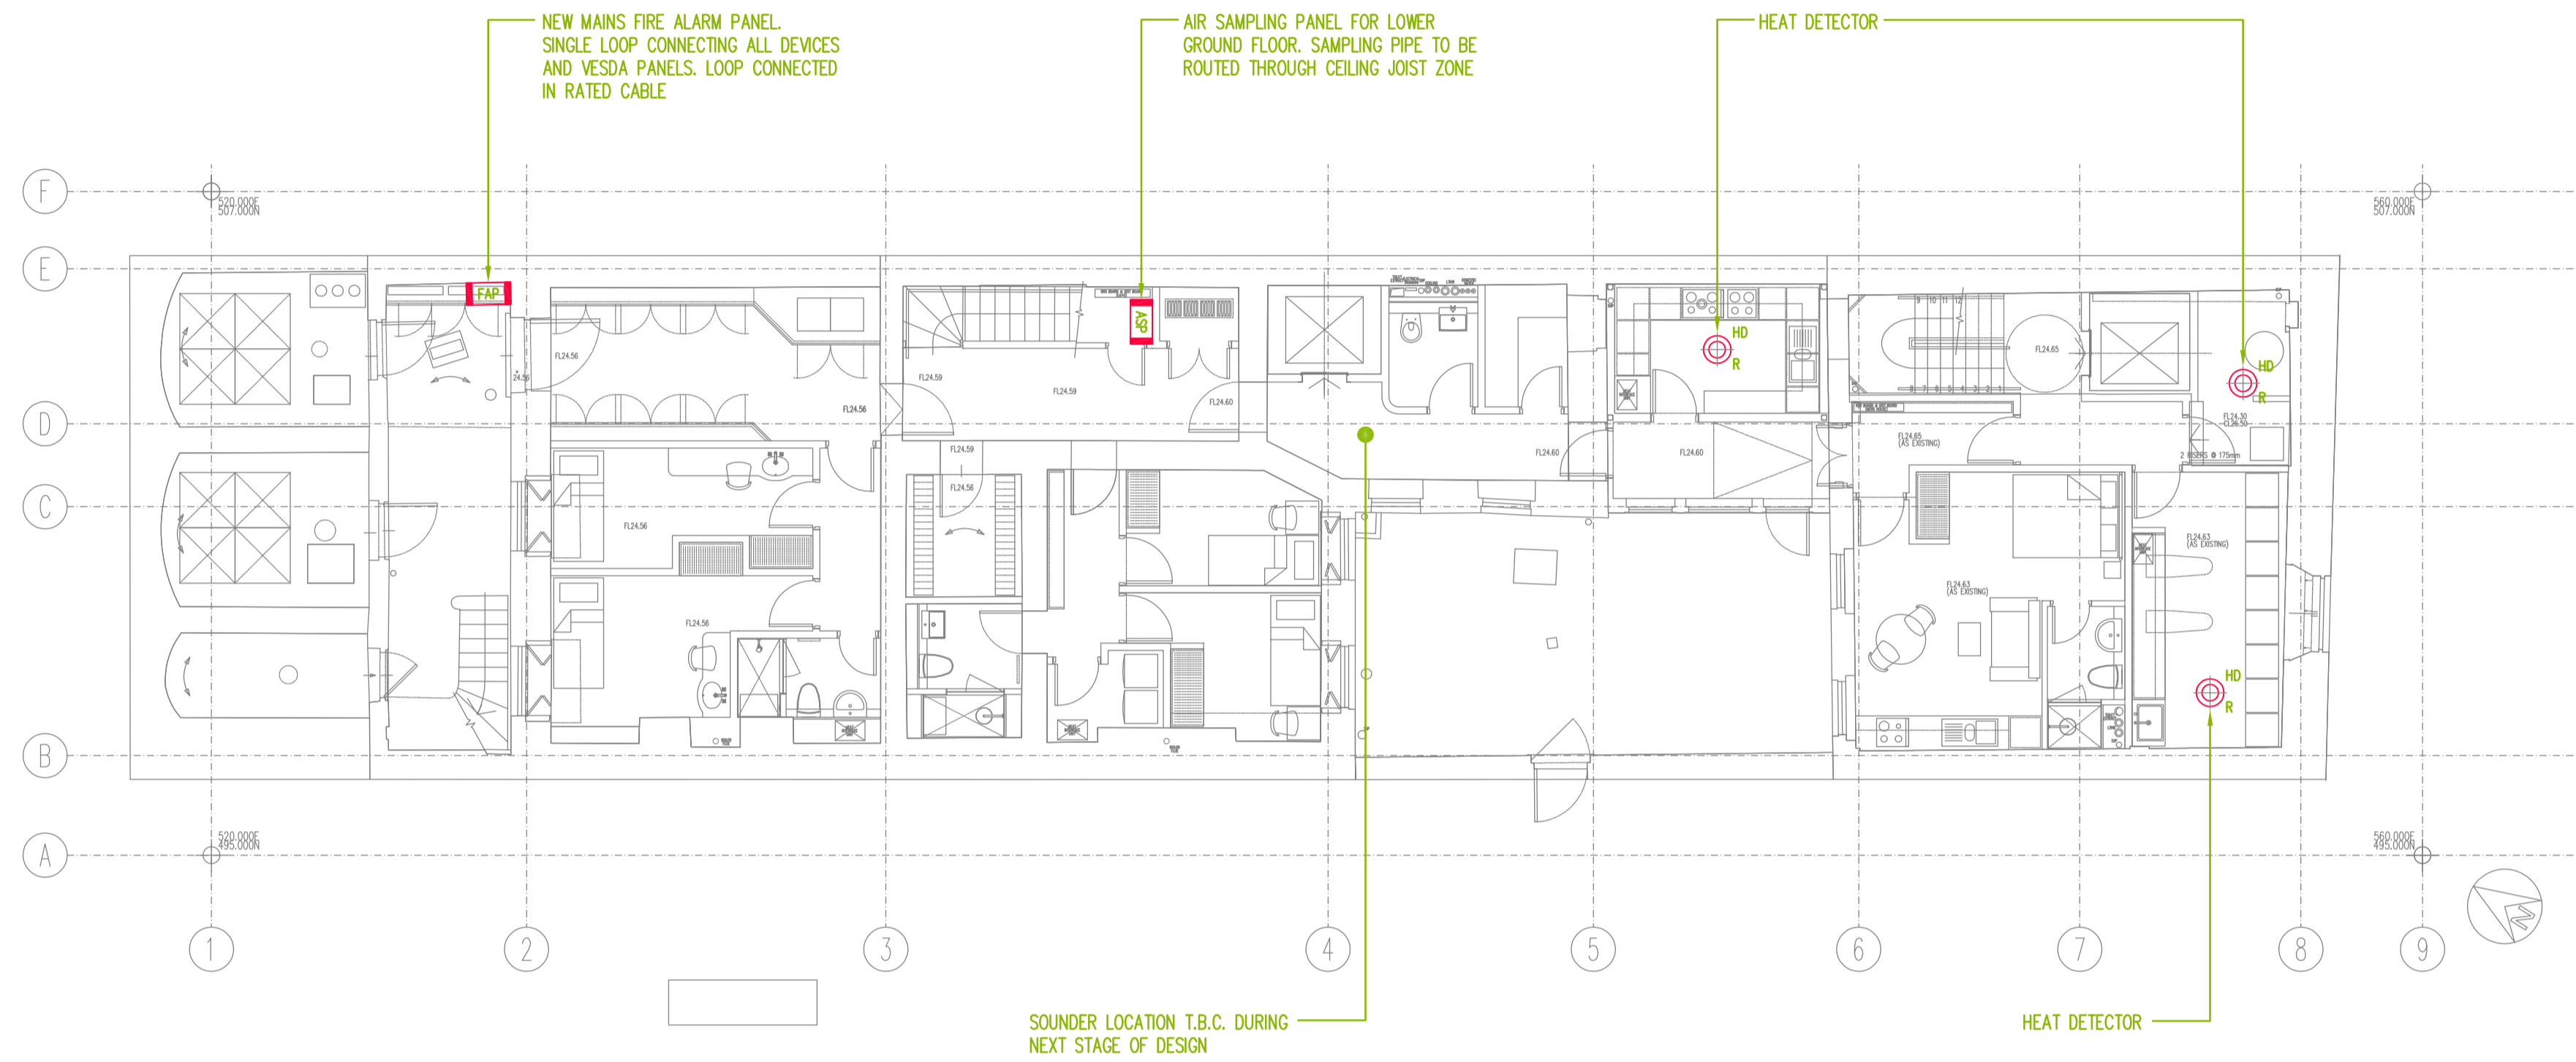

B	XREF UPDATED	AJM	PRM	JUN'15
A	PLANNING ISSUE	JC	MJ	JUL'13
Index	Description	Drawn & Ck'd by	Rev'd by	Date

Revisions

Architect
BDP.

Client

PLANNING

HOARE LEA

BIRMINGHAM
BRISTOL
CAMBRIDGE
CARDIFF
ISLE of MAN
LEEDS
LONDON
MANCHESTER
OXFORD
PLYMOUTH
POOLE

www.hoarelea.com

Project Title
**42 BEDFORD SQUARE
LONDON**

Drawing Title
**ELECTRICAL SERVICES
FIRE ALARM LAYOUT
BASEMENT LEVEL**

Project No	Drawn & Checked by	Reviewed by
26/01045	JC	MJ
Date	Scale	Issuing Office
JULY 2013	1:100@ A1	Cambridge

DRAWING NUMBER								
Project Code	Orig.	Zone	Level	Type	Role	Class.	Number	Rev.
2601045	HL	XX	B0	SK	E	650	5000	B