


**CDM Pre-Construction Information**

The following information is provided in pursuance of Regulations 11 (6) of the CDM Regulations 2007:

**NOTES:**

1. The drawing does not necessarily show all the information needed to interpret the design intent or the construction details.
2. The drawing contains information from more than one source and must be read in conjunction with all relevant specifications.
3. Any apparent drafting errors and differences between other drawings and specifications shall be brought to our attention.
4. Xref Reference - BDP Dwg No. P2005698(15)AP025\_Rev D

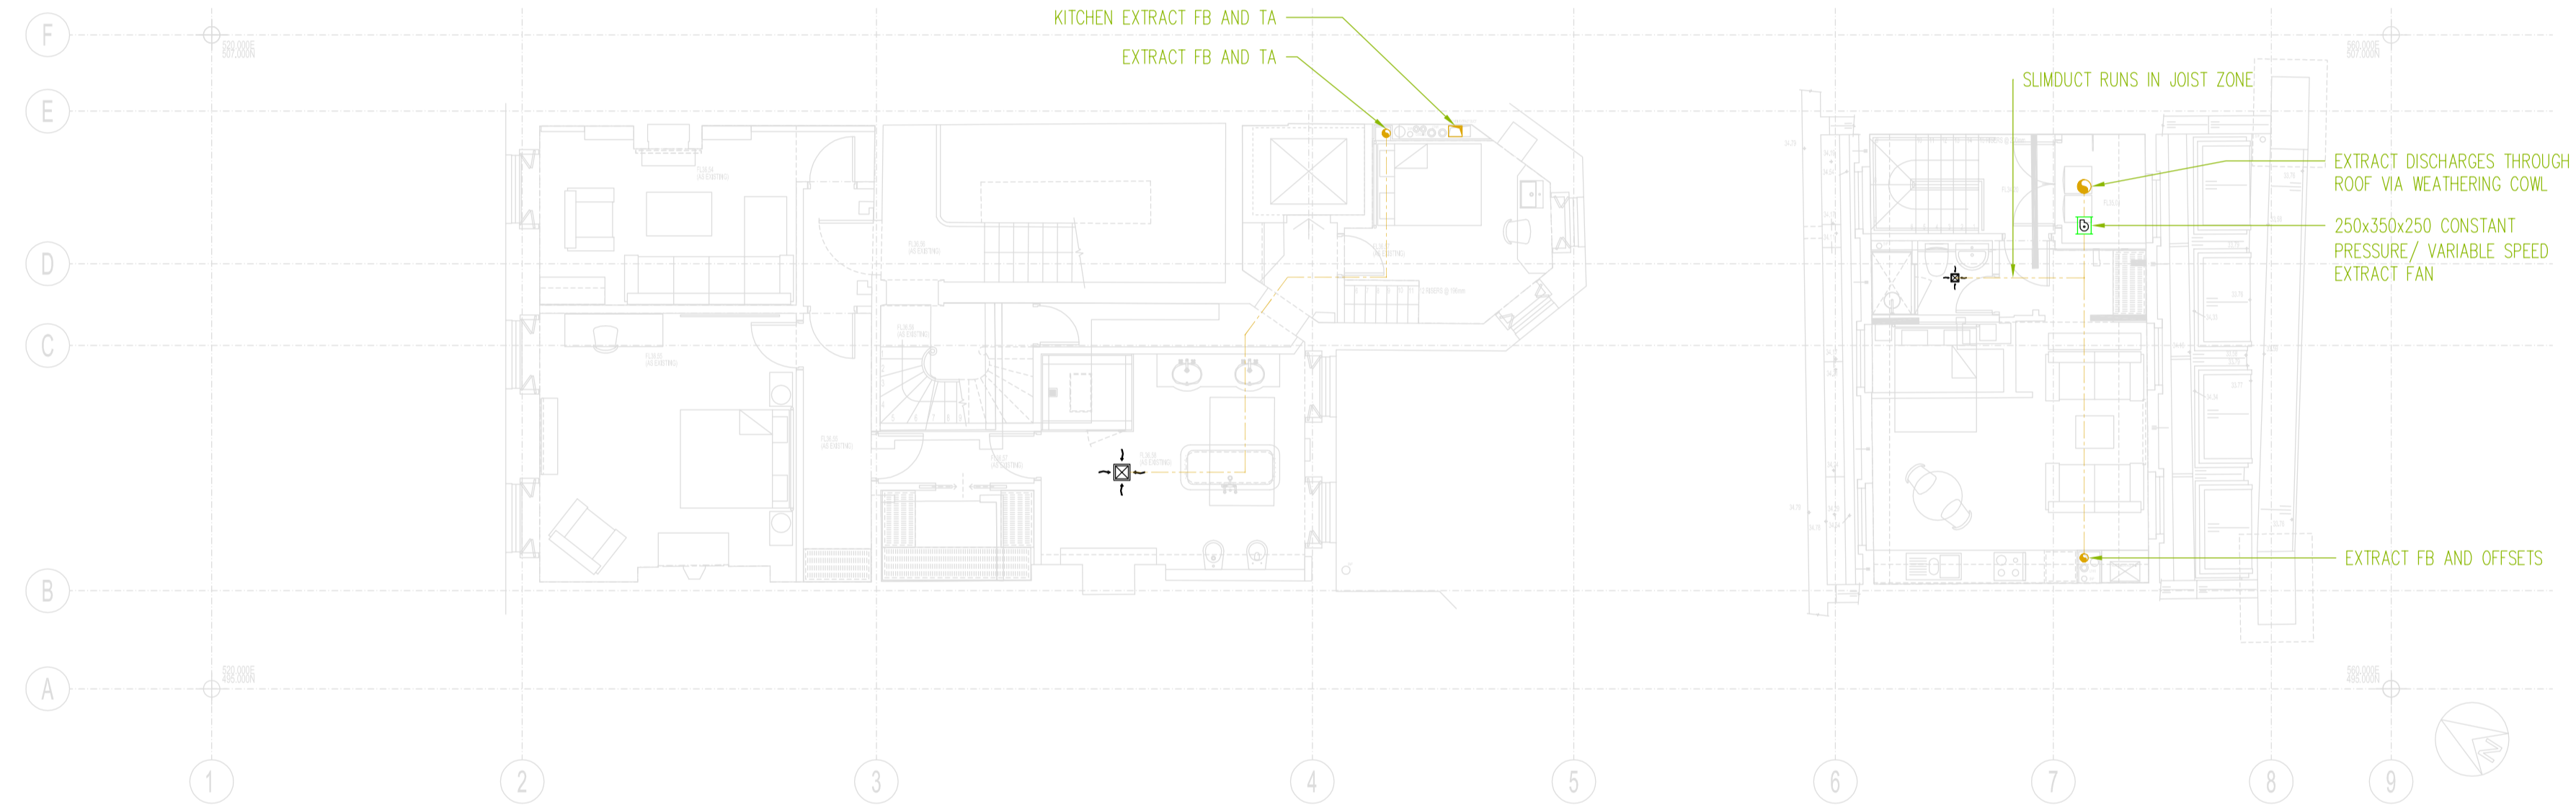

B	XREF UPDATED	TS	TW	JUN'15
A	PLANNING ISSUE	DB	KS	AUG'13
Index	Description	Drawn & Chk'd by	Rev'd by	Date

Revisions				
Architect				
<b>BDP.</b>				
Client				

**PLANNING**

**HOARE LEA**  
www.hoarelea.com

BIRMINGHAM  
BRISTOL  
CAMBRIDGE  
CARDIFF  
ISLE of MAN  
LEEDS  
LONDON  
MANCHESTER  
OXFORD  
PLYMOUTH  
POOLE

Project Title  
**42 BEDFORD SQUARE  
 LONDON**

Drawing Title  
**Second Floor  
 Mechanical Ventilation Layout**

Project No	Drawn & Checked by	Reviewed by
26/01045	PC	AW
Date	Scale	Issuing Office
AUG 13	1:100@ A1	Cambridge

DRAWING NUMBER								
Project Code	Orig.	Zone	Level	Type	Role	Class.	Number	Rev.
2601045	HL	XX	02	SK	M	570	0022	A