


- NOTES:
1. The drawing does not necessarily show all the information needed to interpret the design intent or the construction details.
 2. The drawing contains information from more than one source and must be read in conjunction with all relevant specifications.
 3. Any apparent drafting errors and differences between other drawings and specifications shall be brought to our attention.
 4. Xref Reference - BDP Dwg No. P2005698(15)AP021_Rev D

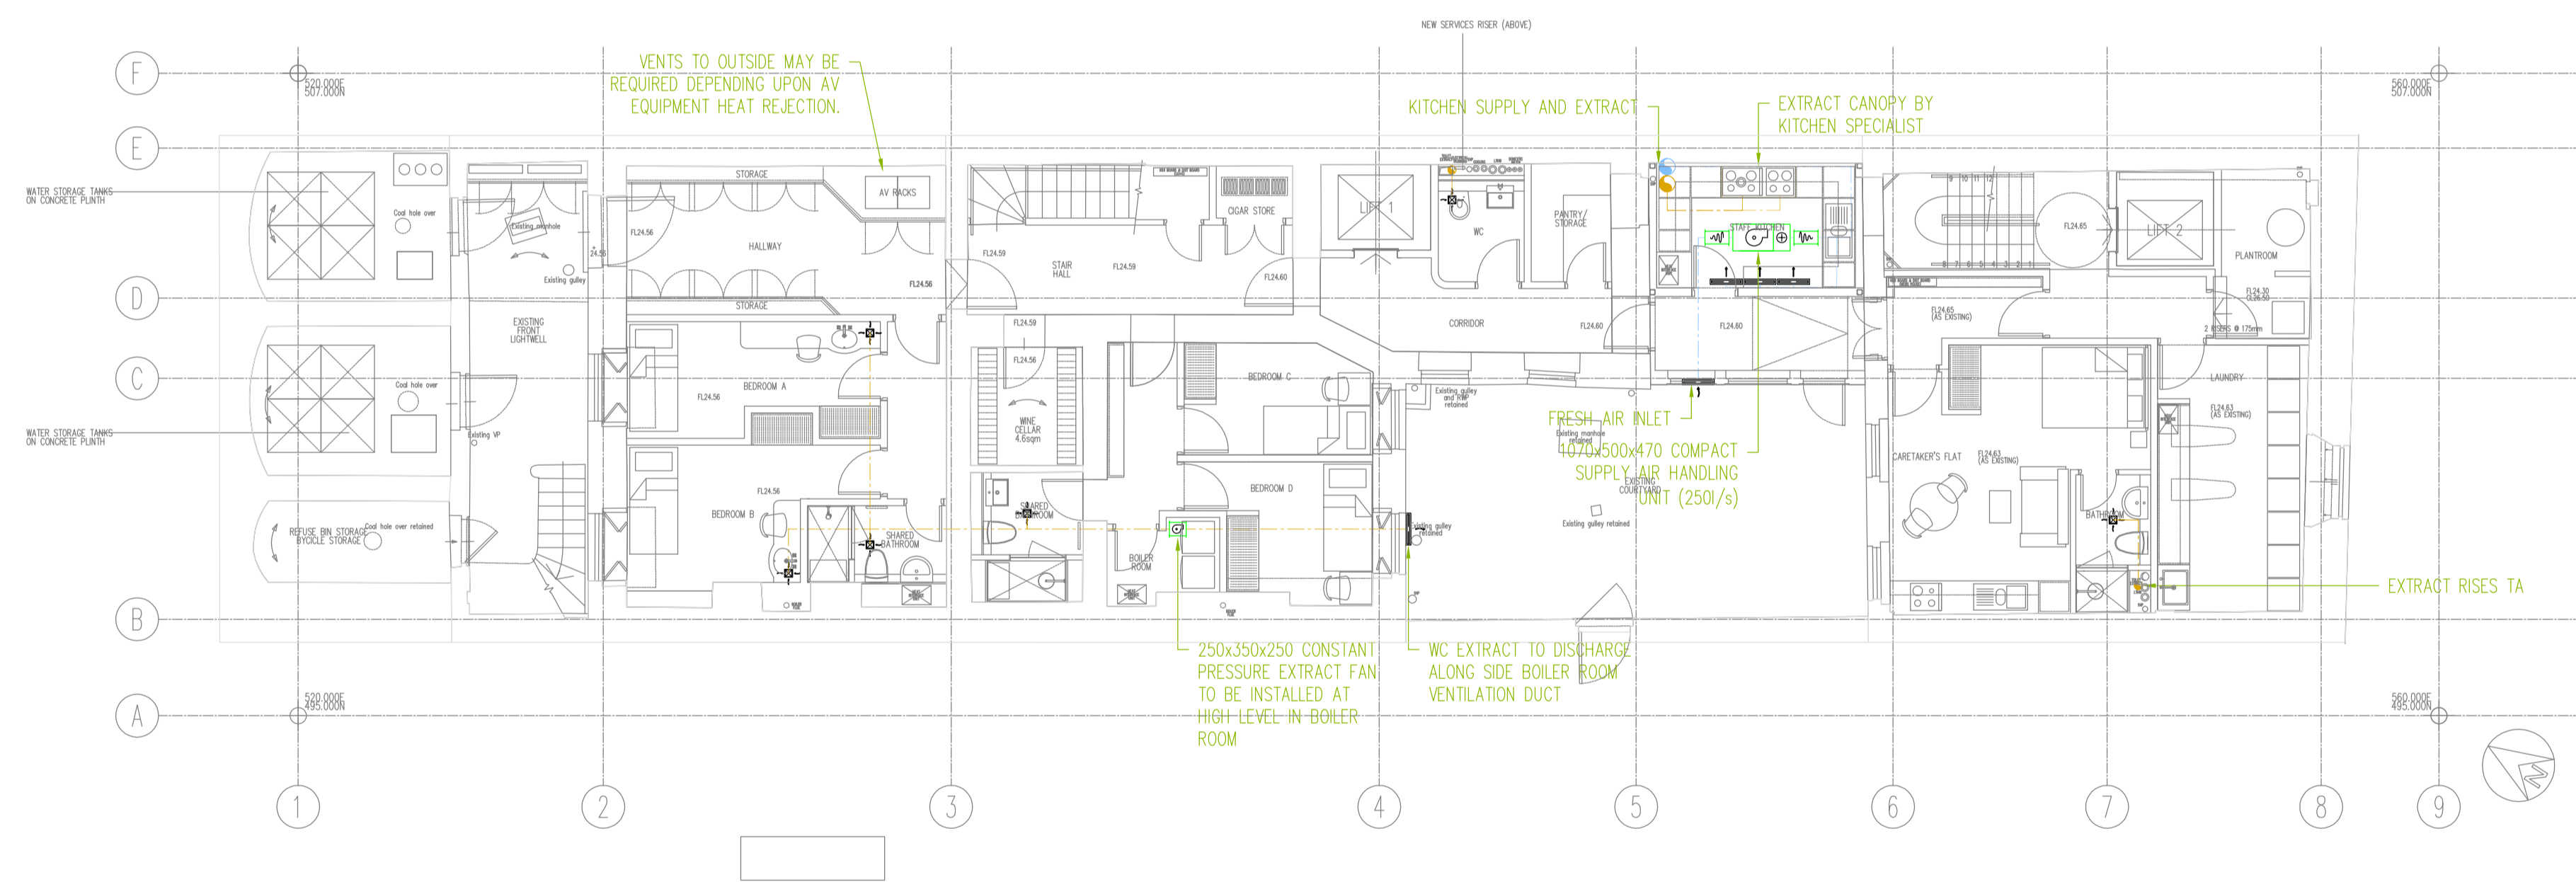

C	NOTATION UPDATED FOLLOWING COMMENTS	TS	TW	JUN'15
B	XREF UPDATED	TS	TW	JUN'15
A	PLANNING ISSUE	DB	KS	AUG'13
Index	Description	Drawn & Chk'd by	Rev'd by	Date

Revisions

Architect
BDP.

Client

PLANNING

HOARE LEA

BIRMINGHAM
BRISTOL
CAMBRIDGE
CARDIFF
ISLE of MAN
LEEDS
LONDON
MANCHESTER
OXFORD
PLYMOUTH
POOLE

www.hoarelea.com

Project Title
**42 BEDFORD SQUARE
LONDON**

Drawing Title
**Basement Level
Mechanical Ventilation Layout**

Project No	Drawn & Checked by	Reviewed by
26/01045	PC	MJ
Date	Scale	Issuing Office
AUG 13	1:100@ A1	CAMBRIDGE

DRAWING NUMBER								
Project Code	Orig.	Zone	Level	Type	Role	Class.	Number	Rev.
2601045	HL	XX	00	SK	M	570	0019	C