

FOR PLANNING

ATHÉ
DESIGN & INTERIORS

15A Harecourt Road, London N12 1LW
T. 07760 498 009 E. studio@athedesign.com

Job

44 Platts Lane, London NW3 7NT.

Drawing title



DRAINAGE PLAN

Scale 1 : 100 @ A3

Date	Drawn	Issued	Checked
02.07.2015	VS	VS	VS

Drwg. No. **017** / Rev.

NEW DOWNPIPES / RAINWATER DRAINAGE SHOWN IN RED
NEW WASTEWATER DRAINAGE SHOWN IN BLUE
ALL OTHER DRAINAGE / DOWNPIPES TO REMAIN AS PER EXISTING

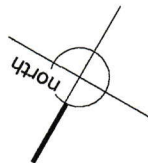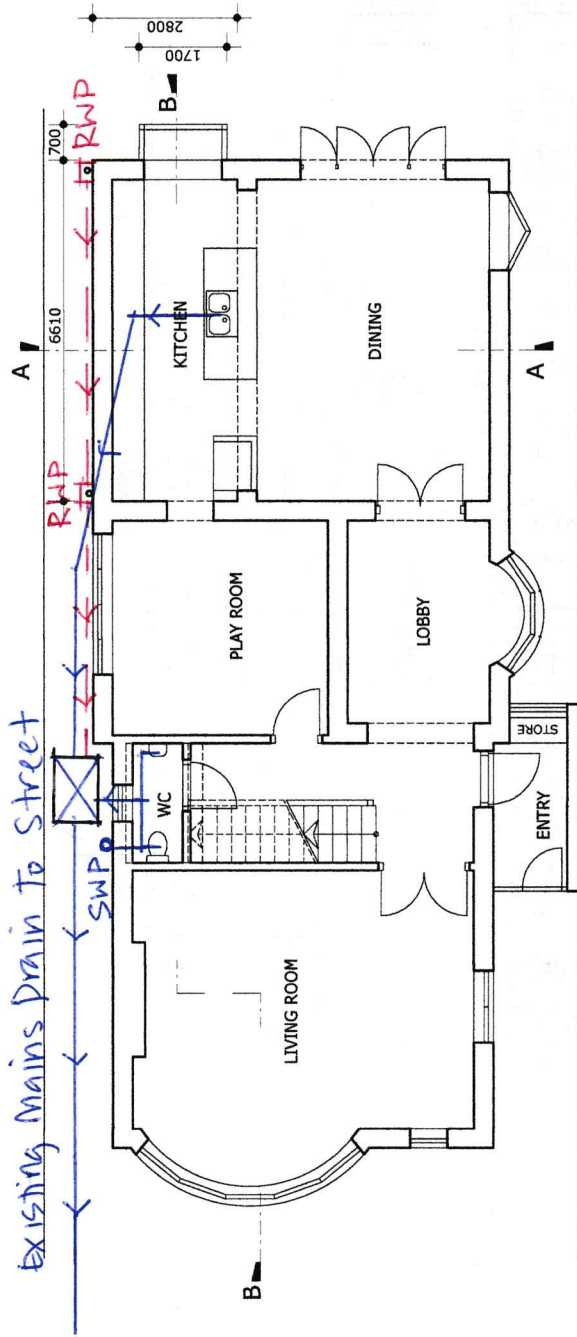

PLATTS LANE