




01 M_Level R05 - Ventilation Layout
1:50

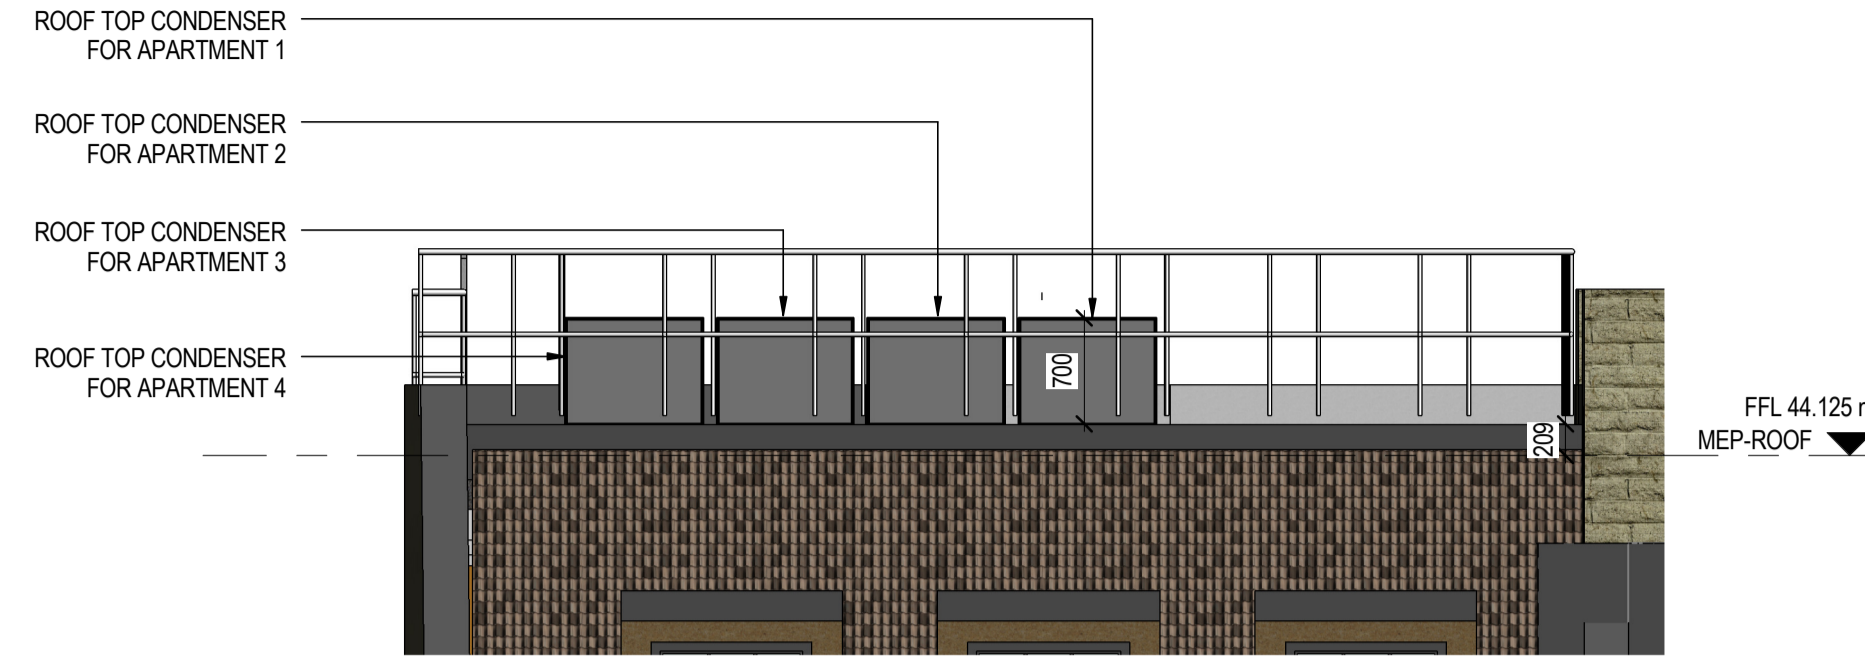

02 M_R05 Ventilation Section 01
1:50

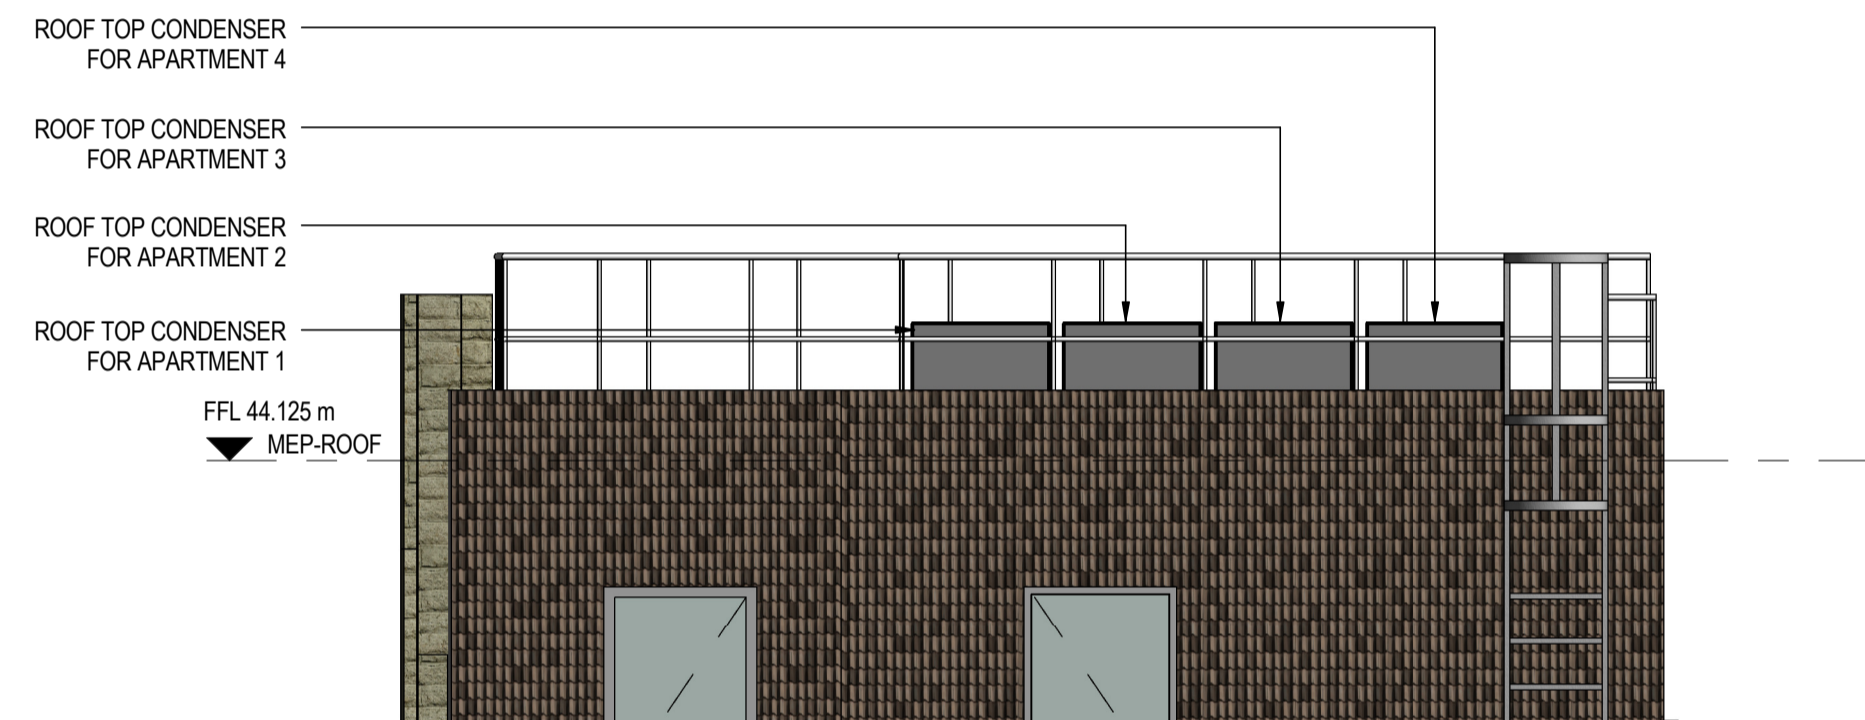

03 M_R05 Ventilation Section 02
1:50

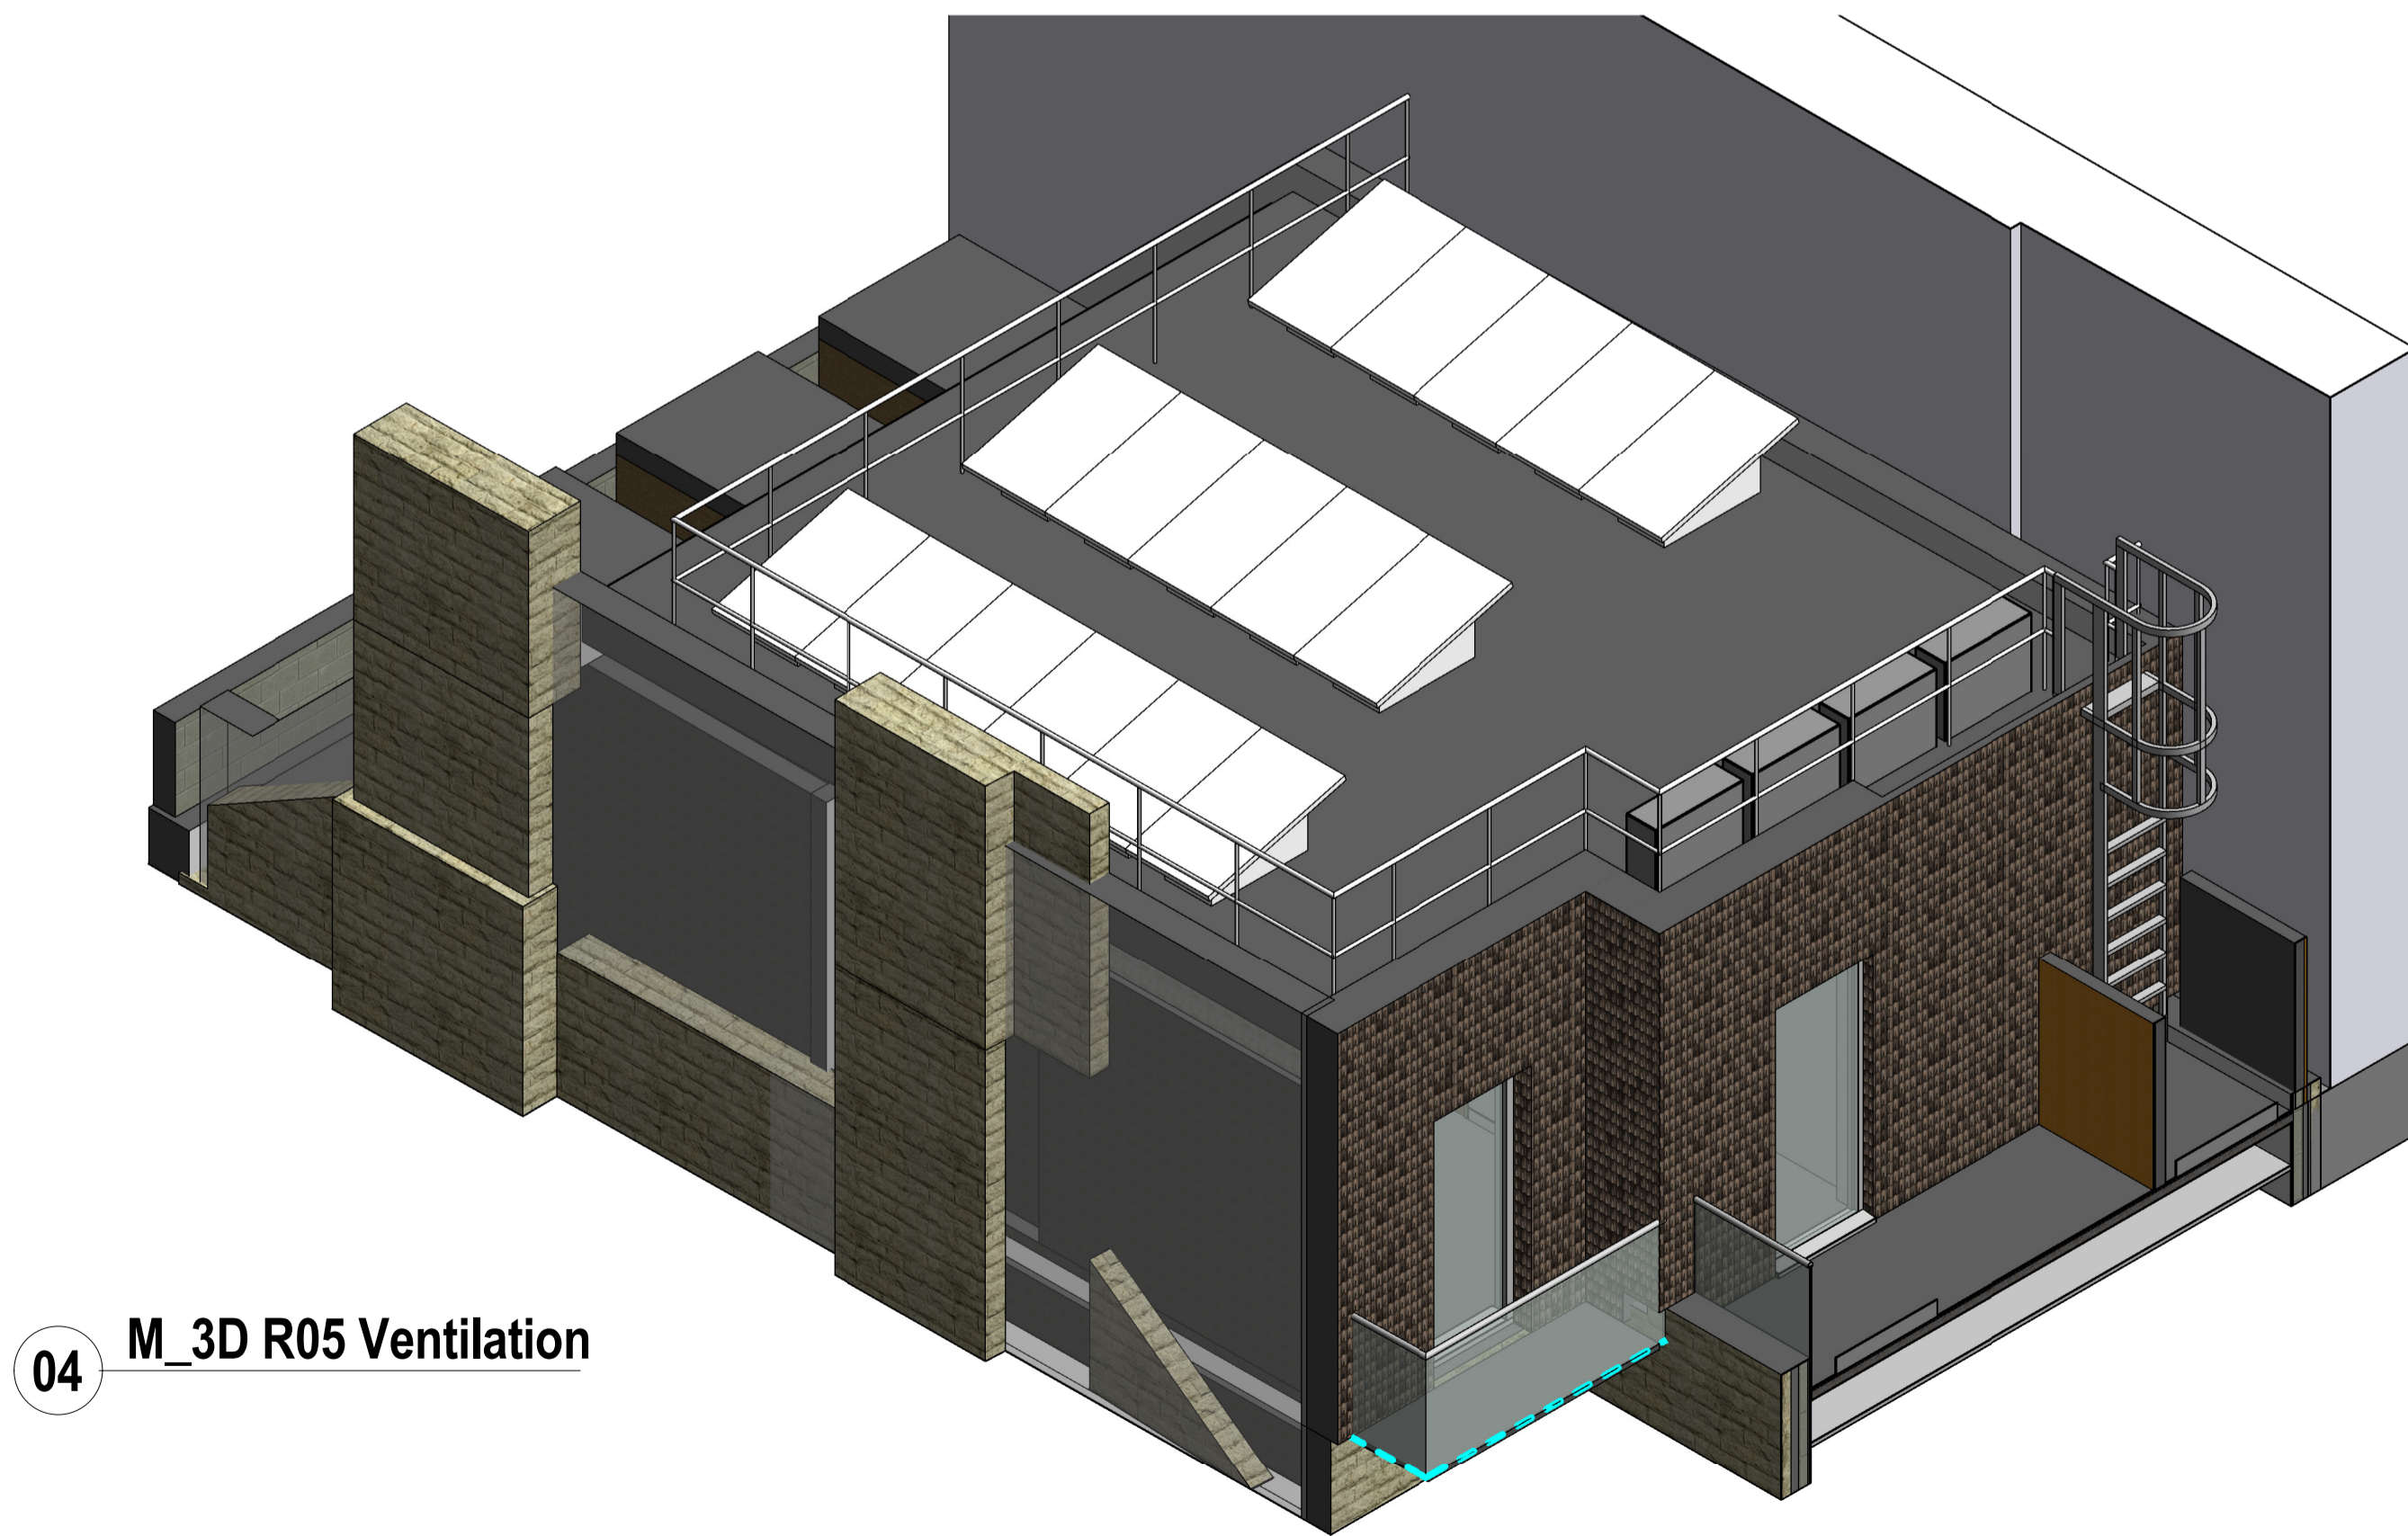

04 M_3D R05 Ventilation

NOTES

CONTRACTORS MUST VERIFY ALL DIMENSIONS ON SITE BEFORE COMMENCING ANY WORK ON SHOP DRAWINGS
DO NOT SCALE FROM THIS DRAWING
MCBAINS COOPER CONSULTING LTD COPYRIGHT

BIM TRANSMITTAL DISCLAIMER

MCBAINS COOPER CONSULTING LTD MAKES NO EXPRESS OR IMPLIED WARRANTIES WITH RESPECT TO THE CHARACTER, FUNCTION, OR CAPABILITIES OF THE DATA (INCLUDING OF 3RD PARTY DATA INCORPORATED WITHIN), OR THE SUITABILITY OF THE DATA FOR ANY PARTICULAR PURPOSE BEYOND THOSE ORIGINALLY INTENDED BY MCBAINS COOPER CONSULTING LTD. PLEASE REFER TO OUR STANDARD TERMS AND CONDITIONS FOR FURTHER DETAILS.

- NOTES
- PLEASE NOTE THAT THIS DRAWING SHOWS THE CONCEPT DESIGN INTENT ONLY. THE CONTRACTOR IS RESPONSIBLE FOR THE DETAILED DESIGN, FULL CO-ORDINATION INCLUDING SPATIAL FIT AND SIZING OF ALL SERVICES. THE DRAWING SHALL BE READ IN CONJUNCTION WITH THE MECHANICAL AND ELECTRICAL SPECIFICATION
 - ALL SERVICES SHALL BE COORDINATED WITH THE ARCHITECTS LAYOUTS AND TERMINAL POSITIONS OF GRILLES, LIGHTING, RADIATORS, ETC TO SUIT INTERNAL LAYOUTS
 - THE CONTRACTOR SHALL ENSURE THAT ALL M&E ITEMS AND BUILDERS WORK COMPLY WITH ALL LOCAL AUTHORITY, STATUTORY AND BUILDING CONTROL REQUIREMENTS. THE CONTRACTOR SHALL PROVIDE DETAILED INSTALLATION DRAWINGS FOR APPROVAL BY THE CLIENT

REV	AMENDMENT	DATE	CHKD
E	PV LAYOUT INCORPORATED, EQUIPMENT LOCATION REVISED	24-07-15	C.S.
D	ELEVATIONS ADDED, LAYOUT & NOTES UPDATED	20-07-15	C.S.
C	ISSUE TO ACOUSTIC SPECIALIST	14-07-15	C.S.
B	ISSUE FOR PLANNING	15-06-15	C.S.
A	TENDER ISSUE	01-05-15	C.S.

DRAWING STATUS: **TENDER**



MCBAINS COOPER CONSULTING LTD.
120 OLD BROAD STREET LONDON EC2N 1AR
TELEPHONE: 020 7786 7900 FACSIMILE: 020 7786 7999

CLIENT
KAHUNA

PROJECT
74 CHARLOTTE STREET

DRAWING TITLE
ROOF LEVEL VENTILATION LAYOUT PLAN / SECTION / DETAILS

MECHANICAL

SCALE: 1:50 @ A1
DRAWN BY: M.Y.
CHECKED: C.S.
DATE: FEB 15

DRAWING NUMBER	REVISION
LME57802_M_920_R05	E