

The significant unusual hazards / risks associated with this type of work are noted as:

CONSTRUCTION			
CI	NONE	NONE	NONE
CII	NONE	NONE	NONE
OPERATION AND MAINTENANCE			
OI	NONE	NONE	NONE
OII	NONE	NONE	NONE
DISMANTLING/DEMOLITION			
DI	NONE	NONE	NONE
DII	NONE	NONE	NONE


NOTE - TO BE READ IN CONJUNCTION WITH RISK REGISTER

GENERAL NOTES:

- DO NOT SCALE THE DRAWINGS
- ALL BUILDING SERVICES DRAWINGS TO BE READ IN CONJUNCTION WITH MECHANICAL & ELECTRICAL SPECIFICATIONS & SCHEDULES
- THIS DRAWING SHALL ONLY BE USED FOR THE SPECIFIC SERVICES INTENDED
- DIMENSIONS TO BE CHECKED ON SITE BEFORE ANY WORK IS PUT IN BY HAND OR PREFABRICATED
- FINAL ACCESS & SETTING OUT OF SERVICES TO BE AGREED WITH ARCHITECT
- UNLESS OTHERWISE STATED ALL DIMENSIONS IN MILLIMETERS
- REFER TO STANDARD DETAILS
- REFER TO 28731-SOAS-E-SYM-GEN-XX-850 FOR STANDARD SYMBOLS AND ABBREVIATIONS
- THIS DRAWING IS COPYRIGHT AND SHALL NOT BE USED WITHOUT PERMISSION
- FINAL LOCATIONS OF DOOR LOCK COMMUNICATIONS HUB SUBJECT TO MANUFACTURER'S SITE SURVEY

REV	DATE	DESCRIPTION	DWN	CHK/APP
6	03.08.15	PRE-CONSTRUCTION - LIGHT FITTINGS TYPE AG + AGE ADDED AND TYPE A + AE REINSTATED WHERE APPLICABLE	SH	MF/DP
5	21.07.15	PRE-CONSTRUCTION - LIGHT FITTINGS TYPE A + AE OMITTED	SH	MF/DP
4	01.05.15	PRE-CONSTRUCTION	SH	KM/DP
3	22.08.14	PRE-CONSTRUCTION	SH	RS/DP
2	12.08.14	PRE-CONSTRUCTION	SH	RS/DP
1	01.08.14	PRE-CONSTRUCTION	PJS	RS/DP

KEY PLAN

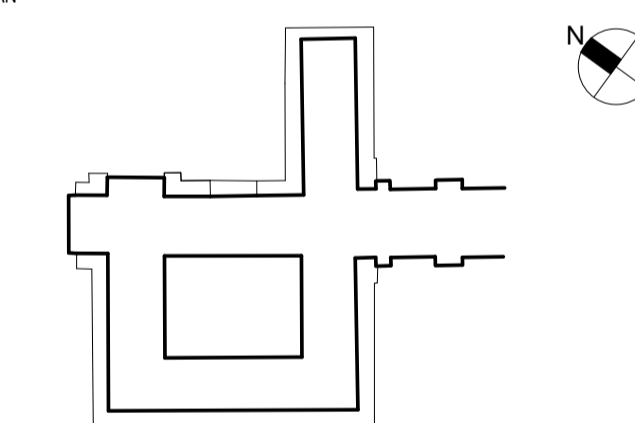

PROJECT STATUS: **PRE-CONSTRUCTION**



155 Moorgate, London, EC2M 6XB
 www.macegroup.com

PROJECT TITLE:
**SOAS INTO SENATE HOUSE
 MALET STREET
 LONDON, WC1E 7HU**


DRAWING TITLE:
**ELECTRICAL SERVICES
 LIGHTING LAYOUT
 GROUND FLOOR**

PROJECT NO.	DRAWN BY	SH	DATE	01.08.14
28731	CHK BY	RS	DATE	01.08.14
	APPD BY	DP	DATE	01.08.14

PROJECT CODE	DISC.	VIEW TYPE	VIEW CAT.	LEVEL	DWG. NO.
SOAS - E - PLN - LTG - 00 -					111
SHEET NO.	SCALE	ORIG. SHEET SIZE	REV.		
1 of 1	1:100	@ A1	C 6		

INFORMATION HANDLING CLASSIFICATION

UNRESTRICTED

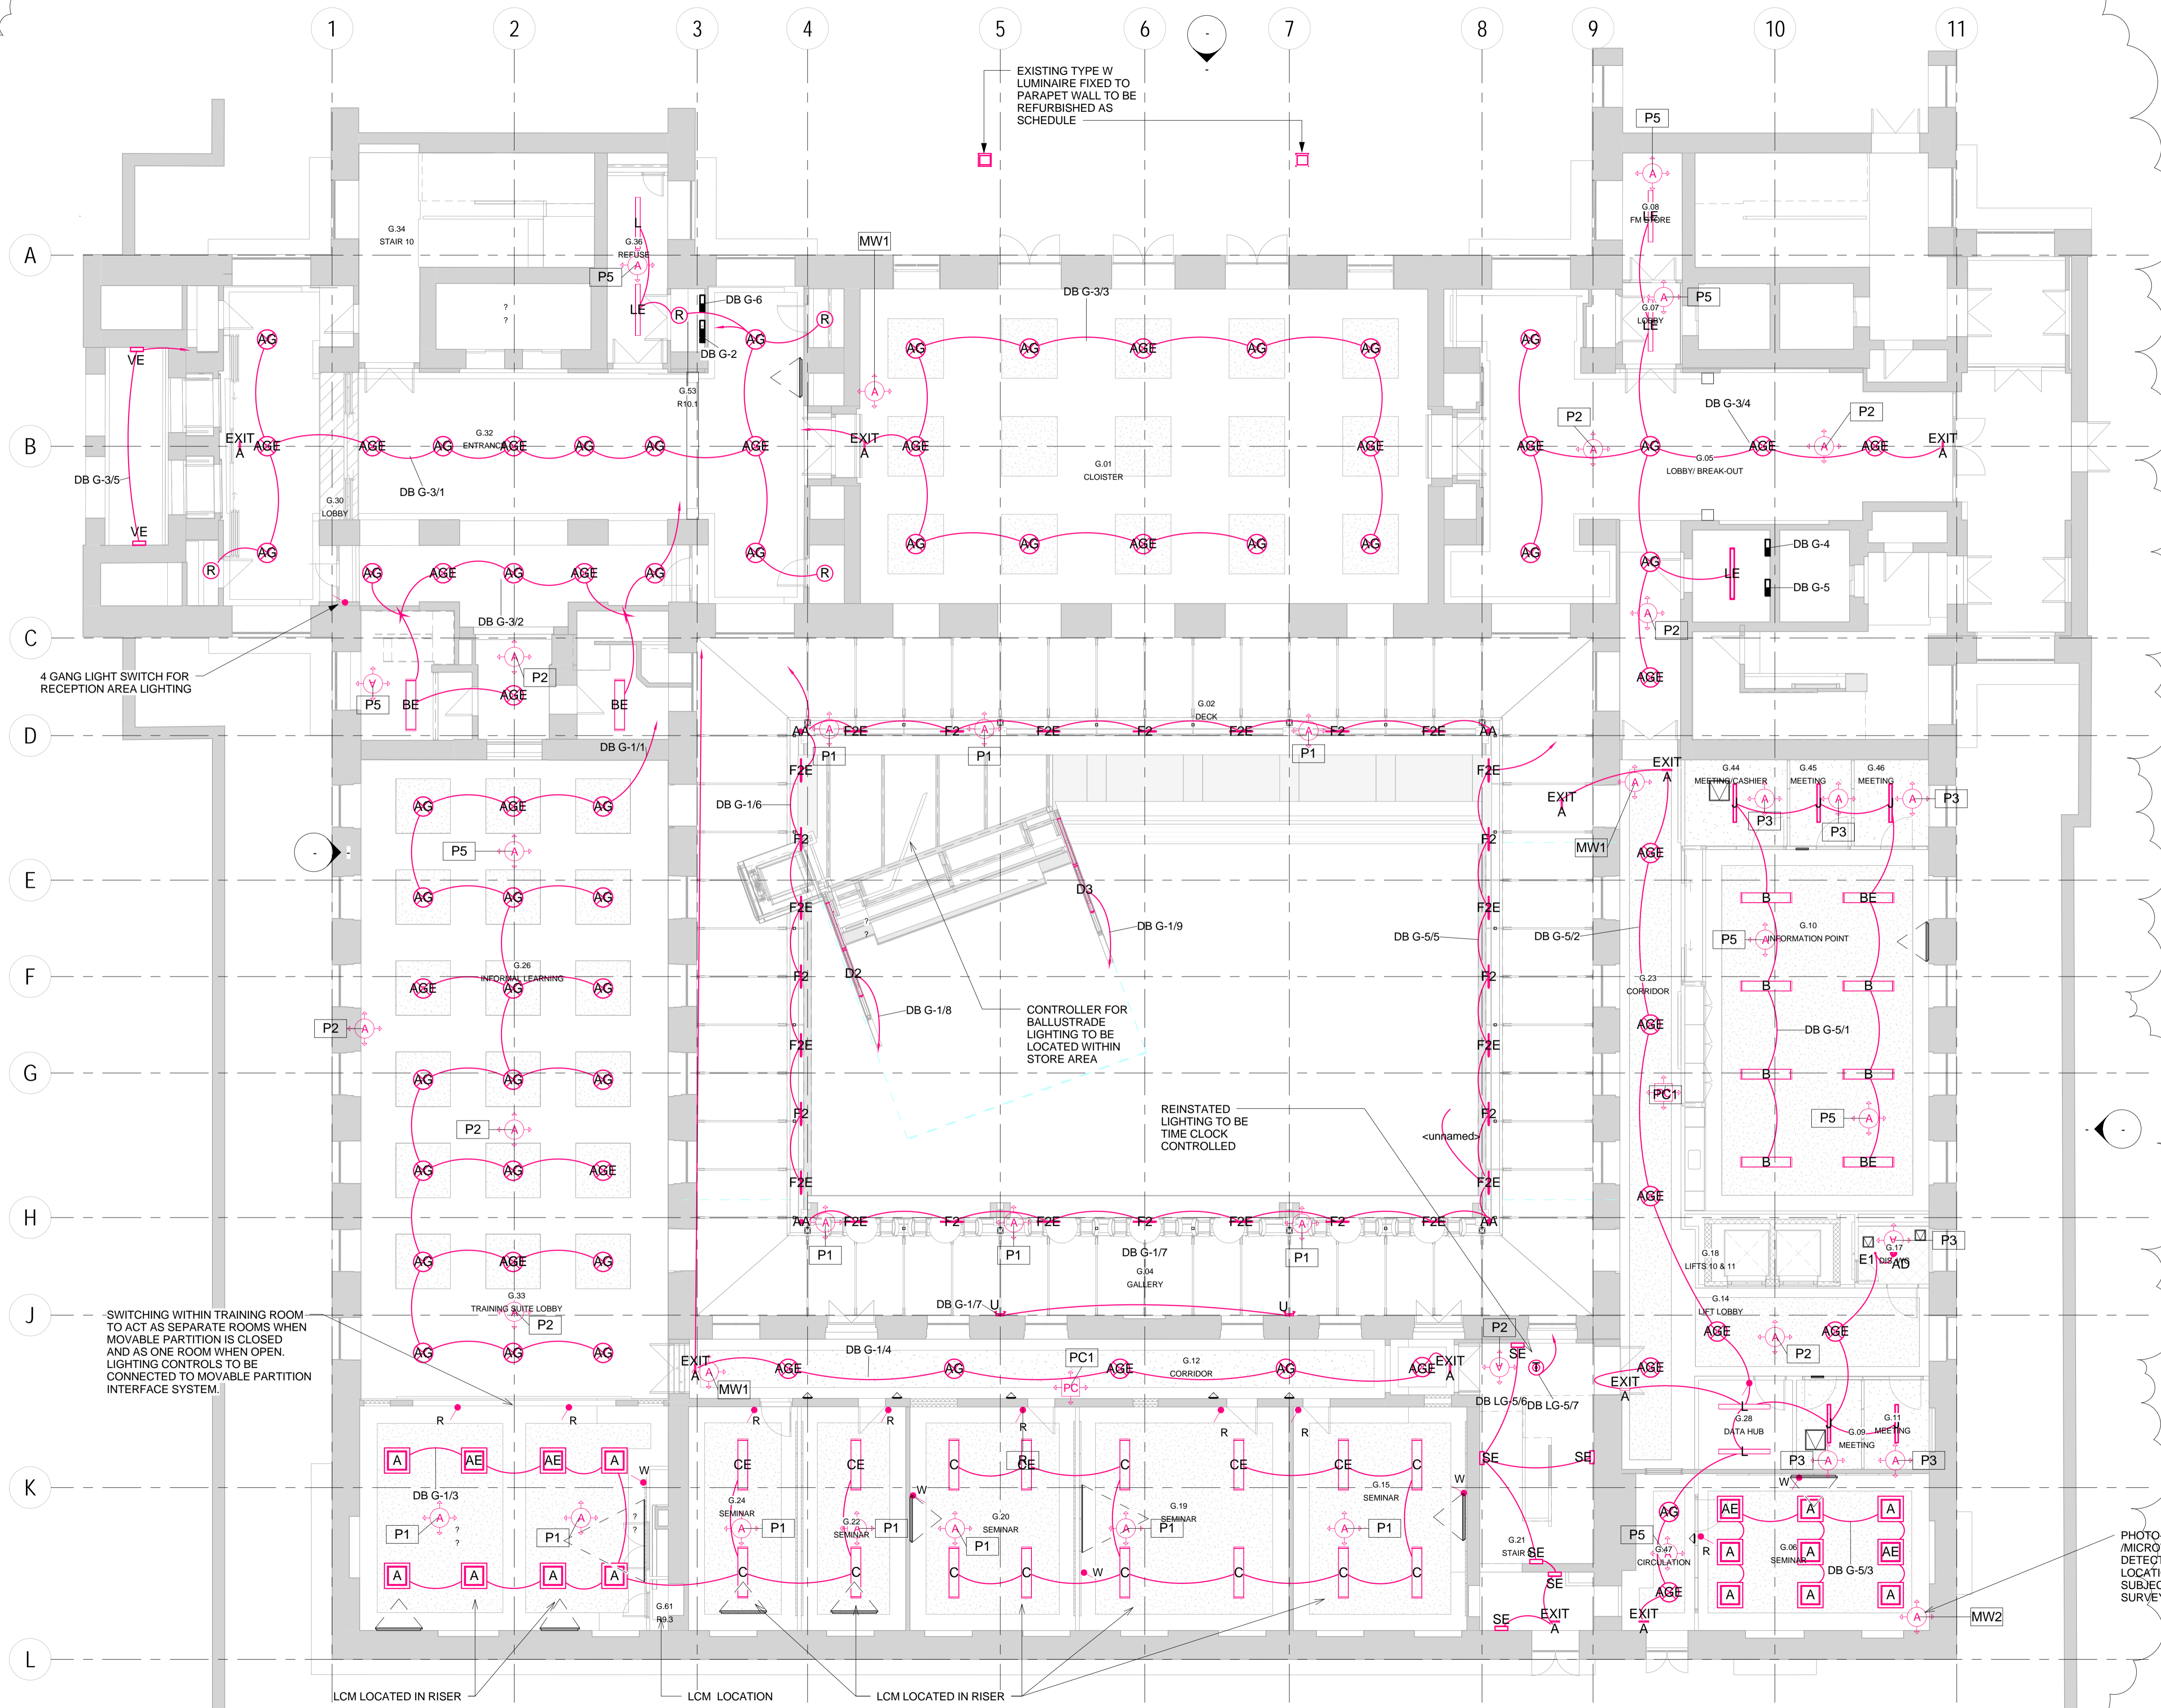

02 Ground Floor - Lighting
 1:100