 



PROPOSED GROUND FLOOR PLAN



ELECTRICAL KEY

- 1 way light switch
- ⊕ Wall mounted exterior bulkhead light fitting with sensor
- ▶ Dome camera external & internal
- Lighting wiring layout

NOTE:
 Exterior lighting to be BS 5489 with no bollard lighting.
 All CCTV's to comply and registered with the Data Protection Act 1998 (DPA) issued by the Information Commissioner's Office (ICO)

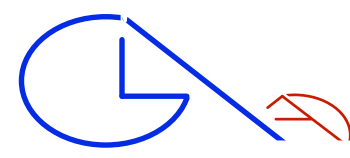

GLA Architecture and Design
 Southgate Office Village, Block E, First Floor,
 286A Chase Road, London, N14 6HF
 T 020 8886 5100 F 020 8886 0669 E g@glaad.co.uk

Revision:- A1: 03.08.15: dk : Exterior lighting & CCTV note added.

Client S. ASPRIS & SON LTD.		
Main Contractor		
Project PROPOSED RESIDENTIAL & COMMERCIAL UNITS TO 17 & 19 FERDINAND STREET, LONDON NW1 8EU		
Drawing Title PROPOSED GROUND FLOOR PLAN SHOWING CAMERA POSITIONS & EXTERNAL LIGHTING		
Scale 1:200 @ A3	Date June 2015	Drawn By SH
Project No. 1002	Drawing No. 28	Rev. A1
DO NOT SCALE THIS DRAWING. ALL DIMENSIONS TO BE CHECKED ON SITE		
DRAWING STATUS		
A SCHEME - Outline/Scheme drawings for proposals, budgets, etc.		
B DESIGN DEVELOPMENT - Evolving final design drawings for approvals, tenders, billing etc.		
C CONSTRUCTION - Fully developed drawings issued under instruction for construction.		
ONLY STATUS 'C' DRAWINGS TO BE USED FOR CONSTRUCTION PURPOSES		