


FIRST FLOOR

Existing

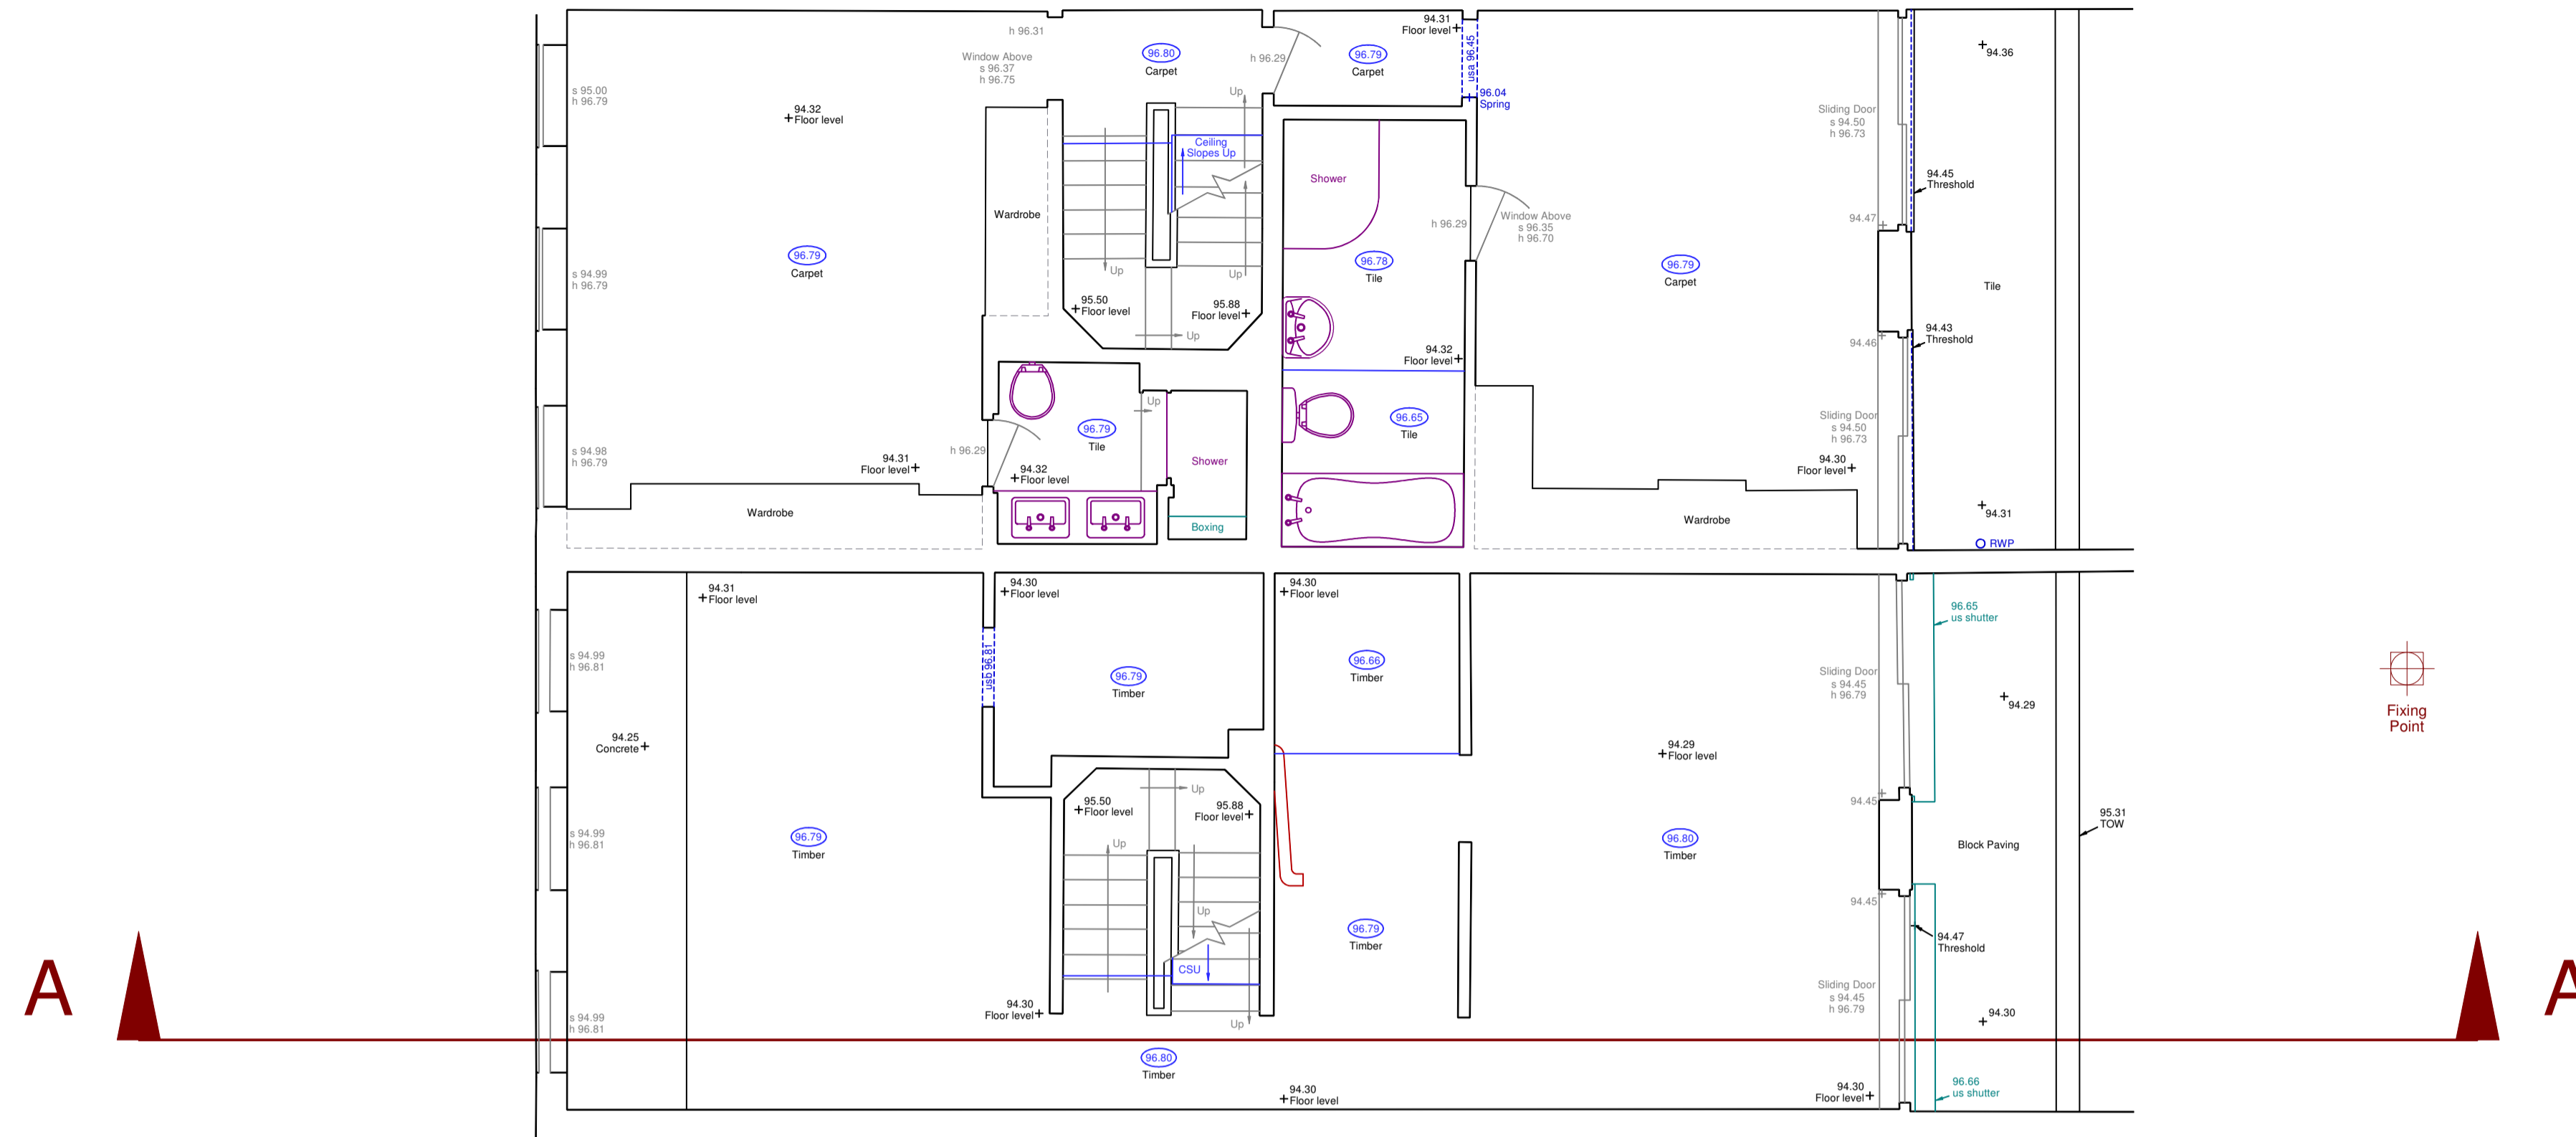

NOTES

- LEVELS ARE RELATED TO OSBM LOCATED ON WALL OF NO. 28 / 30 REDINGTON ROAD. LEVEL GIVEN AS 98.033 METRES.
- SURVEY HAS BEEN CARRIED OUT TO AN ACCURACY COMMENSURATE WITH A 1:50 SCALE DRAWING.

ABBREVIATION LIST

AC	AIR CONDITIONING VENTS OR EQUIPMENT
BSU	BEAM SLOPES UP
CSU	CEILING SLOPES UP
DP	DOUBLE PLUG
ELS	EMERGENCY LIGHT SWITCH
EP	ELECTRIC POINT
ESM	ELECTRIC SWITCH MACHINE
FA	FIRE ALARM
FL	FLOOR LEVEL
FS	FUSED ELECTRIC SWITCH
JB	JUNCTION BOX
L	LIGHT
LOB	LIFT CALL BUTTON
LS	LIGHT SWITCH
SP	SINGLE PLUG
TOC	TOP OF COUNTER
TOW	TOP OF WALL
WL	WALL LIGHT

WHERE THESE ARE FOLLOWED BY A MEASUREMENT THIS IS THE HEIGHT MEASURED FROM THE FLOOR.


GENERAL

AC	AIR CONDITIONING VENTS OR EQUIPMENT
ER	EARTHING ROD
GU	GULLY
IC	INSPECTION COVER
MK	MANHOLE
ST	STANCHION
SVP	SOIL AND VENT PIPE

s 1.00 SILL LEVEL
 h 1.00 HEAD LEVEL
 ub 1.00 LEVEL OF UNDERSIDE OF BEAM
 uel 1.00 LEVEL OF UNDERSIDE OF DUCTING
 up 1.00 LEVEL OF UNDERSIDE OF PIPE
 us 1.00 UNDERSIDE LEVEL
 (94.00) CEILING LEVEL
 (20.00) FALSE CEILING LEVEL

SECOND FLOOR

Existing

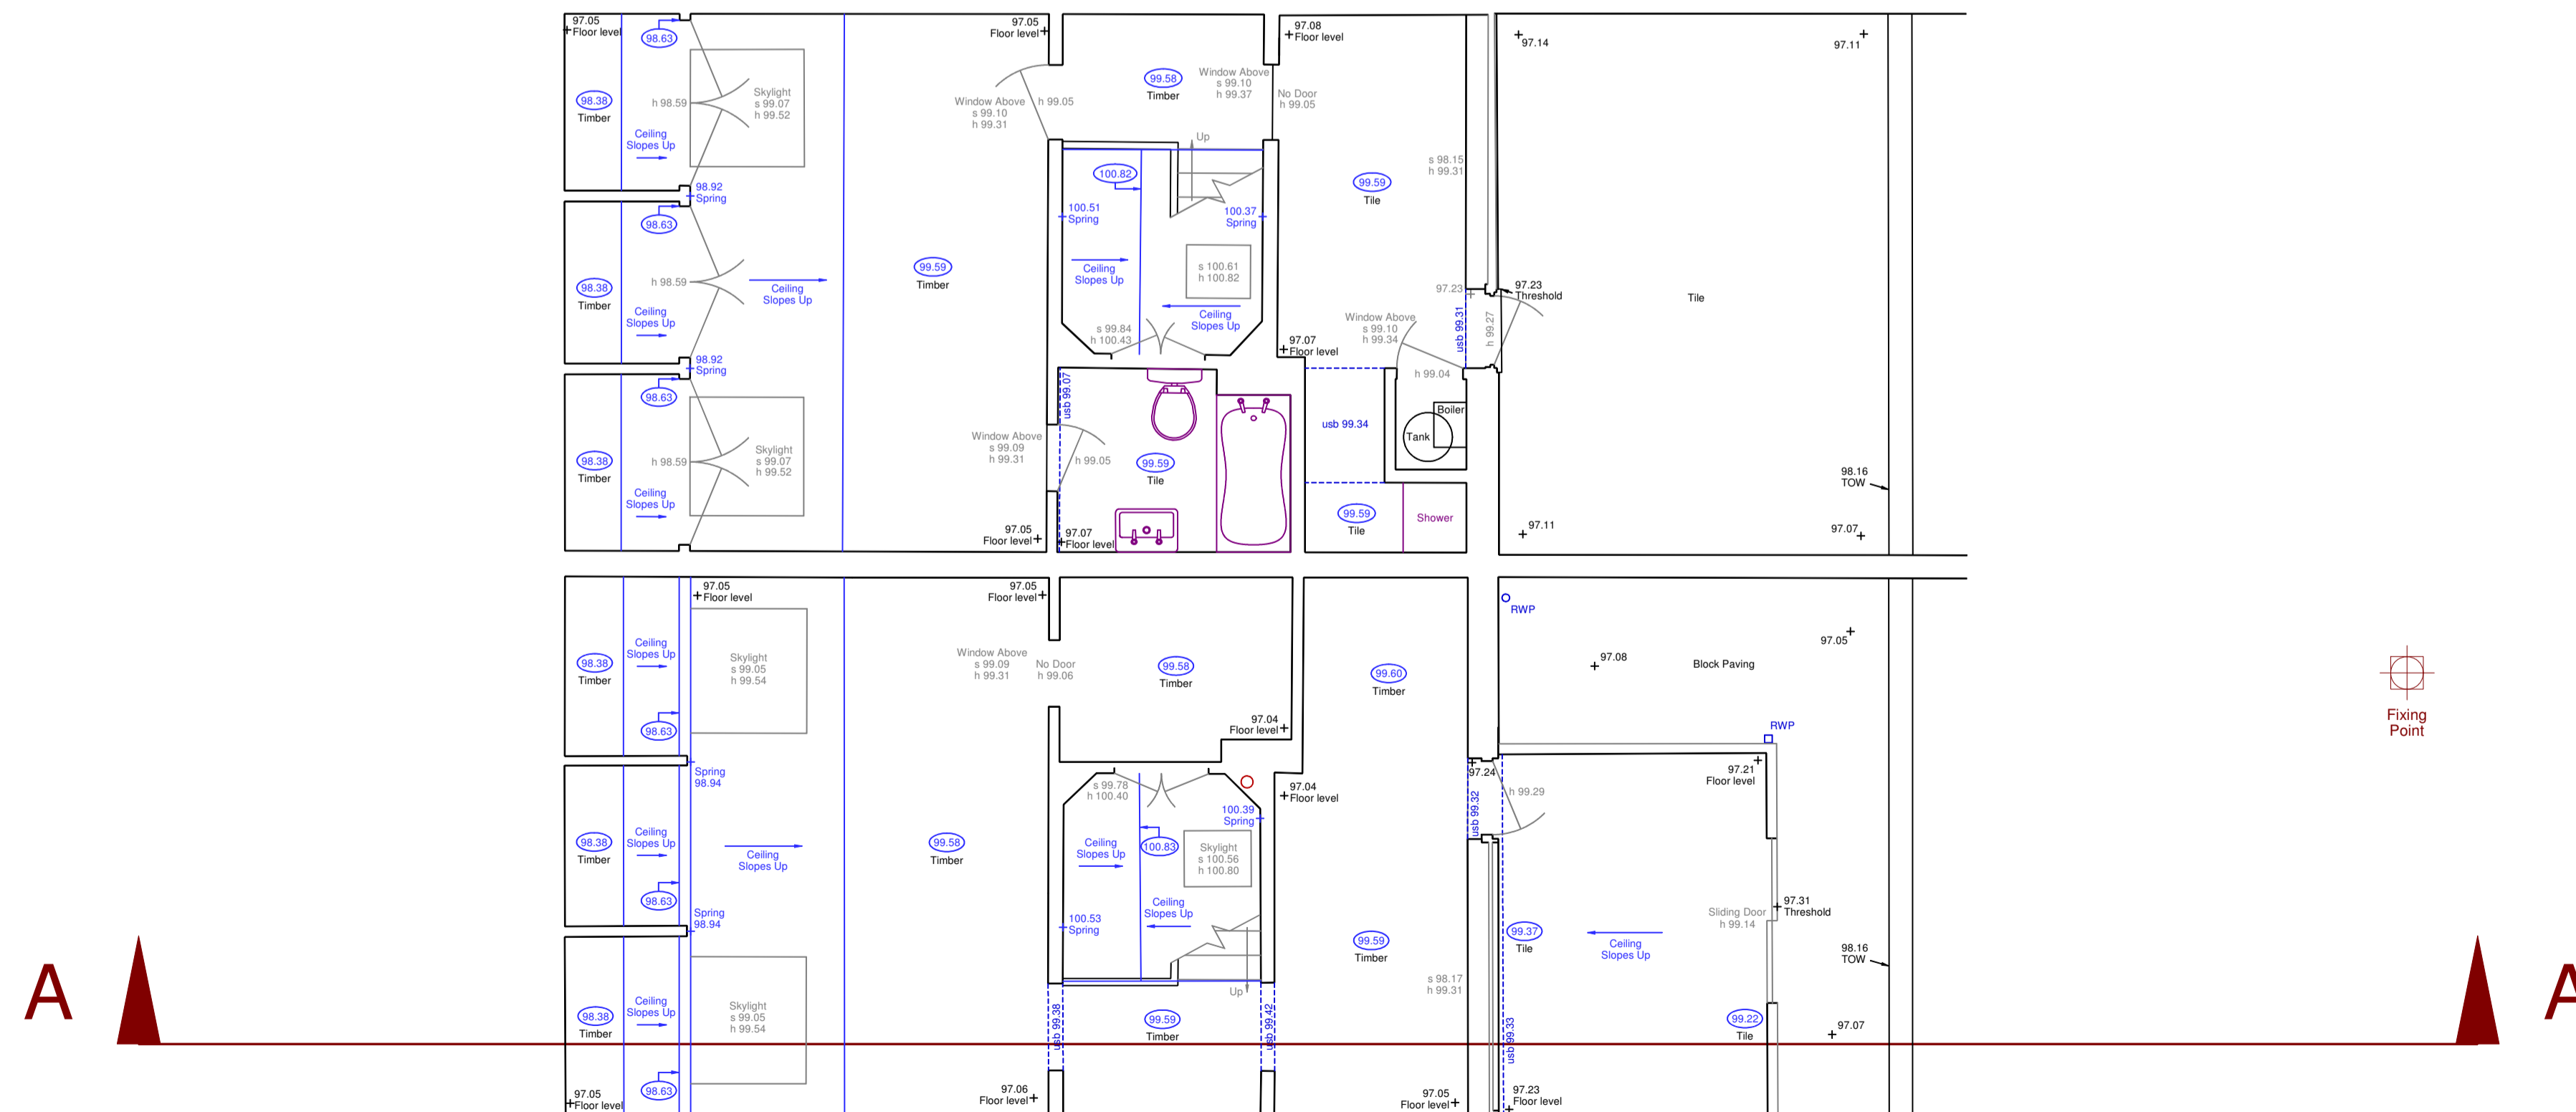

NO.	DATE	DETAILS

REVISIONS



74 WATCHET LANE
HOLMER GREEN
HIGH WYCOMBE
BUCKINGHAMSHIRE
HP15 6UG

Tel: 01494 718453
Fax: 01494 717576
e-mail: enquiry@kndsveys.com

CLIENT

MRS VALERIE WONG
&
MR KEVIN BROWN


JOB TITLE

1C + 1D OAKHILL AVENUE
NW3 7RD

DRAWING TITLE

EXISTING
FLOOR PLANS

Z
A

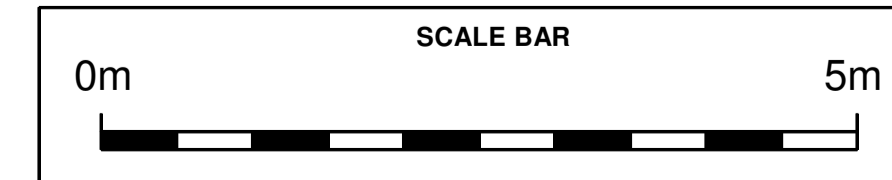

DRAWING No. K 12 14 - 12	DRAWN BY JS	DATE 27 NOV 2014
SURVEYED BY JS / AJF	SCALE 1:50	