

Do not scale from this drawing. Verify all dimensions on site. Drawing should be read in conjunction with information from all other design consultants and contractors. All drawings in digital format are for reference only, paper copies are available on request.

FOR PLANNING

© Maccreanor Lavington Ltd.




Brick wall to be removed

Gas meter housing to be relocated

Timber fence to be removed

Brick wall to be removed

Ventilation plant to be relocated

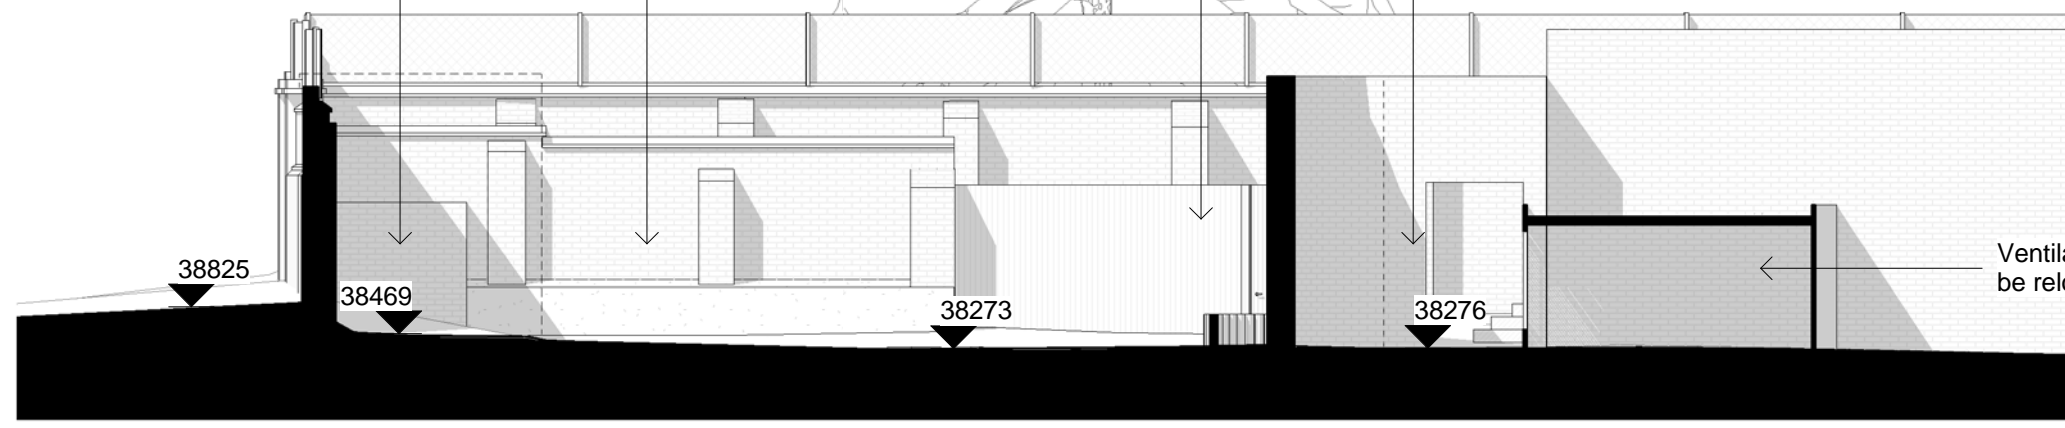

Messina Avenue

Yard

Service alley

Rev Details Drwn Chkd Date

MaccreanorLavington

3rd Floor
19-21 Nile Street
London, N1 7LL

t +44(0)20 7336 7353
f +44(0)20 7336 7655
e uk@ml-architects.com

Client
London Borough of Camden

Project
Kingsgate Primary School

Title: Existing - Block 4 (Science Classroom) Site
East Elevation

Scale: 1 : 100 @ A3

MLUK-419-A_L-00-0343