






EXISTING MECHANICAL PLANT LAYOUT

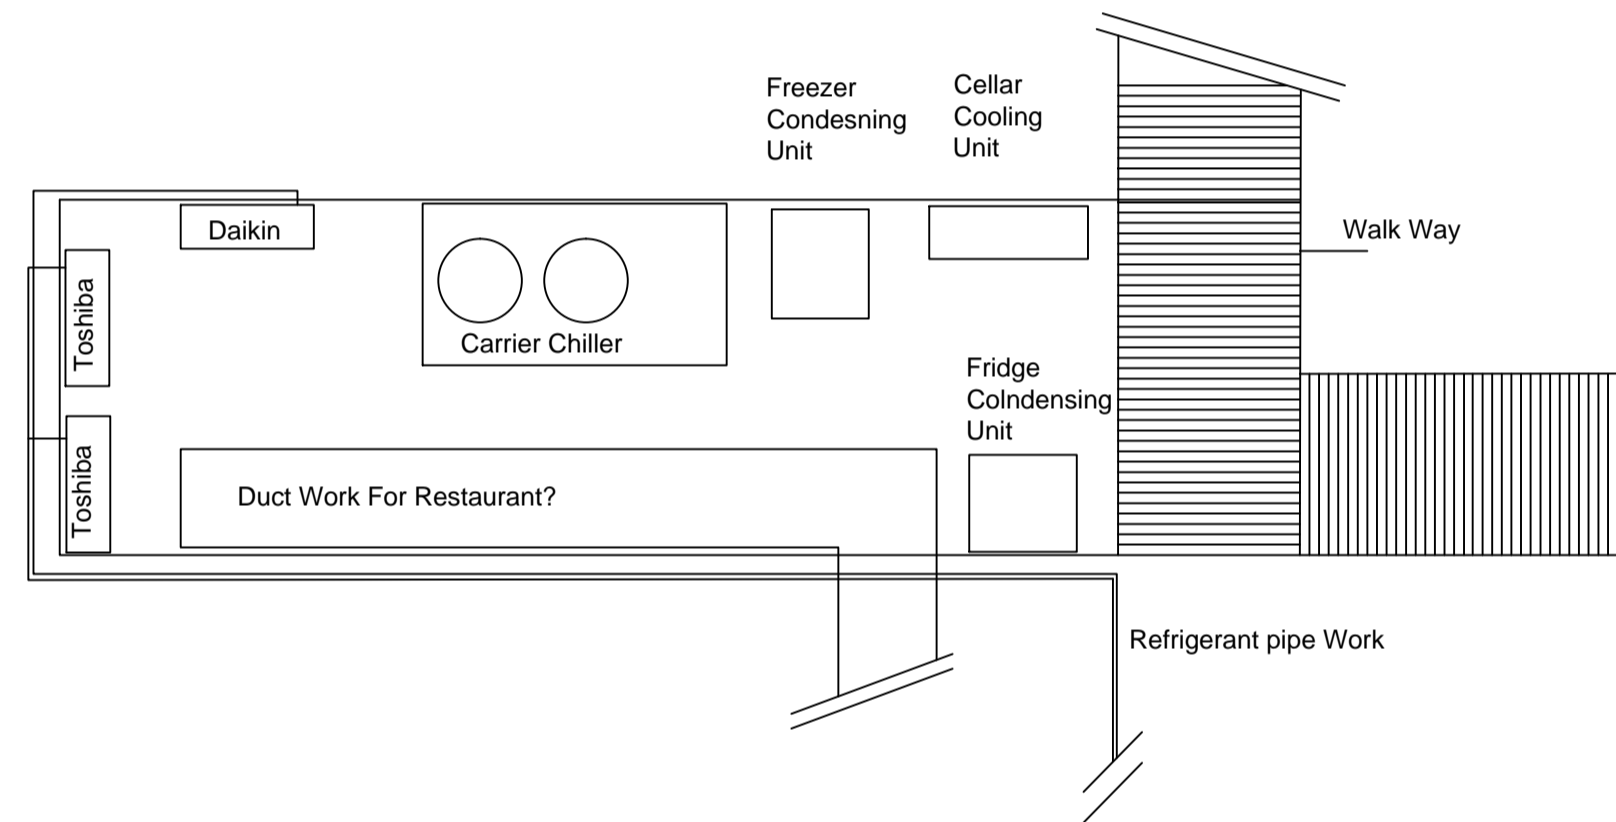


EXISTING ROOF PLANT LAYOUT

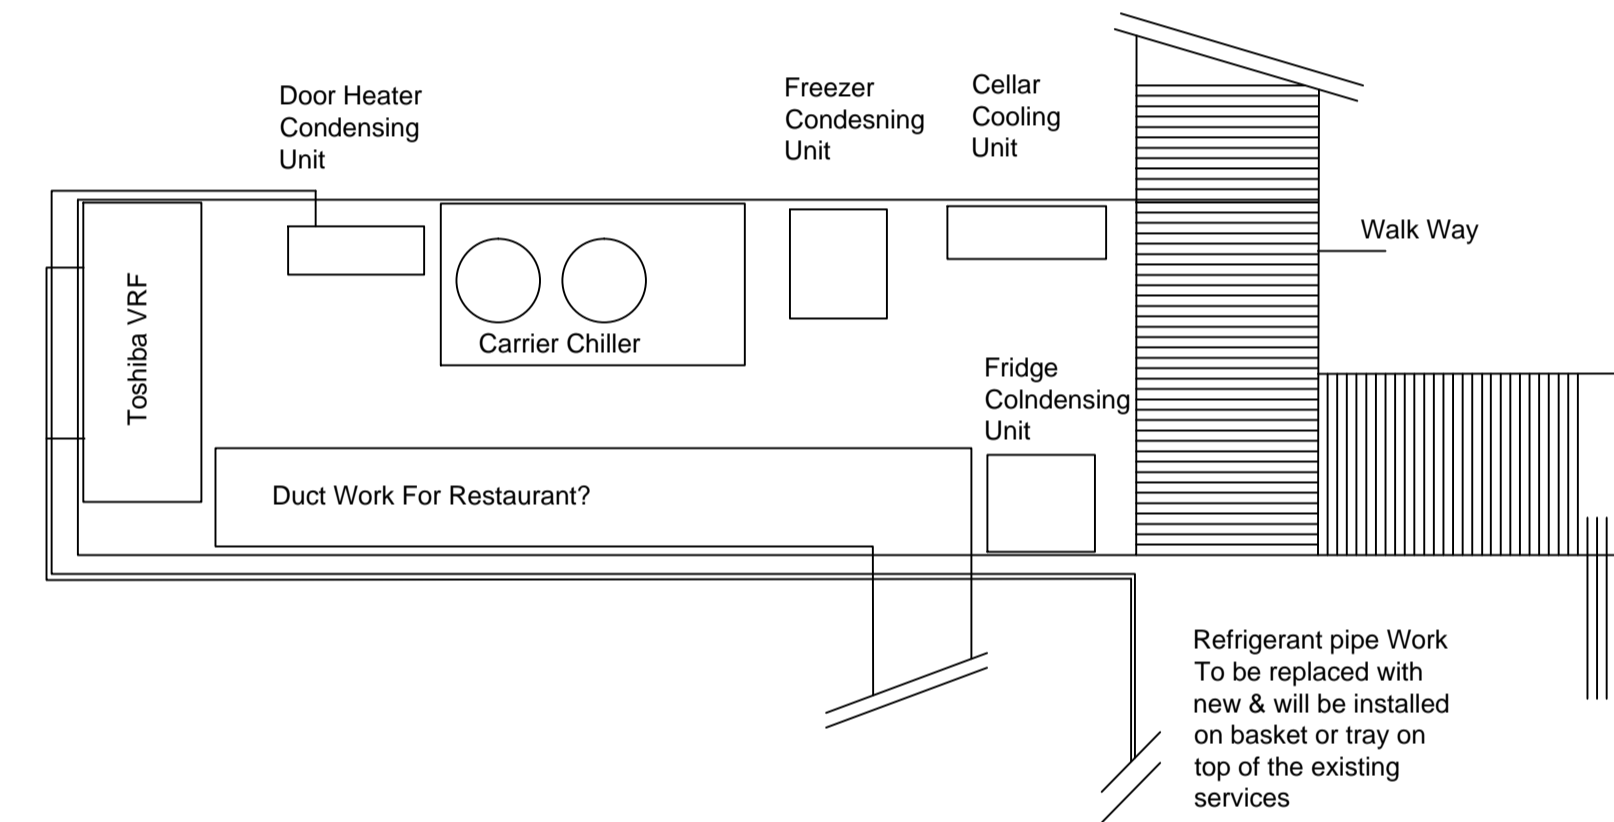

PROPOSED ROOF PLANT LAYOUT
OPTION 1

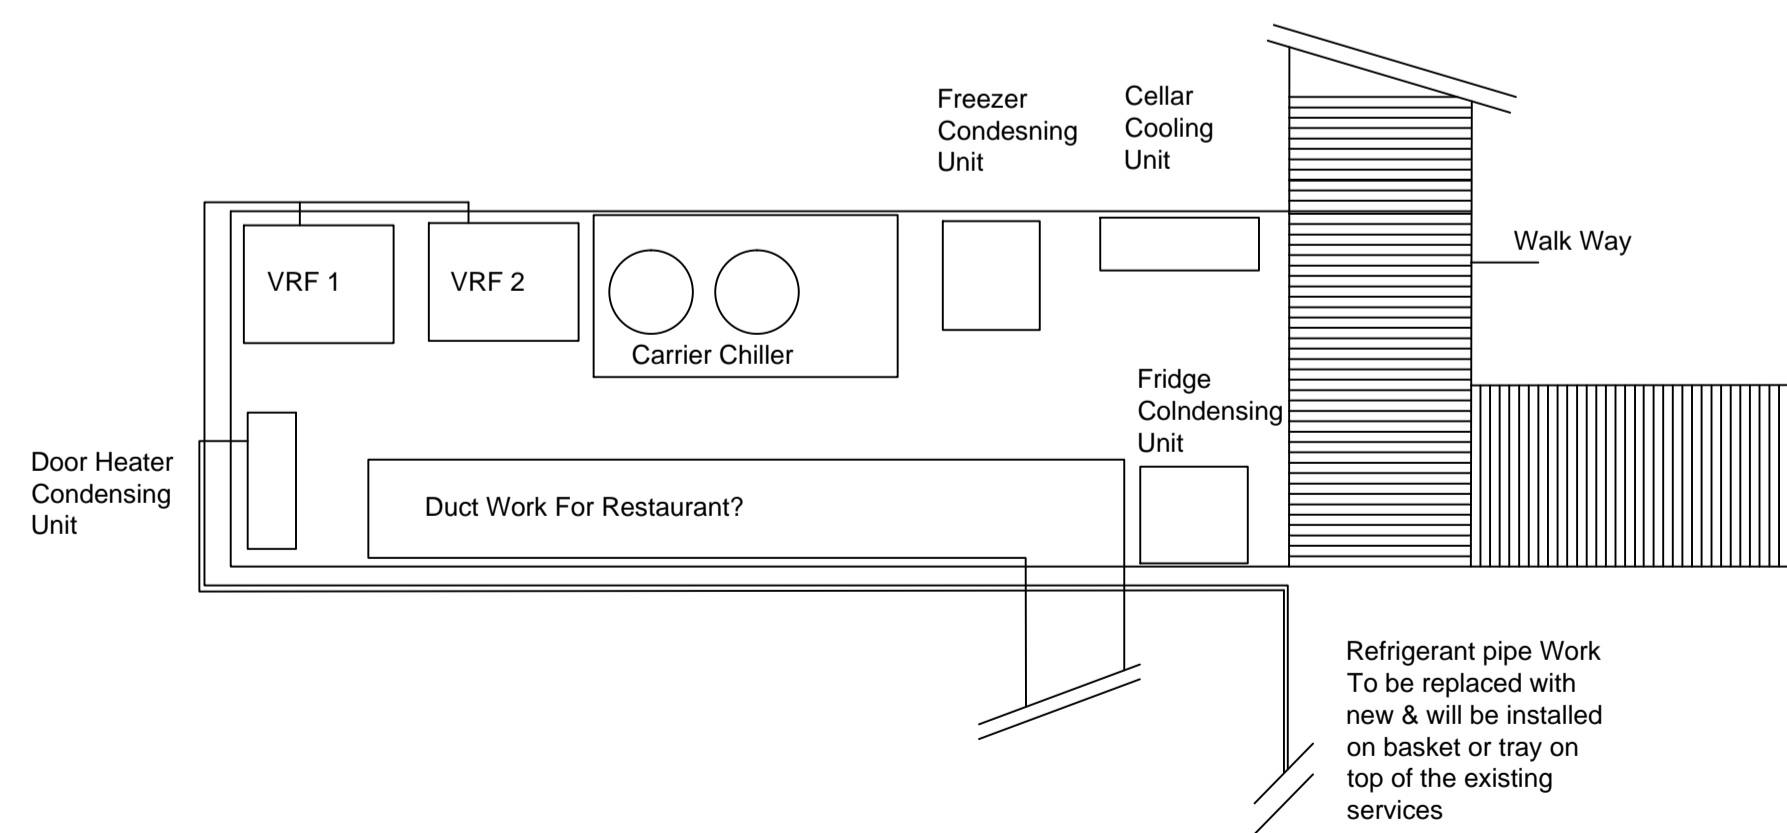

PROPOSED ROOF PLANT LAYOUT
OPTION 2

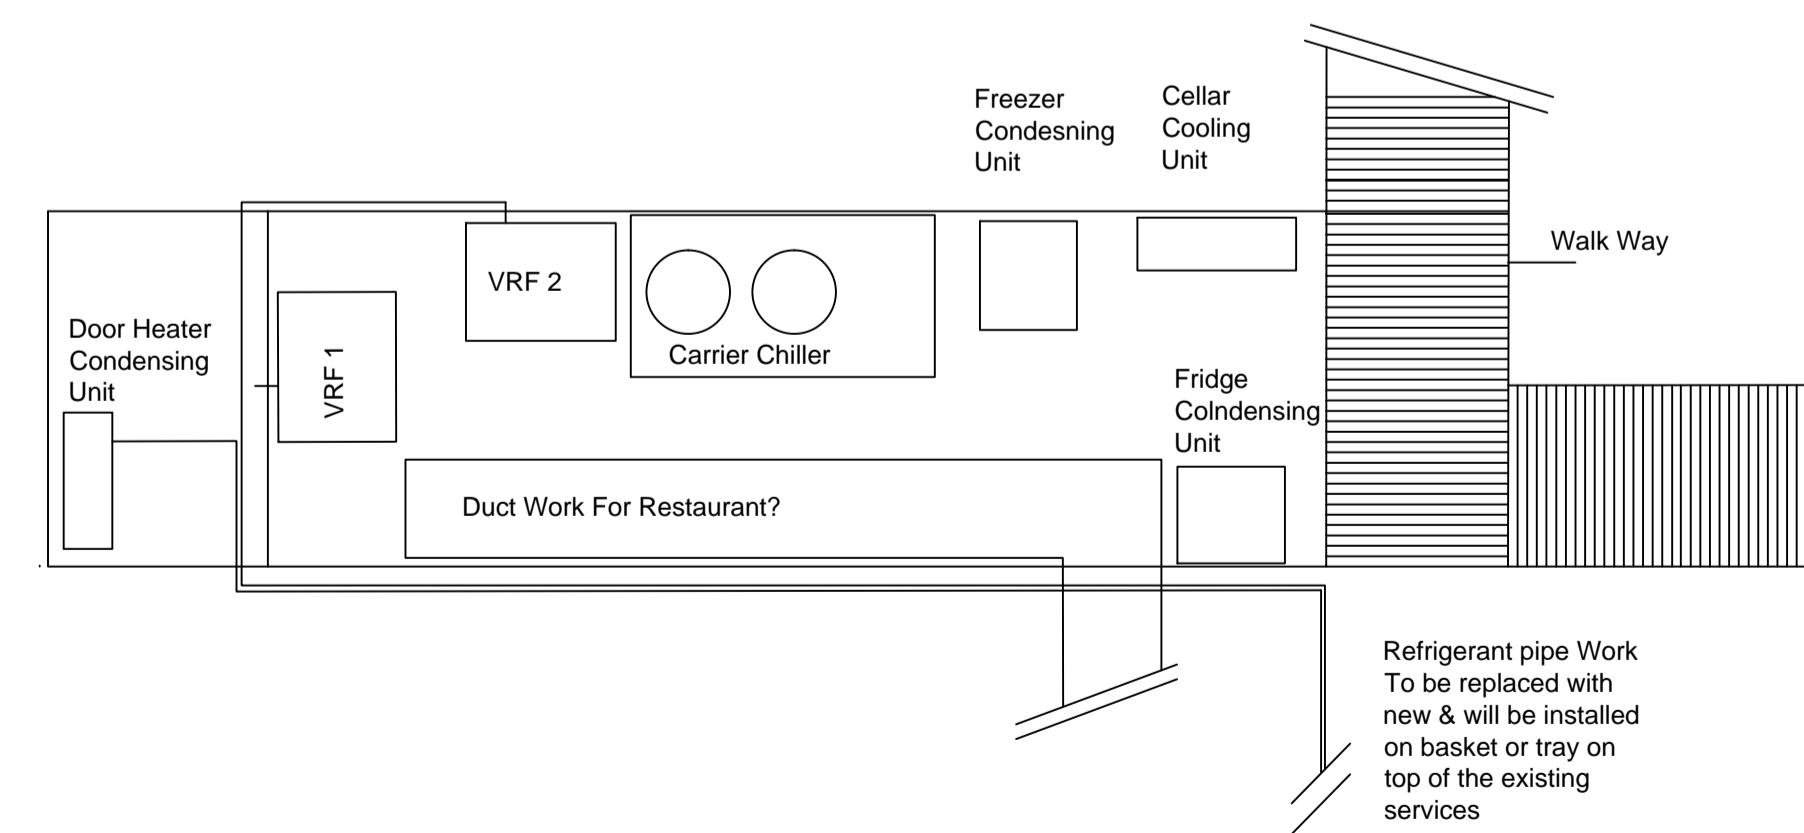

PROPOSED ROOF PLANT LAYOUT
OPTION 3

Revisions

Reference	Date

This drawing is the property of Barnwood Shopfitting Limited. At all times it must not be copied or passed to a third party without written consent.

Figured dimensions to be read in preference to scaled.

Client

Nationwide B.S.

Contract

225-226 Tottenham Court Road
London. W1T 7PZ

Drawing Title
Mechanical Plant Details To Roof
Layout Options

Date 22.06.2015	Cad Ref.
Drawing No. 120211-02	Revision
Scale 1:50	Drawn By N. L.

Barnwood Shopfitting

203 Barnwood Rd
Barnwood Gloucester. GL4 3HS
Phone: (01452) 614124
Fax: (01452) 372933

Web: www.barnwoodshopfitting.com
Email: mail@barnwoodshopfitting.com