


TPS

Taylor Project Services LLP
BUILDING SERVICES CONSULTANTS

TPSLLP : 21 Bedford Square, London, WC1

M&E Drawings – Planning Issue – Rev A

GENERAL NOTES



RADIATOR

A	JUL.15	BACKGROUND UPDATED TO SUIT TFT LAYOUTS
0	APR.15	PLANNING ISSUE
Rev	Date	Description

No.1 Cornhill
London EC3V 3ND
Tel 020 7743 6602
www.taylorprojectservices.co.uk



Montague Street
London
WC1B 5BL
Tel: 0171 636 2885
Fax: 0171 255 1729

21 BEDFORD SQUARE
LONDON
WC1


BASEMENT LEVEL
EXISTING MECHANICAL SERVICES
LAYOUT

Drawing Status	PLANNING
----------------	----------

Drawing No. TPS/21BS/B/EX/M




BEDFORD SQUARE

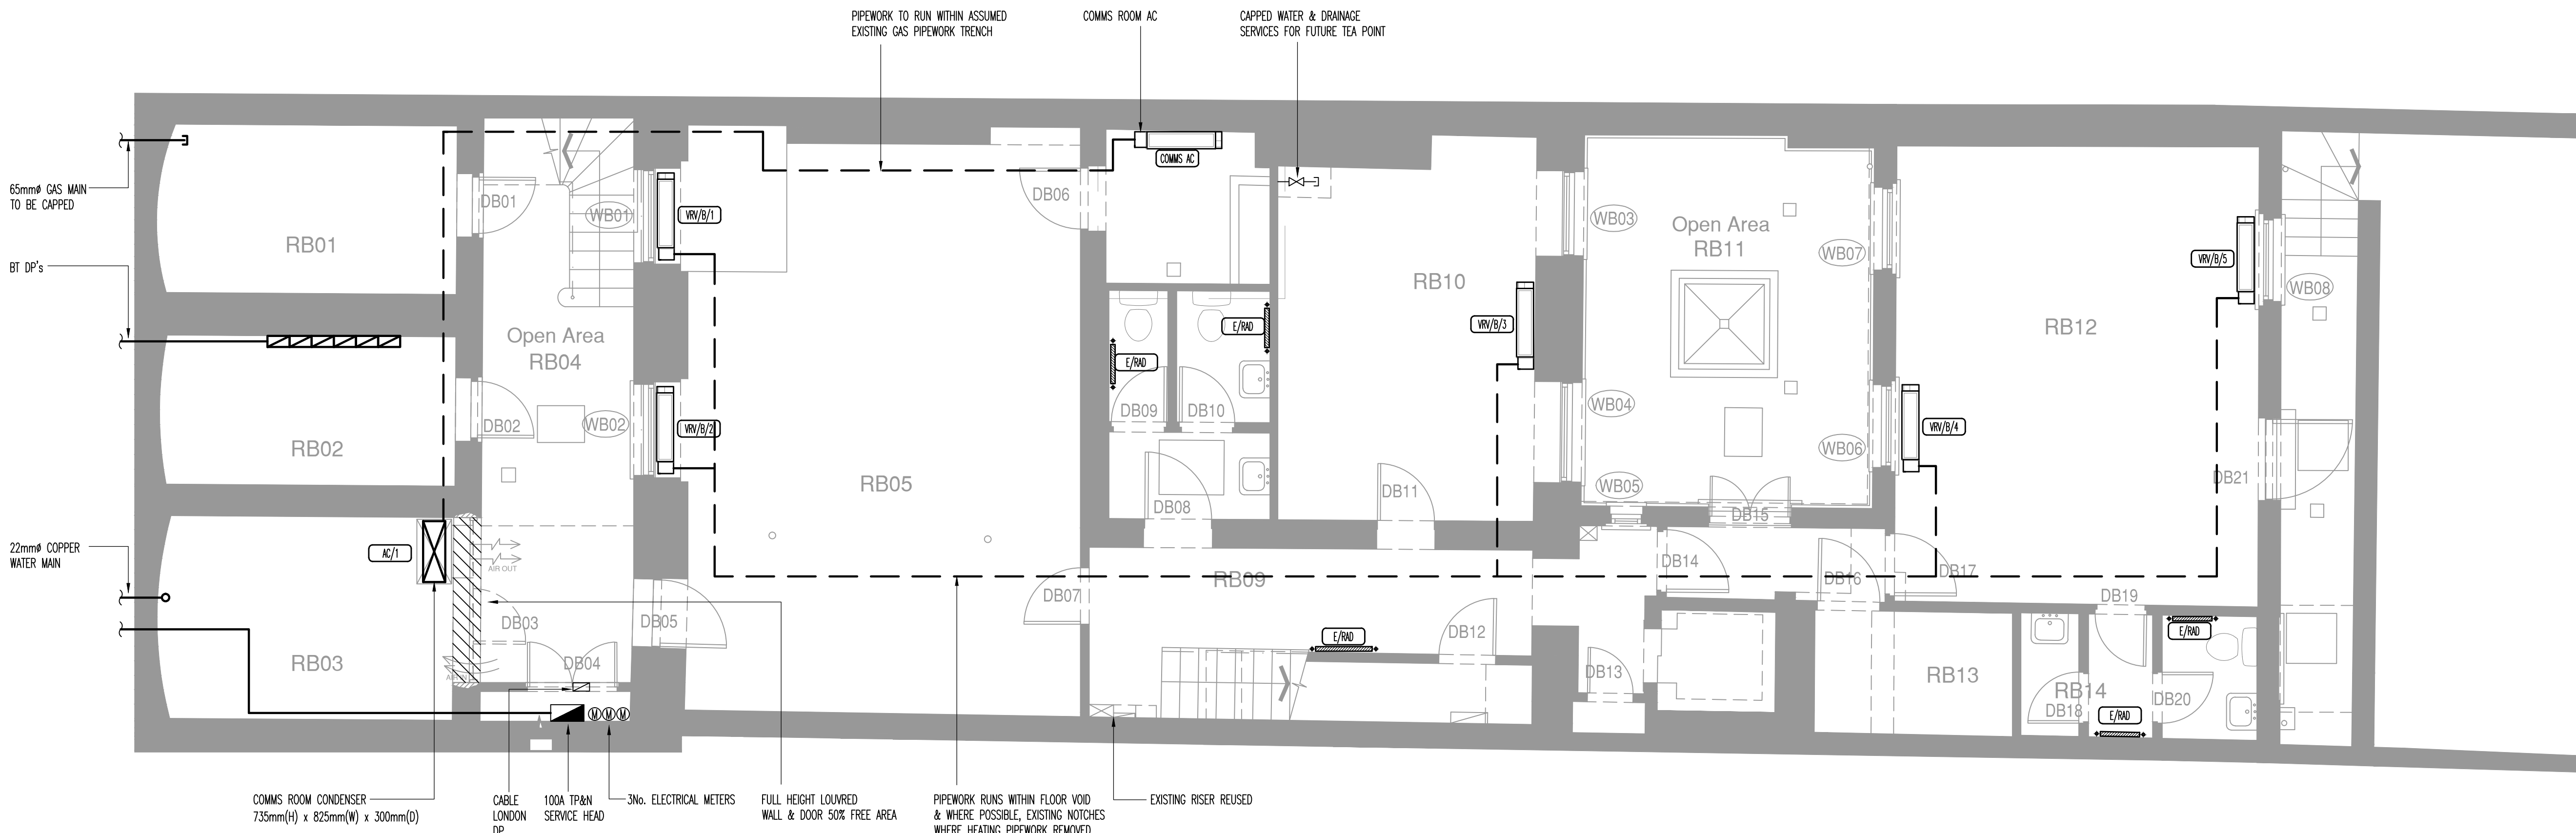


THIS DRAWING MUST NOT BE REPRODUCED WITHOUT PRIOR CONSENT.
DO NOT SCALE FROM THIS DRAWING.
THIS DRAWING IS COPYRIGHTED

 
GENERAL NOTES



ELECTRIC RADIATOR



VAV UNIT POSITION



REFRIGERANT PIPEWORK RUN


PLANNING		
B	JUL.15	AC UNIT, CONDENSER AND LOUVERED WALL/DOOR ADDED.
A	JUL.15	COMMS ROOM AC ADDED
0	APR.15	PLANNING ISSUE
Rev	Date	Description

TPS

Taylor Project Services LLP

No.1 Cornhill
London EC3V 3ND
Tel 020 7743 6602
www.taylorprojectservices.com

Client



THE BEDFORD ESTATES

29a Montague Street
London WC1B 5BL
Tel 0171 636 2885
Fax 0171 255 1729


Project

21 BEDFORD SQUARE
LONDON
WC1

Drawing Title


BASEMENT LEVEL
PROPOSED MECHANICAL
SERVICES LAYOUT


Scale	1:50 @ A1	Date	10.04.15
Drawn	R.J.L.	Checked	G.N.T.
Drawing Status			
PLANNING			
Revision	0	A	B
Drawing No.			
TPS/21BS/B/M			

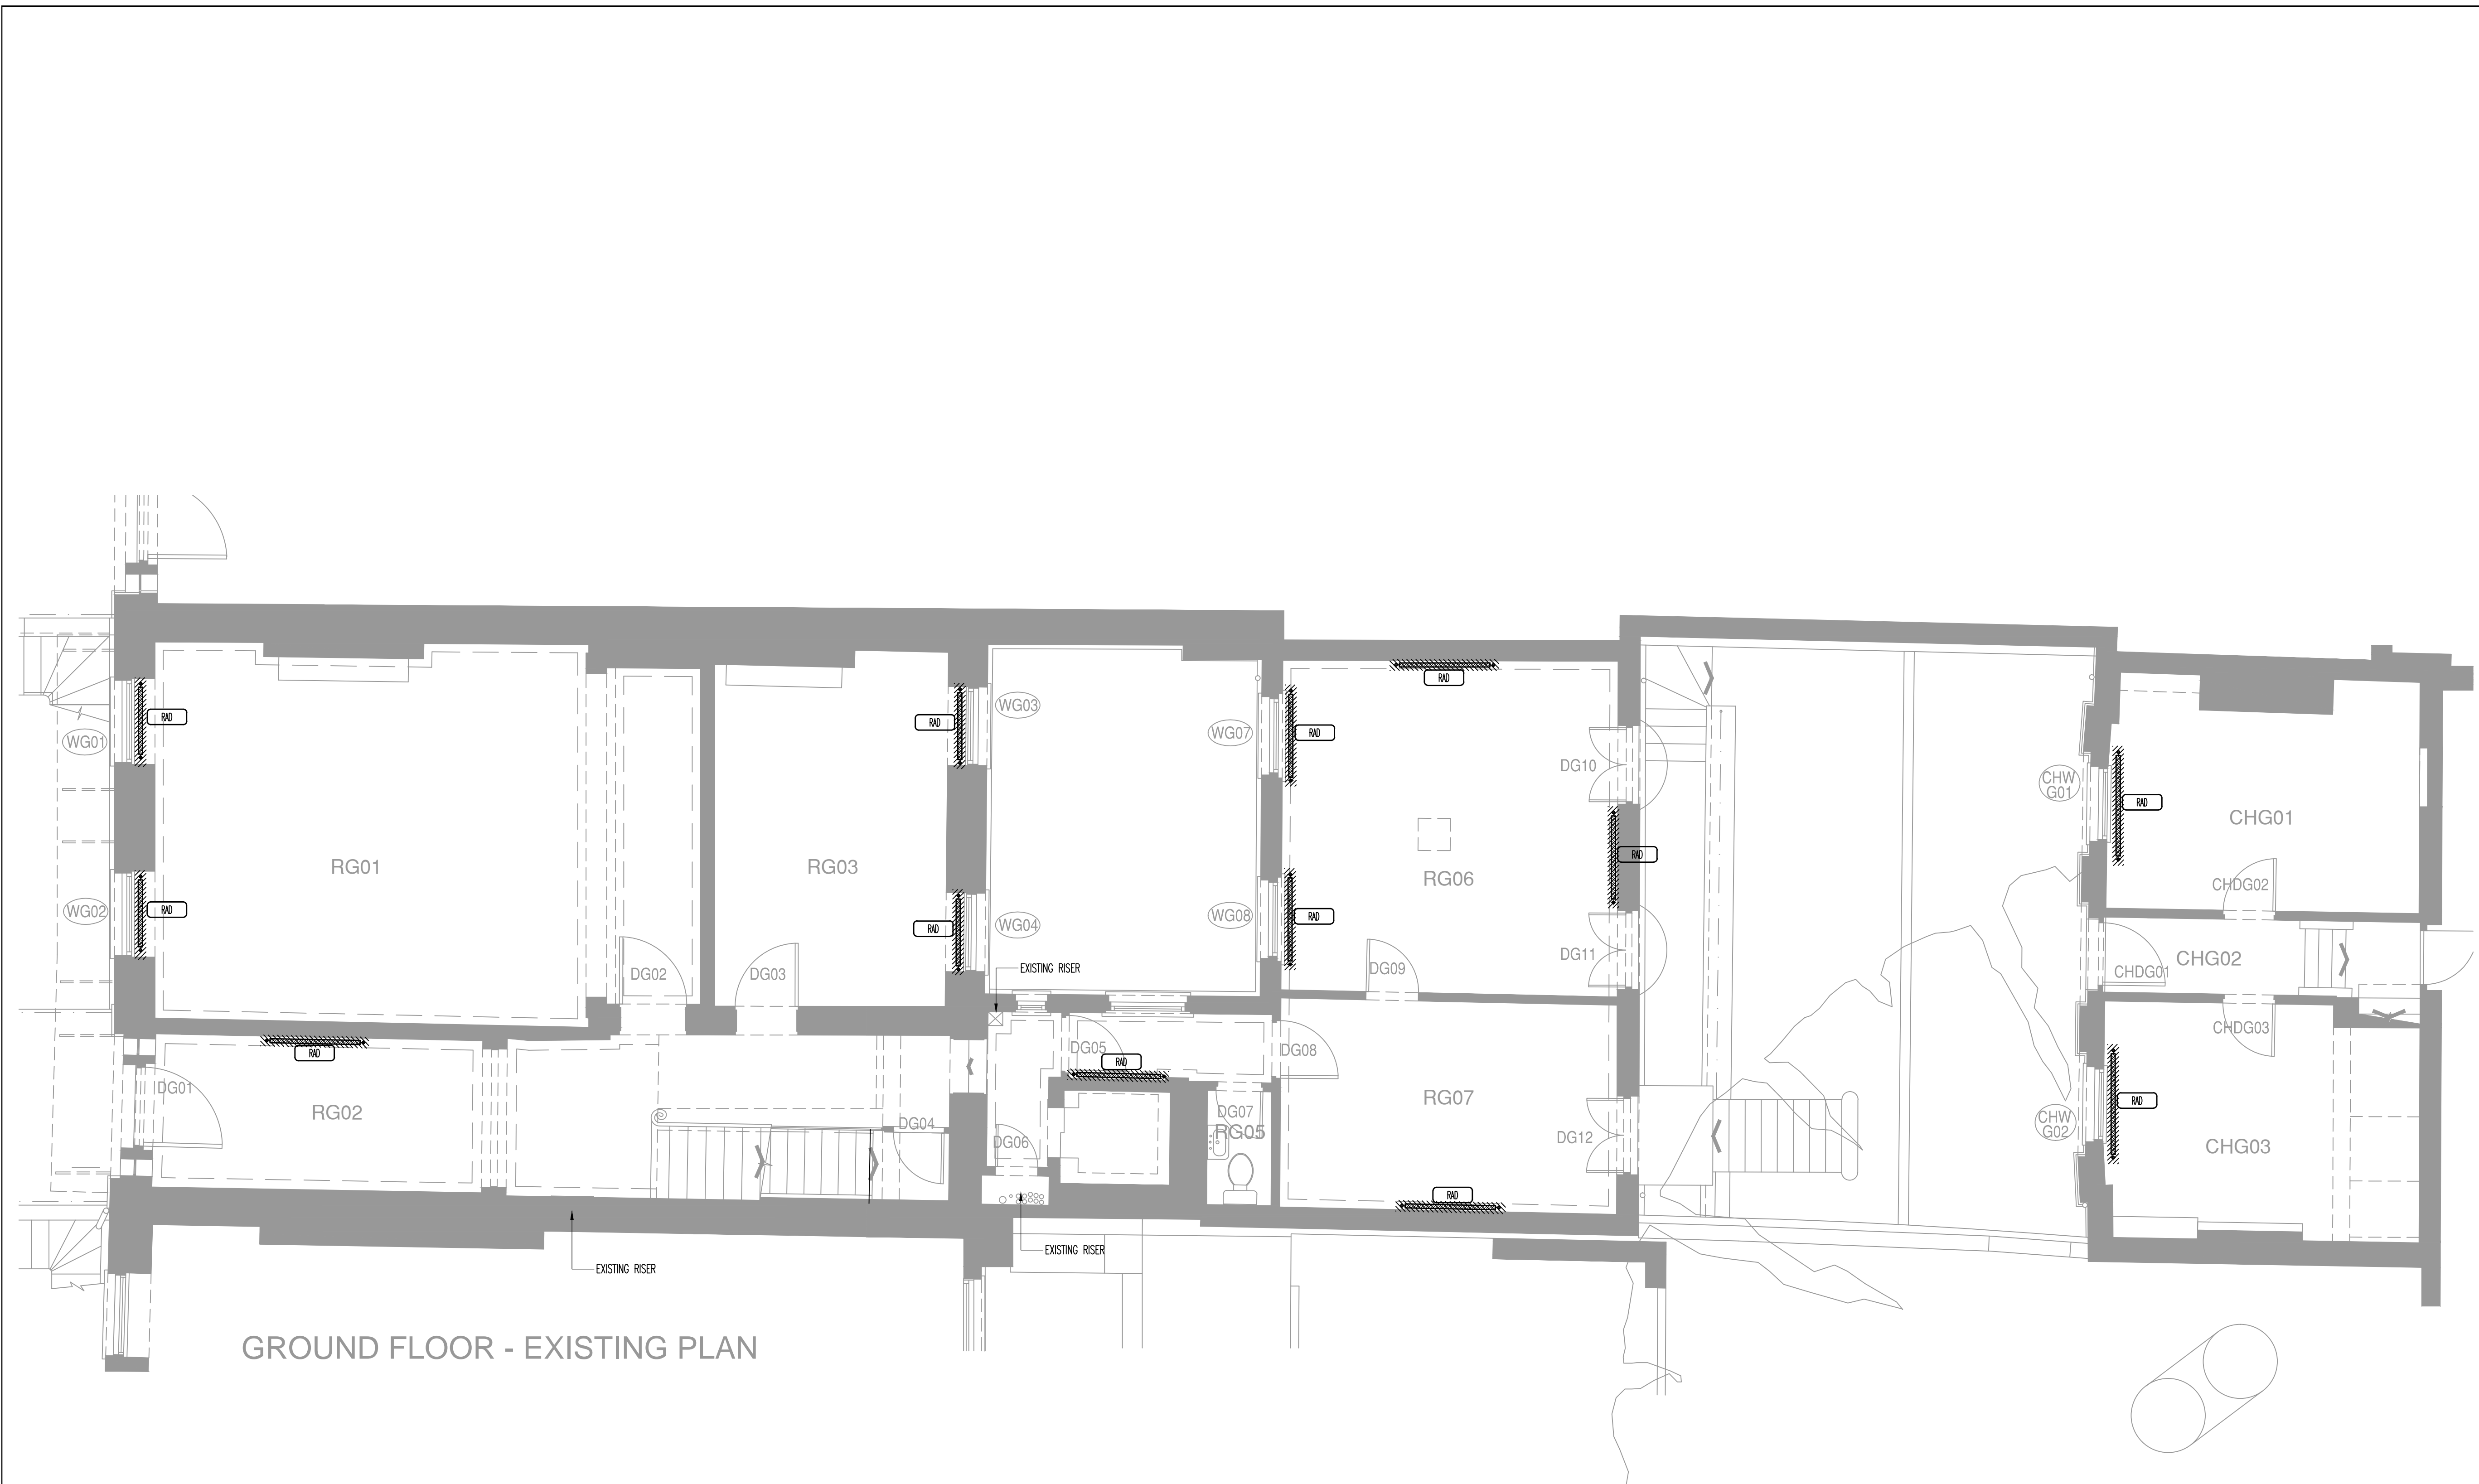

THIS DRAWING MUST NOT BE REPRODUCED WITHOUT PRIOR CONSENT.
DO NOT SCALE FROM THIS DRAWING.
THIS DRAWING IS COPYRIGHTED

GENERAL NOTES

  TO BE STRIPPED OUT

 RADIATOR


PLANNING		
Rev	Date	Description
A	JUL.15	BACKGROUND UPDATED TO SUIT TFT LAYOUTS
0	APR.15	PLANNING ISSUE

TPS

Taylor Project Services LLP

No.1 Cornhill
London EC3V 3ND
Tel 020 7743 6602
www.taylorprojectservices.com

Client

 **THE BEDFORD ESTATES**
29a Montague Street
London WC1B 5BL
Tel 0171 636 2885
Fax 0171 255 1729

Project

21 BEDFORD SQUARE
LONDON
WC1

Drawing Title

GROUND FLOOR
EXISTING MECHANICAL SERVICES
LAYOUT

Scale	1:50 @ A1	Date	10.04.15
Drawn	R.J.L.	Checked	G.N.T.


Drawing Status

PLANNING

Revision	0	A																	
----------	---	---	--	--	--	--	--	--	--	--	--	--	--	--	--	--	--	--	--


Drawing No.

TPS/21BS/G/EX/M

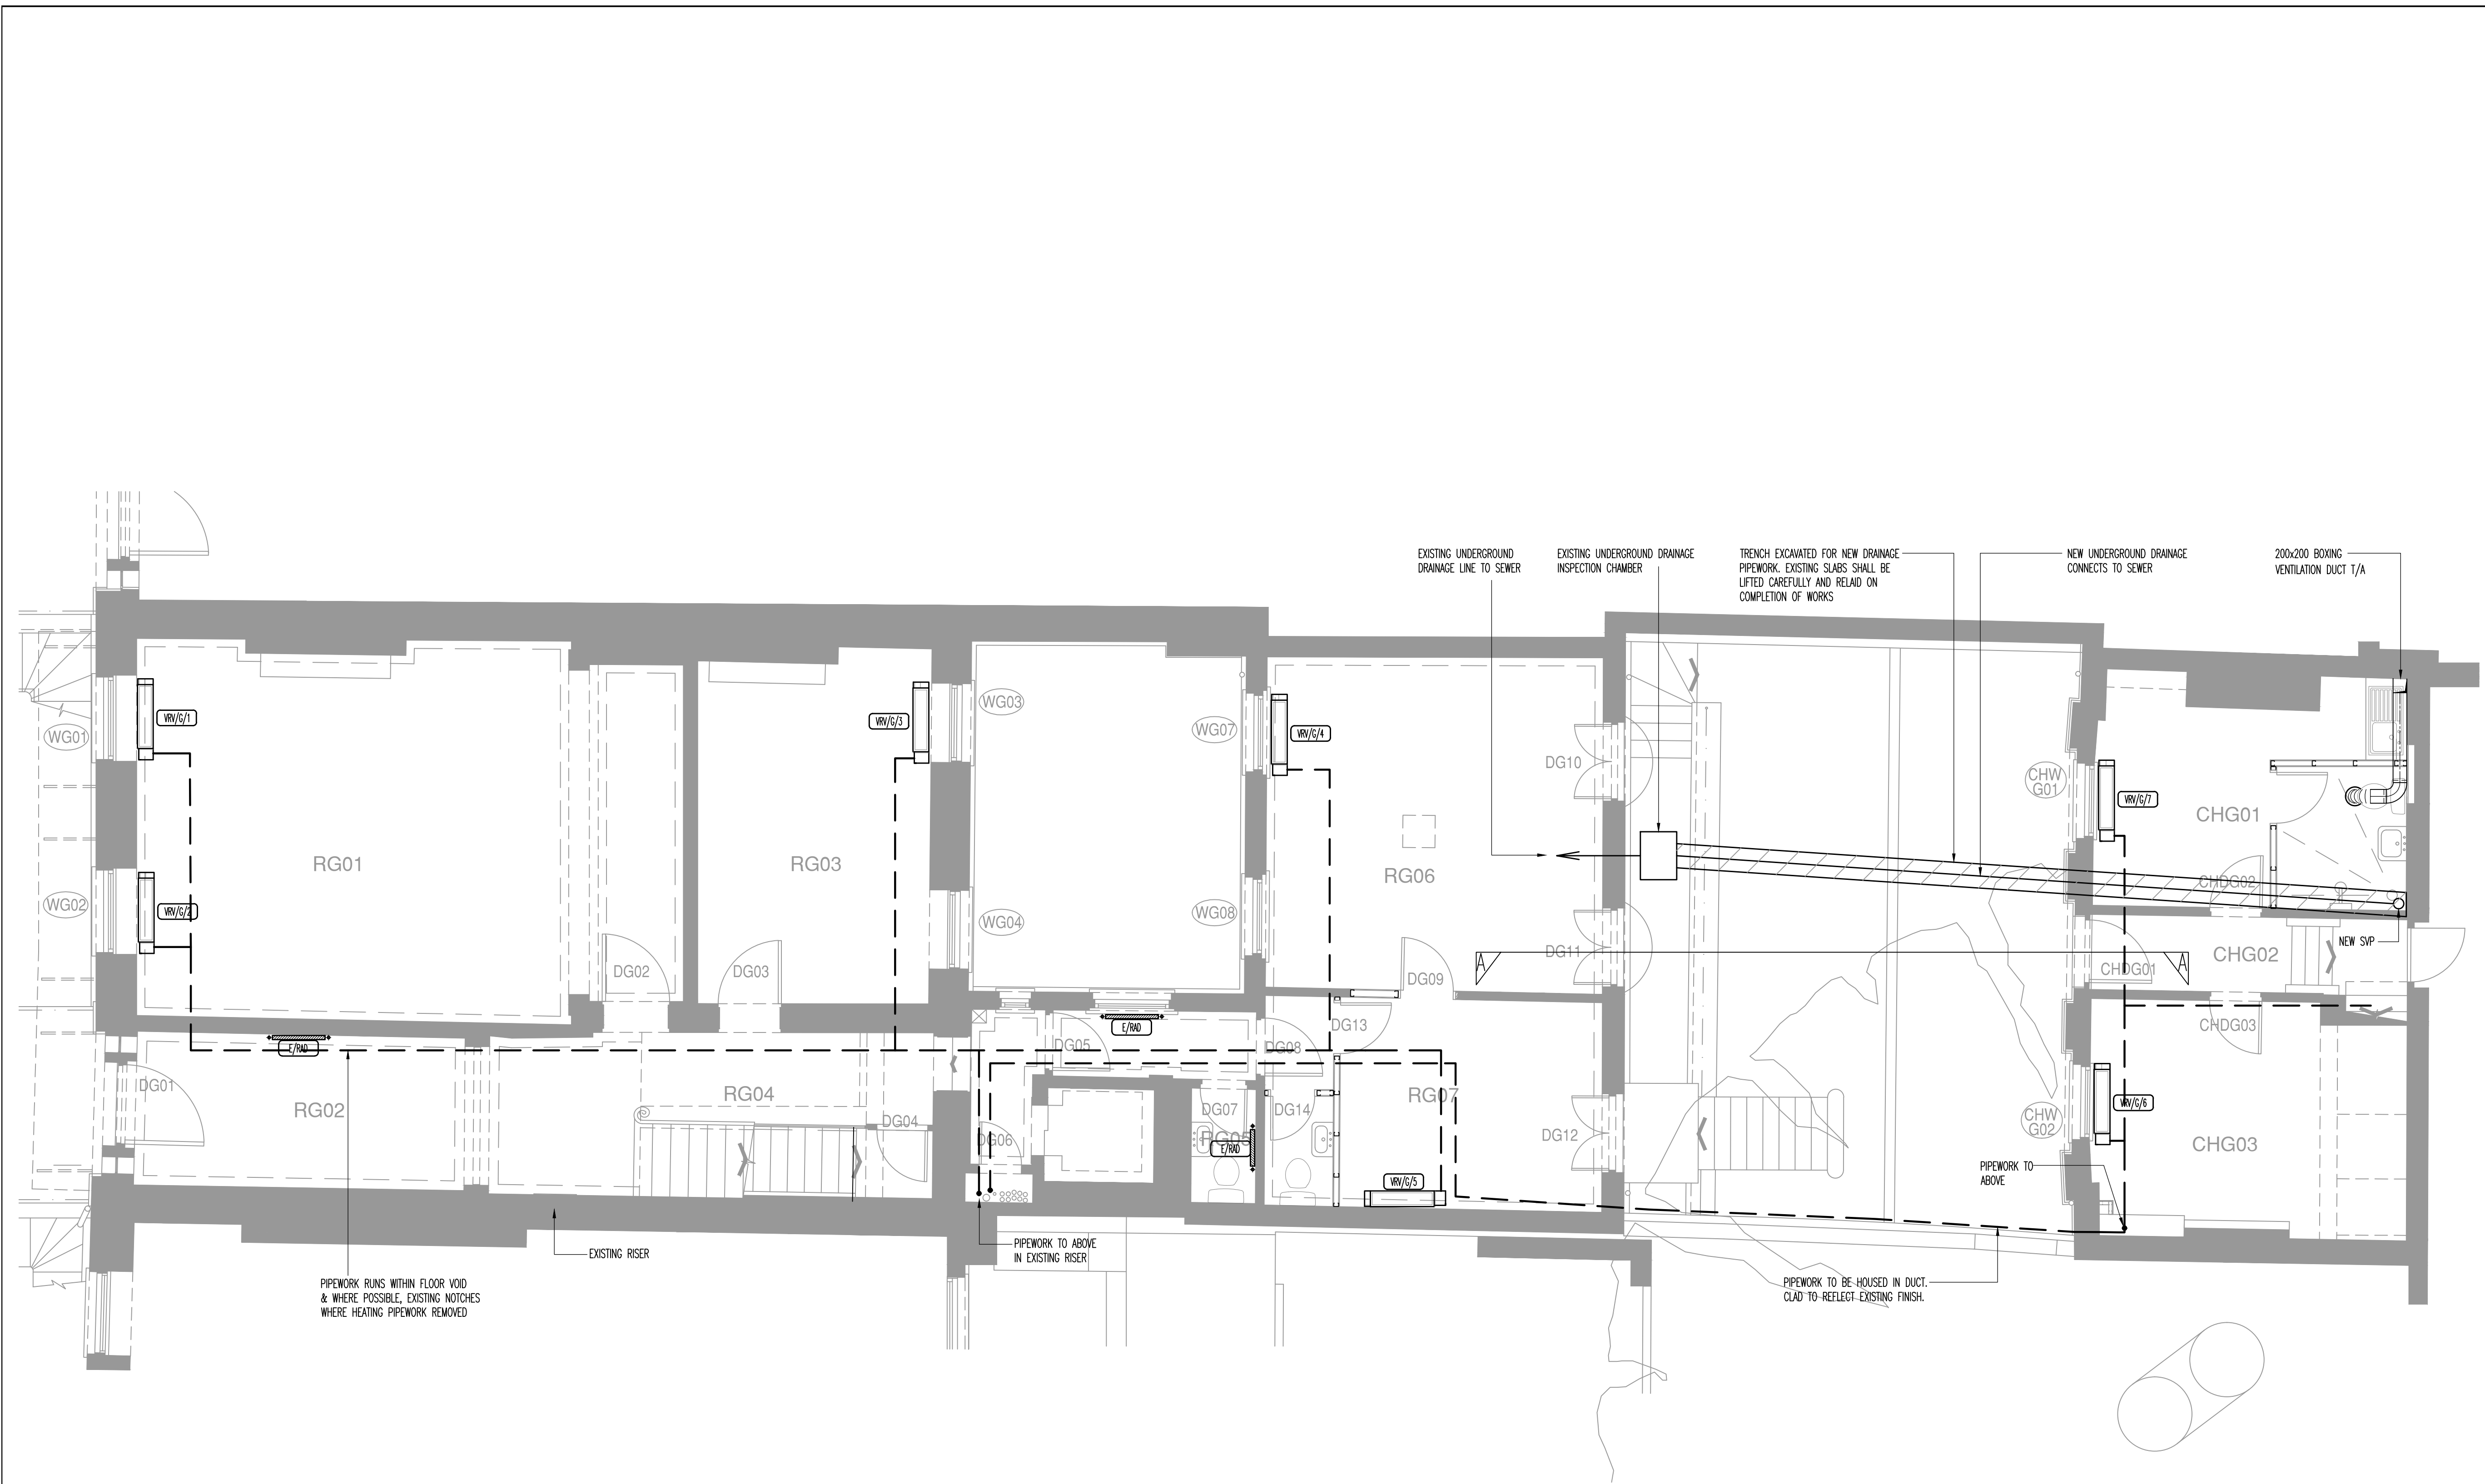


THIS DRAWING MUST NOT BE REPRODUCED WITHOUT PRIOR CONSENT.
DO NOT SCALE FROM THIS DRAWING.
THIS DRAWING IS COPYRIGHTED

 
GENERAL NOTES



ELECTRIC RADIATOR

 

VRV UNIT POSITION

 

REFRIGERANT PIPEWORK RUN

PLANNING		
B	JUL.15	NEW PIPEWORK, DUCTING AND DRAINAGE ADDED. AC UNIT REMOVED
A	JUL.15	COMMS ROOM AC ADDED
0	APR.15	PLANNING ISSUE
Rev	Date	Description

TPS

Taylor Project Services LLP

No.1 Cornhill
London EC3N 3ND
Tel 020 7743 6602
www.taylorprojectservices.com

Client



THE BEDFORD ESTATES

29a Montague Street
London WC1B 5BL
Tel 0171 636 2885
Fax 0171 255 1779


Project

21 BEDFORD SQUARE
LONDON
WC1

Drawing Title

GROUND FLOOR
PROPOSED MECHANICAL
SERVICES LAYOUT


Scale	1:50 @ A1	Date	10.04.15
Drawn	R.J.L.	Checked	G.N.T.
Drawing Status			
PLANNING			
Revision			
0	A	B	
Drawing No.			
TPS/21BS/G/M			

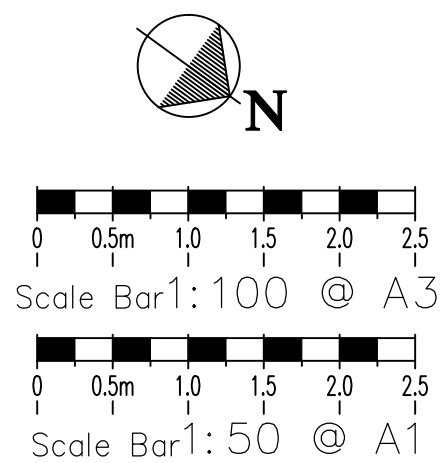

RADIATOR

TPS/21BS/1/EX/M

Drawing No. TPS/21BS/1/EX/M

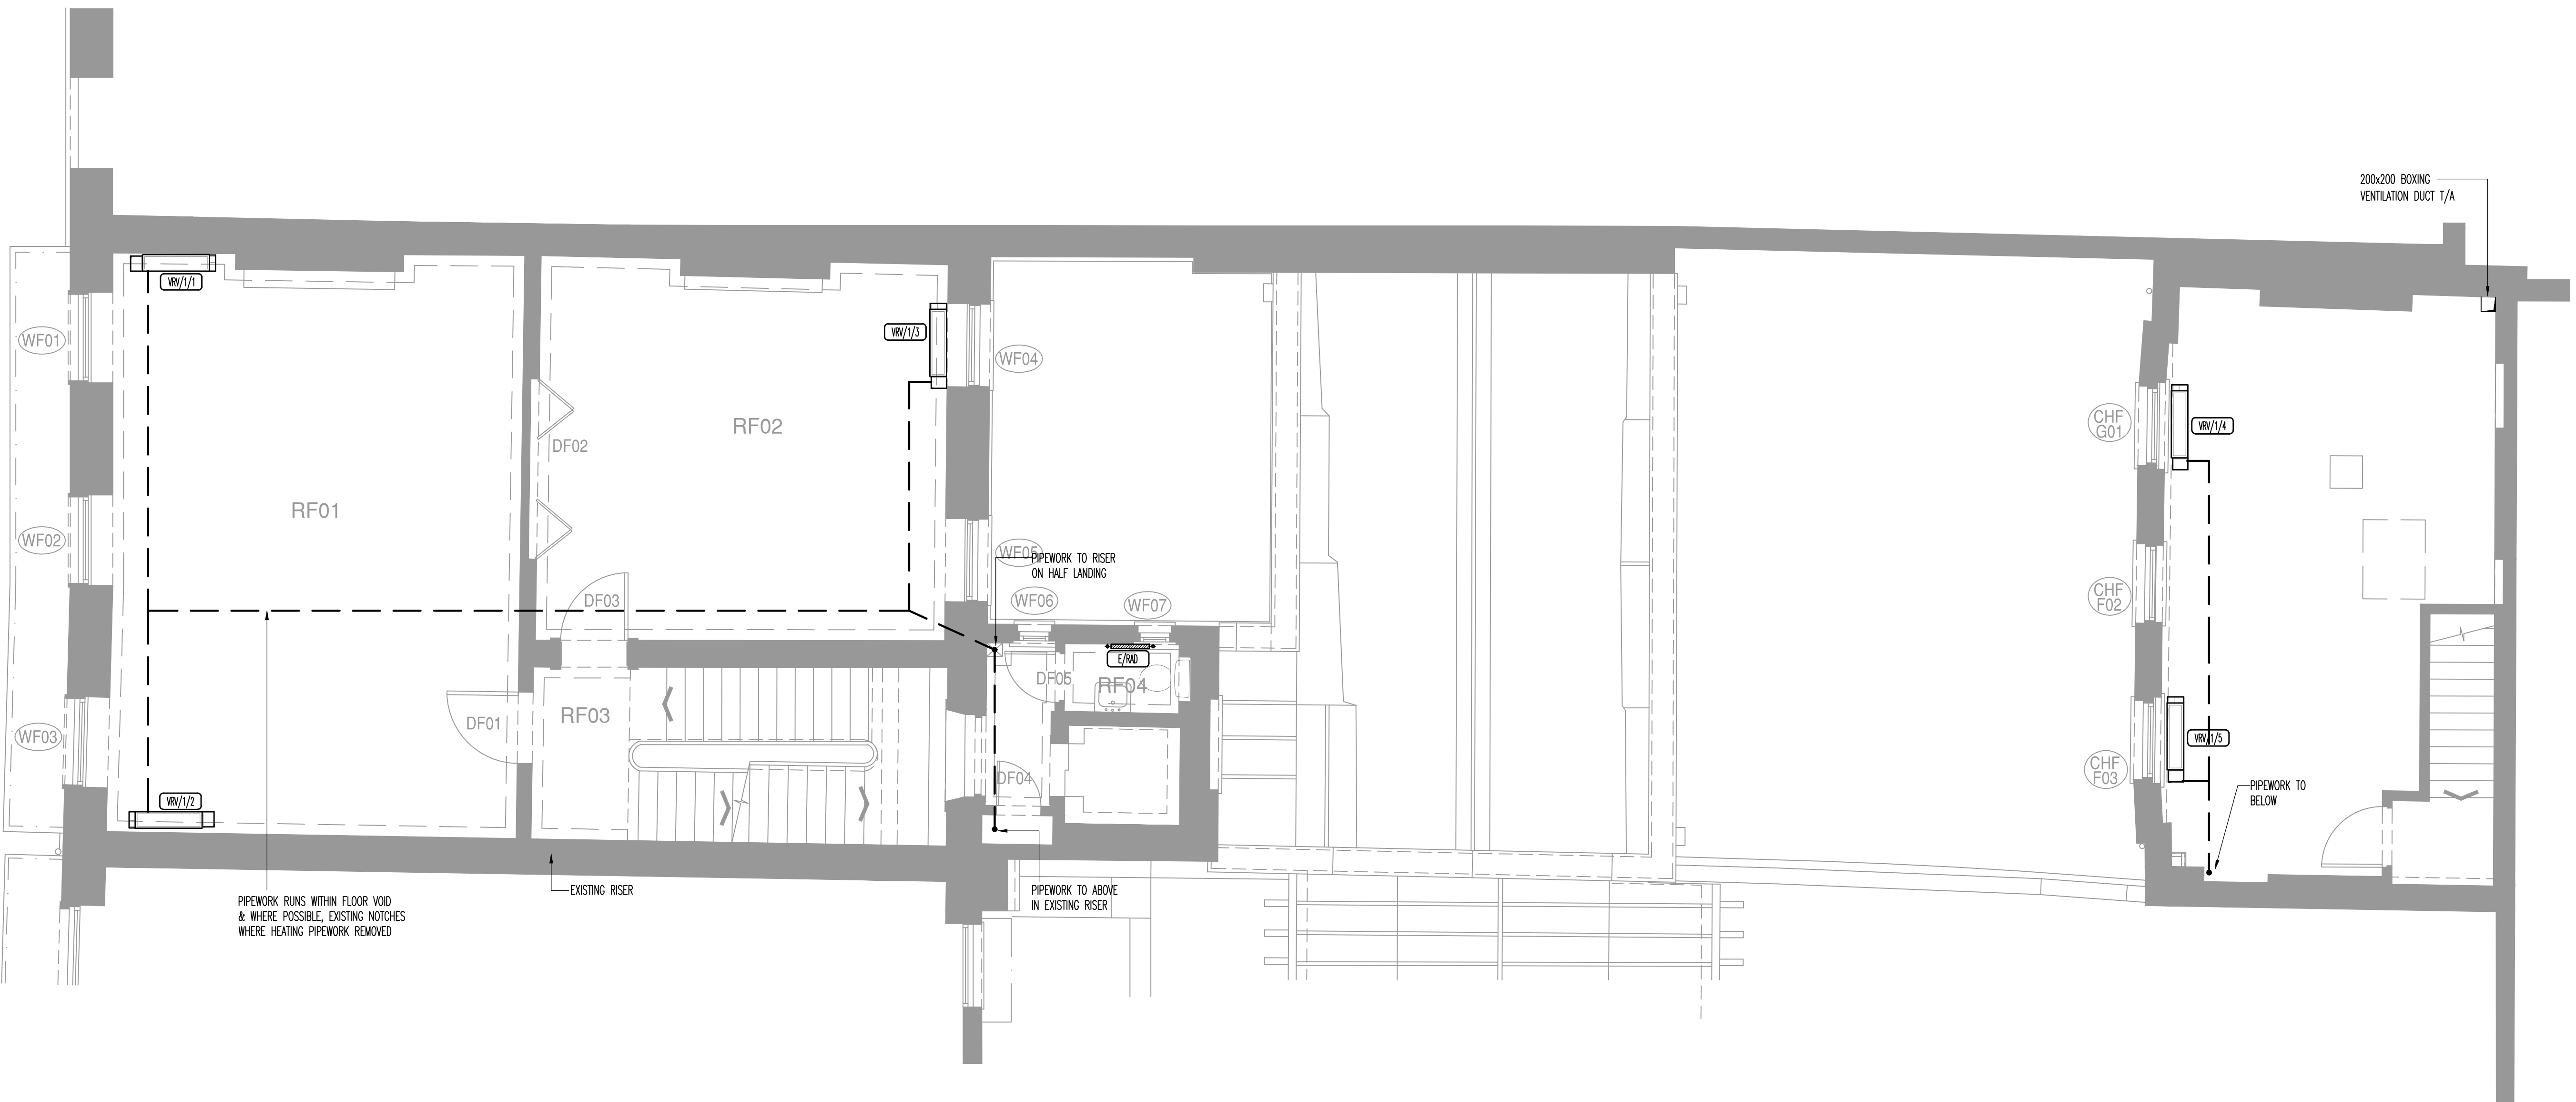

THIS DRAWING MUST NOT BE REPRODUCED WITHOUT PRIOR CONSENT.
DO NOT SCALE FROM THIS DRAWING.
THIS DRAWING IS COPYRIGHTED

GENERAL NOTES

ELECTRIC RADIATOR

VRV UNIT POSITION

REFRIGERANT PIPEWORK RUN

PLANNING

A	JUL.15	NEW VENTILATION DUCT SHOWN
0	APR.15	PLANNING ISSUE
Rev	Date	Description


TPS
Taylor Project Services LLP
No.1 Cornhill
London EC3V 3ND
Tel 020 7743 6602
www.taylorprojectservices.com

Client
THE BEDFORD ESTATES
29a Montague Street
London WC1B 5BL
Tel 0171 636 2885
Fax 0171 255 1729

Project
21 BEDFORD SQUARE
LONDON
WC1


Drawing Title
FIRST FLOOR
PROPOSED MECHANICAL
SERVICES LAYOUT

Scale	1:50 @ A1	Date	10.04.15
Drawn	R.J.L.	Checked	G.N.T.
Drawing Status PLANNING			
Revision	0	A	
Drawing No. TPS/21BS/1/M			

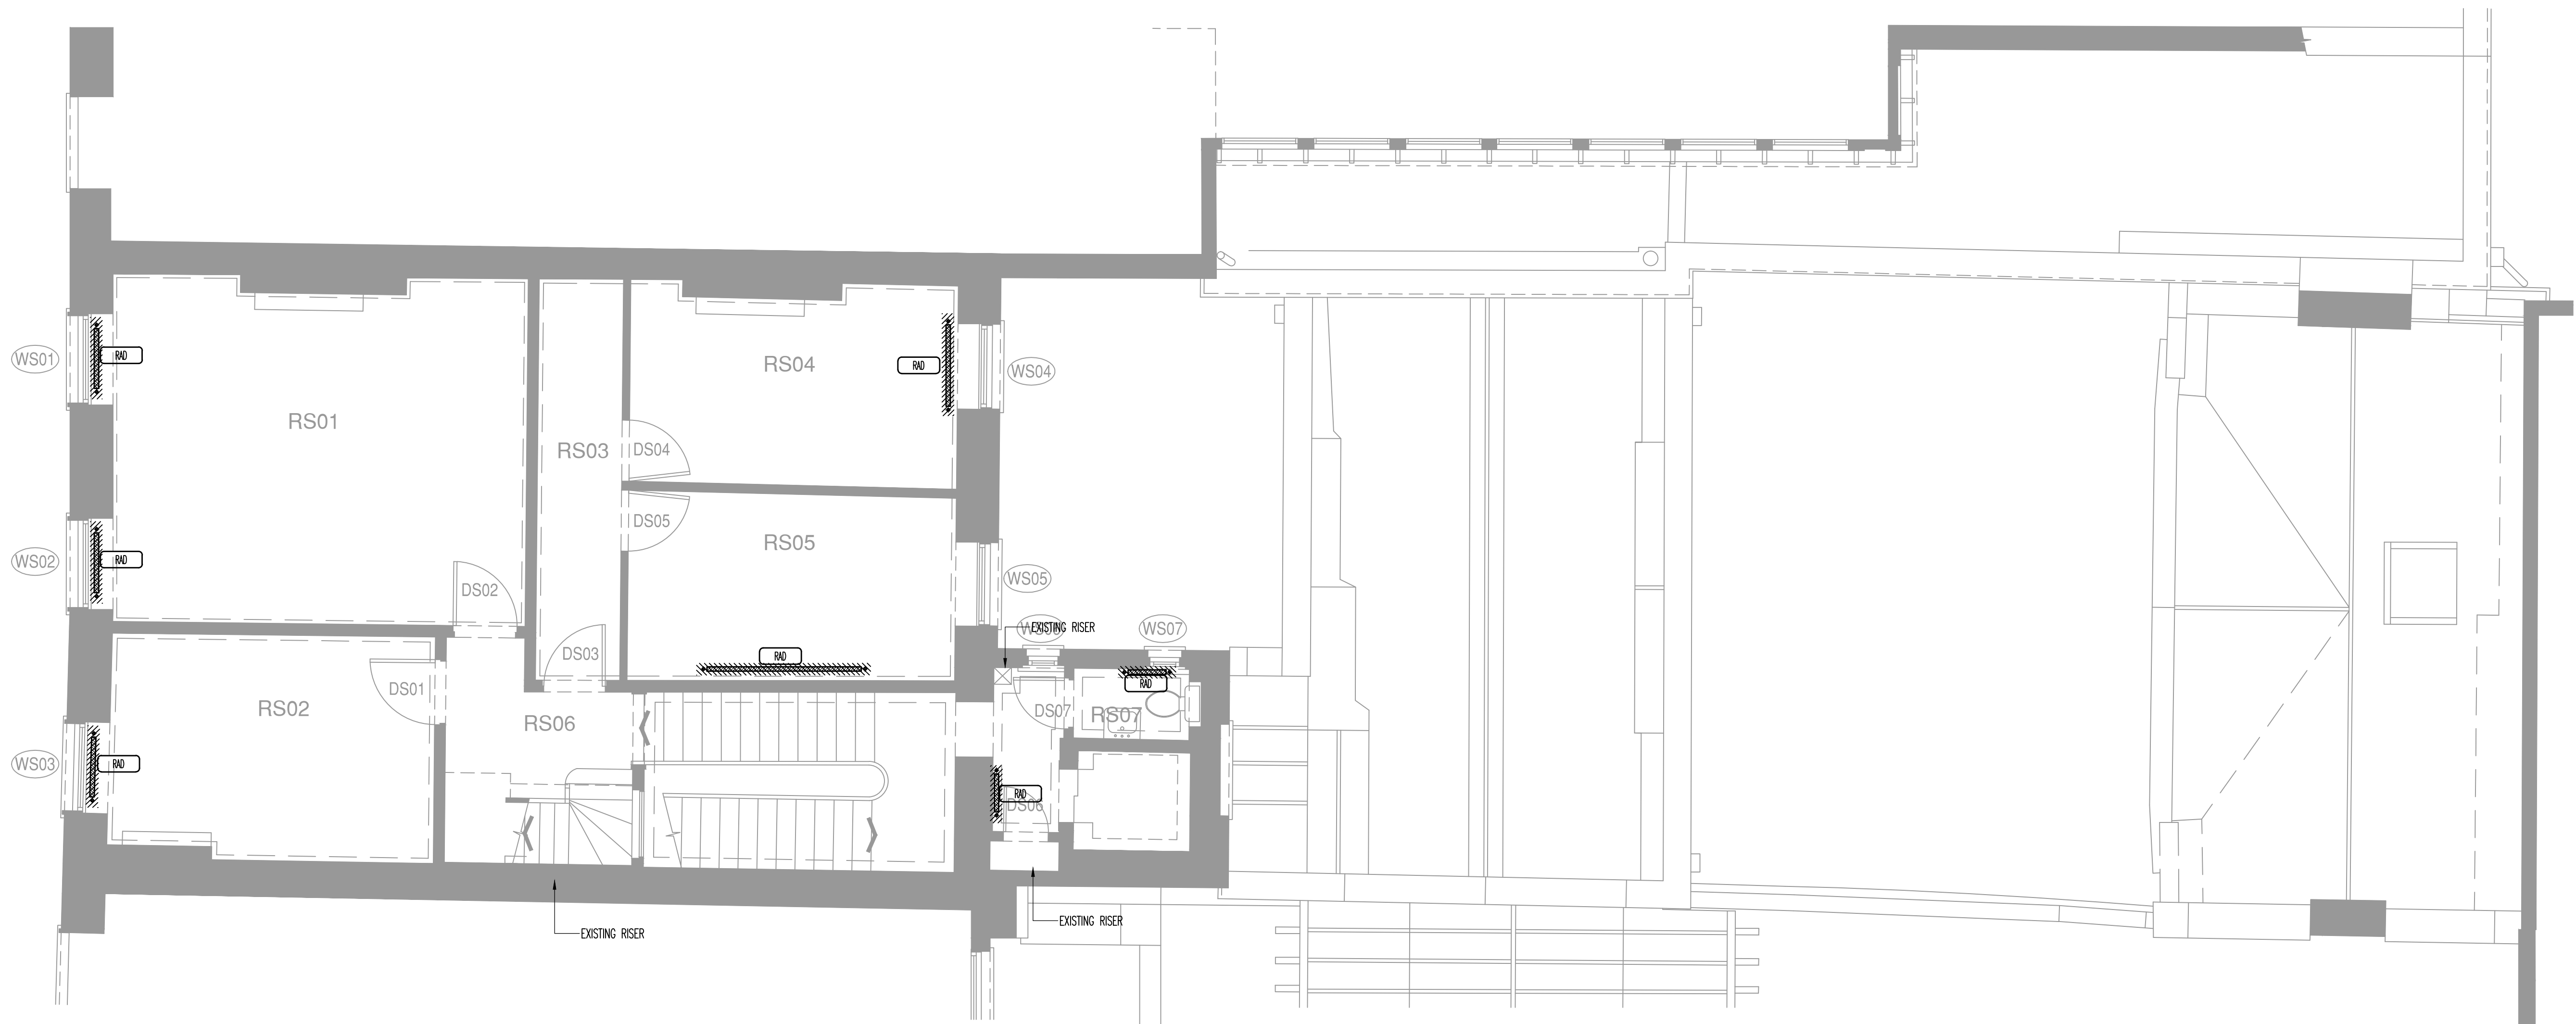

THIS DRAWING MUST NOT BE REPRODUCED WITHOUT PRIOR CONSENT.
DO NOT SCALE FROM THIS DRAWING.
THIS DRAWING IS COPYRIGHTED

GENERAL NOTES

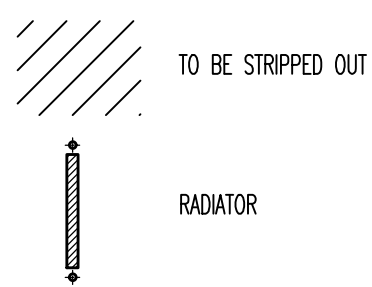

PLANNING

A	JUL.15	BACKGROUND UPDATED TO SUIT TFT LAYOUTS
0	APR.15	PLANNING ISSUE
Rev	Date	Description

TPS

Taylor Project Services LLP

No.1 Cornhill
London EC3V 3ND
Tel 020 7743 6602
www.taylorprojectservices.com

Client



**THE
BEDFORD
ESTATES**

29a Montague Street
London
WC1B 5BL
Tel 0171 636 2885
Fax 0171 255 1729

Project

21 BEDFORD SQUARE
LONDON
WC1

Drawing Title

SECOND FLOOR
EXISTING MECHANICAL SERVICES
LAYOUT

Scale	1:50 @ A1	Date	10.04.15
Drawn	R.J.L.	Checked	G.N.T.


Drawing Status

PLANNING

Revision	0	A																	
----------	---	---	--	--	--	--	--	--	--	--	--	--	--	--	--	--	--	--	--

Drawing No.

TPS/21BS/2/EX/M

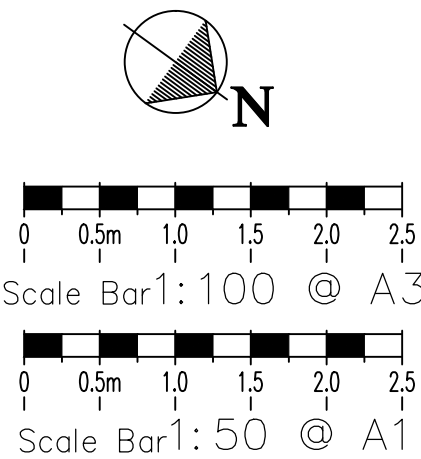

GENERAL NOTES

◆ ◆ ◆

[illegible]

Taylor Project Services LLP

Client	
--------	--



Drawing Title

SECOND FLOOR
PROPOSED MECHANICAL
SERVICES LAYOUT

Drawn R.J.L.	Checked G.N.T.
--------------	----------------

[illegible]


Drawing No. TDS /21BS /2 /M



Scale Bar 1:100 @ A3




Scale Bar 1: 50 @ A1

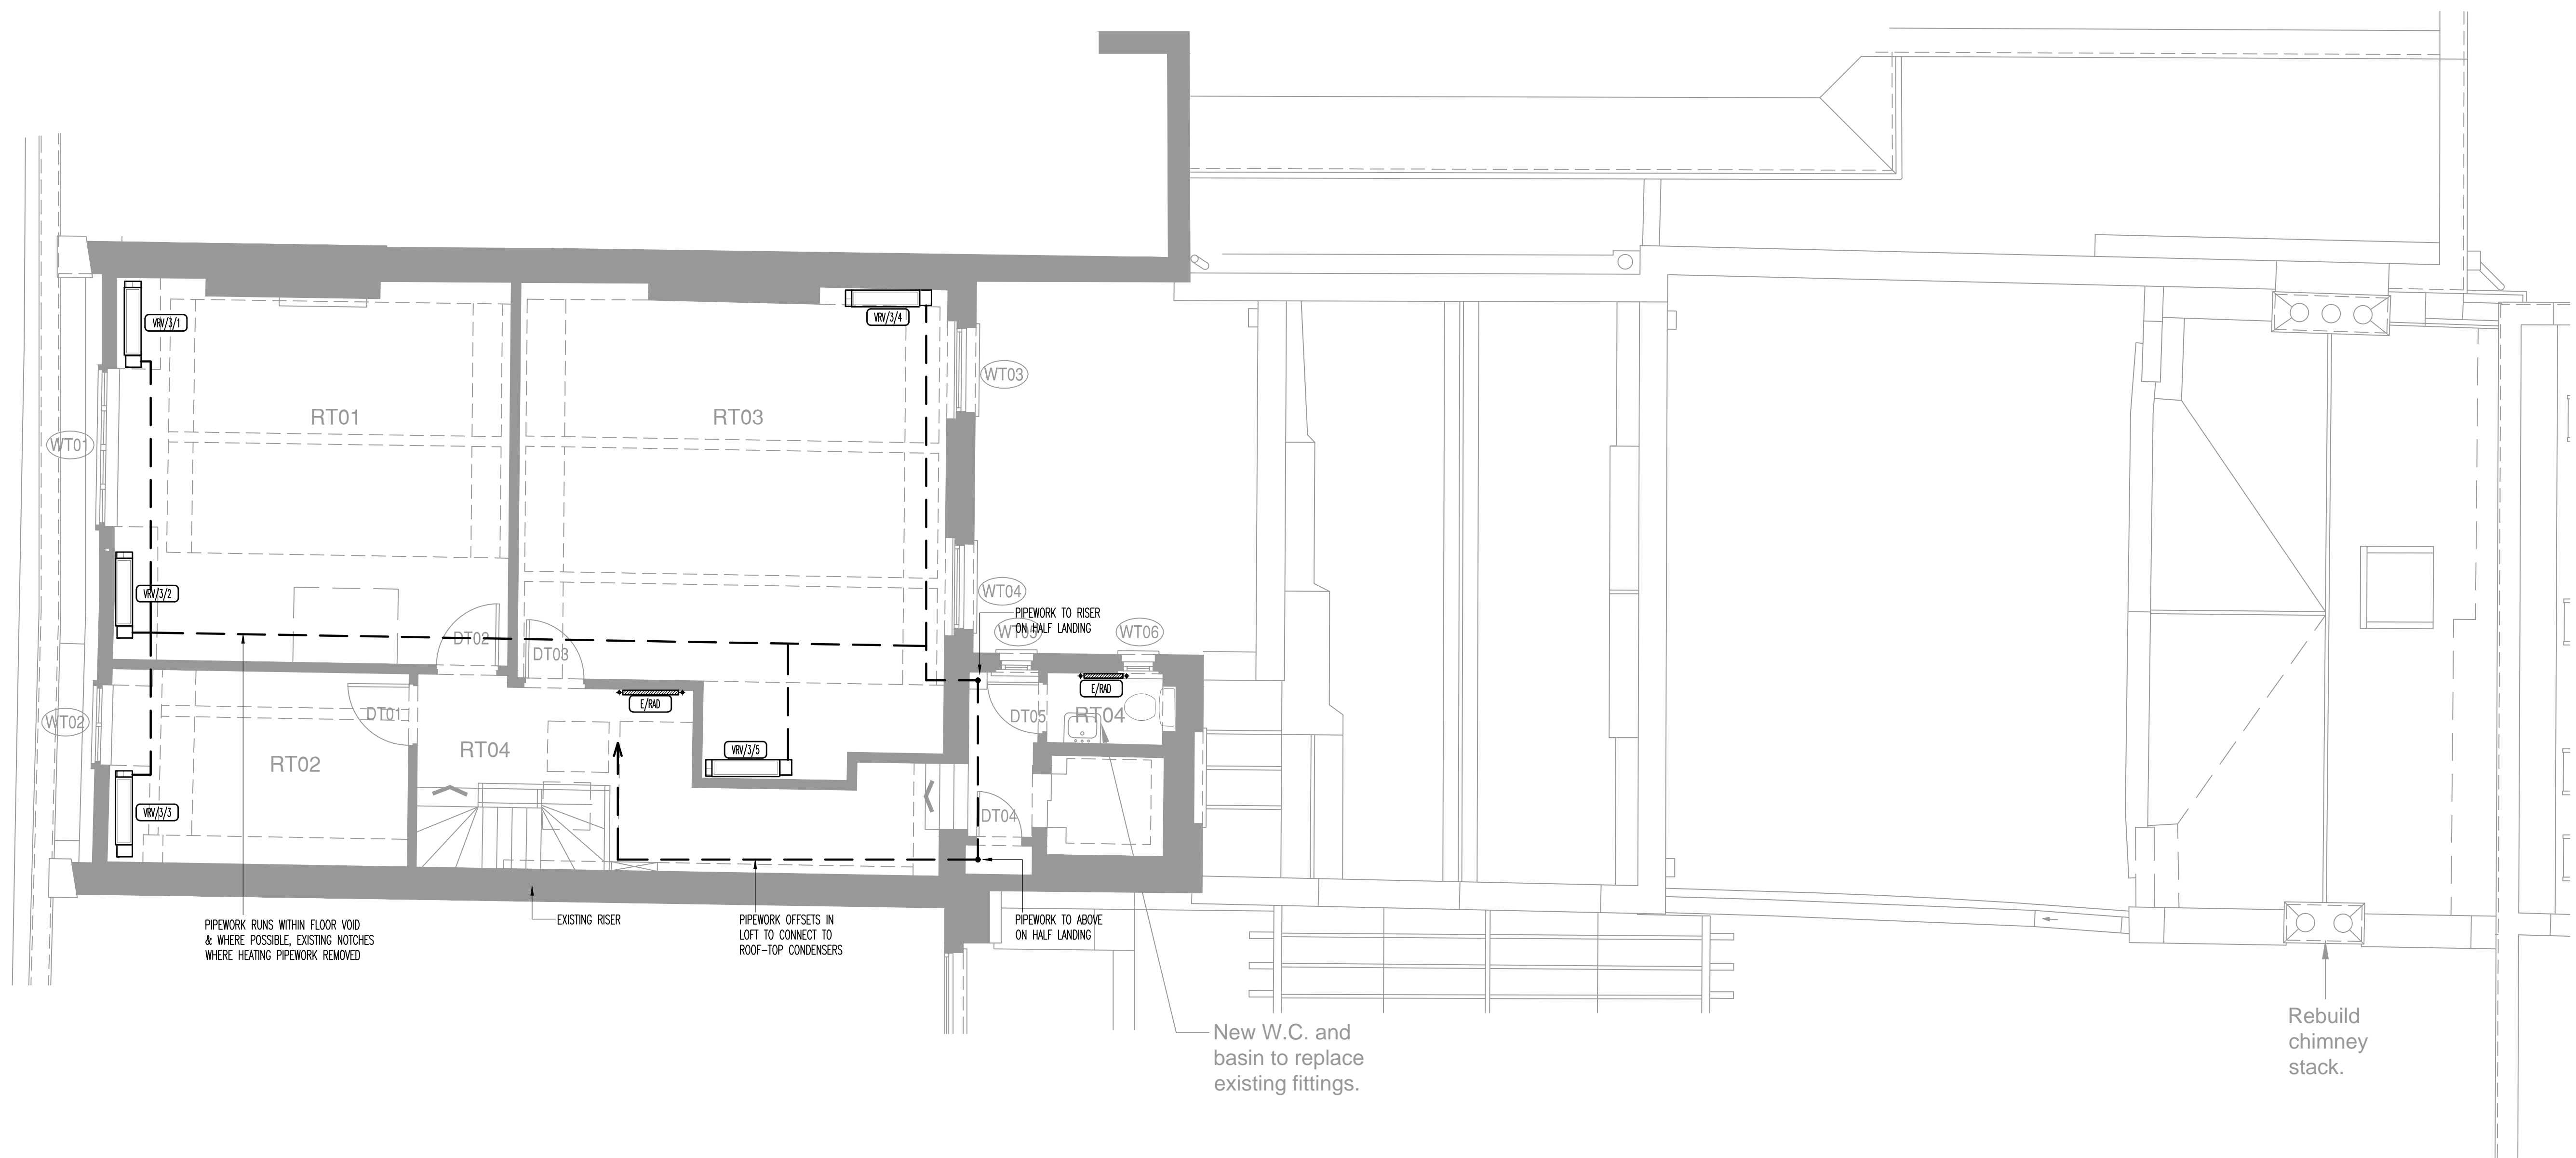


THIS DRAWING MUST NOT BE REPRODUCED WITHOUT PRIOR CONSENT.
DO NOT SCALE FROM THIS DRAWING.
THIS DRAWING IS COPYRIGHTED

 
GENERAL NOTES



ELECTRIC RADIATOR

 

VRV UNIT POSITION

 

REFRIGERANT PIPEWORK RUN

PLANNING		
Rev	Date	Description
A	JUL.15	BACKGROUND UPDATED TO SUIT TIT LAYOUTS
0	APR.15	PLANNING ISSUE

TPS

Taylor Project Services LLP

No.1 Cornhill
London EC3V 3ND
Tel 020 7743 6602
www.taylorprojectservices.com

Client



THE BEDFORD ESTATES

29a Montague Street
London
WC1B 5BL
Tel 0171 636 2885
Fax 0171 255 1729

Project

21 BEDFORD SQUARE
LONDON
WC1

Drawing Title

THIRD FLOOR
PROPOSED MECHANICAL
SERVICES LAYOUT

Scale 1:50 @ A1	Date 10.04.15
Drawn R.J.L.	Checked G.N.T.


Drawing Status



PLANNING

Revision	0	A																	
----------	---	---	--	--	--	--	--	--	--	--	--	--	--	--	--	--	--	--	--

Drawing No.

TPS/21BS/3/M

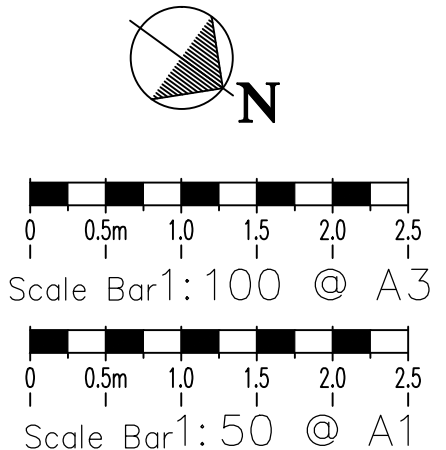

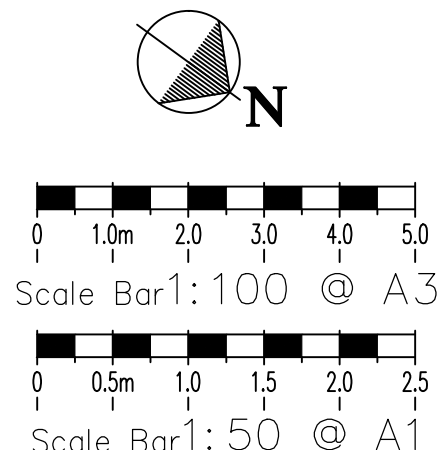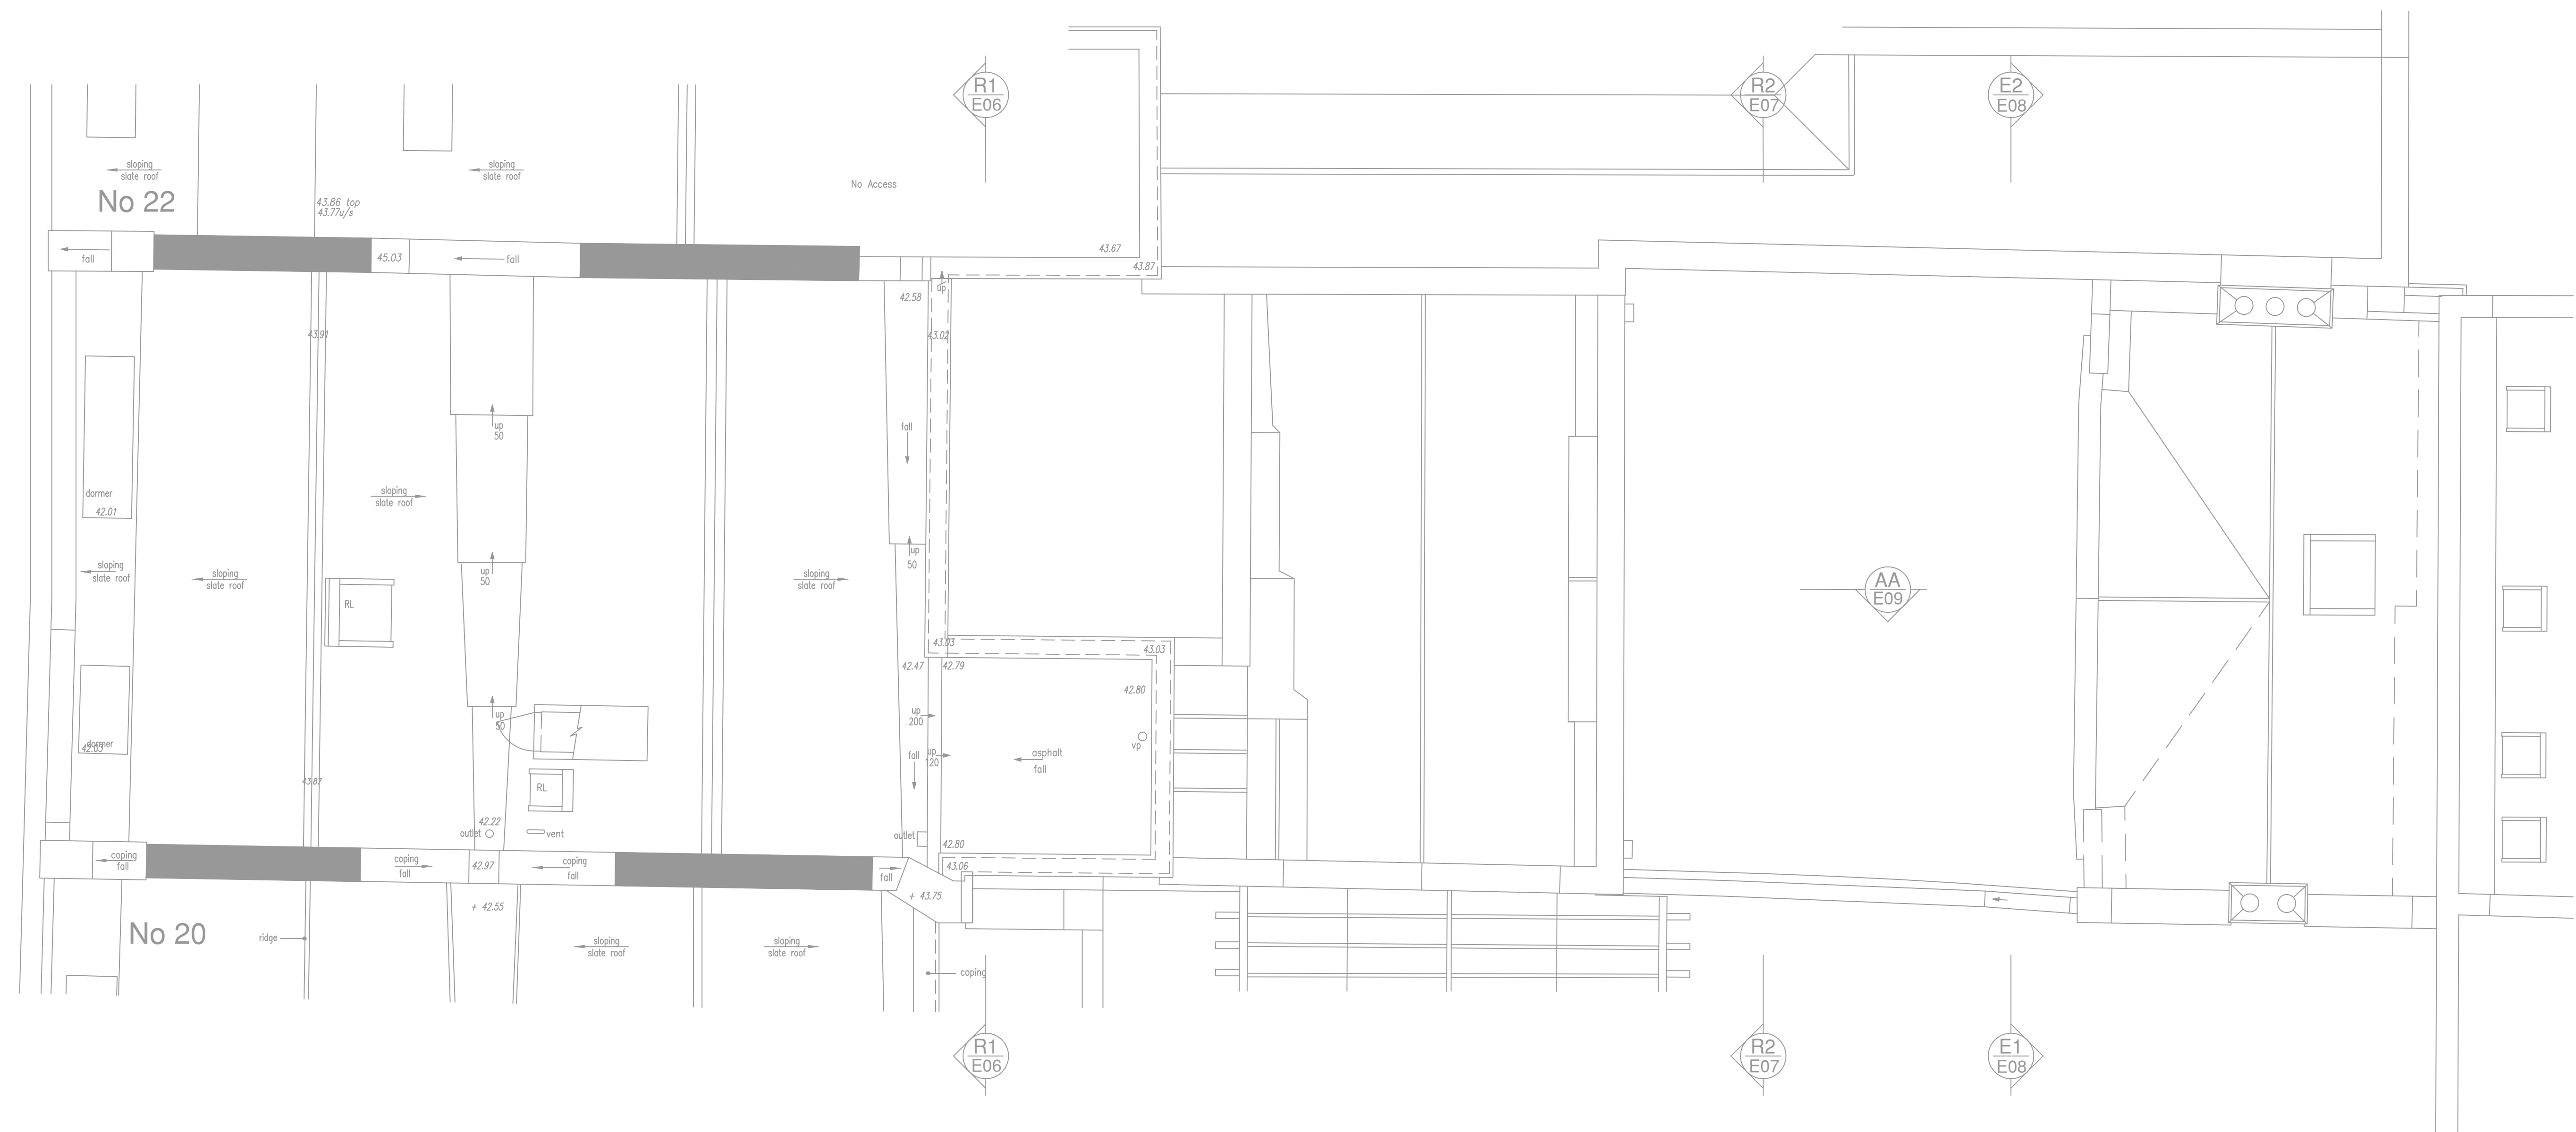

PLANNING		
A	JUL.15	BACKGROUND UPDATED TO SUIT TIT LAYOUTS
0	APR.15	PLANNING ISSUE
Rev	Date	Description

TPS
Taylor Project Services LLP
No.1 Cornhill
London EC3V 3ND
Tel 020 7743 6602
www.taylorprojectservices.com

Client

 **THE BEDFORD ESTATES**
29a Montague Street
London WC1B 5BT
Tel 0171 636 2888
Fax 0171 255 1729

Project

21 BEDFORD SQUARE
LONDON
WC1

Drawing Title

ROOF LEVEL
EXISTING MECHANICAL SERVICES
LAYOUT

Scale	1:50 @ A1	Date	10.04.15
Drawn	R.J.L.	Checked	G.N.T.
Drawing Status			
PLANNING			
Revision	0	A	
Drawing No.			
TPS/21BS/R/EX/M			

GENERAL NOTES



TPS

Taylor Project Services LLP


No.1 Cornhill
London EC3V 3ND
Tel 020 7743 6602
www.taylorprojectservices.com

Project


21 BEDFORD SQUARE
LONDON
WC1

Scale 1:50 @ A1	Date 10.04.15
Drawn R.J.L.	Checked G.N.T.

Drawing No. TPS/21BS/R/M

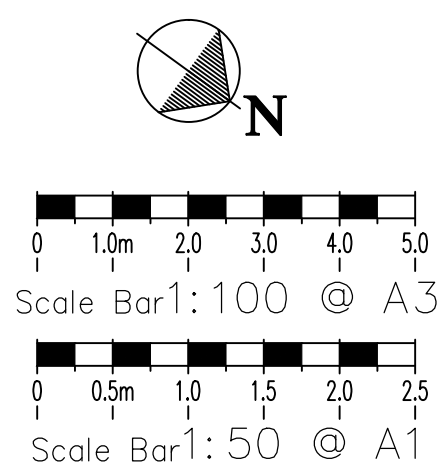

GENERAL NOTES

 

TPS

Taylor Project Services LLP

No.1 Cornhill
London EC3V 3ND
Tel 020 7743 6602
www.taylorprojectservices.com


Project

21 BEDFORD SQUARE
LONDON
WC1

Scale		1:50 @ A1		Date		10.04.15	
Drawn		R.J.L.		Checked		G.N.T.	
Drawing Status							
PLANNING							
Revision	0	A					
Drawing No.							
TPS/21BS/EL/EX/F							



Datum 24.000m 22 Bedford Square 21 Bedford Square 20 Bedford Square

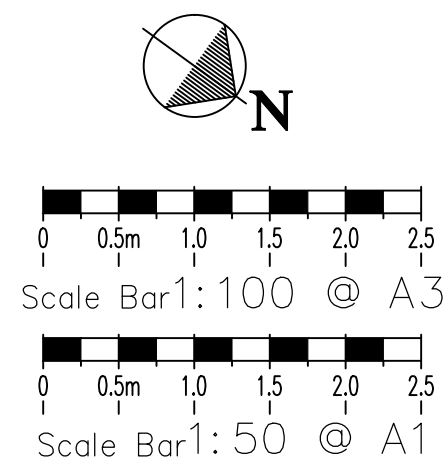

THIS DRAWING MUST NOT BE REPRODUCED WITHOUT PRIOR CONSENT.
DO NOT SCALE FROM THIS DRAWING.
THIS DRAWING IS COPYRIGHTED

GENERAL NOTES


PLANNING		
Rev	Date	Description
A	JUL.15	BACKGROUND UPDATED TO SUIT TFT LAYOUTS
0	APR.15	PLANNING ISSUE

TPS

Taylor Project Services LLP

No.1 Cornhill
London EC3V 3ND
Tel 020 7743 6602
www.taylorprojectservices.com

Client

 **THE BEDFORD ESTATES**
29a Montague Street
London WC1B 5BL
Tel 0171 636 2885
Fax 0171 255 1729

Project

21 BEDFORD SQUARE
LONDON
WC1

Drawing Title

PROPOSED
FRONT ELEVATION
LAYOUT

Scale	1:50 @ A1	Date	10.04.15
Drawn	R.J.L.	Checked	G.N.T.

Drawing Status											
PLANNING											
Revision	0	A									
Drawing No.	TPS/21BS/EL/F										



THIS DRAWING MUST NOT BE REPRODUCED WITHOUT PRIOR CONSENT.
DO NOT SCALE FROM THIS DRAWING.
THIS DRAWING IS COPYRIGHTED

GENERAL NOTES


PLANNING		
Rev	Date	Description
A	JUL.15	BACKGROUND UPDATED TO SUIT TFT LAYOUTS
0	APR.15	PLANNING ISSUE

TPS

Taylor Project Services LLP

No.1 Cornhill
London EC3V 3ND
Tel 020 7743 6602
www.taylorprojectservices.com

Client

 **THE BEDFORD ESTATES**
29a Montague Street
London WC1B 5BL
Tel 0171 636 2885
Fax 0171 255 1729

Project

21 BEDFORD SQUARE
LONDON
WC1

Drawing Title

EXISTING
REAR ELEVATION
LAYOUT

Scale	1:50 @ A1	Date	10.04.15
Drawn	R.J.L.	Checked	G.N.T.
Drawing Status			
PLANNING			
Revision	0	A	
Drawing No.			
TPS/21BS/EL/EX/R			

GENERAL NOTES



A	JUL.15	BACKGROUND UPDATED TO SUIT TFT LAYOUT
0	APR.15	PLANNING ISSUE
Rev	Date	Description

Taylor Project Services LLP
No.1 Cornhill
London EC3V 3ND
Tel 020 7743 6602
www.taylorprojectservices.com

Project


21 BEDFORD SQUARE
LONDON
WC1

Scale 1:50 @ A1	Date 10.04.15
Drawn R.J.L.	Checked G.N.T.


Drawing Status		PLANNING									
Revision	0	A									
Drawing No.		TPS/21BS/EL/R									

THIS DRAWING MUST NOT BE REPRODUCED WITHOUT PRIOR CONSENT.
DO NOT SCALE FROM THIS DRAWING.
THIS DRAWING IS COPYRIGHTED


GENERAL NOTES

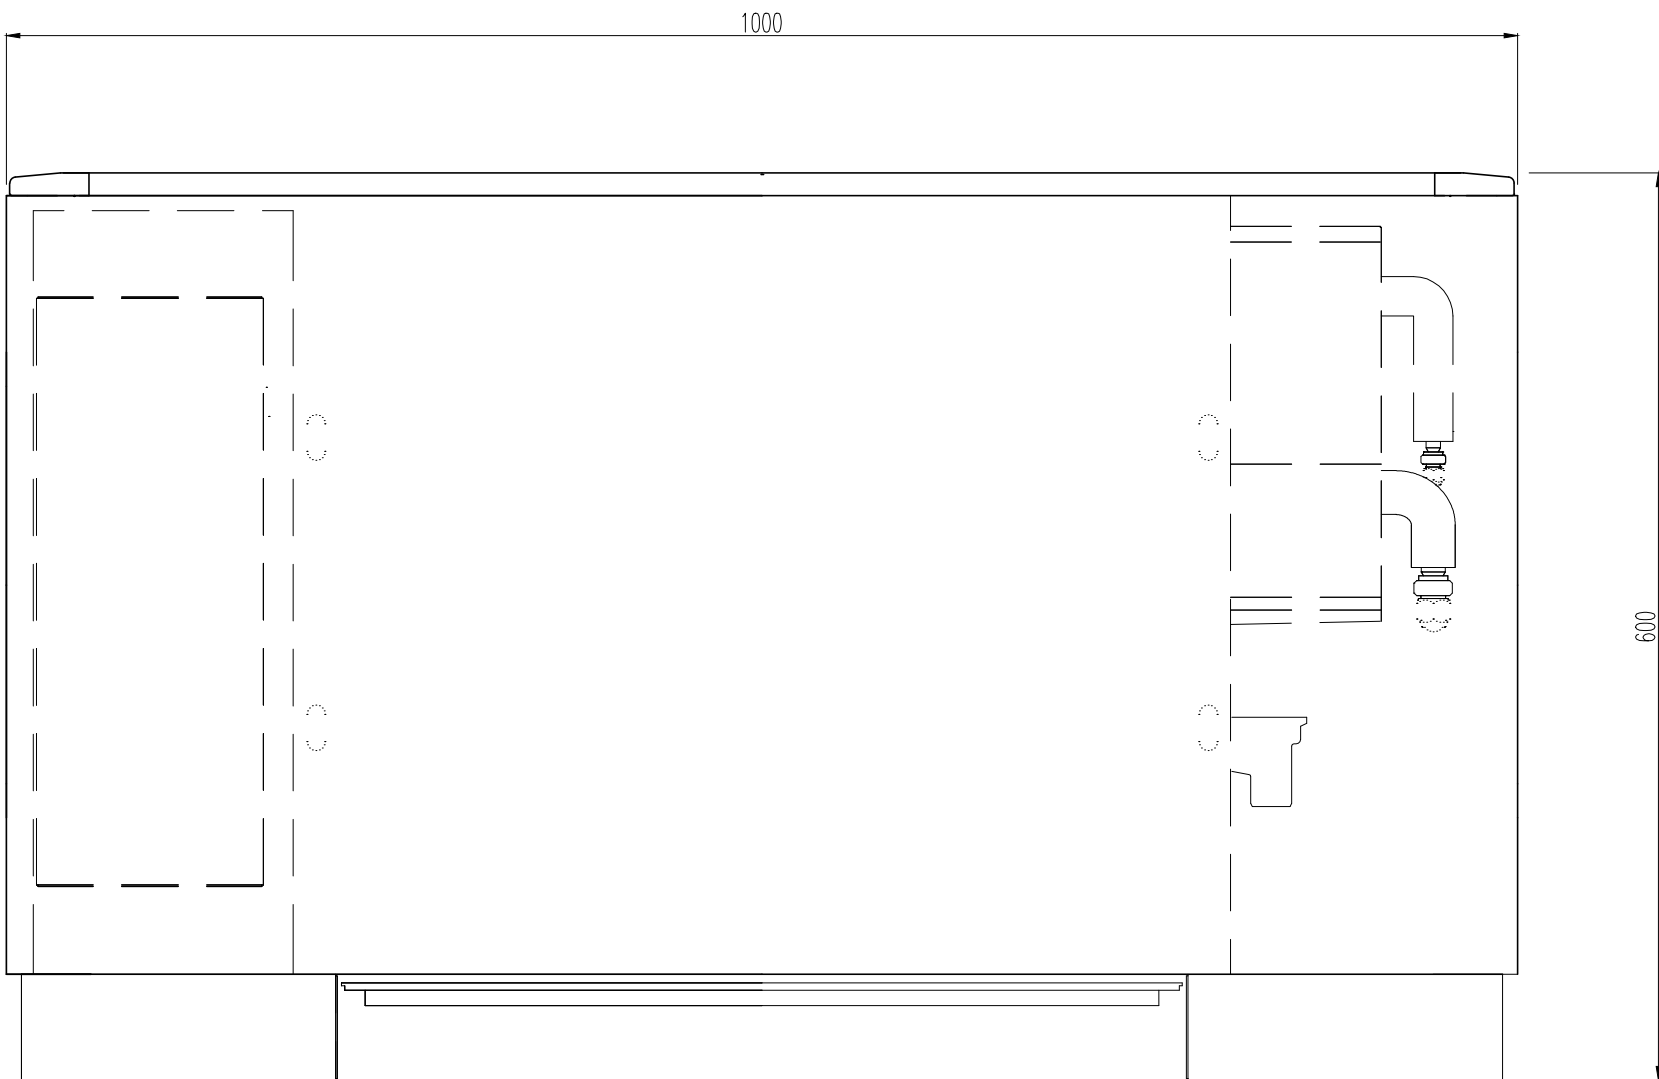

FRONT VIEW

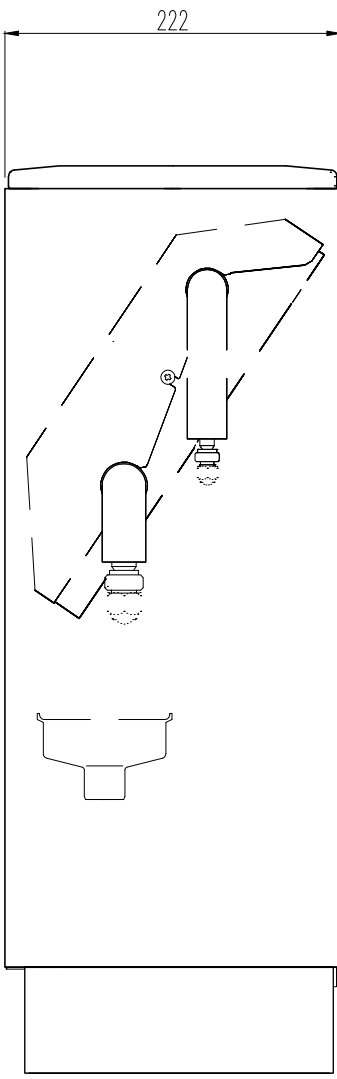


SECTION

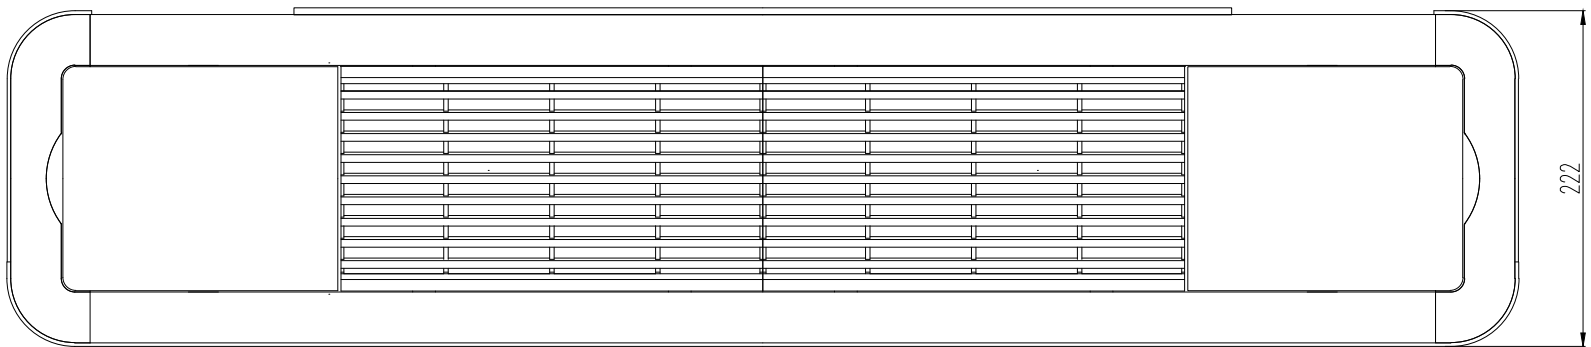

PLAN

DAIKIN PROPRIETARY METAL CASED VRV UNITS

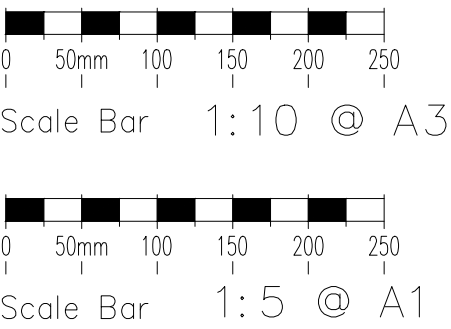

PLANNING


0	APR.15	PLANNING ISSUE
Rev	Date	Description

TPS

Taylor Project Services LLP

No.1 Cornhill
London EC3V 3ND
Tel 020 7743 6602
www.taylorprojectservices.com

Client

THE BEDFORD ESTATES

29a Montague Street
London
WC1B 5BL
Tel 0171 636 2888
Fax 0171 255 1729

Project

21 BEDFORD SQUARE
LONDON
WC1

Drawing Title

VRV STANDARD CASING DETAIL
(SECOND & THIRD FLOORS)

Scale	1:5 @ A1	Date	10.04.15
Drawn	R.J.L.	Checked	G.N.T.


Drawing Status

PLANNING


Revision	0																		
----------	---	--	--	--	--	--	--	--	--	--	--	--	--	--	--	--	--	--	--

Drawing No.


TPS/21BS/VRV/M

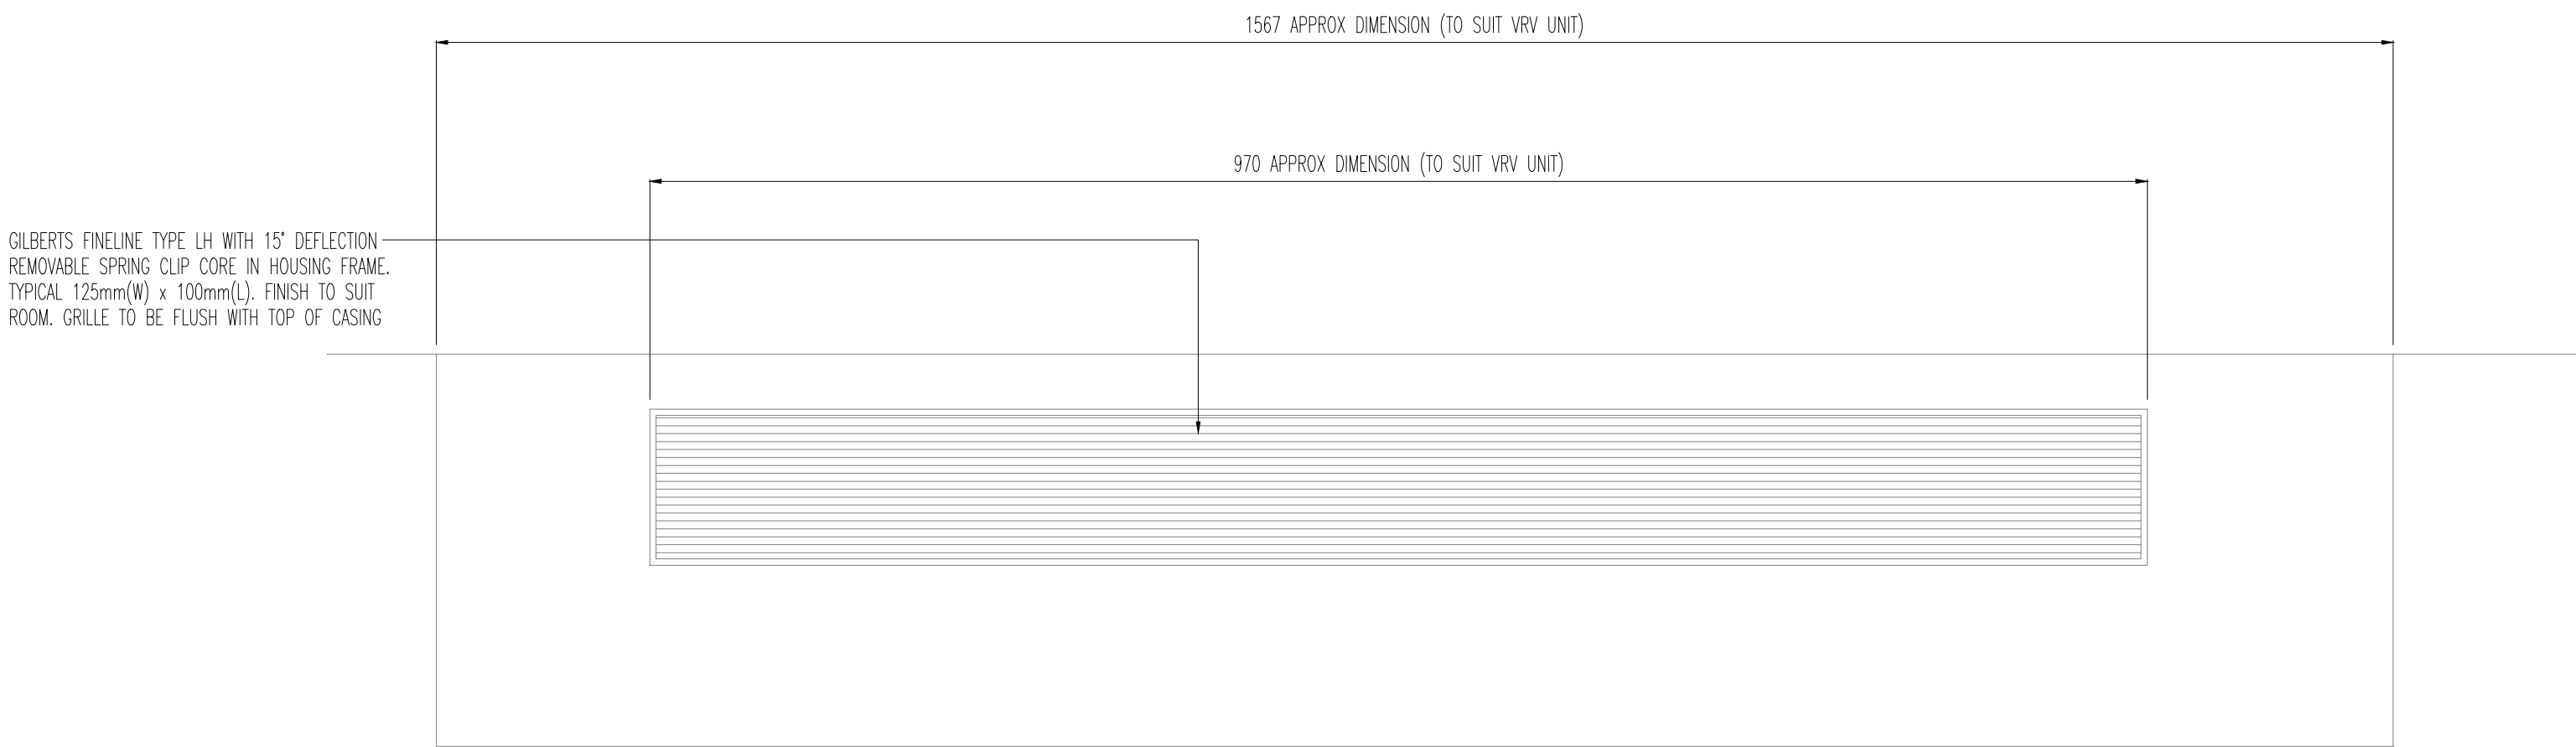


TOP VIEW

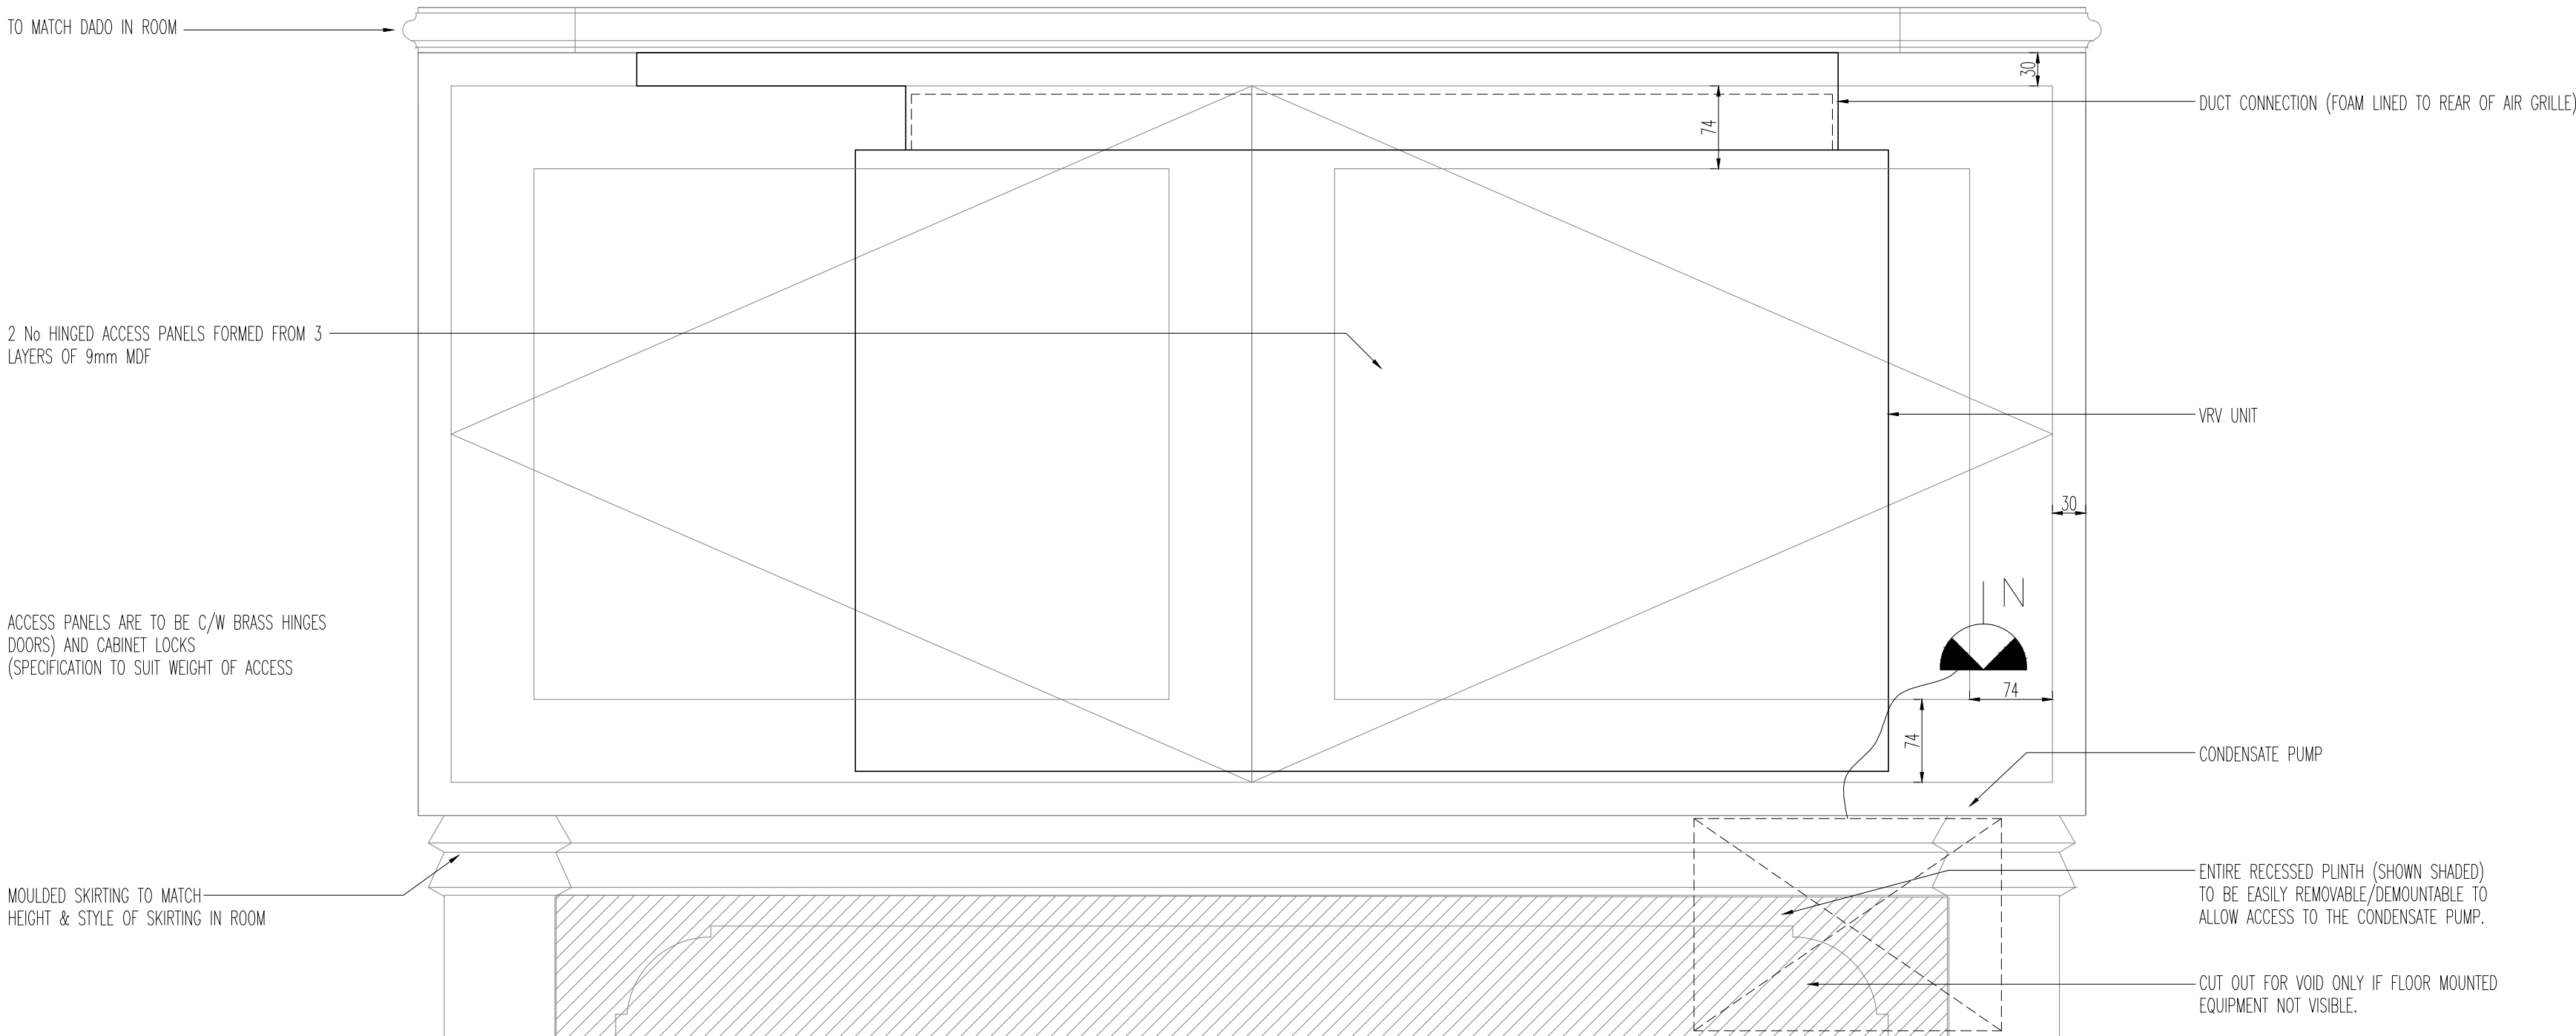


FRONT VIEW

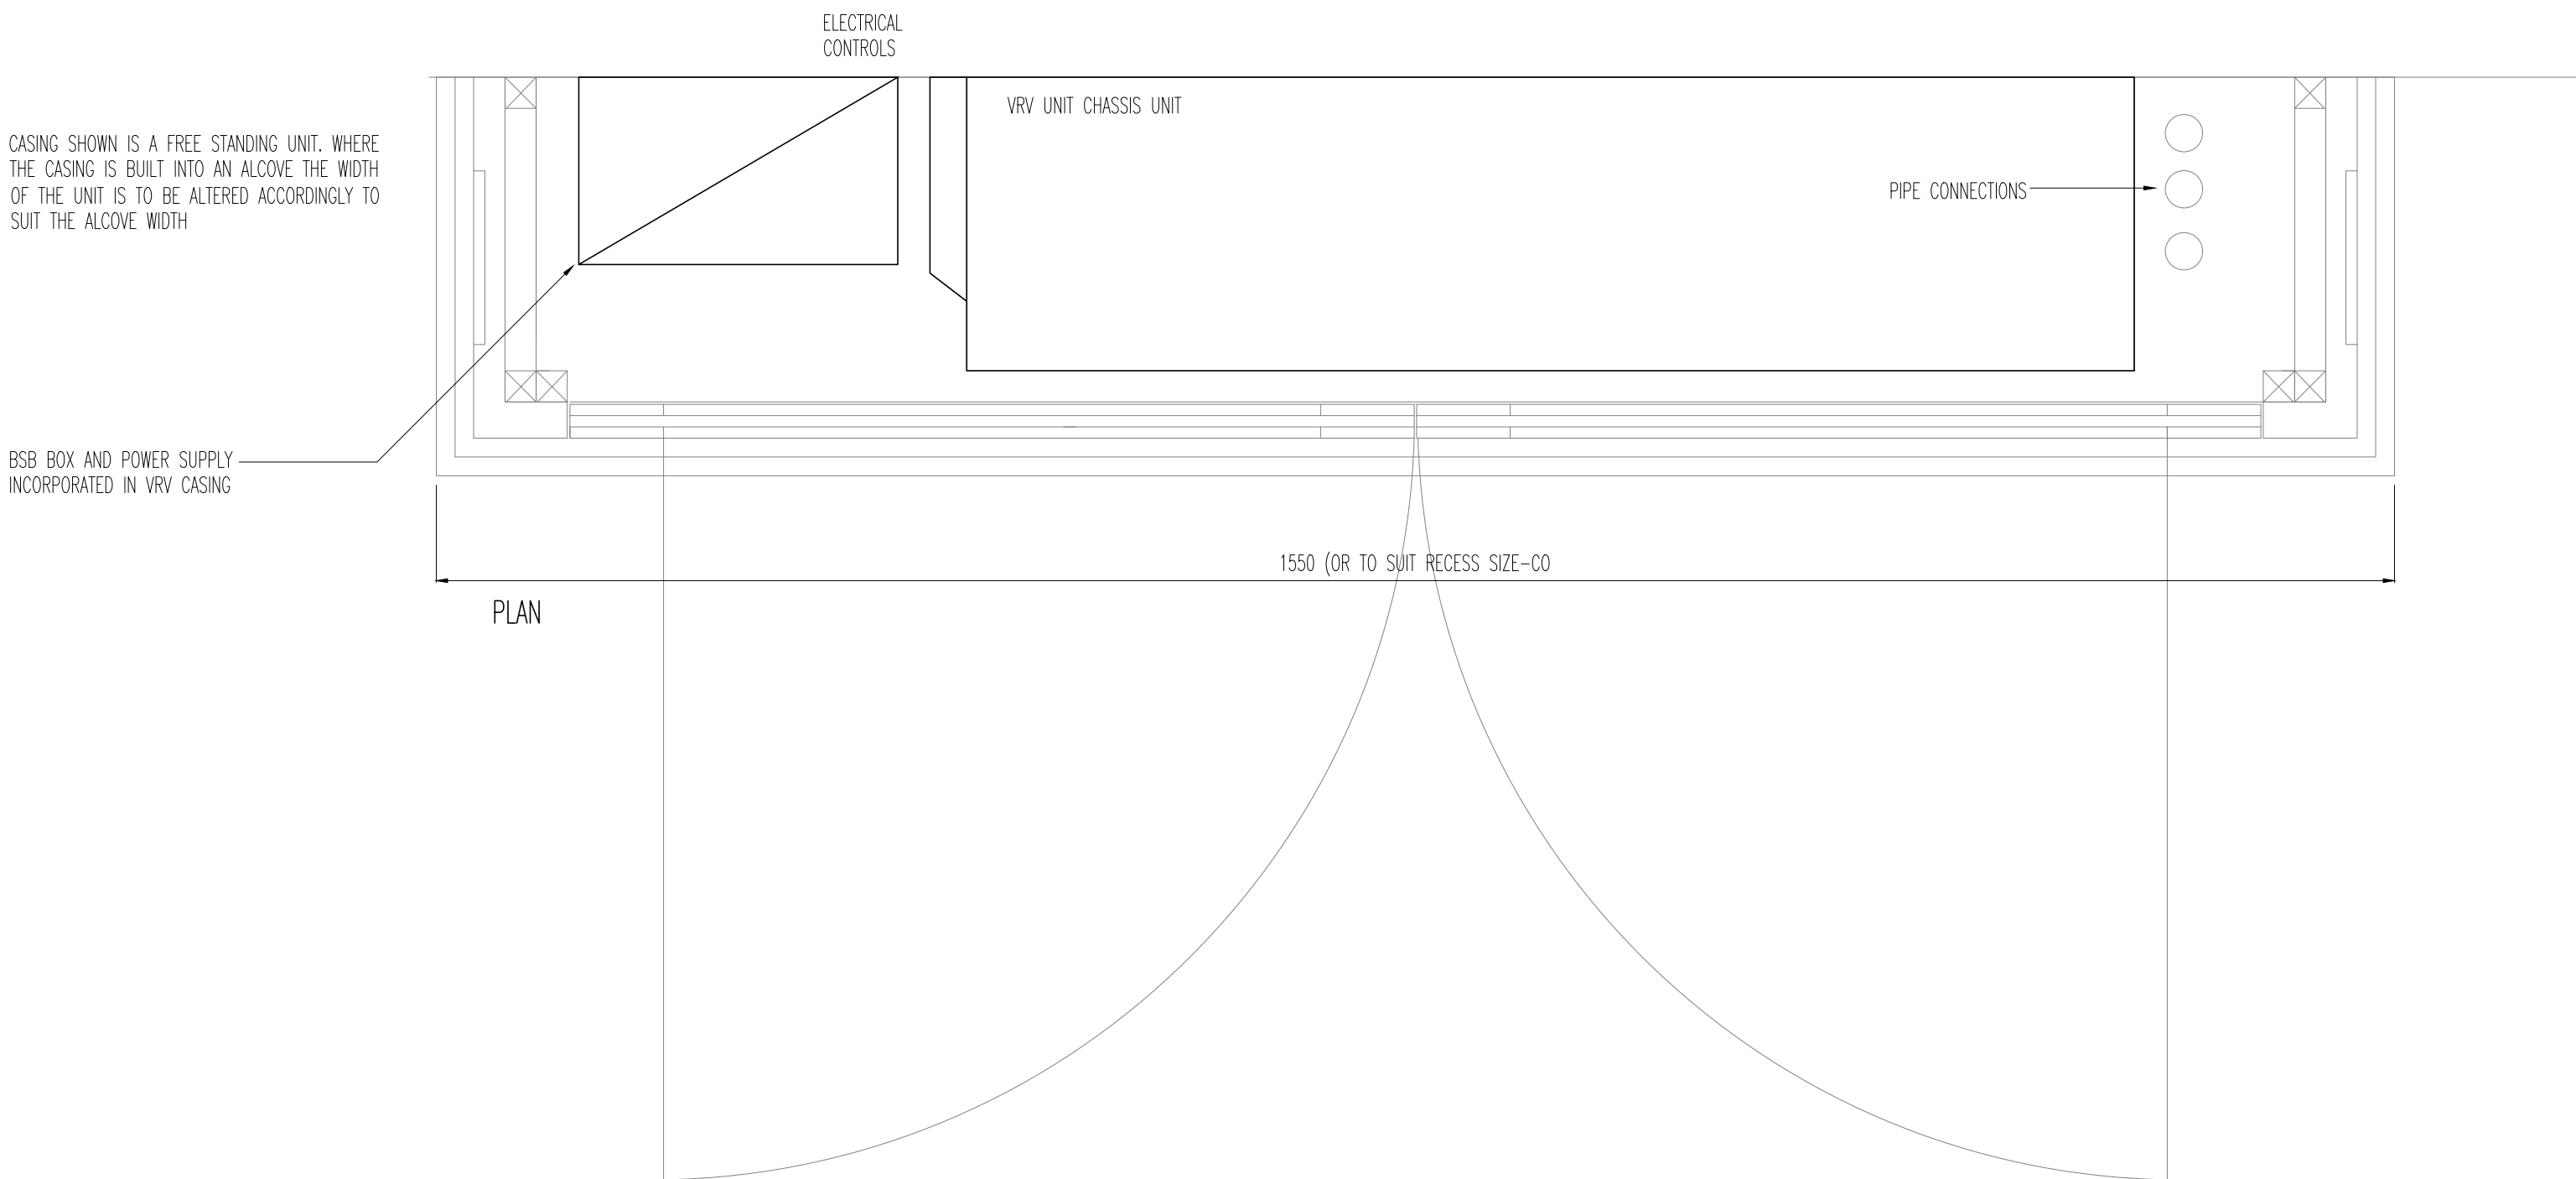


PLAN

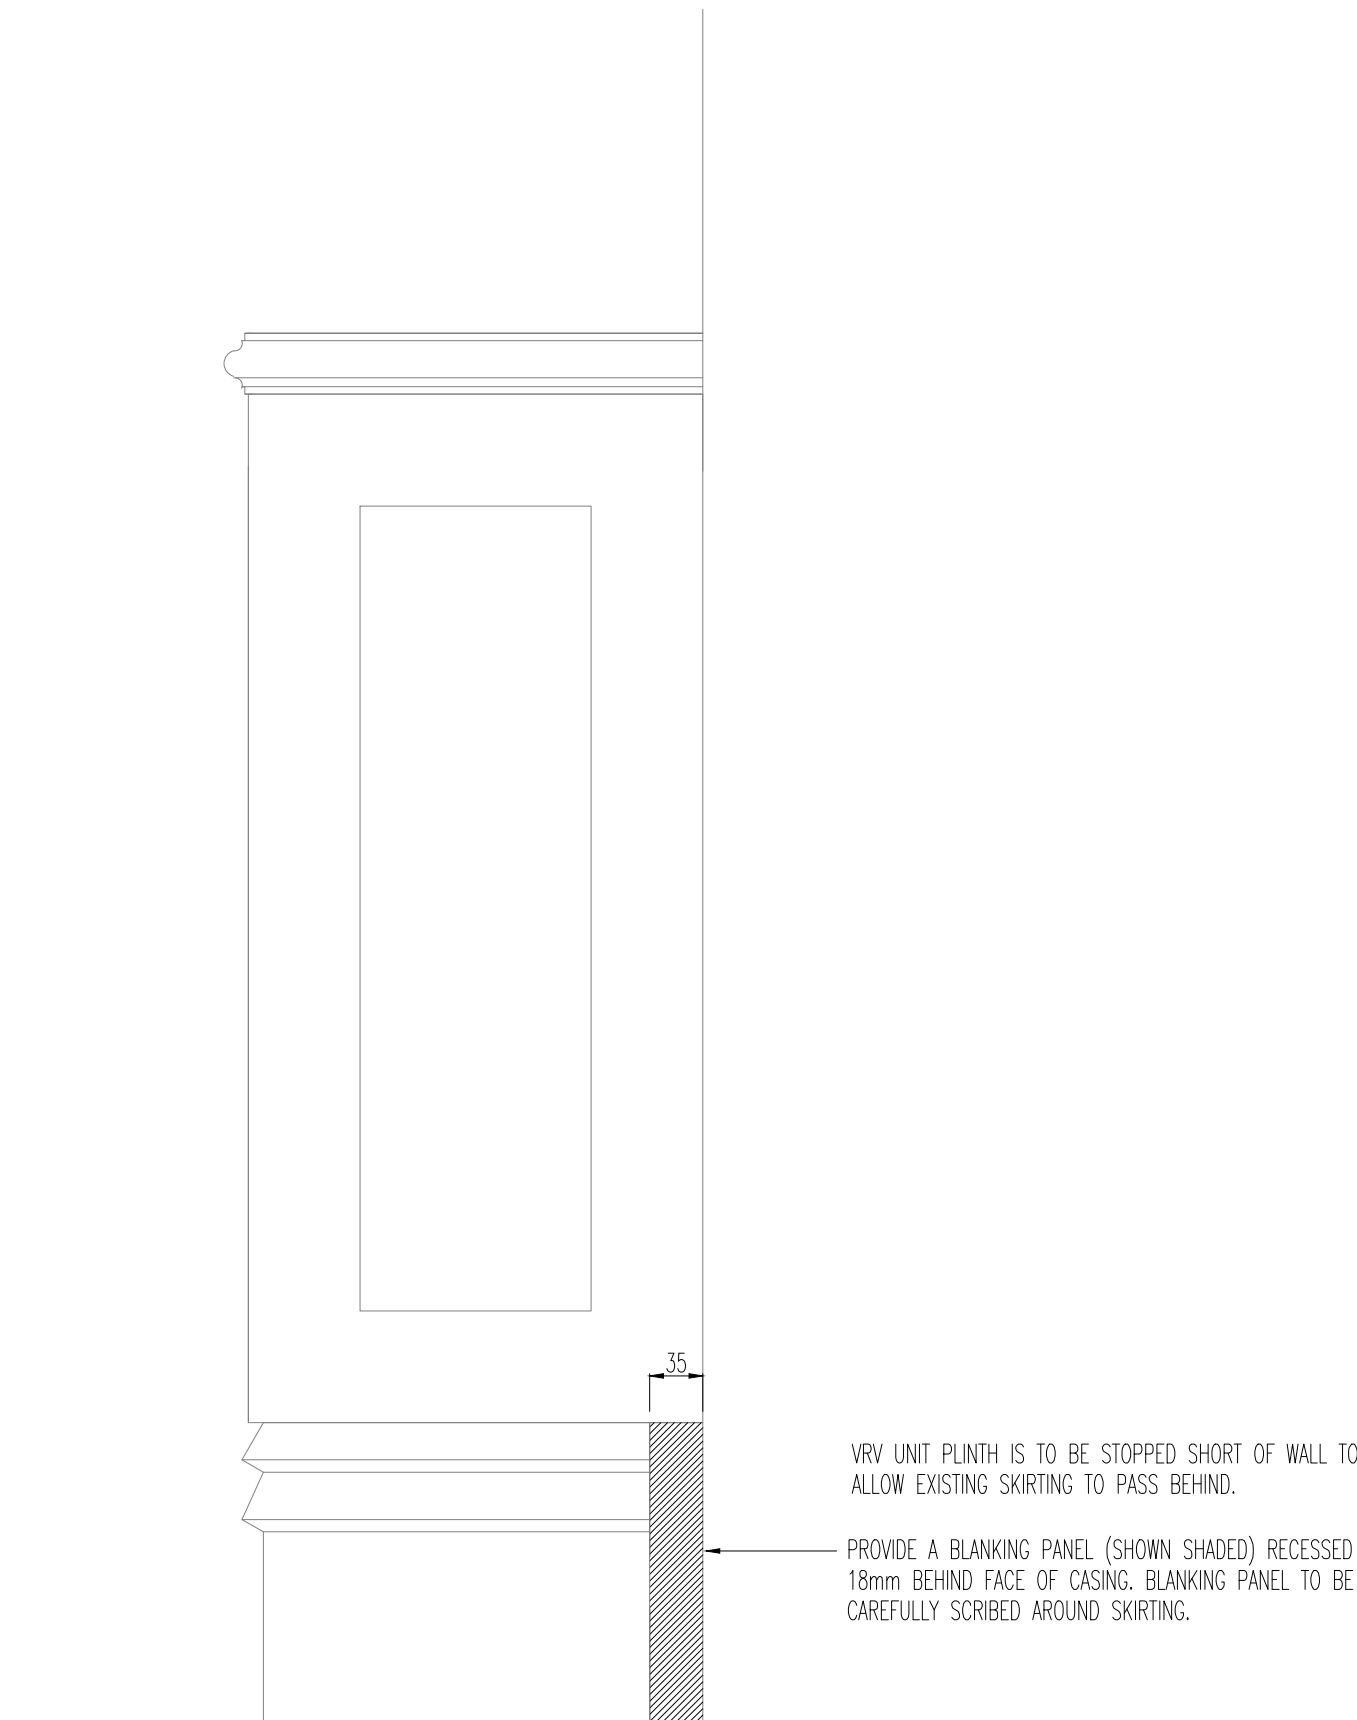

SIDE VIEW

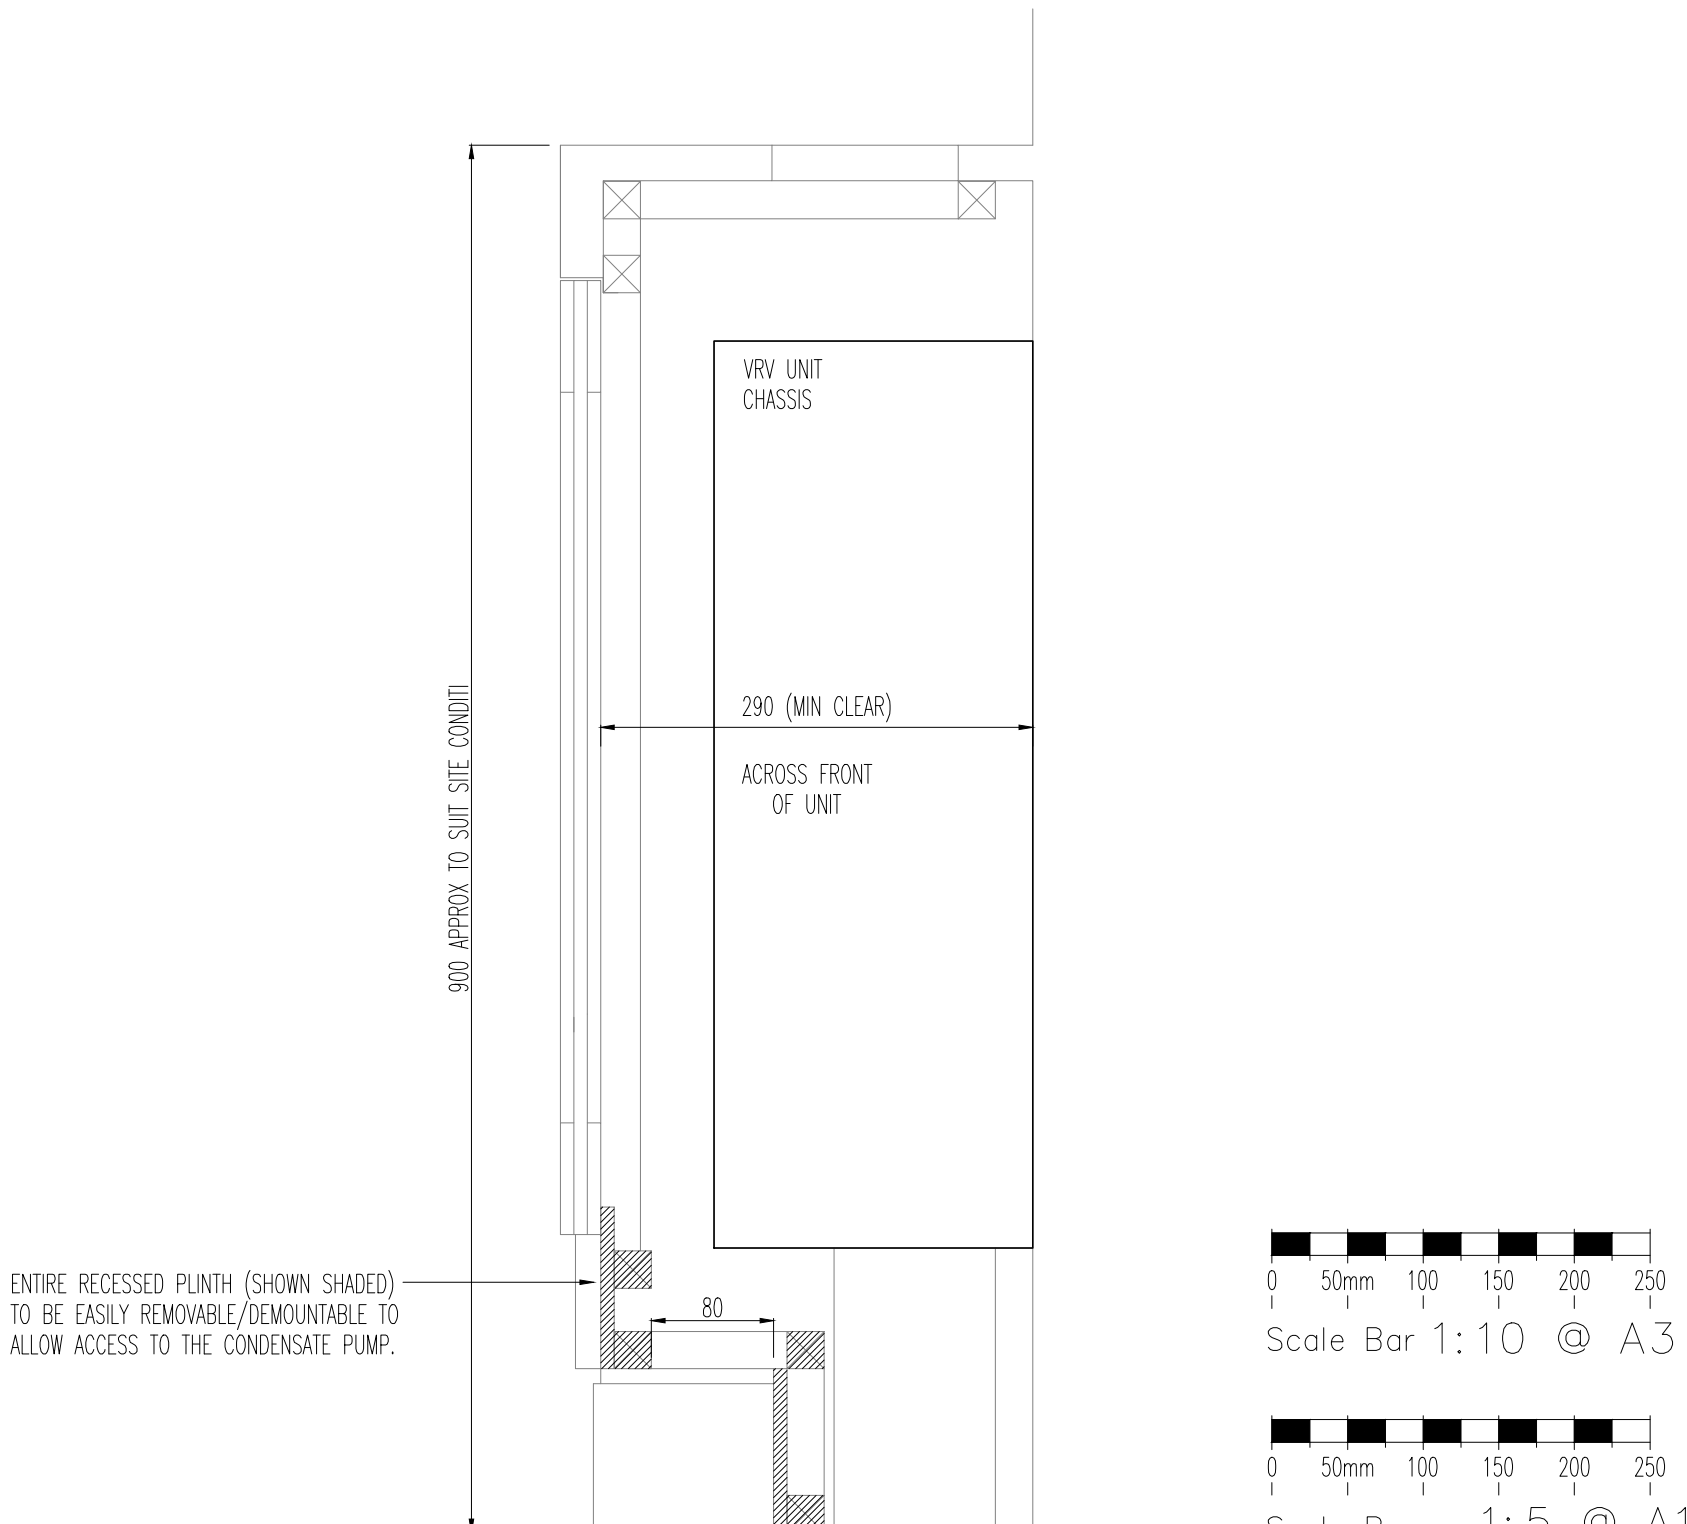

SECTION

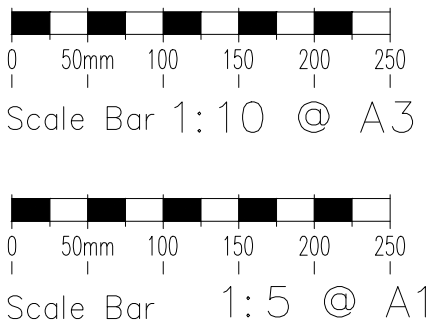

THIS DRAWING MUST NOT BE REPRODUCED WITHOUT PRIOR CONSENT.
DO NOT SCALE FROM THIS DRAWING.
THIS DRAWING IS COPYRIGHTED

GENERAL NOTES

PLANNING		
Rev	Date	Description
0	APR.15	PLANNING ISSUE

TPS

Taylor Project Services LLP

No.1 Cornhill
London EC3V 3ND
Tel 020 7743 6602
www.taylorprojectservices.com

Client

THE BEDFORD ESTATES

29a Montague Street
London WC1B 5BT
Tel 0171 434 2888
Fax 0171 255 1729

Project

21 BEDFORD SQUARE
LONDON
WC1

Drawing Title

VRV JOINERY CASING DETAIL
(LOWER GROUND, GROUND &
& FIRST FLOOR)

Scale	1:5 @ A1	Date	10.04.15
Drawn	R.J.L.	Checked	G.N.T.

Drawing Status


PLANNING

Revision	0																		
----------	---	--	--	--	--	--	--	--	--	--	--	--	--	--	--	--	--	--	--

Drawing No.


TPS/21BS/VRV/J

NOTES

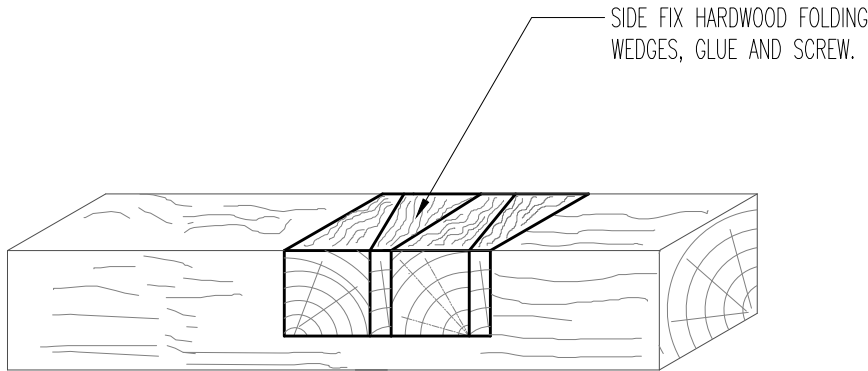

NOTCH REPAIR DETAIL
FOR LONG NOTCH


FOR NOTCHES GREATER THAN 25mm DEEP.

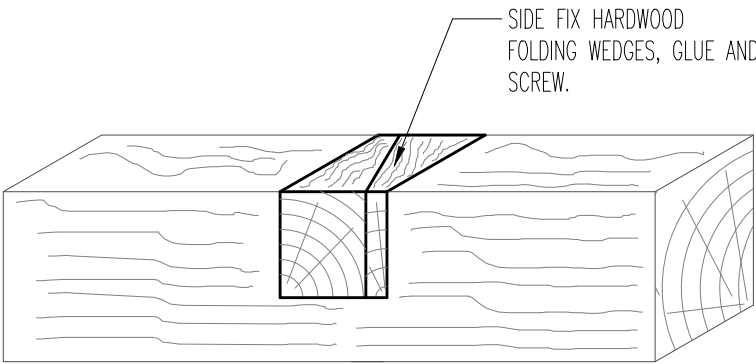

NOTCH REPAIR DETAIL 2


FOR NOTCHES GREATER THAN 25mm DEEP.

NOTES

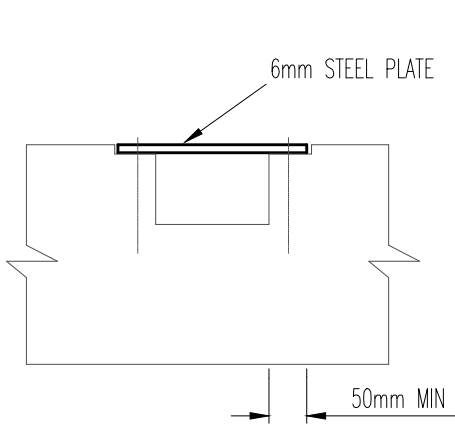


NOTCH REPAIR DETAIL 1

FOR NOTCHES UPTO 25mm DEEP AND OVER SERVICES

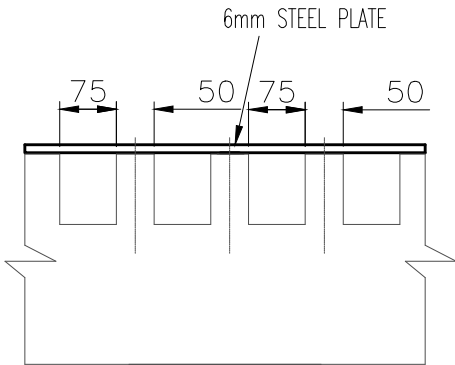


MULTI-NOTCH DETAIL 2

FOR NOTCHES UPTO 25mm DEEP AND OVER SERVICES

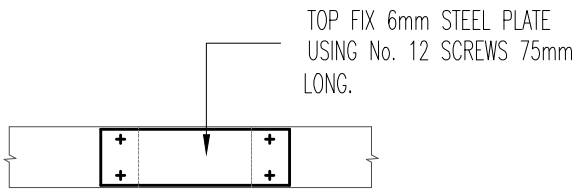

PLAN ON NOTCH REPAIR

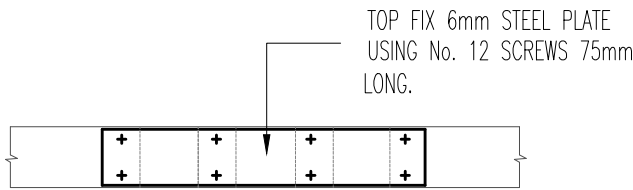

PLAN ON MULTI-NOTCH REPAIR

TPS

Taylor Project Services LLP

No.1 Cornhill
London
EC3V 3ND
Tel 020 7743 6602
www.taylorprojectservices.com

Project

21 BEDFORD SQUARE
LONDON
WC1

Drawing Title

TIMBER NOTCH PLATE REPAIR

Scale 1:10@A3
Date APR.15
Drawn L.R.
Chkd G.N.T.

0	APR.15	PLANNING ISSUE
---	--------	----------------

Rev	Date	Description
-----	------	-------------

Drg No.	21BS-TN1
---------	----------

Rev	0
-----	---

Status	PLANNING
--------	----------