
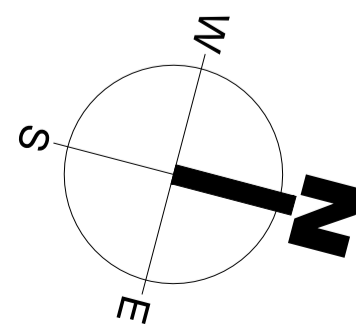


SCALE 1:200 @ A1

PROPOSED GROUND FLOOR PLAN 01

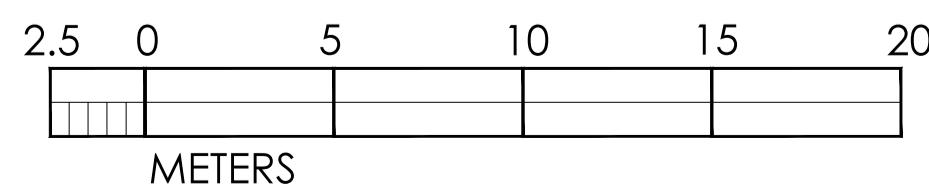

C	15-09-02 LANDLORDS PROPOSED CONDENSERS MOVED TO 1.0M FROM EXG' PENTHOUSE	MN
B	15-08-28 BOILER FLUES AND LOUVER PROPOSALS ADDED	MN
A	15-07-23 REFERENCE TO CONSENTED ENTRANCE CORE OMITTED	MN
/	15-06-08 PLANNING	KLT

client	GYMBOX 9		
project	120 HOLBORN LONDON EC1		
title	PROPOSED GROUND PLAN		
scale	1:200@A1		
date	MAY 2015	status	PLANNING
drawn by	KLT	checked by	MNA
job no.	1191	dwg no.	013 C



notes: This drawing is copyright. Do not scale from drawing. The Main Contractor is to check all dimensions and report any discrepancies to the Project Architect prior to work on site.