



PROPOSED PIPE SUPPORT METHOD
NOT TO SCALE

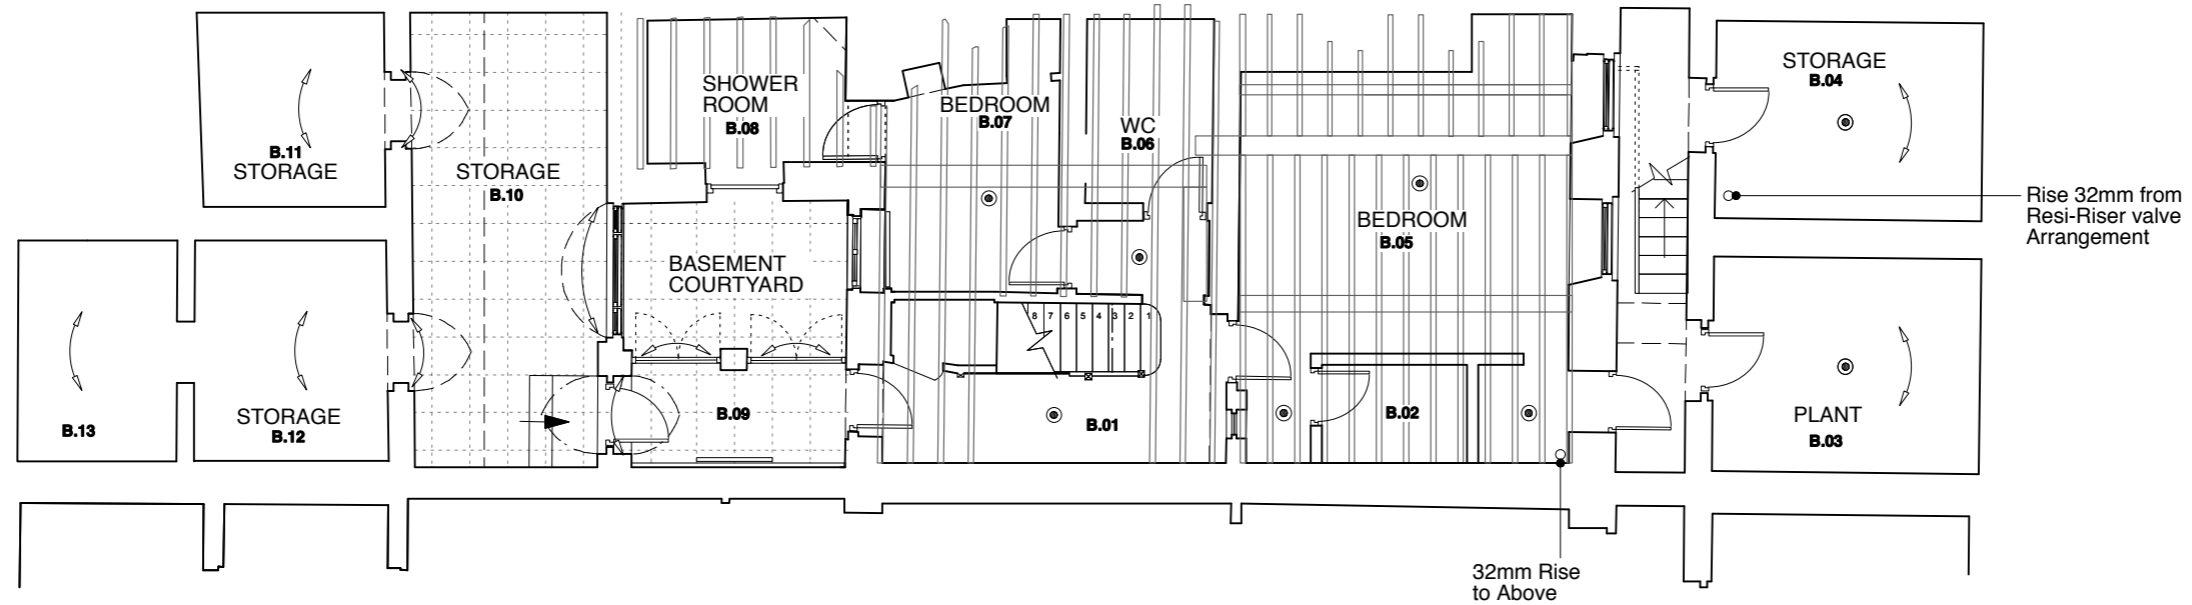

PROPOSED BASEMENT FLOOR PLAN SHOWING SPRINKLER LAYOUT ON GROUND FLOOR JOISTS

KEY
 Sprinkler head



GENERAL NOTES:
 DO NOT SCALE FROM THIS DRAWING.
 ALL DIMENSIONS MUST BE CHECKED ON SITE AND ANY DISCREPANCIES VERIFIED WITH THE ARCHITECT.

Rev A - 13.01.15
 Client revisions following meeting with planning officer

CLIENT
MR AND MRS MACDONAGH

JOB TITLE
**30 GREAT JAMES ST.
 LONDON
 WC1N 3EY**

DRAWING TITLE
**BASEMENT RCP
 SHOWING SPRINKLER
 LAYOUT**

SCALE 1:100@A3	DATE 09.14
--------------------------	----------------------

FT ARCHITECTS LTD
 Hamilton House
 Mabledon Place
 Bloomsbury
 WC1H 9BB
 020 7953 0388
 www.ftarchitects.co.uk

DRAWING No. 241_51_01	REVISION A
---------------------------------	----------------------