


GENERAL NOTES:
 DO NOT SCALE FROM THIS DRAWING.
 ALL DIMENSIONS MUST BE CHECKED ON SITE AND ANY DISCREPANCIES VERIFIED WITH THE ARCHITECT.

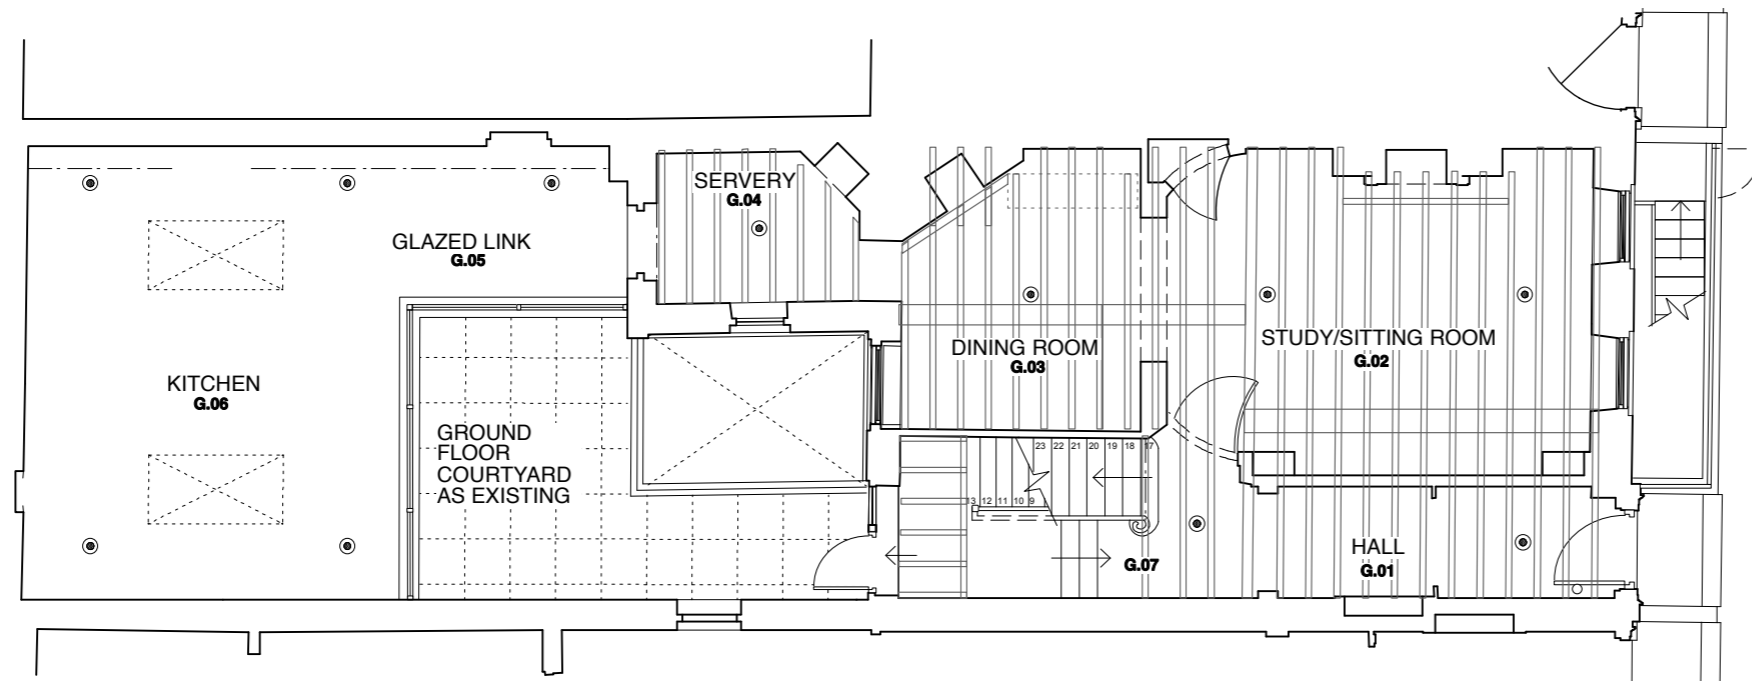

PROPOSED GROUND FLOOR PLAN SHOWING SPRINKLER LAYOUT ON FIRST FLOOR JOISTS

KEY
 ● Sprinkler head

Rev A - 13.01.15
 Client revisions following meeting with planning officer

CLIENT
MR AND MRS MACDONAGH

JOB TITLE
30 GREAT JAMES ST. LONDON WC1N 3EY

DRAWING TITLE
GROUND FLOOR RCP SHOWING SPRINKLER LAYOUT

SCALE	DATE
1:100@A3	09.14

FT ARCHITECTS LTD
 Hamilton House
 Mabledon Place
 Bloomsbury
 WC1H 9BB
 020 7953 0388
 www.ftarchitects.co.uk

DRAWING No.	REVISION
241_51_02	A

