


GENERAL NOTES:  
 DO NOT SCALE FROM THIS DRAWING.  
 ALL DIMENSIONS MUST BE CHECKED ON SITE AND ANY DISCREPANCIES VERIFIED WITH THE ARCHITECT.

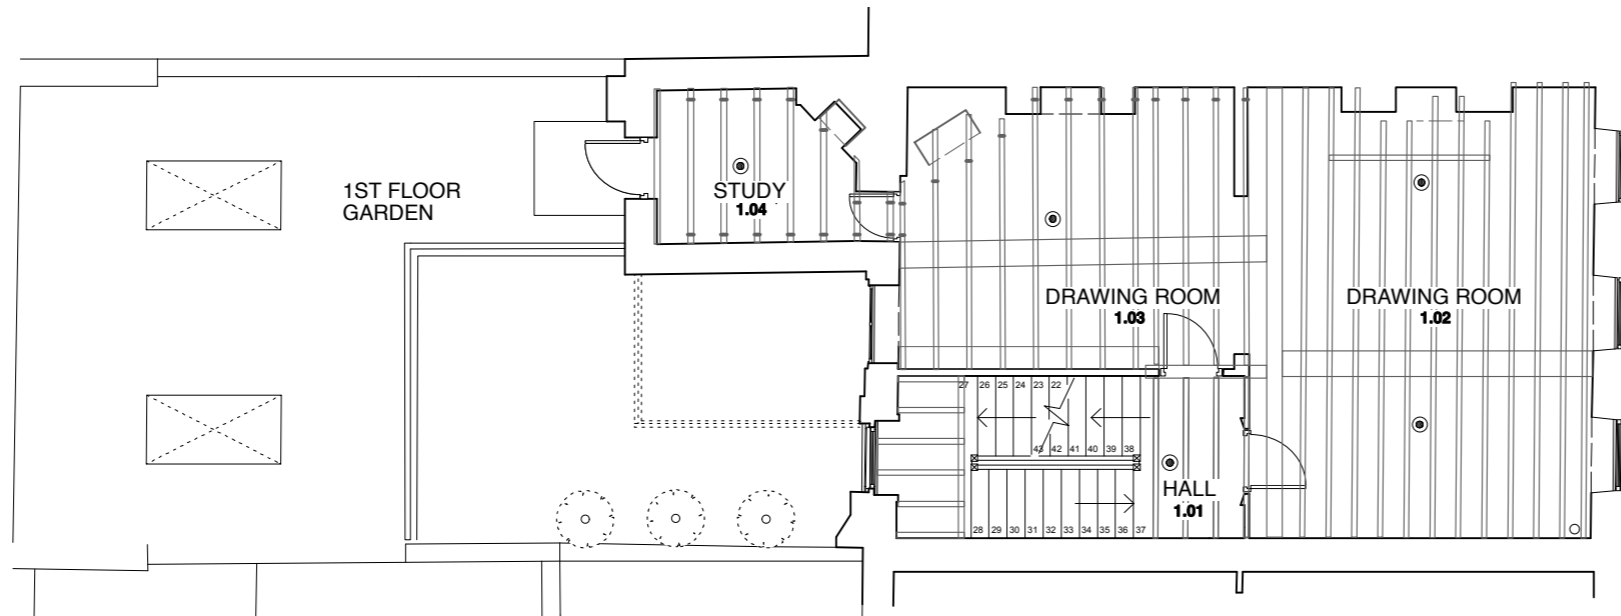

PROPOSED FIRST FLOOR PLAN SHOWING SPRINKLER LAYOUT ON SECOND FLOOR JOISTS

KEY  
 ● Sprinkler head

Rev A - 13.01.15  
 Client revisions following meeting with planning officer

CLIENT  
**MR AND MRS MACDONAGH**

JOB TITLE  
**30 GREAT JAMES ST. LONDON WC1N 3EY**

DRAWING TITLE  
**FIRST FLOOR RCP SHOWING SPRINKLER LAYOUT**

SCALE	DATE
<b>1:100@A3</b>	<b>09.14</b>

**FT ARCHITECTS LTD**  
 Hamilton House  
 Mabledon Place  
 Bloomsbury  
 WC1H 9BB  
 020 7953 0388  
 www.ftarchitects.co.uk

DRAWING No.	REVISION
<b>241_51_03</b>	<b>A</b>

