


GENERAL NOTES:
 DO NOT SCALE FROM THIS DRAWING.
 ALL DIMENSIONS MUST BE CHECKED ON SITE AND ANY DISCREPANCIES VERIFIED WITH THE ARCHITECT.

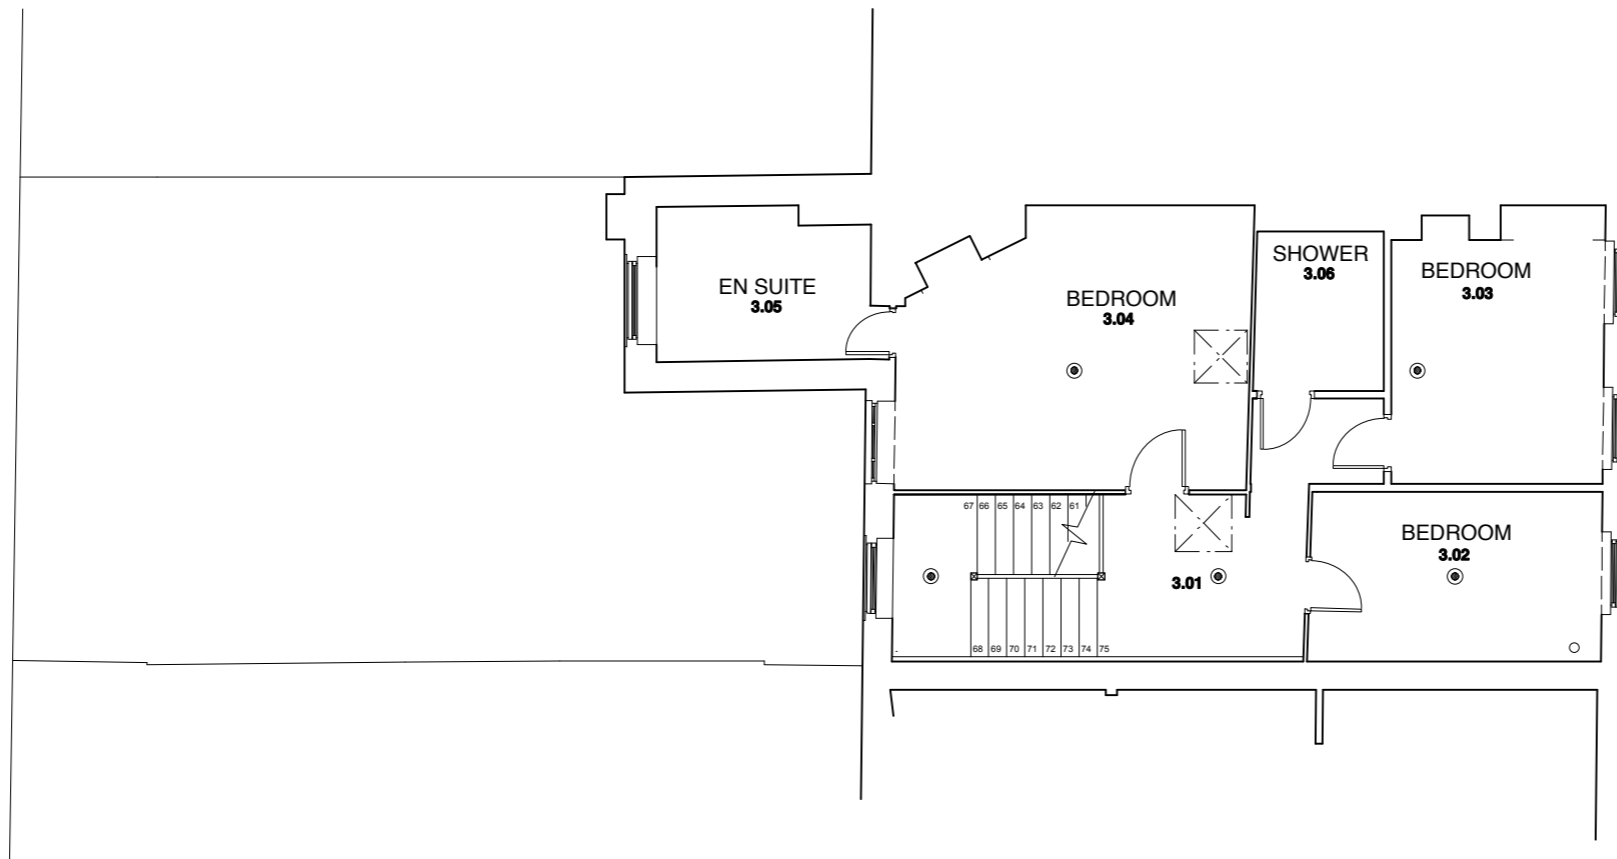

PROPOSED THIRD FLOOR PLAN SHOWING SPRINKLER LAYOUT.
 LAYOUT TO BE COORDINATED WITH ROOF JOIST LAYOUT

KEY
 ● Sprinkler head



Rev A - 13.01.15
 Client revisions following meeting with planning officer

CLIENT

**MR AND MRS
 MACDONAGH**

JOB TITLE

**30 GREAT JAMES ST.
 LONDON
 WC1N 3EY**

DRAWING TITLE

**THIRD FLOOR RCP
 SHOWING SPRINKLER
 LAYOUT**

SCALE

1:100@A3

DATE

09.14

FT ARCHITECTS LTD

Hamilton House
 Mabledon Place
 Bloomsbury
 WC1H 9BB

020 7953 0388

www.ftarchitects.co.uk

DRAWING No.

241_51_05

REVISION

A