



ROOF PLANTROOM

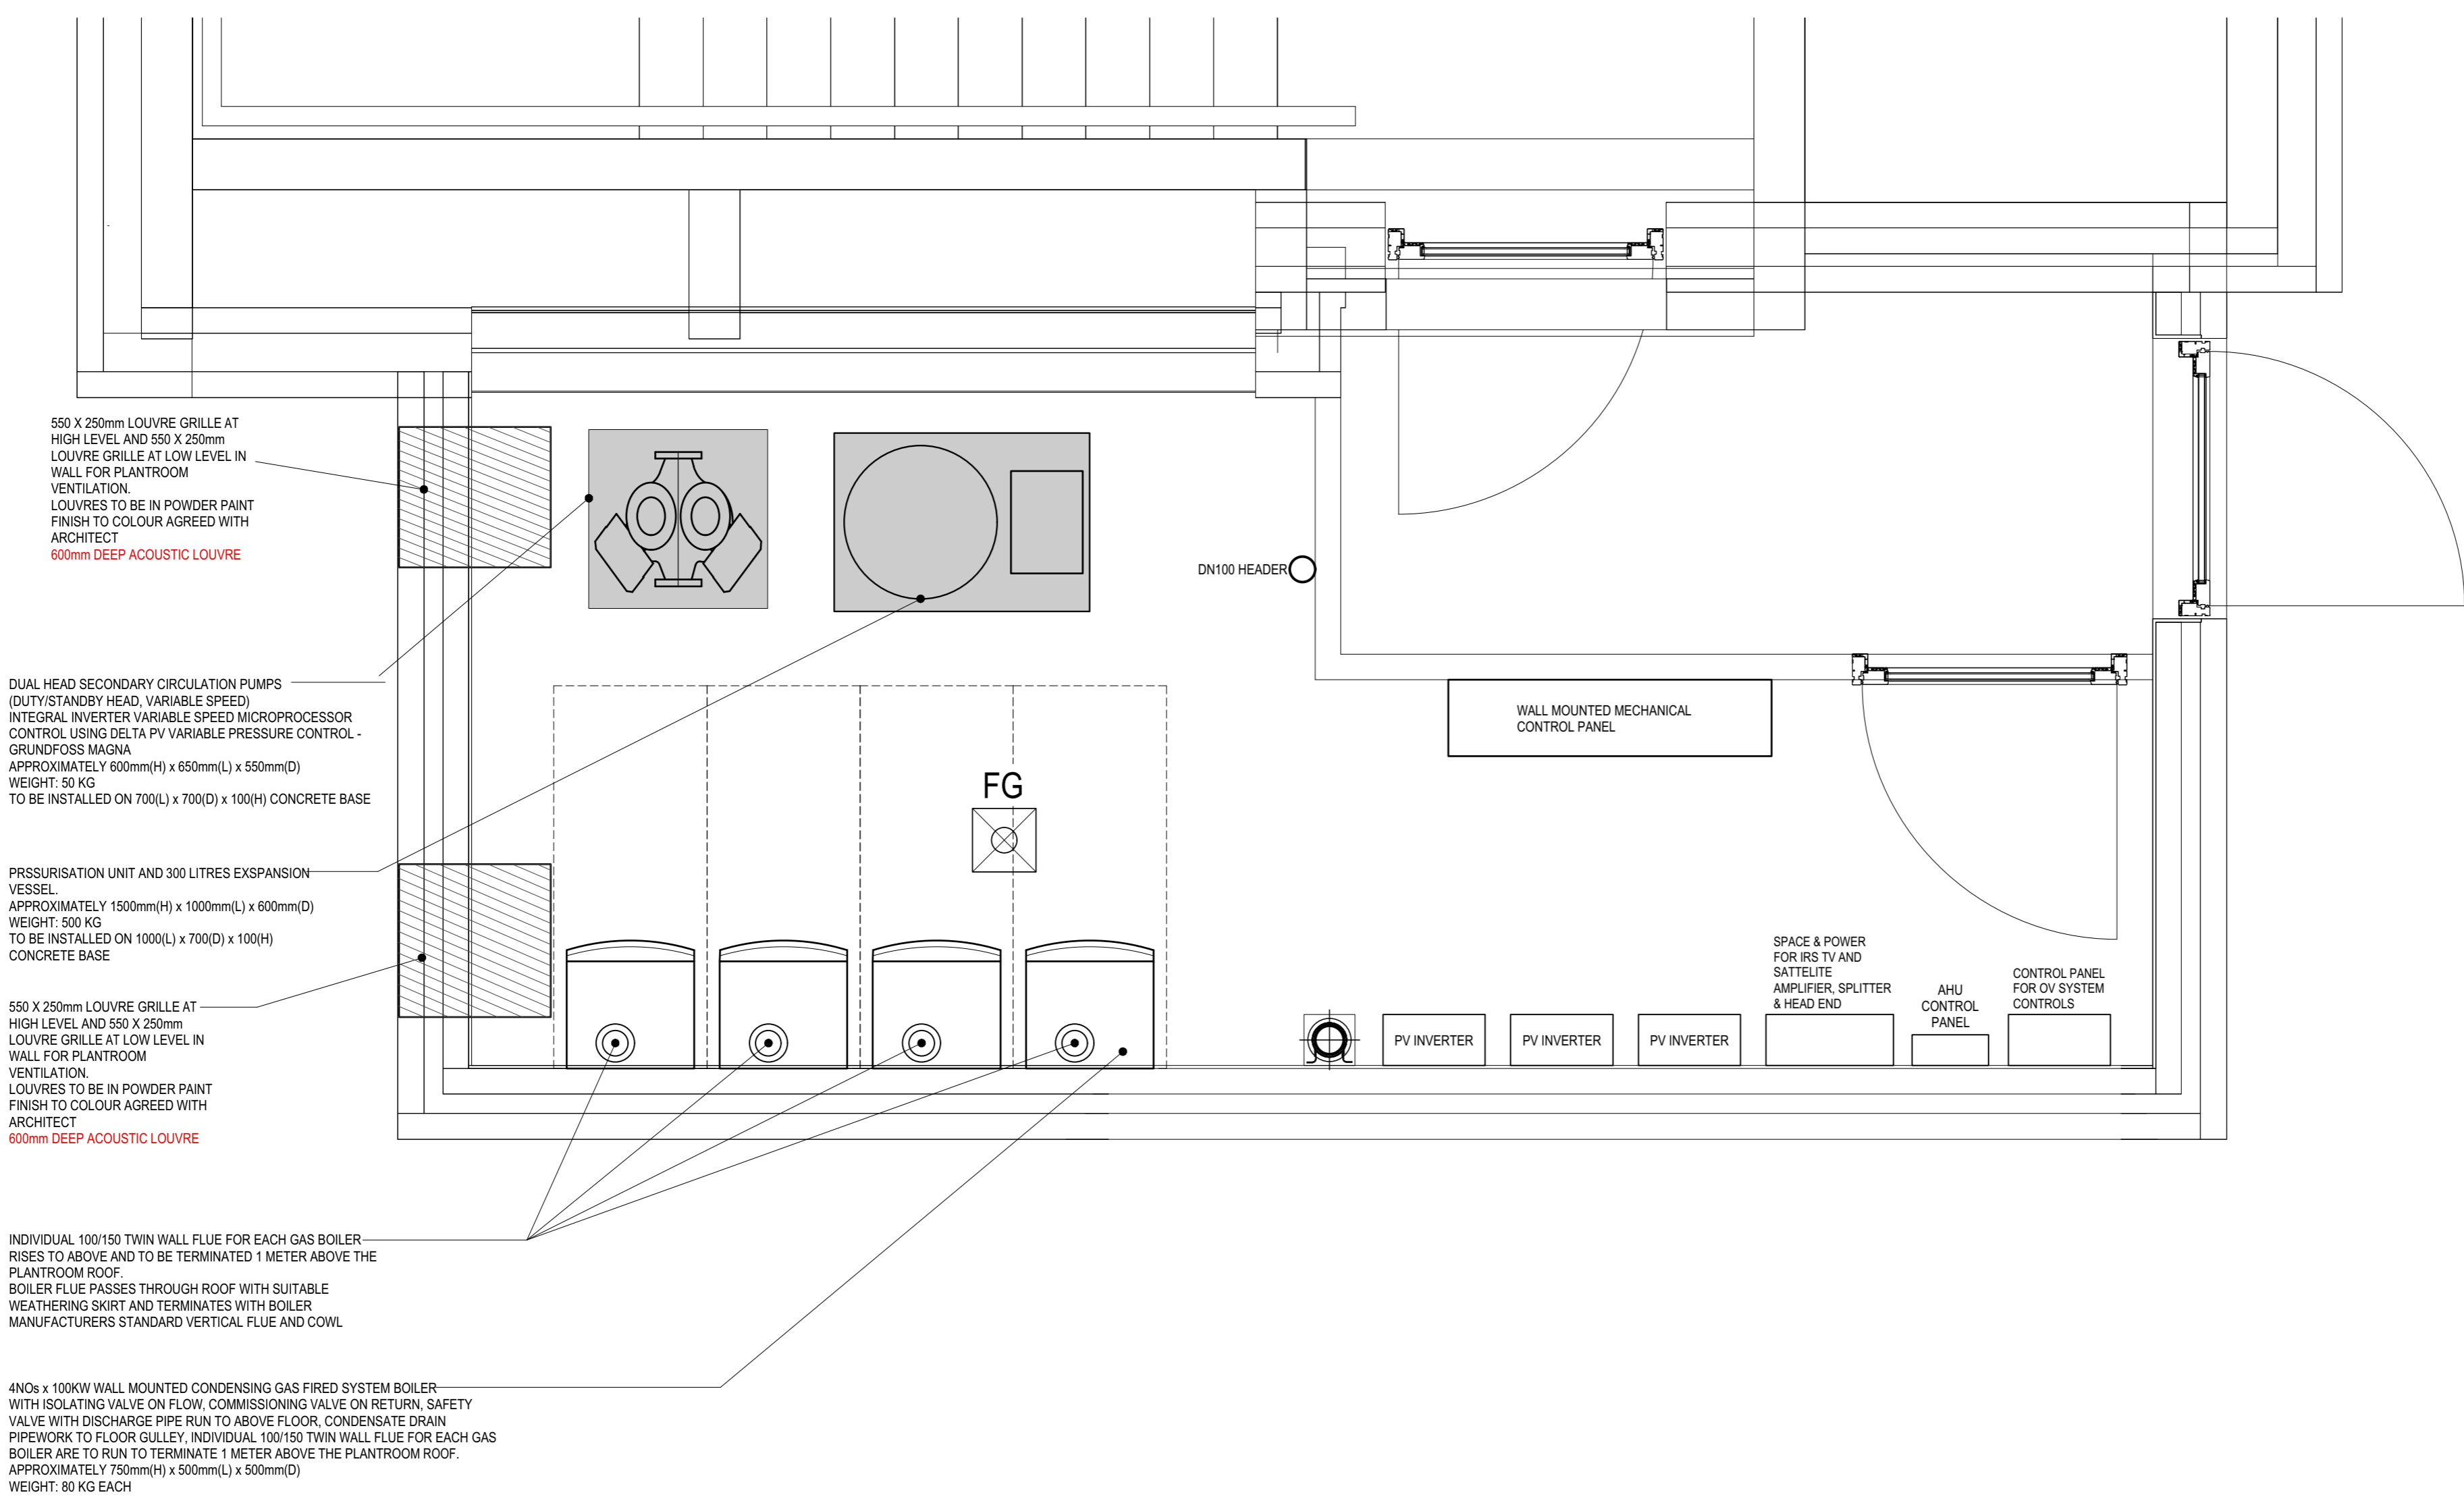

NOTES:
 1. THIS DRAWING IS TO BE READ IN CONJUNCTION WITH ELECTRICAL / MECHANICAL SPECIFICATION.
 2. ALL LOUVRES SIZED ON 50% FREE AREA.

GROUND FLOOR COLD WATER TANK & BOOSTER PLANTROOM

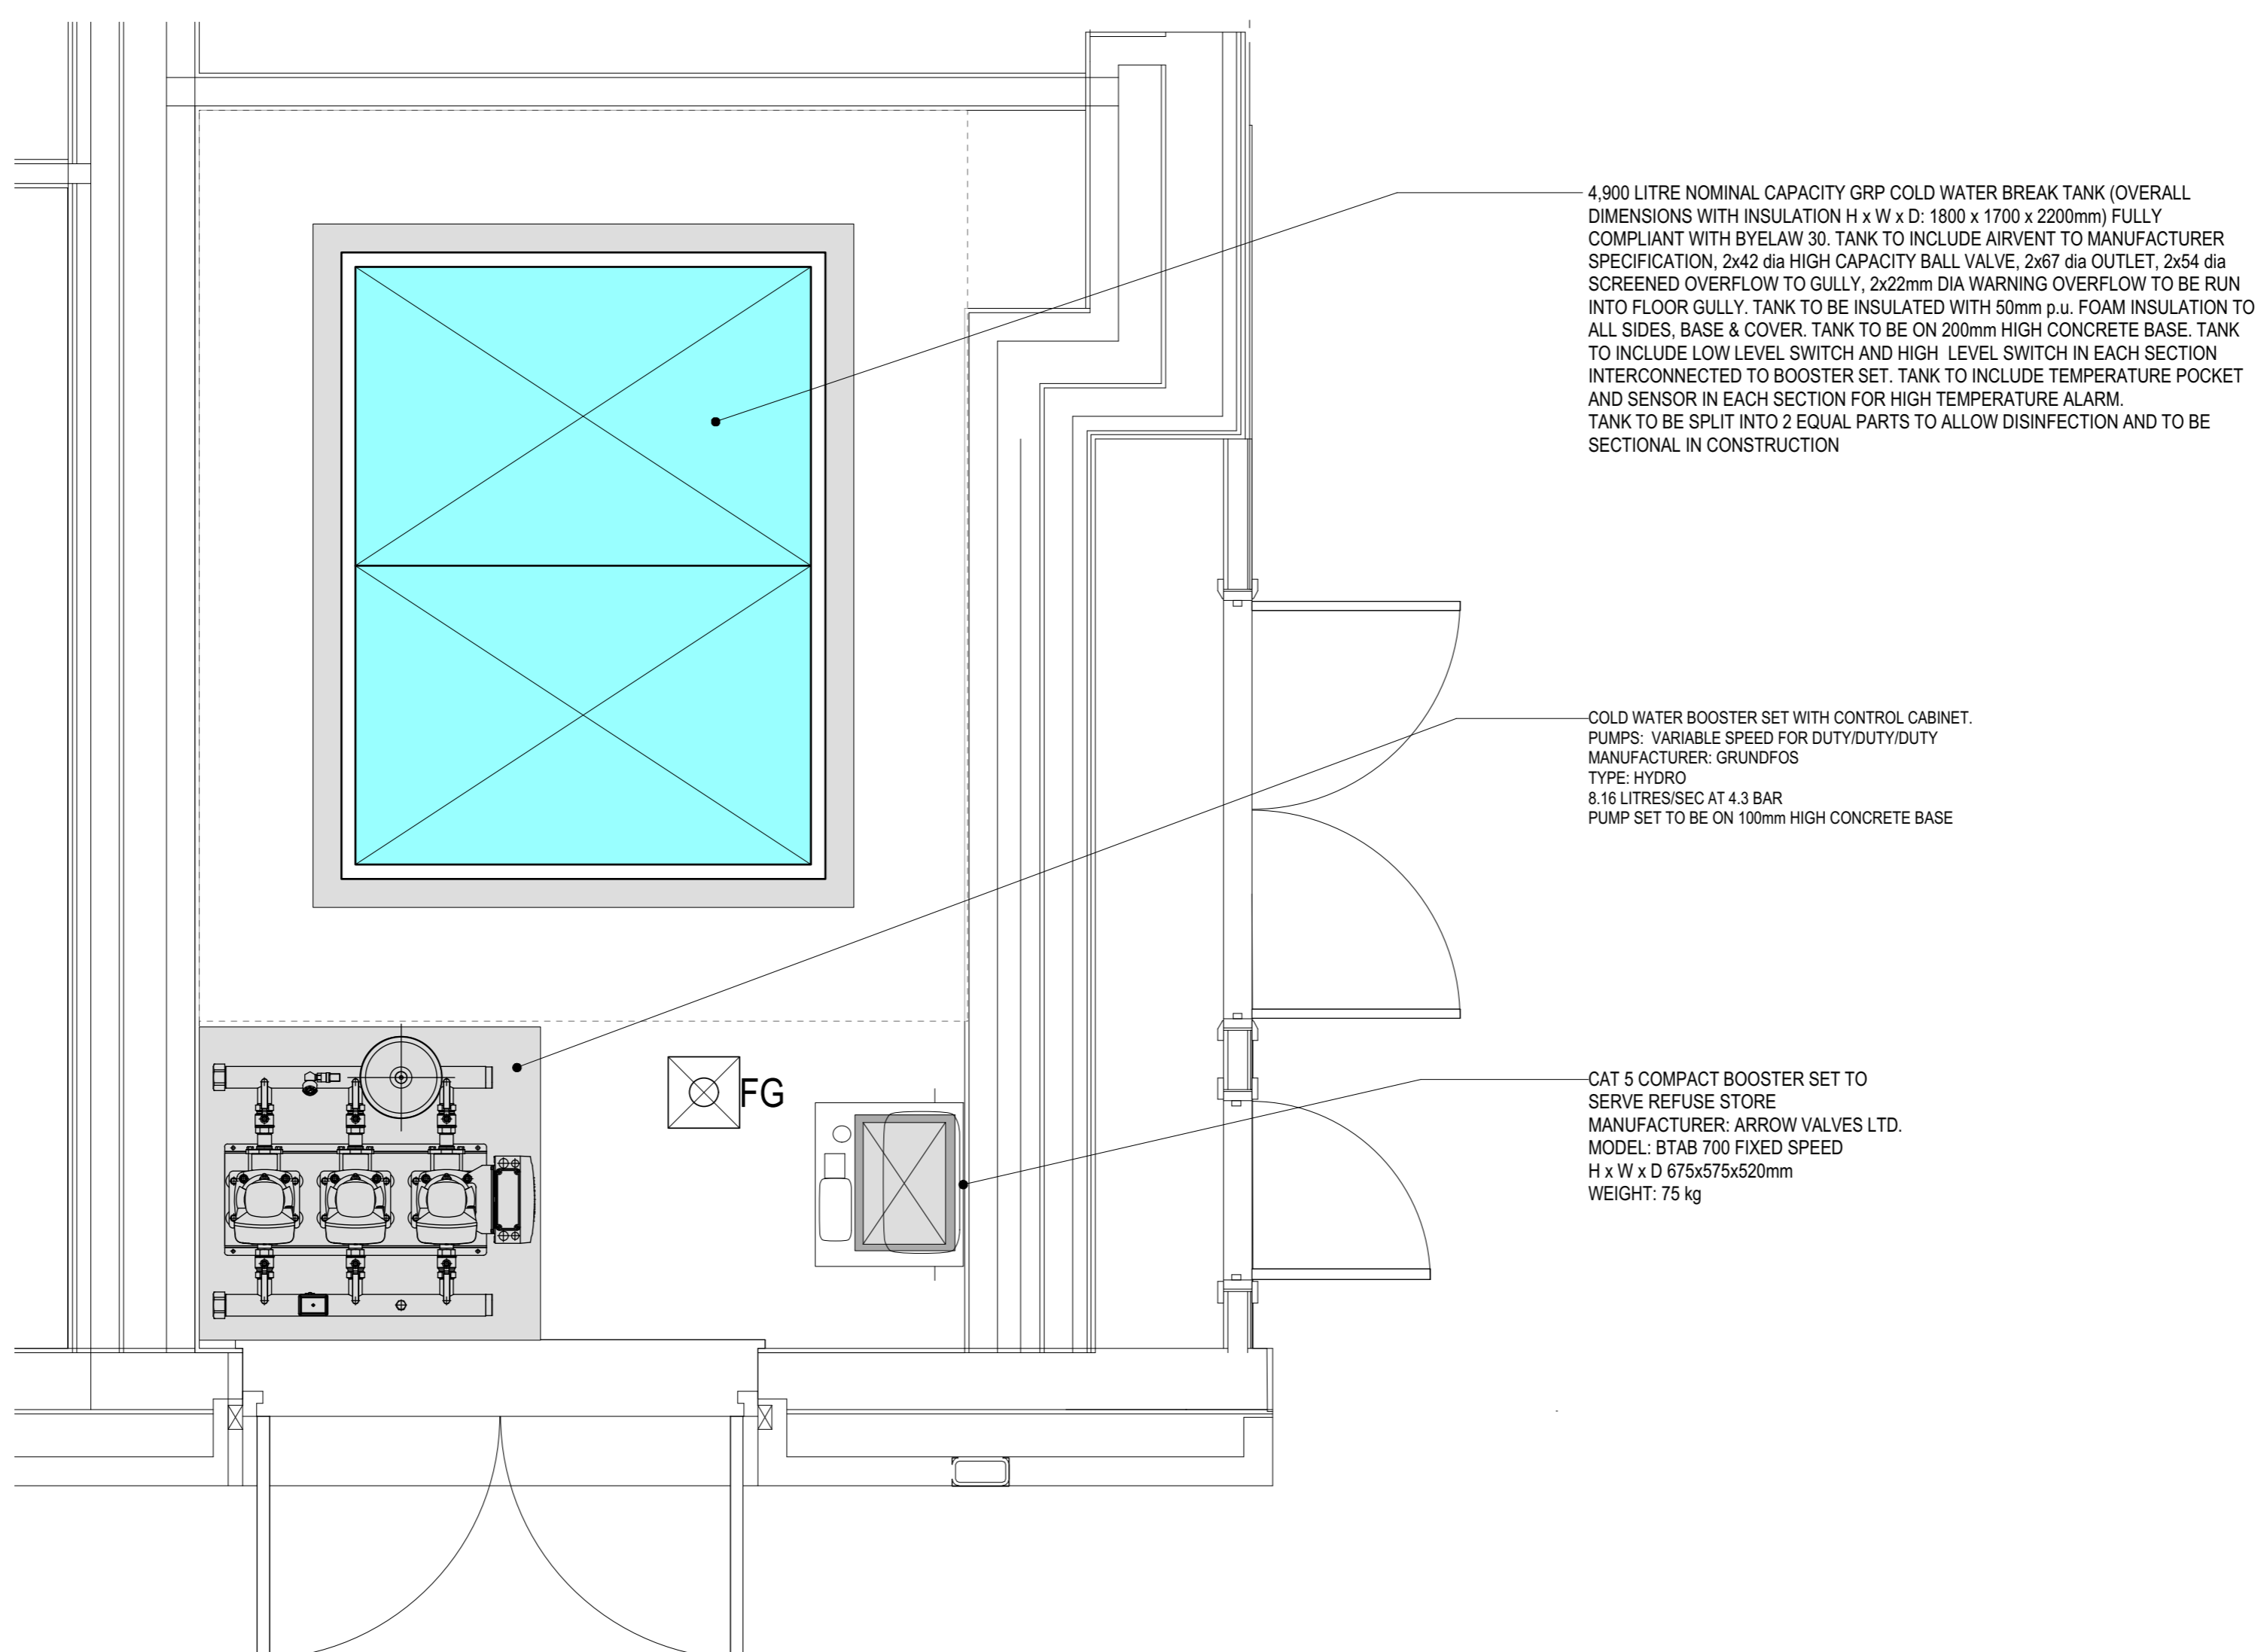

Revision	Author	Date	By
A	PLANTROOM LOUVRE REVISED	05/11/15	A.F.
Amendment Details		Date	By



Job Name:
Agar Grove Block A

Title:
Plantroom Layout

Scale:	Date:	Checked:	Drawn by:	Approved:
1:20 @ A1	Aug 15	M. R.	F. W.	M. R.
Orig. No:	RA5494/7007			Revision
				A

ROBINSON ASSOCIATES
 CHARTERED BUILDING SERVICES ENGINEERS
 www.robinsonengineers.co.uk
 Telephone : 0203 637 1122
 Unit 1, 6 Enterprise Way
 London SW18 1PZ