


PLAN OF NORTH EAST GATE
 (Scale 1:100)

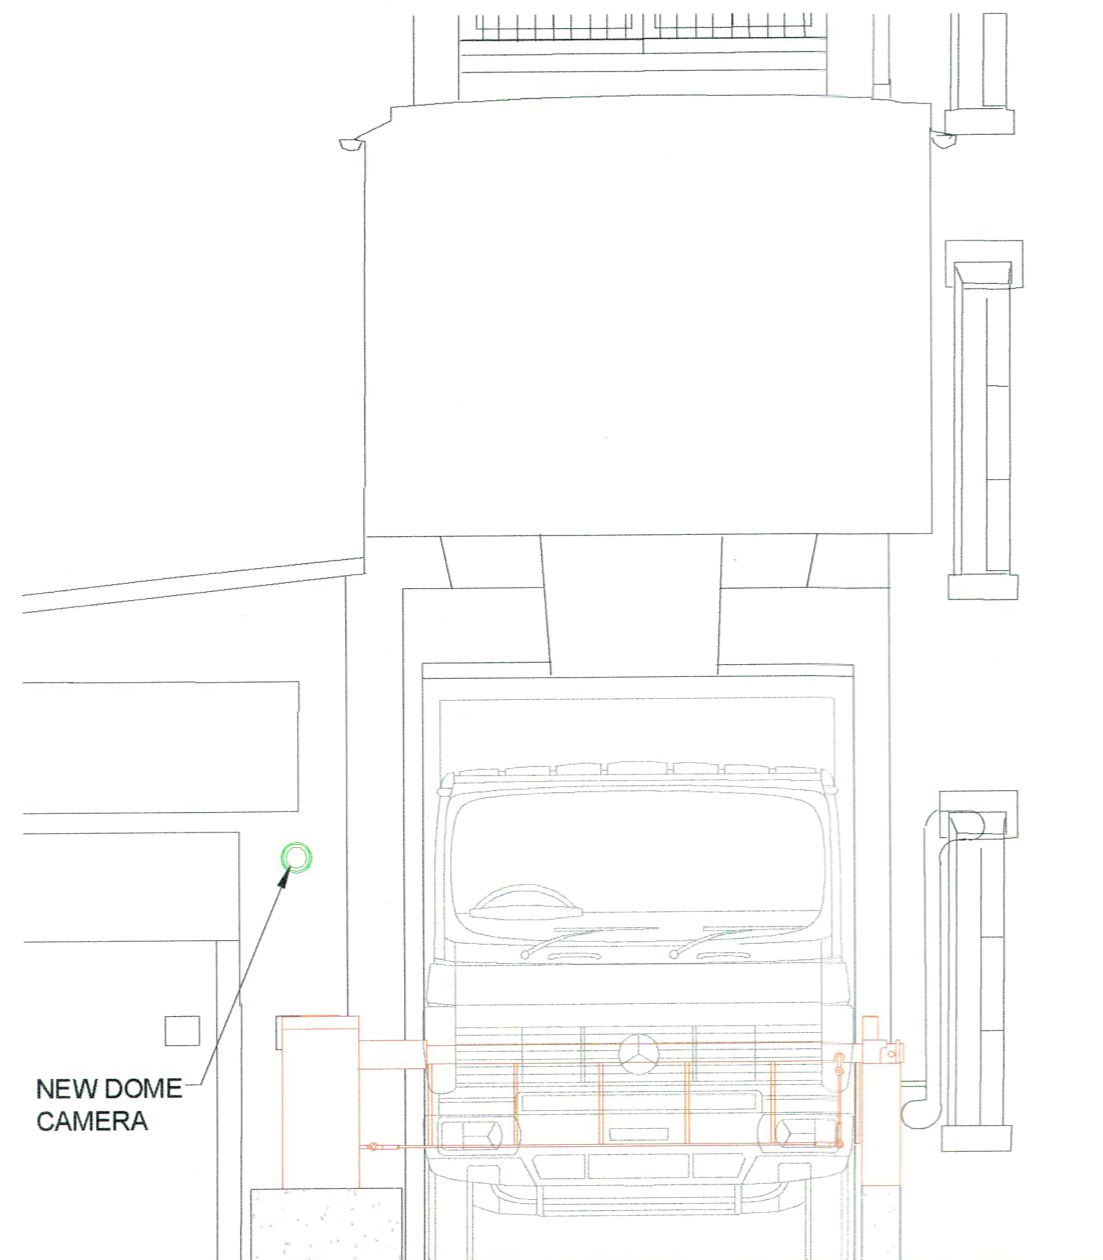

REAR ELEVATION (TOWARDS MONTAGUE PLACE)
 VEHICLE ENTERING SITE
 (Scale 1:50)




SECTION (TOWARDS MONTAGUE PLACE)
 (Scale 1:50)



FRONT ELEVATION (FROM MONTAGUE PLACE)
 VEHICLE LEAVING SITE
 (Scale 1:50)



EXISTING NORTH EAST GATE (VIEW FROM INSIDE PERIMETER)

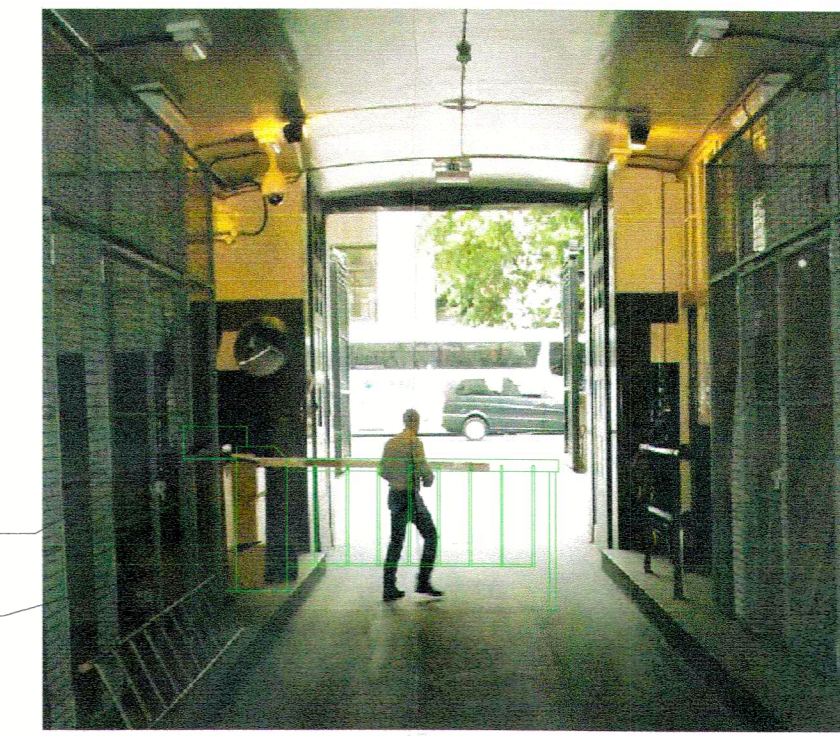

PROPOSED NORTH EAST GATE (VIEW FROM INSIDE PERIMETER)

NEW BARRIER
 EXISTING BARRIER TO BE REMOVED




EXISTING NORTH EAST GATE (VIEW FROM OUTSIDE PERIMETER)



PROPOSED NORTH EAST GATE (VIEW FROM OUTSIDE PERIMETER)

NEW BARRIER
 EXISTING BARRIER TO BE REMOVED

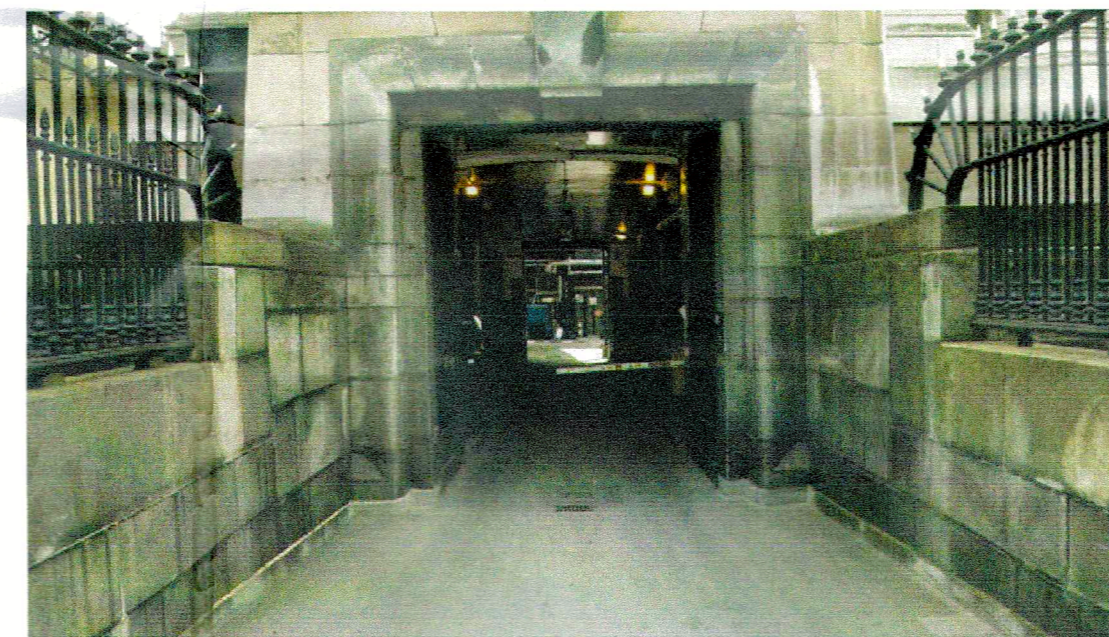


EXISTING NORTH EAST GATE (VIEW FROM MONTAGUE PLACE)



PROPOSED NORTH EAST GATE (VIEW FROM MONTAGUE PLACE)

NEW DOME CAMERA
 EXISTING BARRIER TO BE REMOVED
 NEW BARRIER

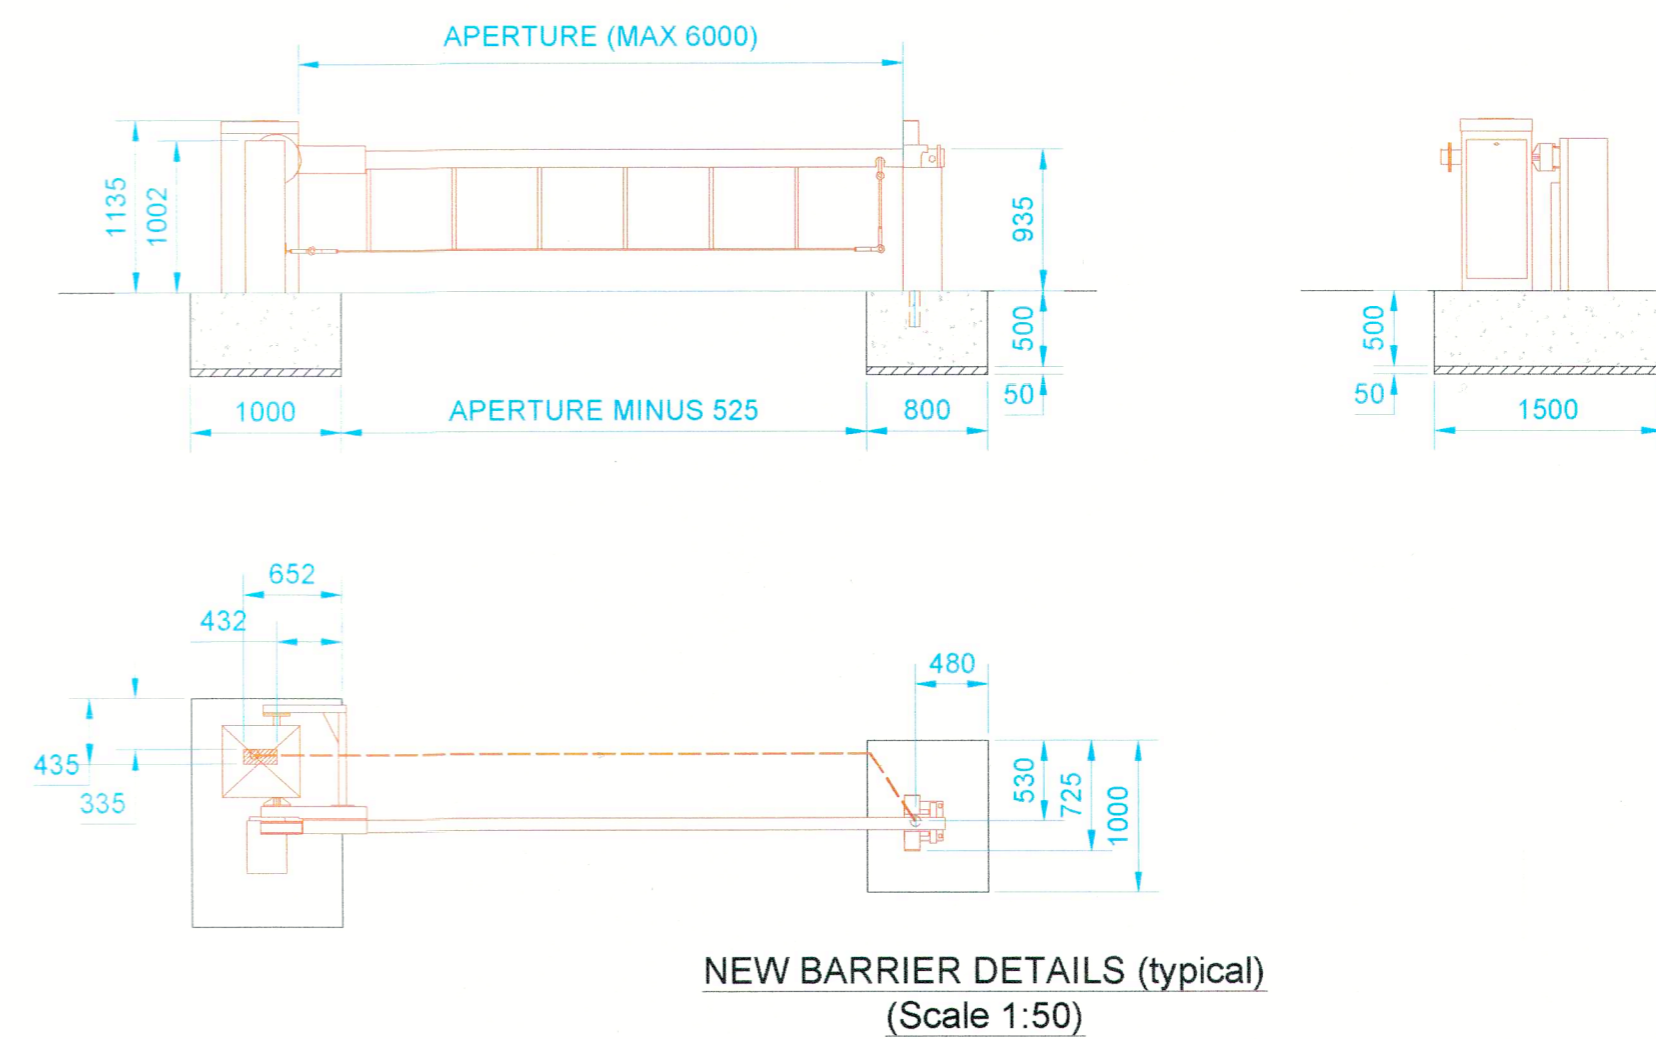

NEW BARRIER DETAILS (typical)
 (Scale 1:50)

ISSUE/REVISION

I/R	DATE	DESCRIPTION
5	30/10/2015	PLANNING SUBMISSION
4	21/10/2015	BARRIERS MODIFIED
3	26/08/2015	ADDITIONAL INFORMATION
2	12/05/2015	GATE POSITION MODIFIED
1	08/12/2014	ADDED SECURITY EQUIP.

Proj Mgr: APC	Proj Dir: GMB
Date Created: 06.06.14	Scale: 1@100/1:50 @A1

PROJECT NUMBER

60304751

SHEET TITLE

North East Gate
 Security Layout

SHEET NUMBER

60304751_TYP_GATE_L2_TS_0002