




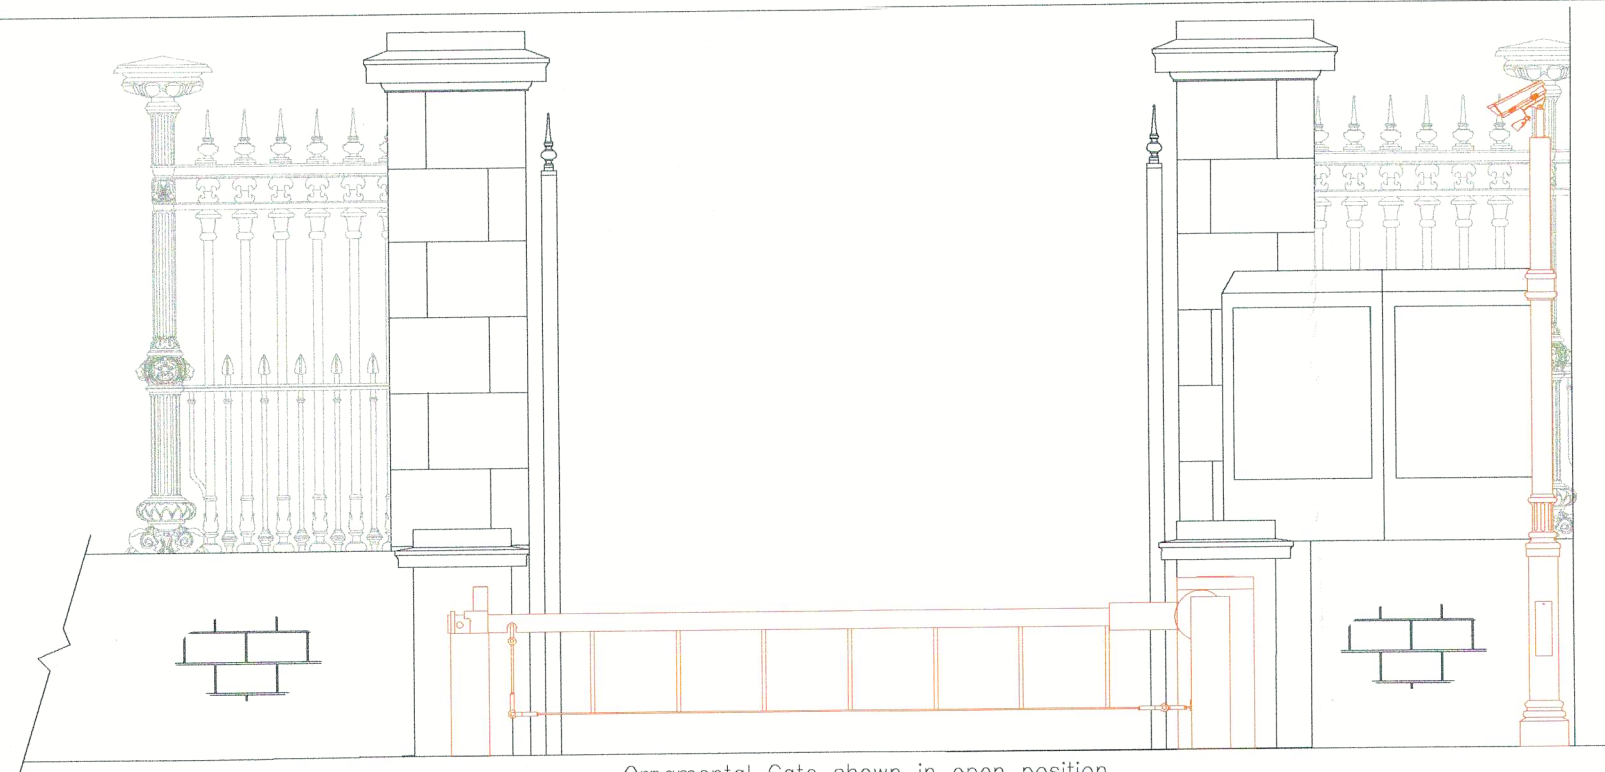

Ornamental Gate shown in open position
ELEVATION INSIDE PERIMETER

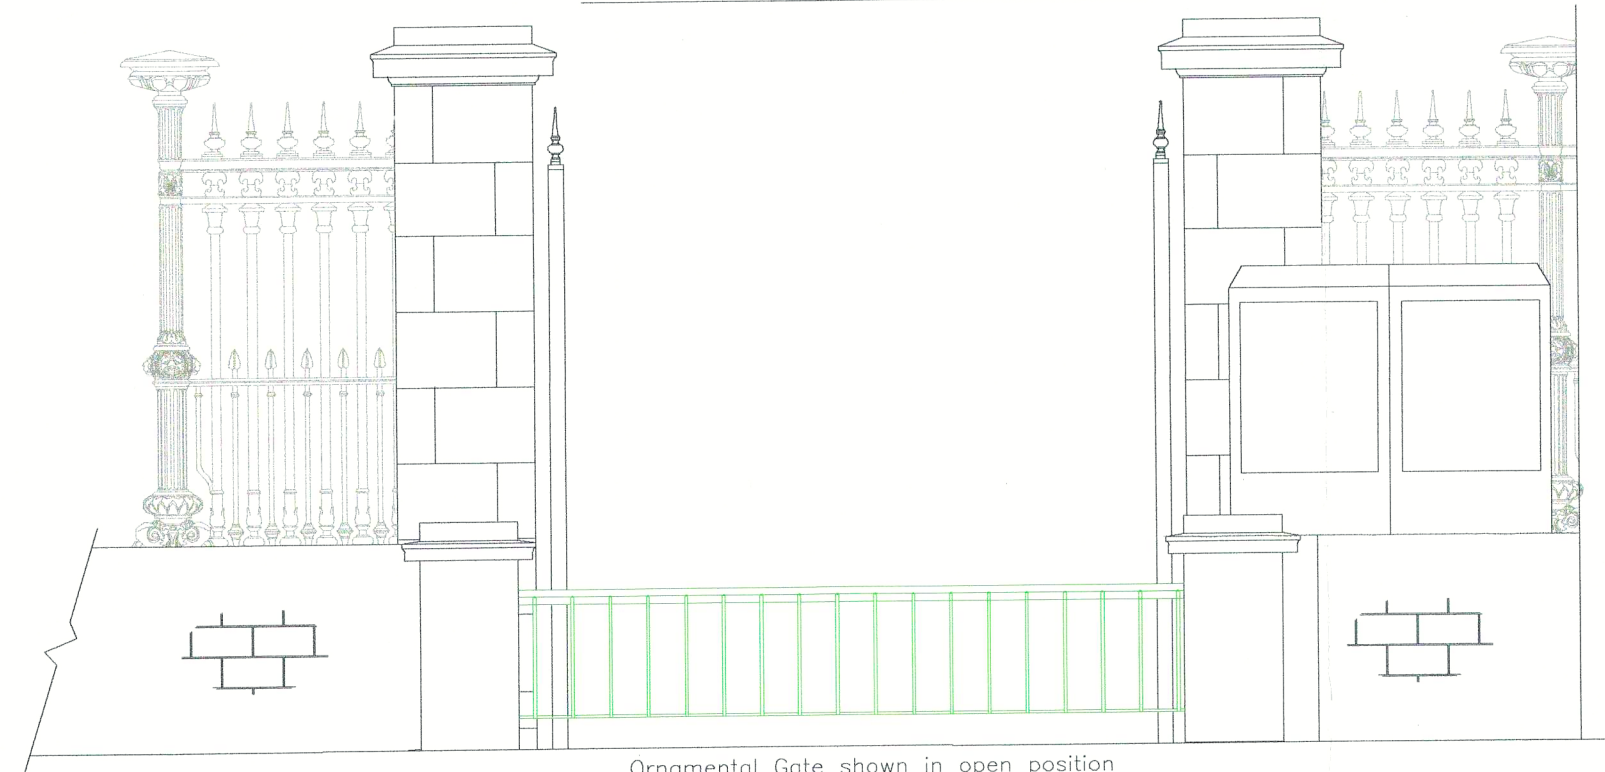

Ornamental Gate shown in open position
ELEVATION TOWARDS STREET

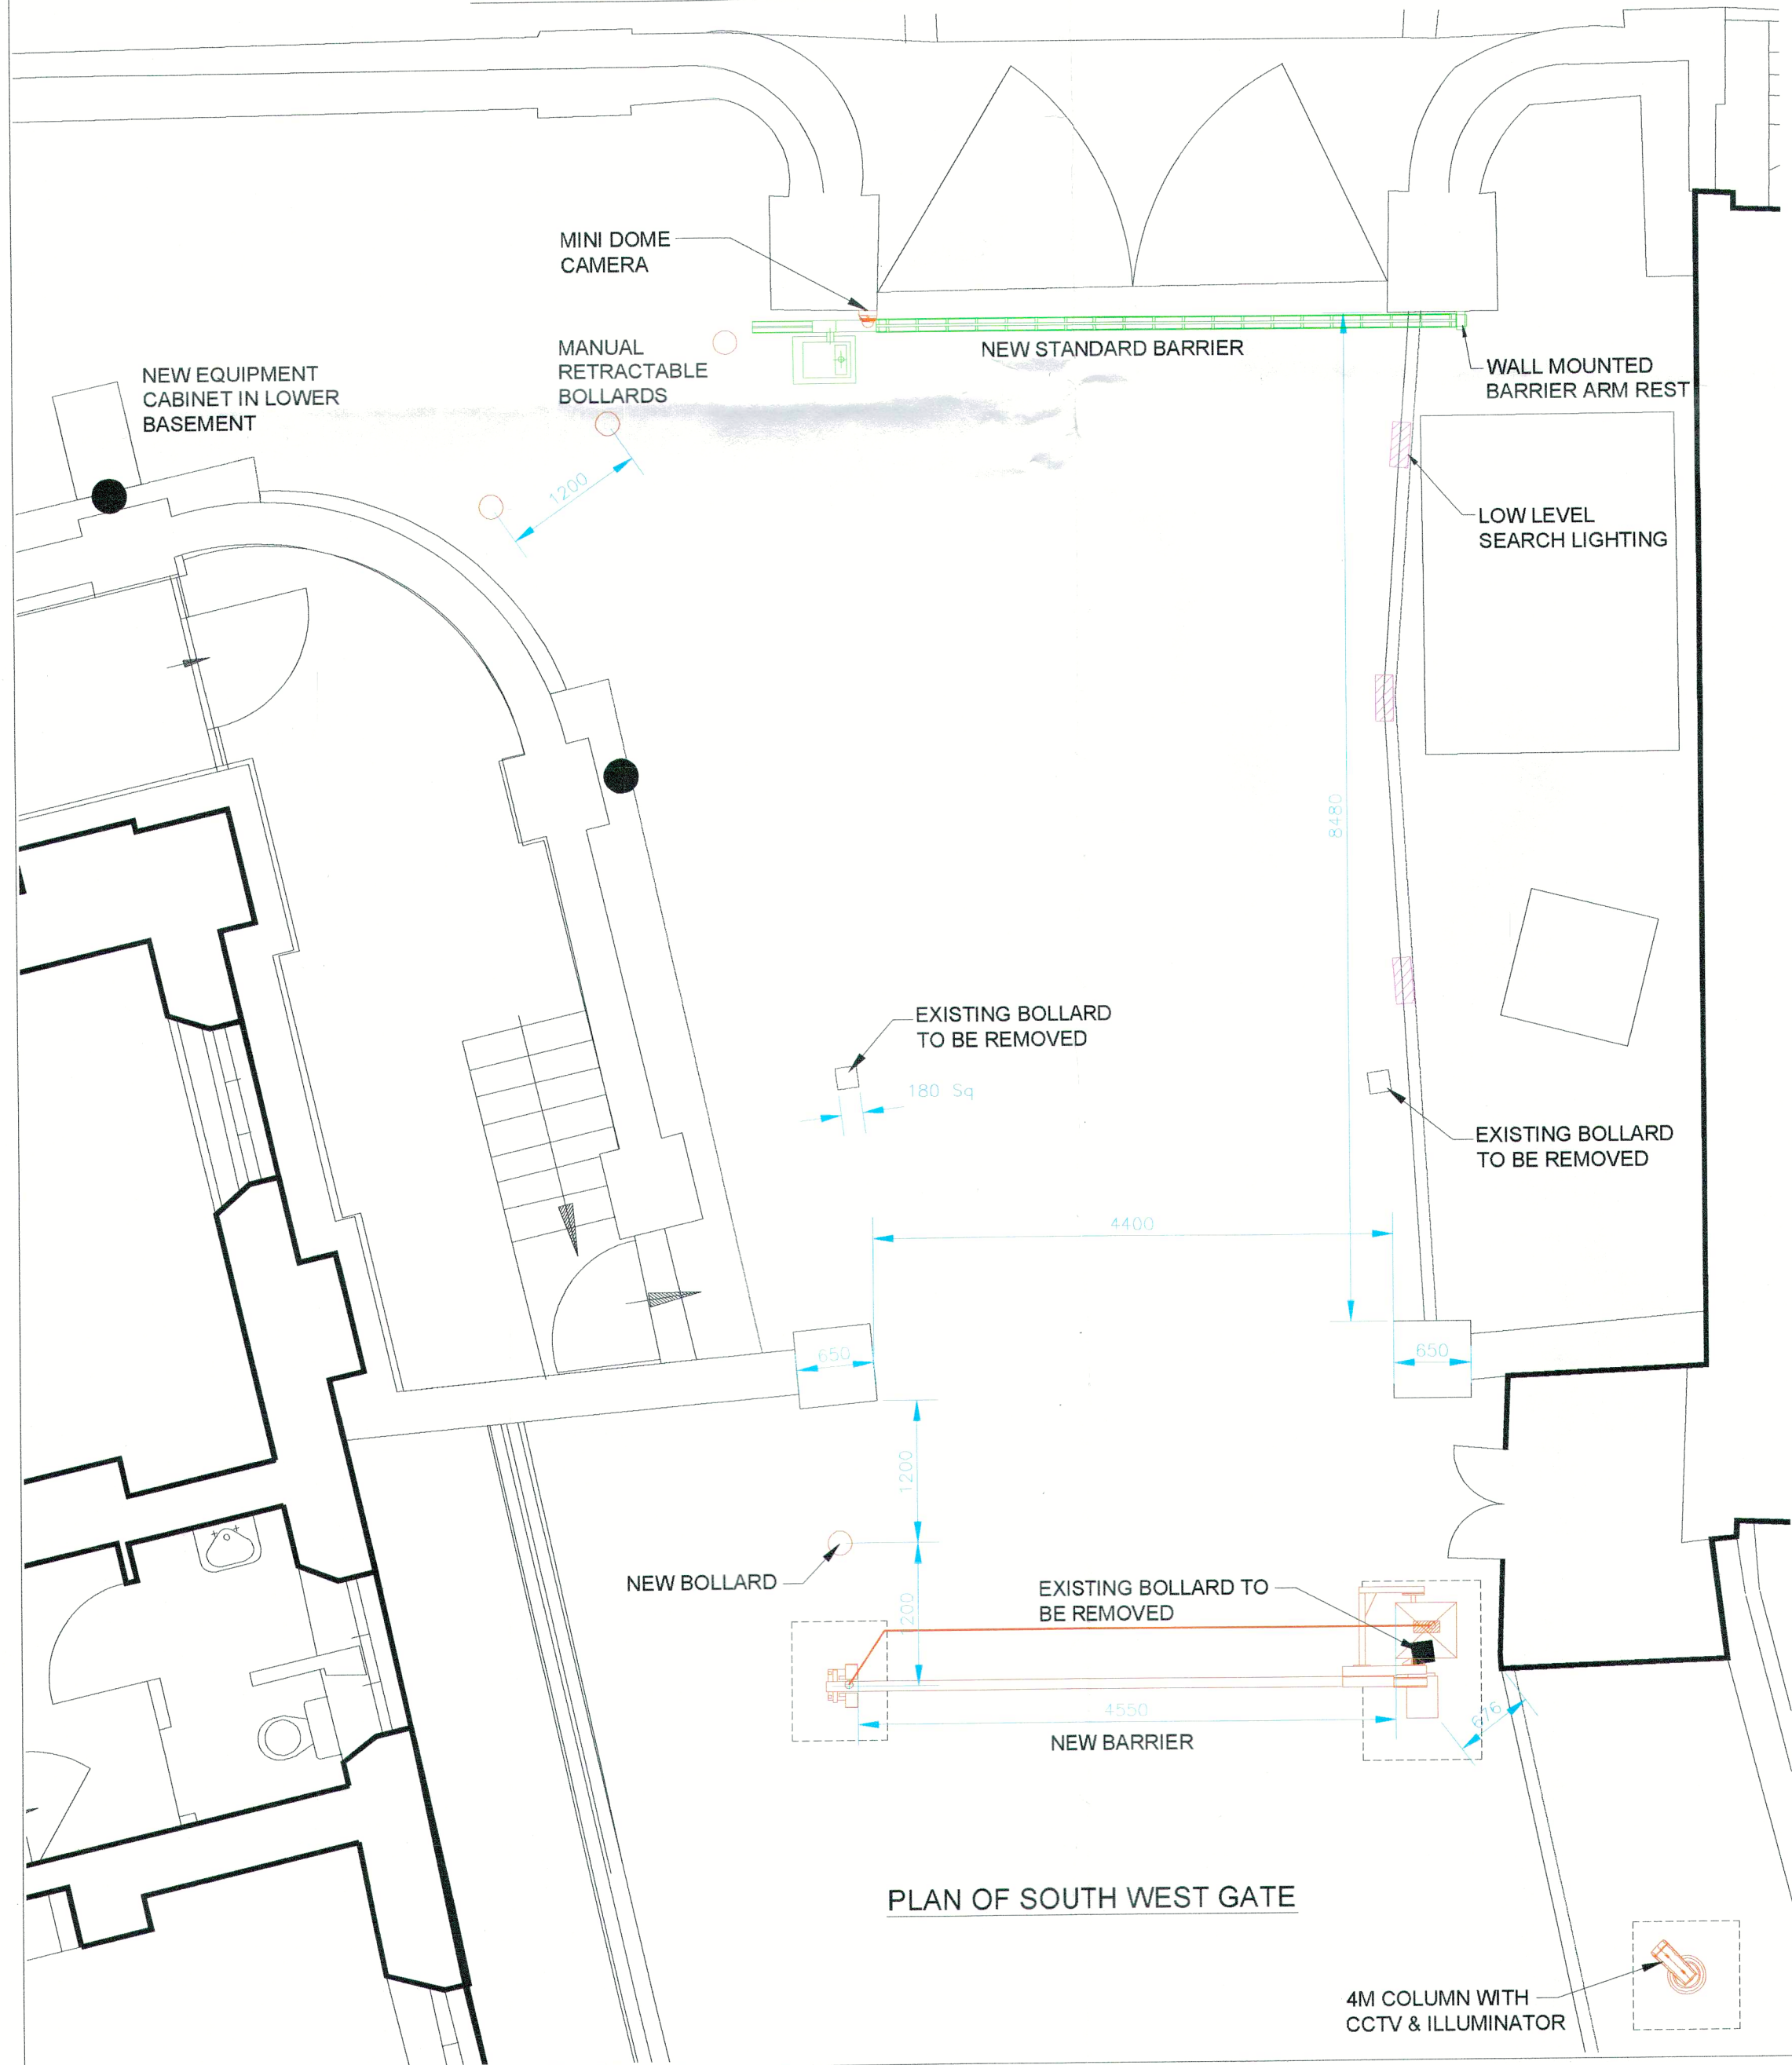

PLAN OF SOUTH WEST GATE




EXISTING GATE (VIEW FROM INSIDE PERIMETER)



PROPOSED GATE (VIEW FROM INSIDE PERIMETER)




TYPICAL EXAMPLE OF A SIMILAR
CAMERA COLUMN INSTALLATION

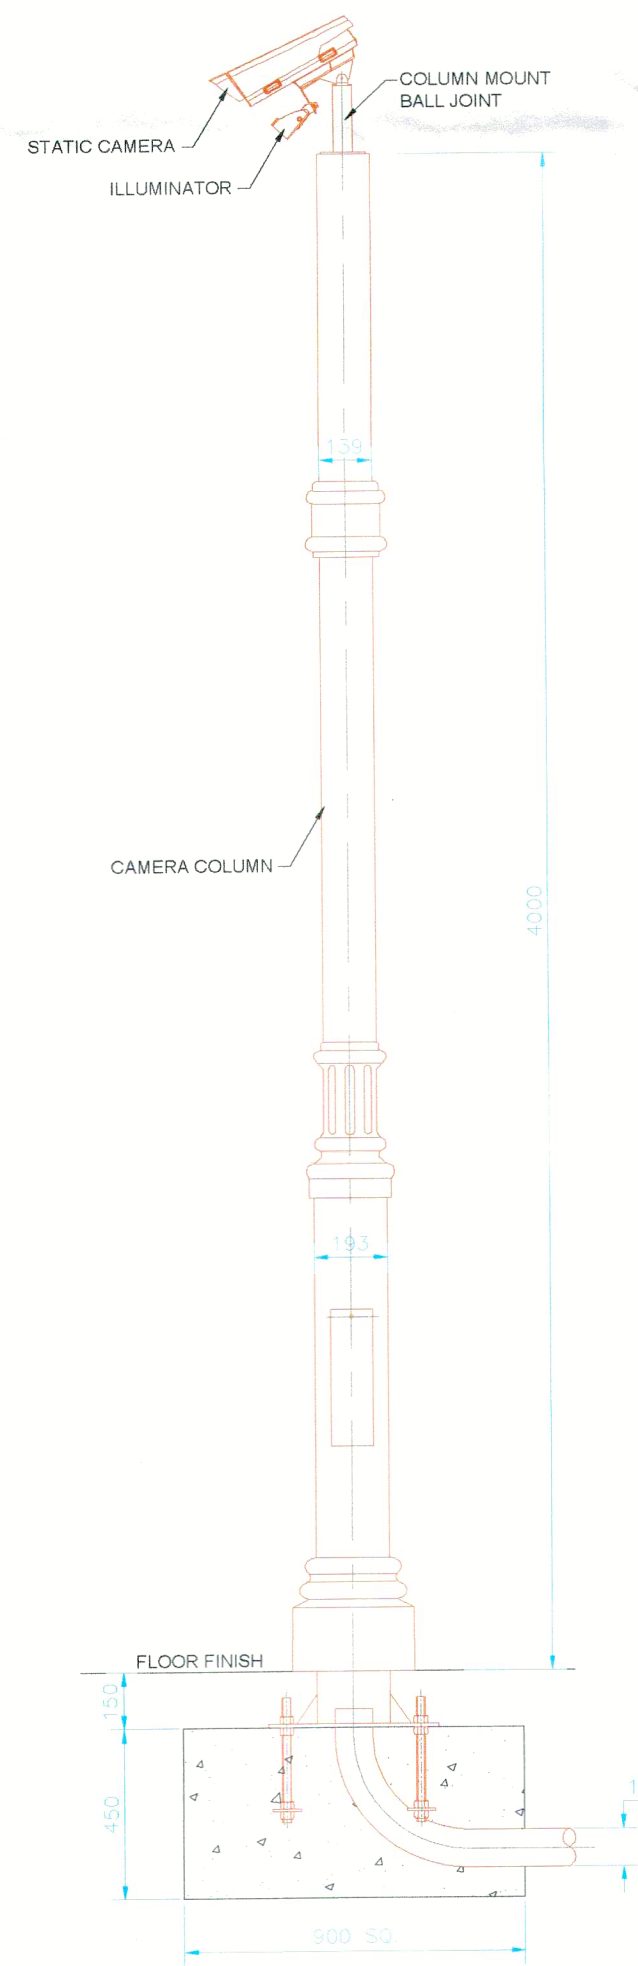


CAMERA COLUMN DETAILS
(SCALE 1:20)



STATIC MINI DONE
DETAILS
(SCALE 1:20)

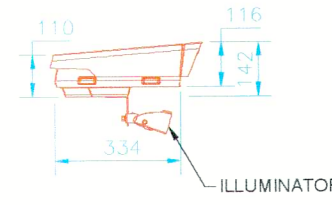

STATIC BODY CAMERA
5M ILLUMINATOR

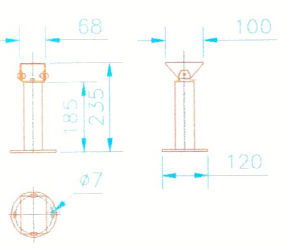

COLUMN MOUNT BALL JOINT
DETAILS

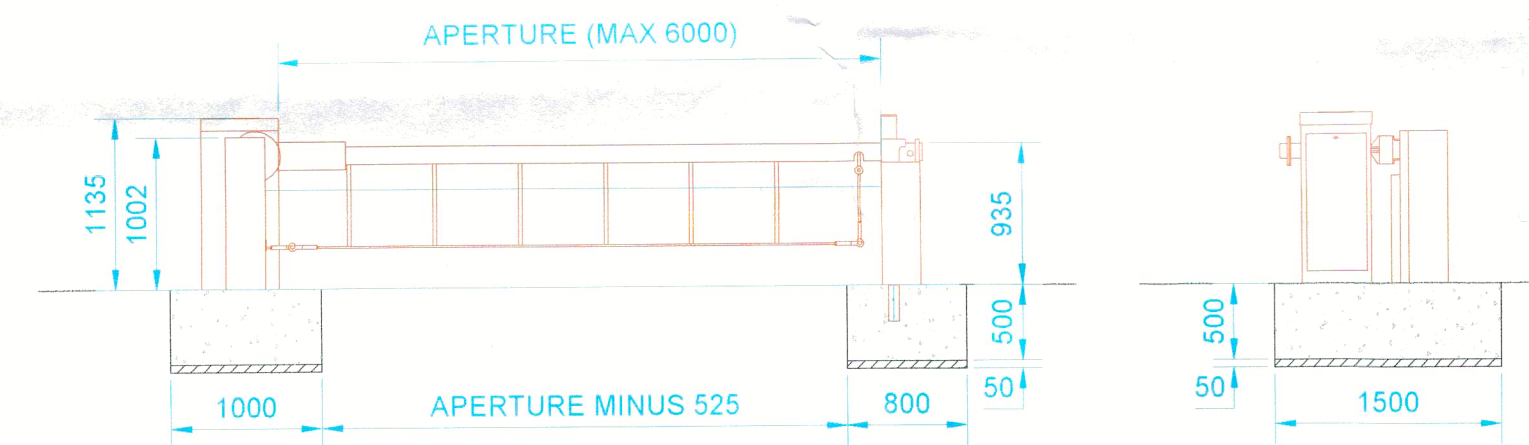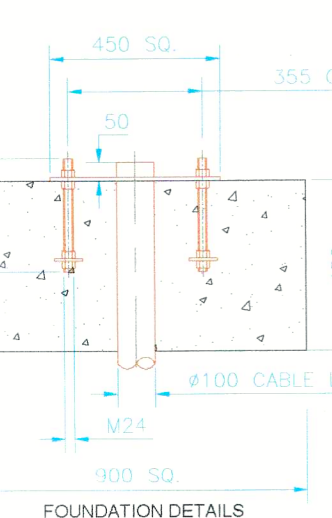

NEW BARRIER DETAILS
(SCALE 1:50)

ISSUE/REVISION

I/R	DATE	DESCRIPTION
4	30/10/2015	PLANNING SUBMISSION
3	22/10/2015	BARRIERS MODIFIED
2	21/10/2015	BARRIERS MODIFIED
1	08/12/2014	ADDED SECURITY EQUIP.

Proj Mgr : APC	Proj Dir : GMB
Date Created : 06.06.14	Scale : 1:50 @ A1

PROJECT NUMBER

60304751

SHEET TITLE

South West Gate
Security Layout

SHEET NUMBER

60304751_TYP_GATE_L2_TS_0003

